

INDEX OF SHEETS

ROADWAY PLANS

SHEET NO.	TITLE
1.	TITLE SHEET
2.	ROADWAY TYPICAL SECTION
3.	ROADWAY LAYOUT (1)
4.	ROADWAY LAYOUT (2)
5.	UTILITY PLAN NO. 1
6.	UTILITY PLAN NO. 2
7.	SEWER LINE
8.	STREET RESURFACING PLAN 1
9.	STREET RESURFACING PLAN 2
10.	LOT 6 STRIPING
11.	LOT 6 EARTHWORK
12.	TEMPORARY PARKING LOT CIRCULATION PLAN
13.	TRAFFIC SIGNAL AND LIGHTING PLAN
14.	SIGNING & STRIPING PLAN NO. 1
15.	SIGNING & STRIPING PLAN NO. 2
16.	TRAFFIC DETOUR PLAN
17.	TRAFFIC DETOUR PLAN
18.	TRAFFIC DETOUR PLAN
19.	TRAFFIC STAGING PLAN NO. 1
20.	TRAFFIC STAGING PLAN NO. 2

BRIDGE PLANS

SHEET NO.	TITLE
21.	GENERAL PLAN NO. 1
22.	GENERAL PLAN NO. 2
23.	GENERAL PLAN NO. 3
24.	CONSTRUCTION STAGING DETAILS NO. 1
25.	CONSTRUCTION STAGING DETAILS NO. 2
26.	CONSTRUCTION STAGING DETAILS NO. 3
27.	VOID LOCATION PLAN
28.	EXISTING GIRDER LAYOUT AND TIEDOWN ANCHOR LOCATIONS
29.	TEMPORARY SUPPORT DETAILS
30.	ABUTMENT DETAILS NO. 1
31.	ABUTMENT DETAILS NO. 2
32.	PRECAST CONCRETE SLAB LAYOUT
33.	PRECAST CONCRETE SLAB AND CAST-IN-PLACE CONCRETE SLAB LAYOUT
34.	SLAB DETAILS NO. 1
35.	SLAB DETAILS NO. 2
36.	SLAB DETAILS NO. 3
37.	SLAB DETAILS NO. 4
38.	PRECAST CONCRETE SLAB DETAILS
39.	CONSTRUCTION DETAILS
40.	UTILITY DETAILS NO. 1
41.	UTILITY DETAILS NO. 2

LEGEND

- TREE
- SEWER MANHOLE
- PG&E MANHOLE
- WATER VALVE
- WATER METER
- FIRE HYDRANT
- AS NOTED
- PARKING METER
- SIGN
- STREET LIGHT
- TRAFFIC SIGNAL
- BRIDGE FOUNDATION WALL
- CURB FACE INLET

CITY OF SAN LUIS OBISPO


PROJECT PLANS FOR CONSTRUCTION OF
HIGUERA STREET BRIDGE REPLACEMENT

STATE BRIDGE NO. 49C0408

NOTE: THE CONTRACTOR IS REQUIRED TO POSSESS A GENERAL
ENGINEERING CONTRACTOR LICENSE AT THE TIME THIS
CONTRACT IS AWARDED

May, 2000

FEDERAL PROJECT No. BHLS 5016(009)

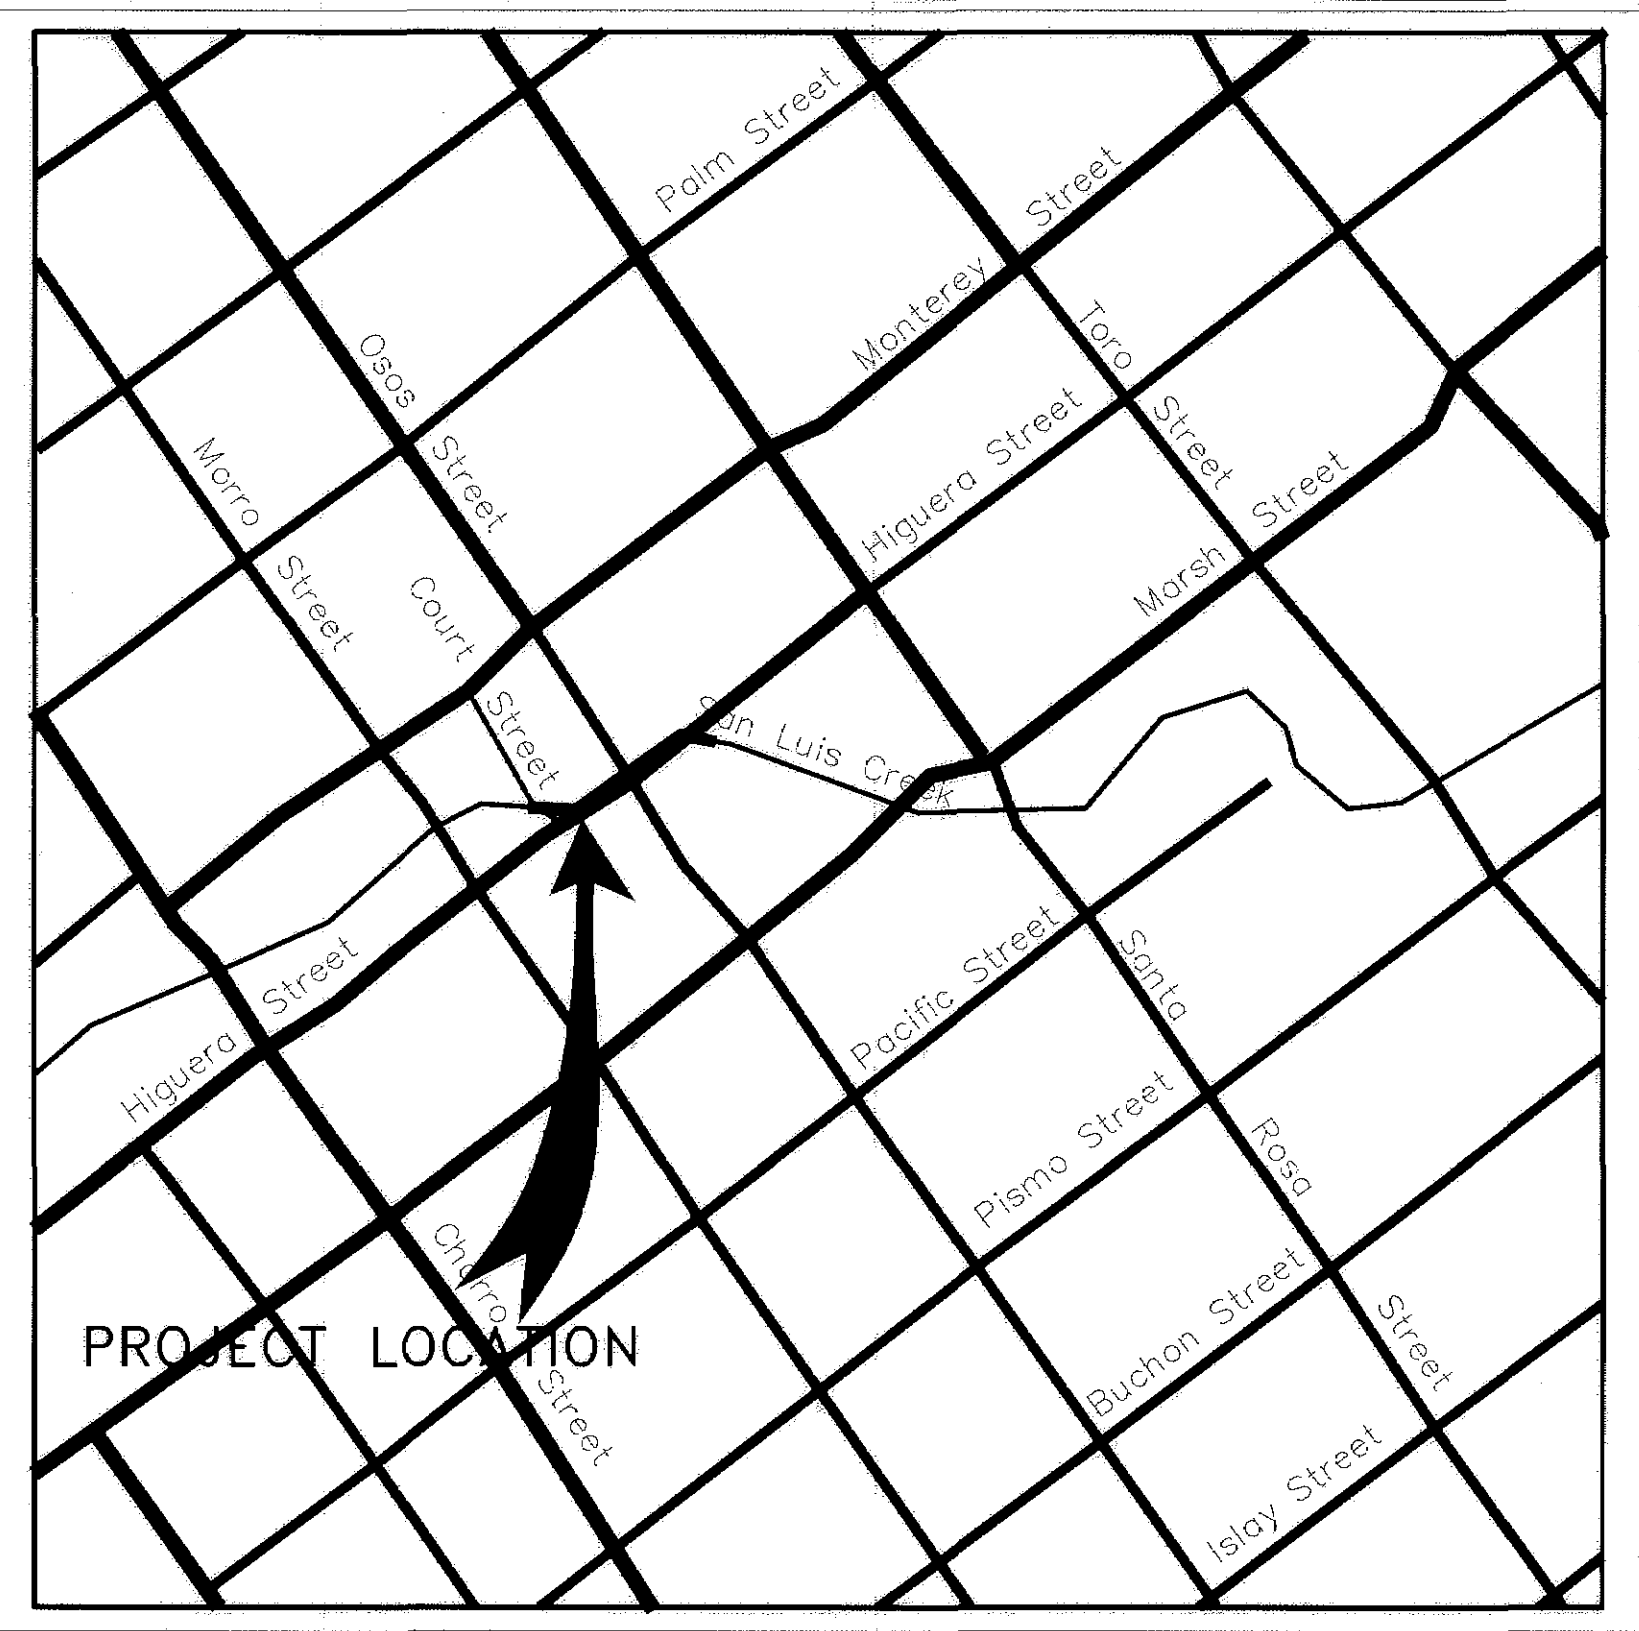


SITE MAP




LOCATION MAP

All dimensions are in meters unless otherwise specified.

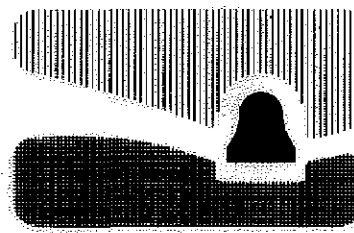

city of san luis obispo

HIGUERA STREET BRIDGE REPLACEMENT

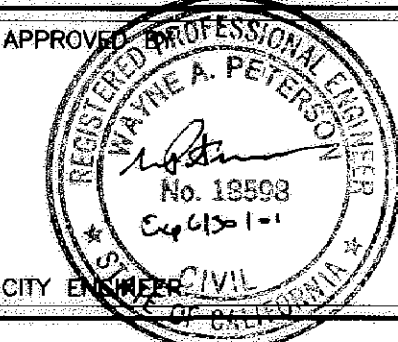

DATE	3/2000
SCALE	
DESIGNED BY	R.F.
DRAWN BY	R.D., K.W.
CHECKED BY	R.R.
APPROVED BY	
UTILITIES DEPARTMENT	

TITLE SHEET

SPECIFICATION NO.	9367
FILE NO./LOCATION	0060 B
SHEET	1 OF 41

- A10A ABBREVIATIONS
- A10B SYMBOLS
- A20A PAVEMENT MARKERS AND TRAFFIC LINES TYPICAL DETAILS
- A20D PAVEMENT MARKERS AND TRAFFIC LINES TYPICAL DETAILS
- A24A PAVEMENT MARKINGS ARROWS
- A24E PAVEMENT MARKINGS WORDS AND CROSSWALKS
- A62C LIMITS OF PAYMENT FOR EXCAVATION AND BACKFILL BRIDGE

T3 TEMPORARY RAILING (TYPE K)


- BD-1 BRIDGE DETAILS
- BD-5 BRIDGE DETAILS




DIST	COUNTY	ROUTE	POST MILES TOTAL PROJECT	SHEET NO.	TOTAL SHEETS
5	SLO		-	2	41

REGISTERED CIVIL ENGINEER
4/5/00
PLANS APPROVAL DATE

MARTIN & KANE, Inc.
2200-B DOUGLAS BLVD, #150
ROSEVILLE • CA 95661

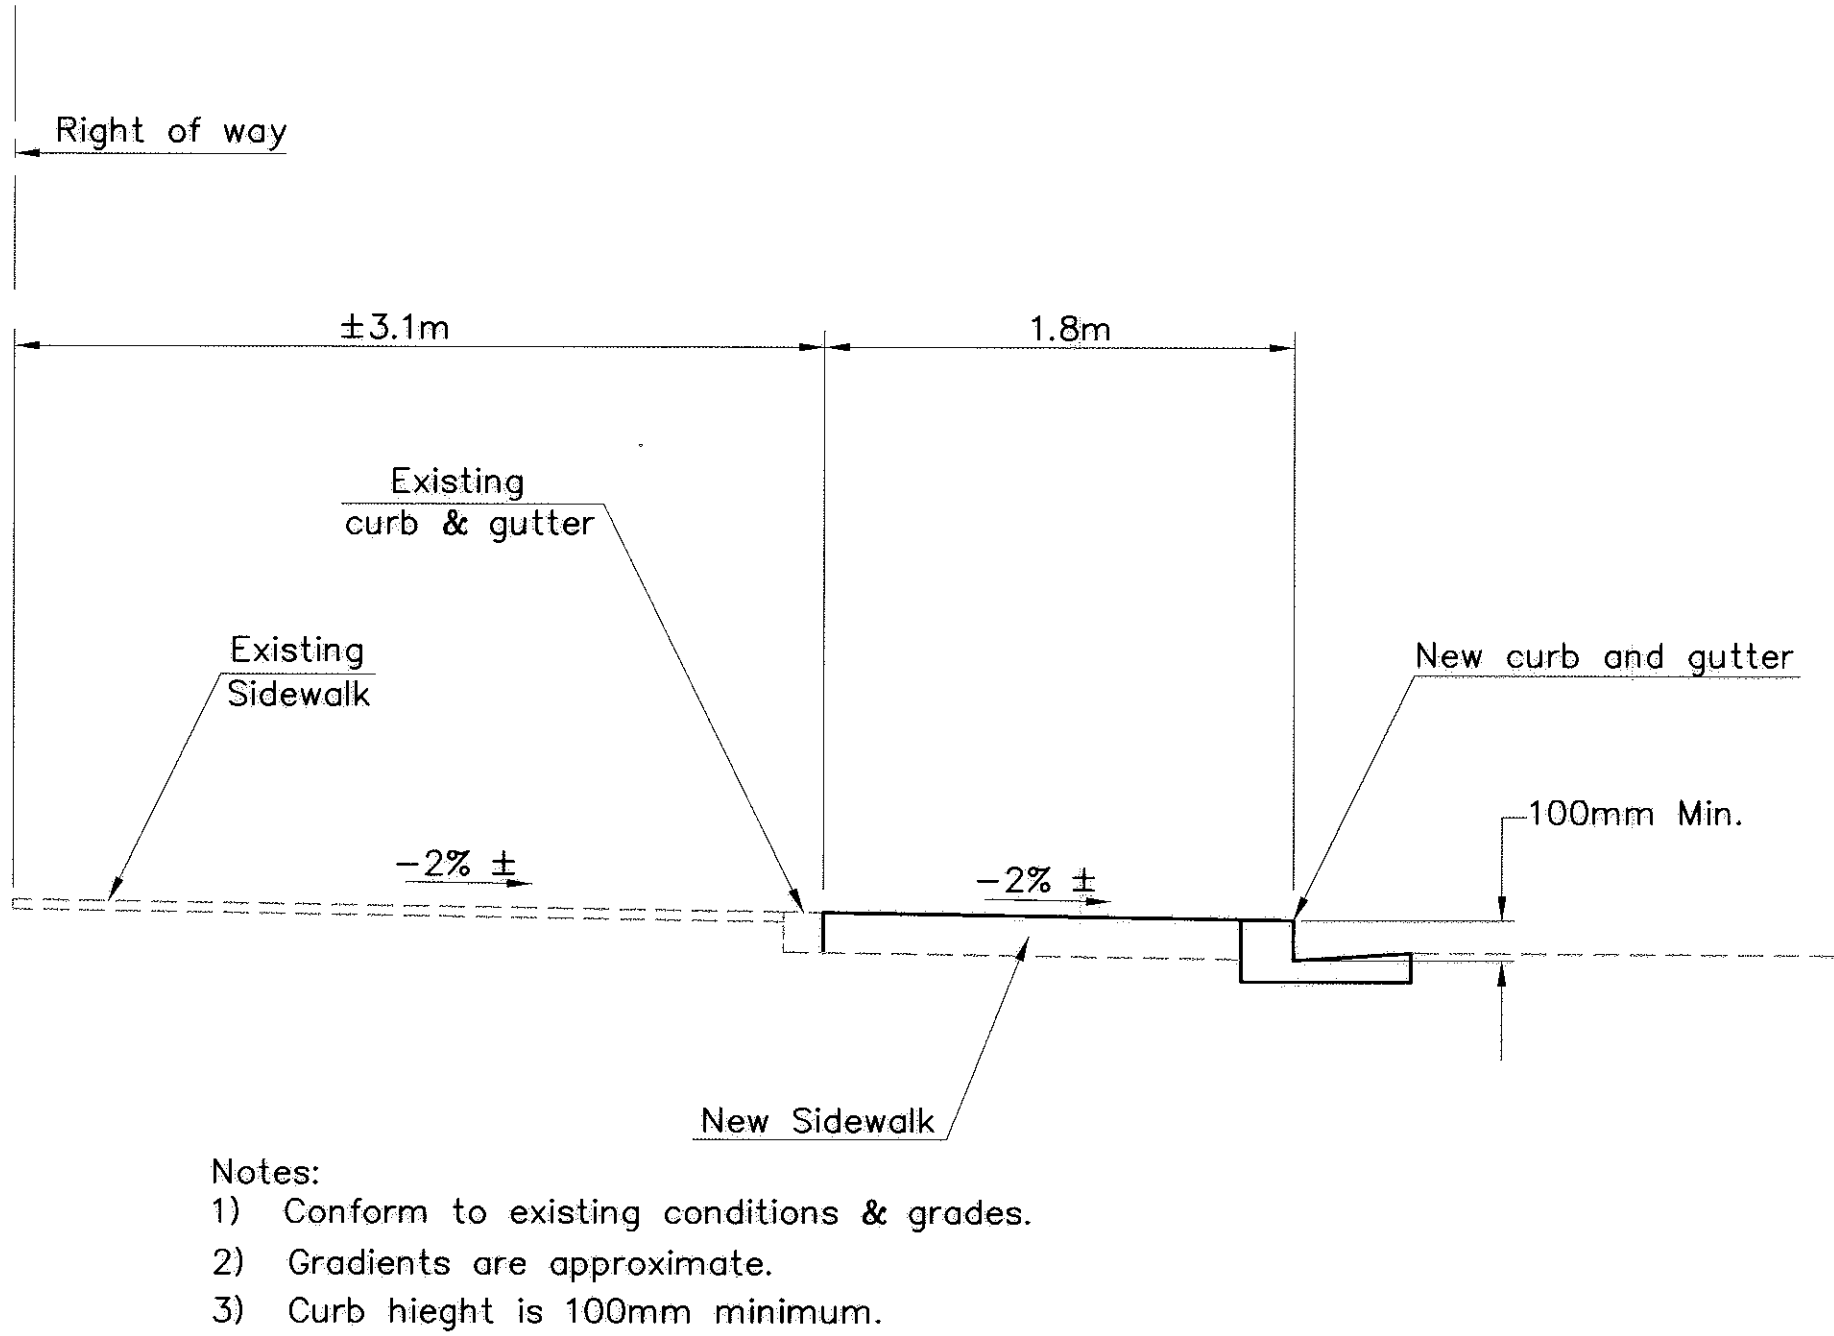


SECTION THRU SIDEWALK BULBOUT

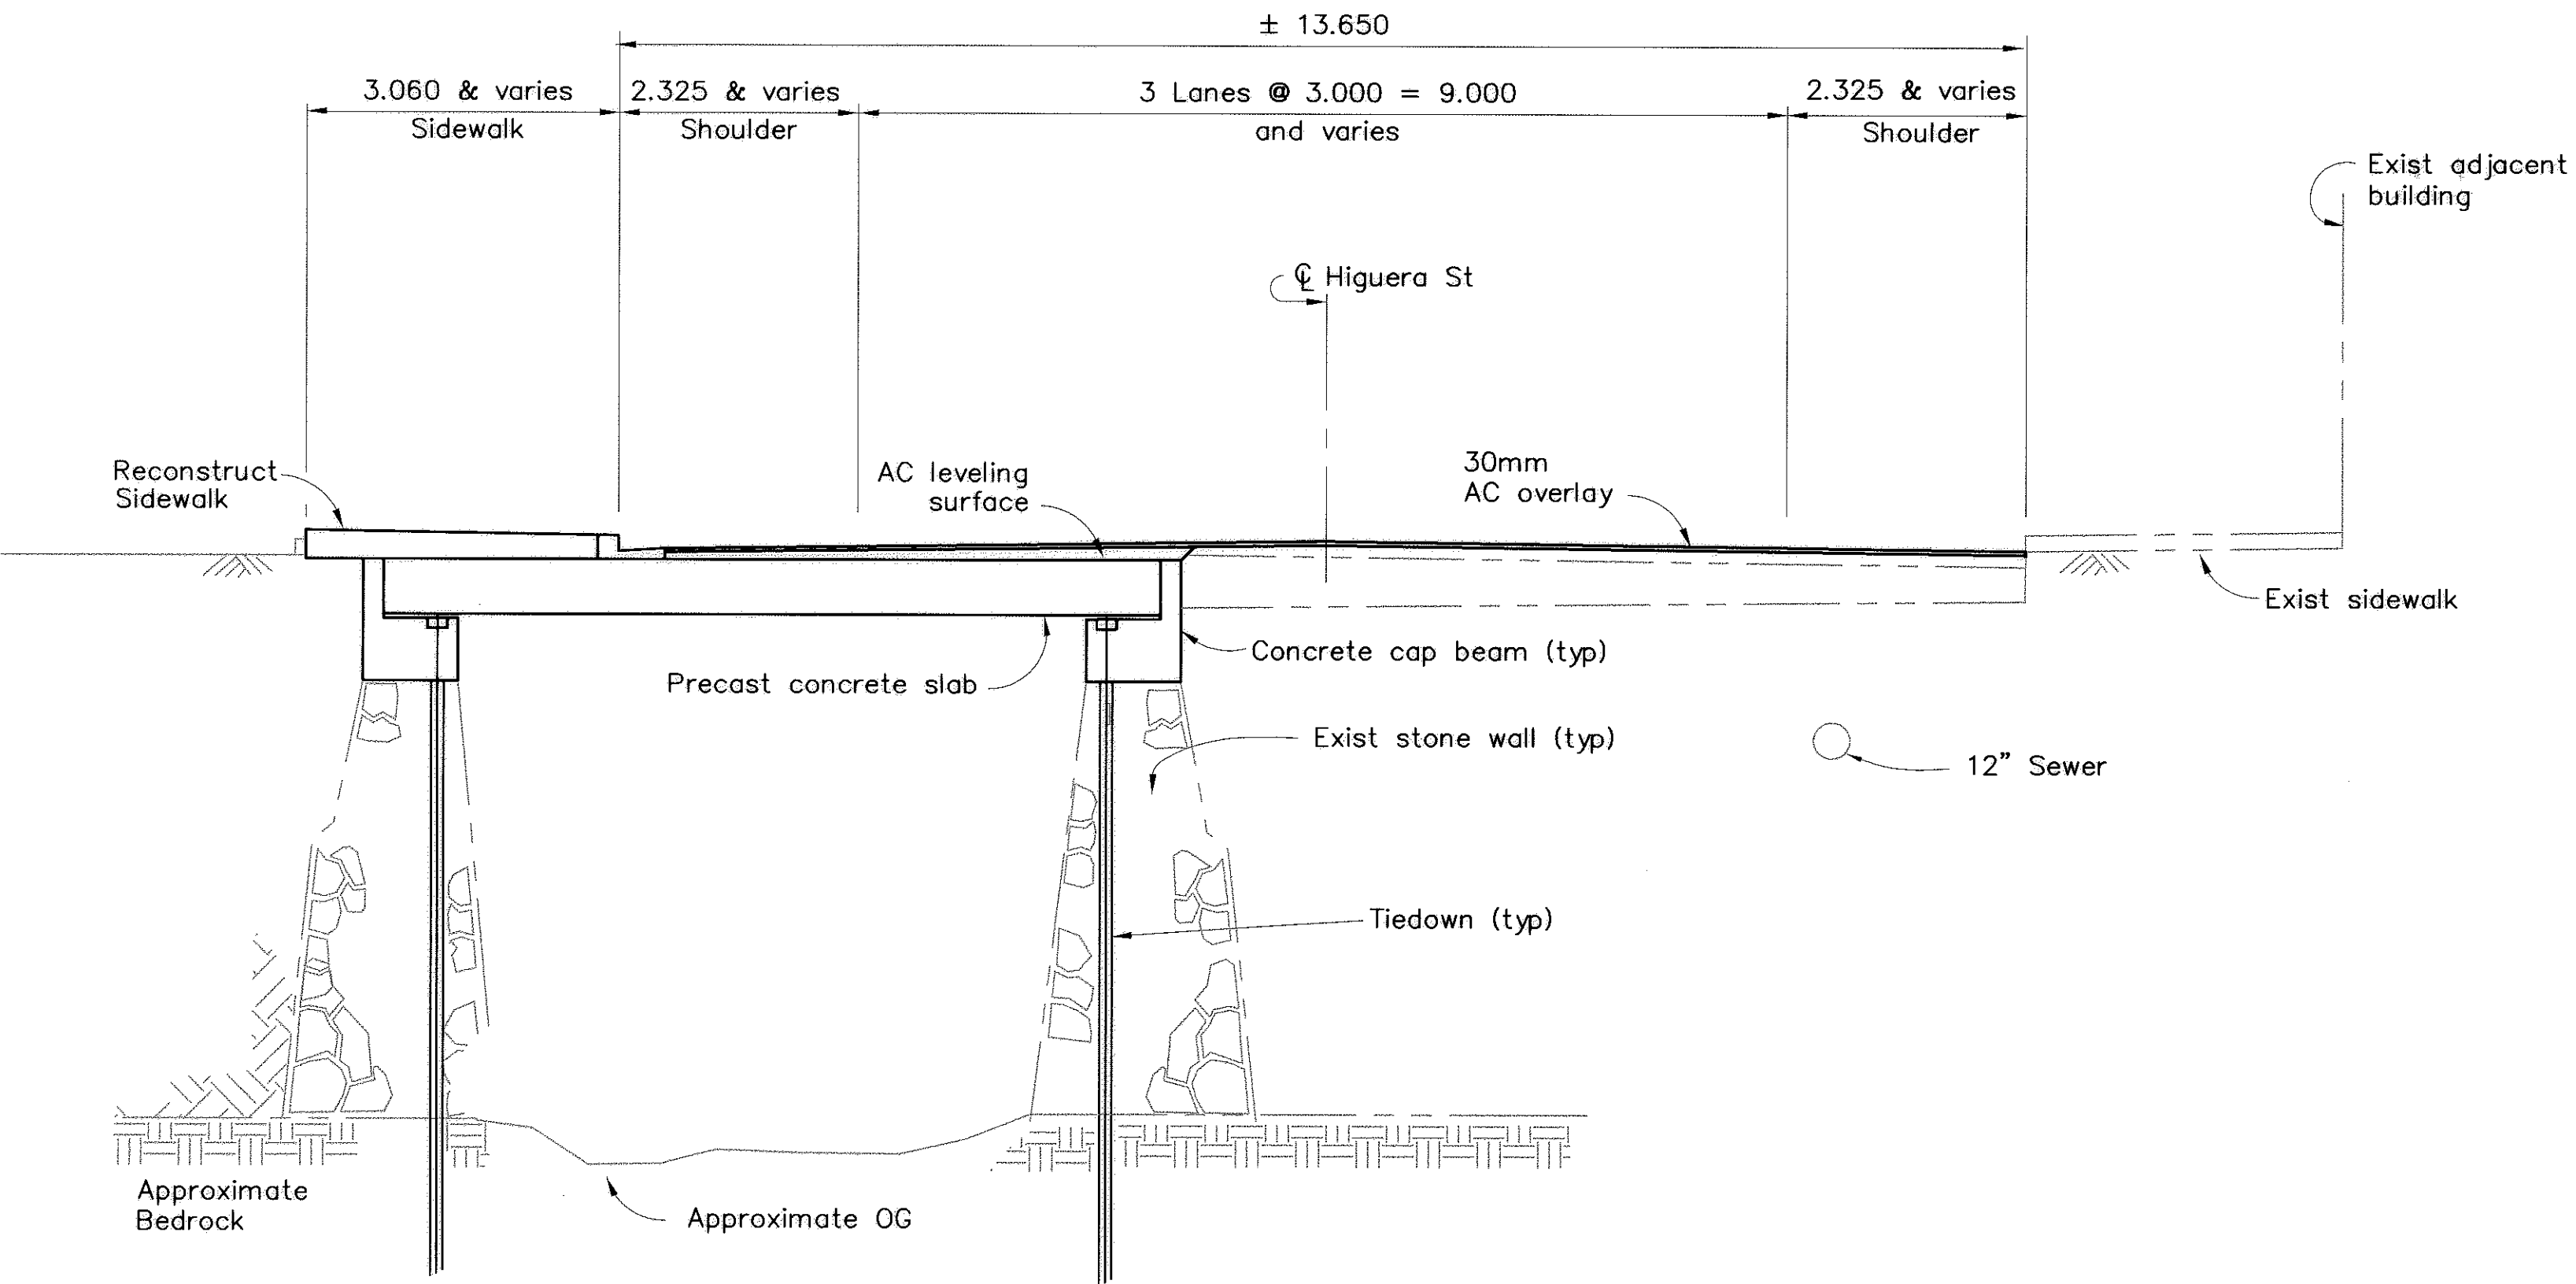

TYPICAL SECTION 0+58.43 to 1+44.80
1:50

All dimensions are in meters unless otherwise noted.

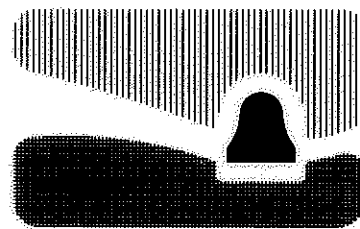

city of san luis obispo

HIGUERA STREET BRIDGE REPLACEMENT

FOR REDUCED PLANS
ORIGINAL SCALE IS IN MILLIMETERS

0 20 40 60 80 100

APPROVED BY

CITY ENGINEER

DATE 3/2000
SCALE AS SHOWN
DESIGNED BY R.F.
DRAWN BY R.D., K.W.
CHECKED BY R.R.
APPROVED BY
UTILITIES DEPARTMENT

ROADWAY TYPICAL SECTION

SPECIFICATION NO. 9367
FILE NO./LOCATION 0060 B
SHEET 2 OF 41

DIST	COUNTY	ROUTE	POST MILES TOTAL PROJECT	SHEET NO.	TOTAL SHEETS
5	SLO		-	3	41

Ronald L. Rivett
REGISTERED CIVIL ENGINEER

4/5/00
PLANS APPROVAL DATE

MARTIN & KANE, INC.
2200-B DOUGLAS BLVD, #150
ROSEVILLE • CA 95661

REGISTERED PROFESSIONAL ENGINEER

Ronald L. Rivett

No. 31,269


EXP. 12/31/00

CIVIL

STATE OF CALIFORNIA

● Survey Control Points					
Point Number	Elevation	Description	Coordinates		
			North	East	
512	65.58	SET PKNAIL	700776.2383	1757984.7870	
600	66.14	FD L&T RLS 3877	700796.8080	1757930.5720	
602	65.37	FD L&T RCE 6923	700787.9310	1757896.6390	

For other control points see Engineer.

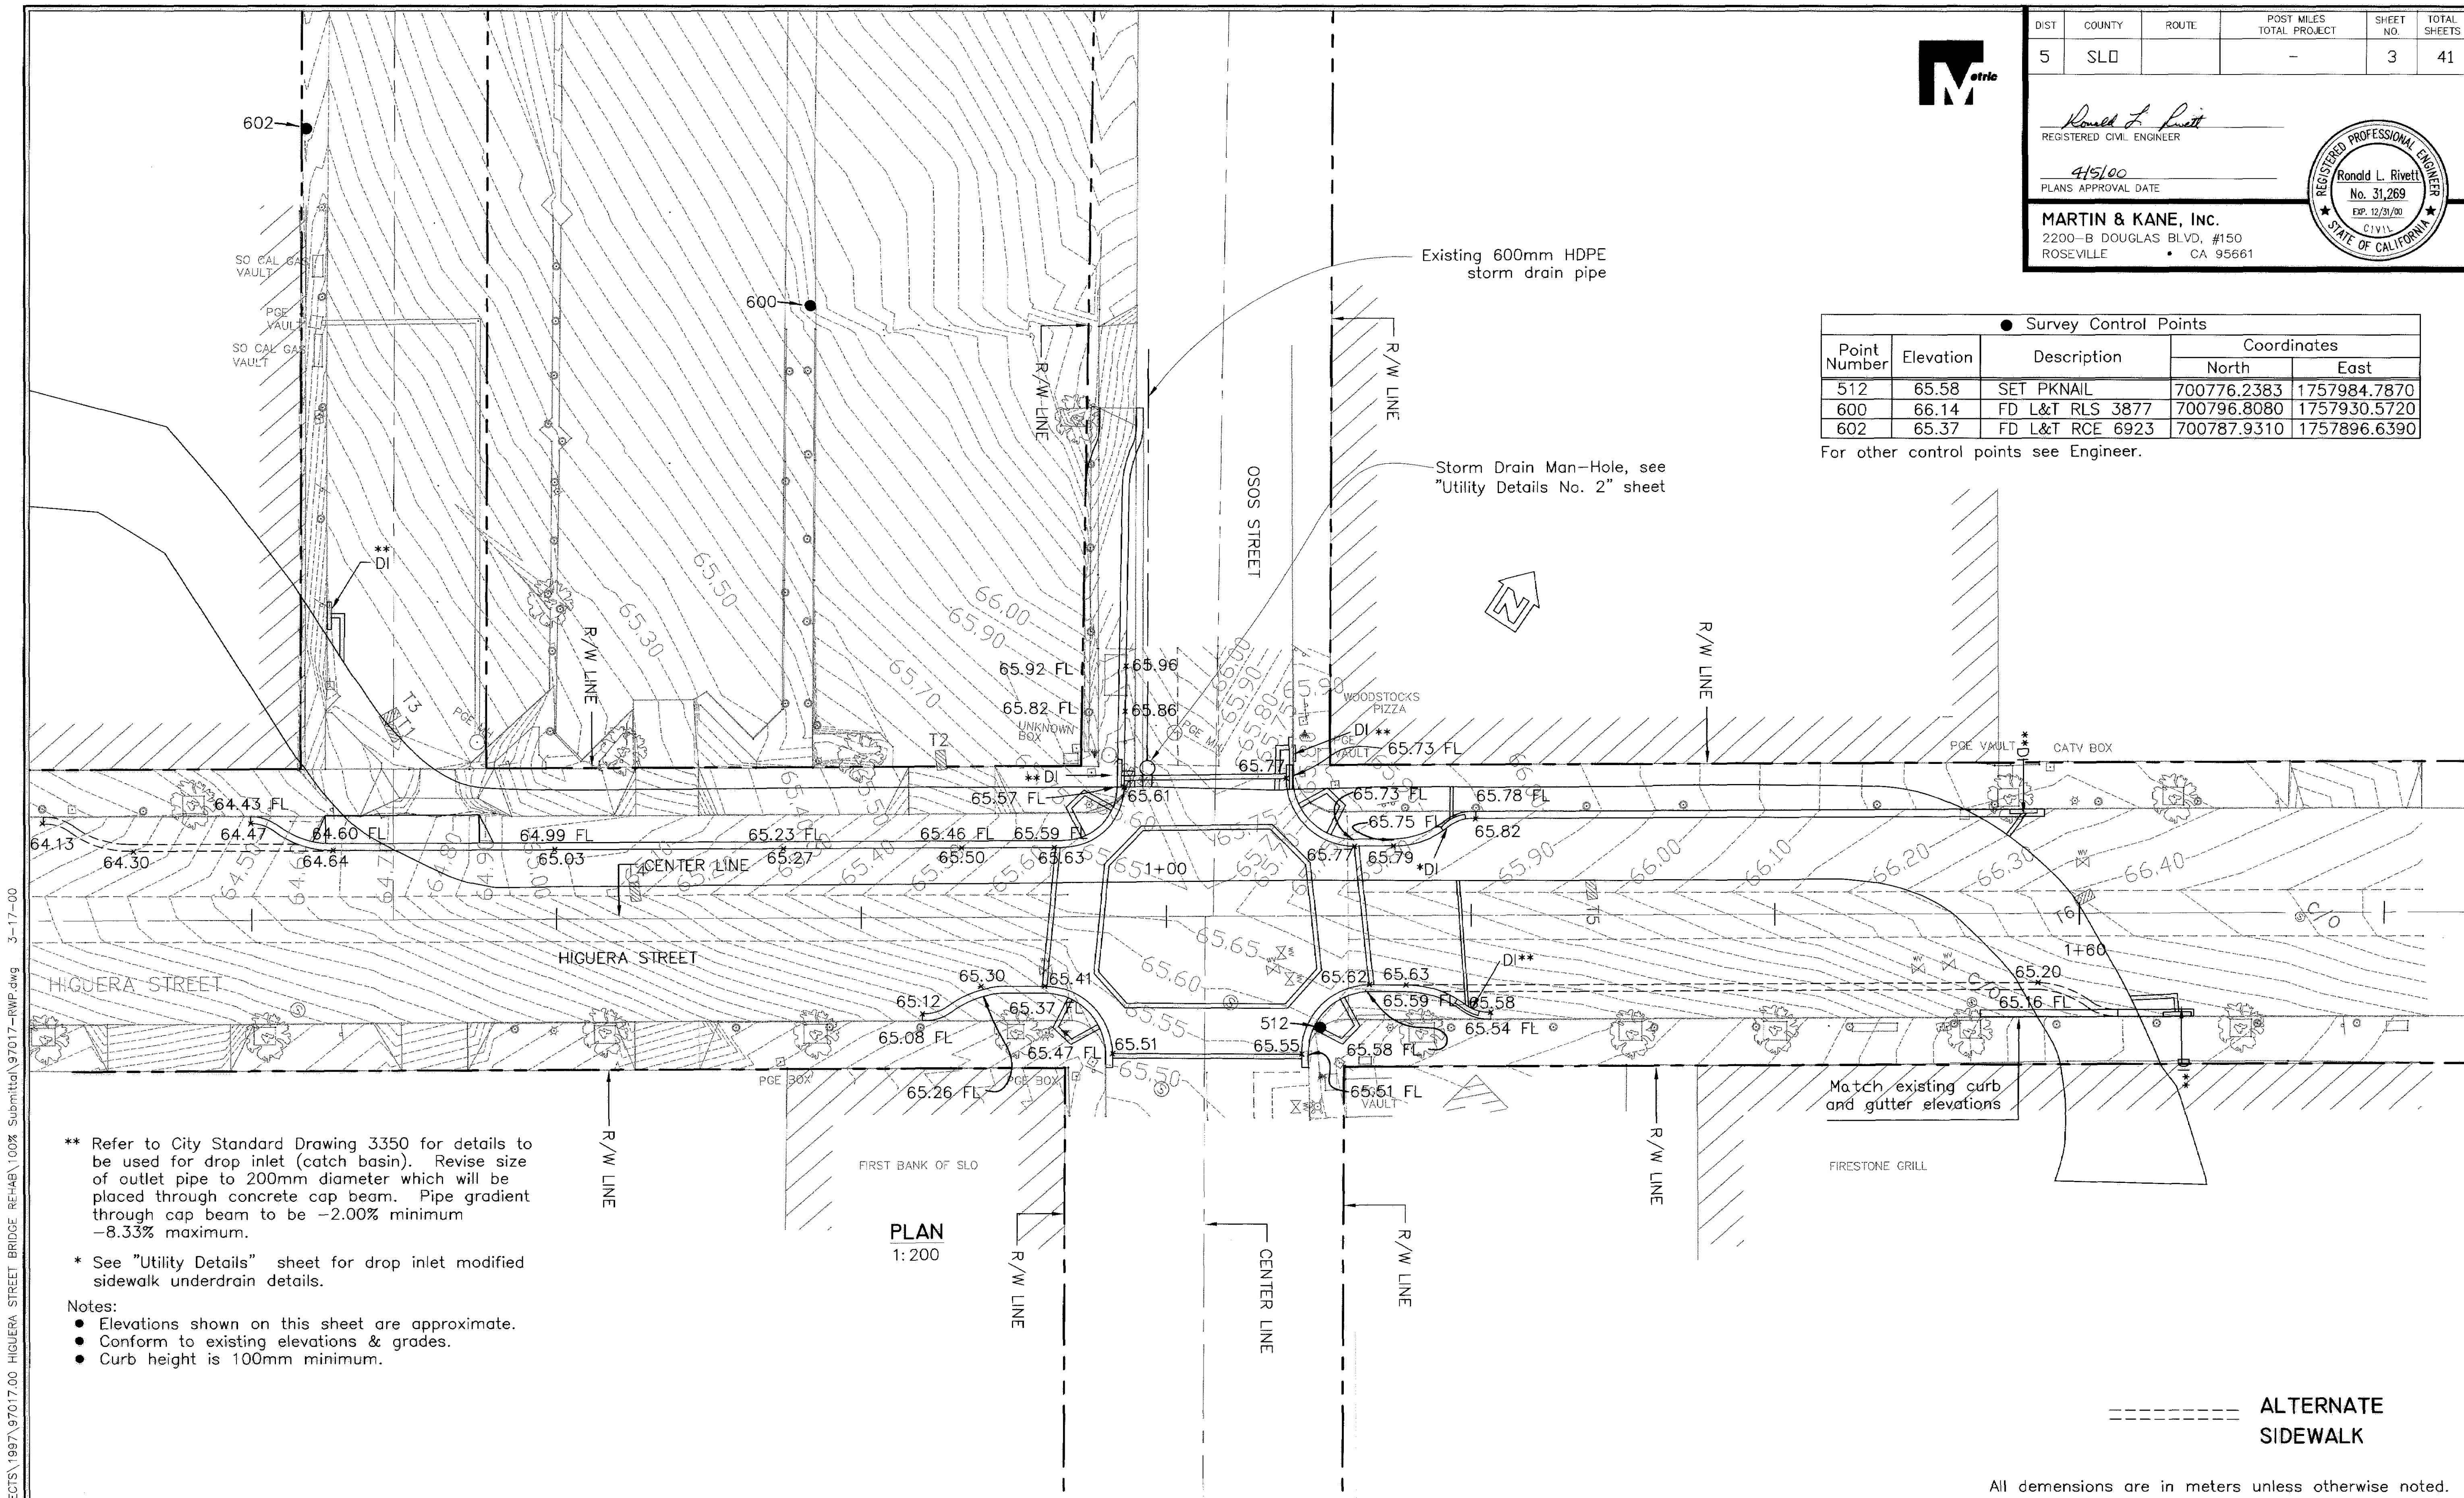


** Refer to City Standard Drawing 3350 for details to be used for drop inlet (catch basin). Revise size of outlet pipe to 200mm diameter which will be placed through concrete cap beam. Pipe gradient through cap beam to be -2.00% minimum -8.33% maximum.

* See "Utility Details" sheet for drop inlet modified sidewalk underdrain details.

Notes:

- Elevations shown on this sheet are approximate.
- Conform to existing elevations & grades.
- Curb height is 100mm minimum.

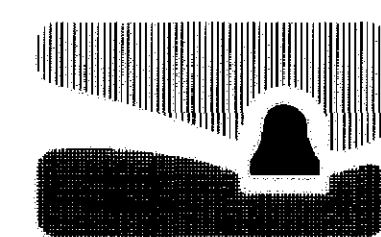

city of san luis obispo

HIGUERA STREET BRIDGE REPLACEMENT

APPROVED BY

CITY ENGINEER

DATE 3/2000

SCALE As Shown

DESIGNED BY R.C.

DRAWN BY K.B.

CHECKED BY A.O.

APPROVED BY UTILITIES DEPARTMENT

ROADWAY LAYOUT (1)

SPECIFICATION NO.

9367

FILE NO./LOCATION

0060 B

SHEET

3 OF 41

N:\MSRVR\1\K PROJECTS\1997\97017.00 HIGUERA STREET BRIDGE REHAB\100% Submittal\97017-RWP.dwg 3-17-00




DIST	COUNTY	ROUTE	POST MILES TOTAL PROJECT	SHEET NO.	TOTAL SHEETS
5	SLO			3	41

REGISTERED CIVIL ENGINEER

PLANS APPROVAL DATE

MARTIN & KANE, INC.
2200-B DOUGLAS BLVD. #150
ROSEVILLE • CA 95661

REGISTERED PROFESSIONAL ENGINEER
Ronald L. Rivett
No. 31,269
EXP. 12/31/00
CIVIL
STATE OF CALIFORNIA

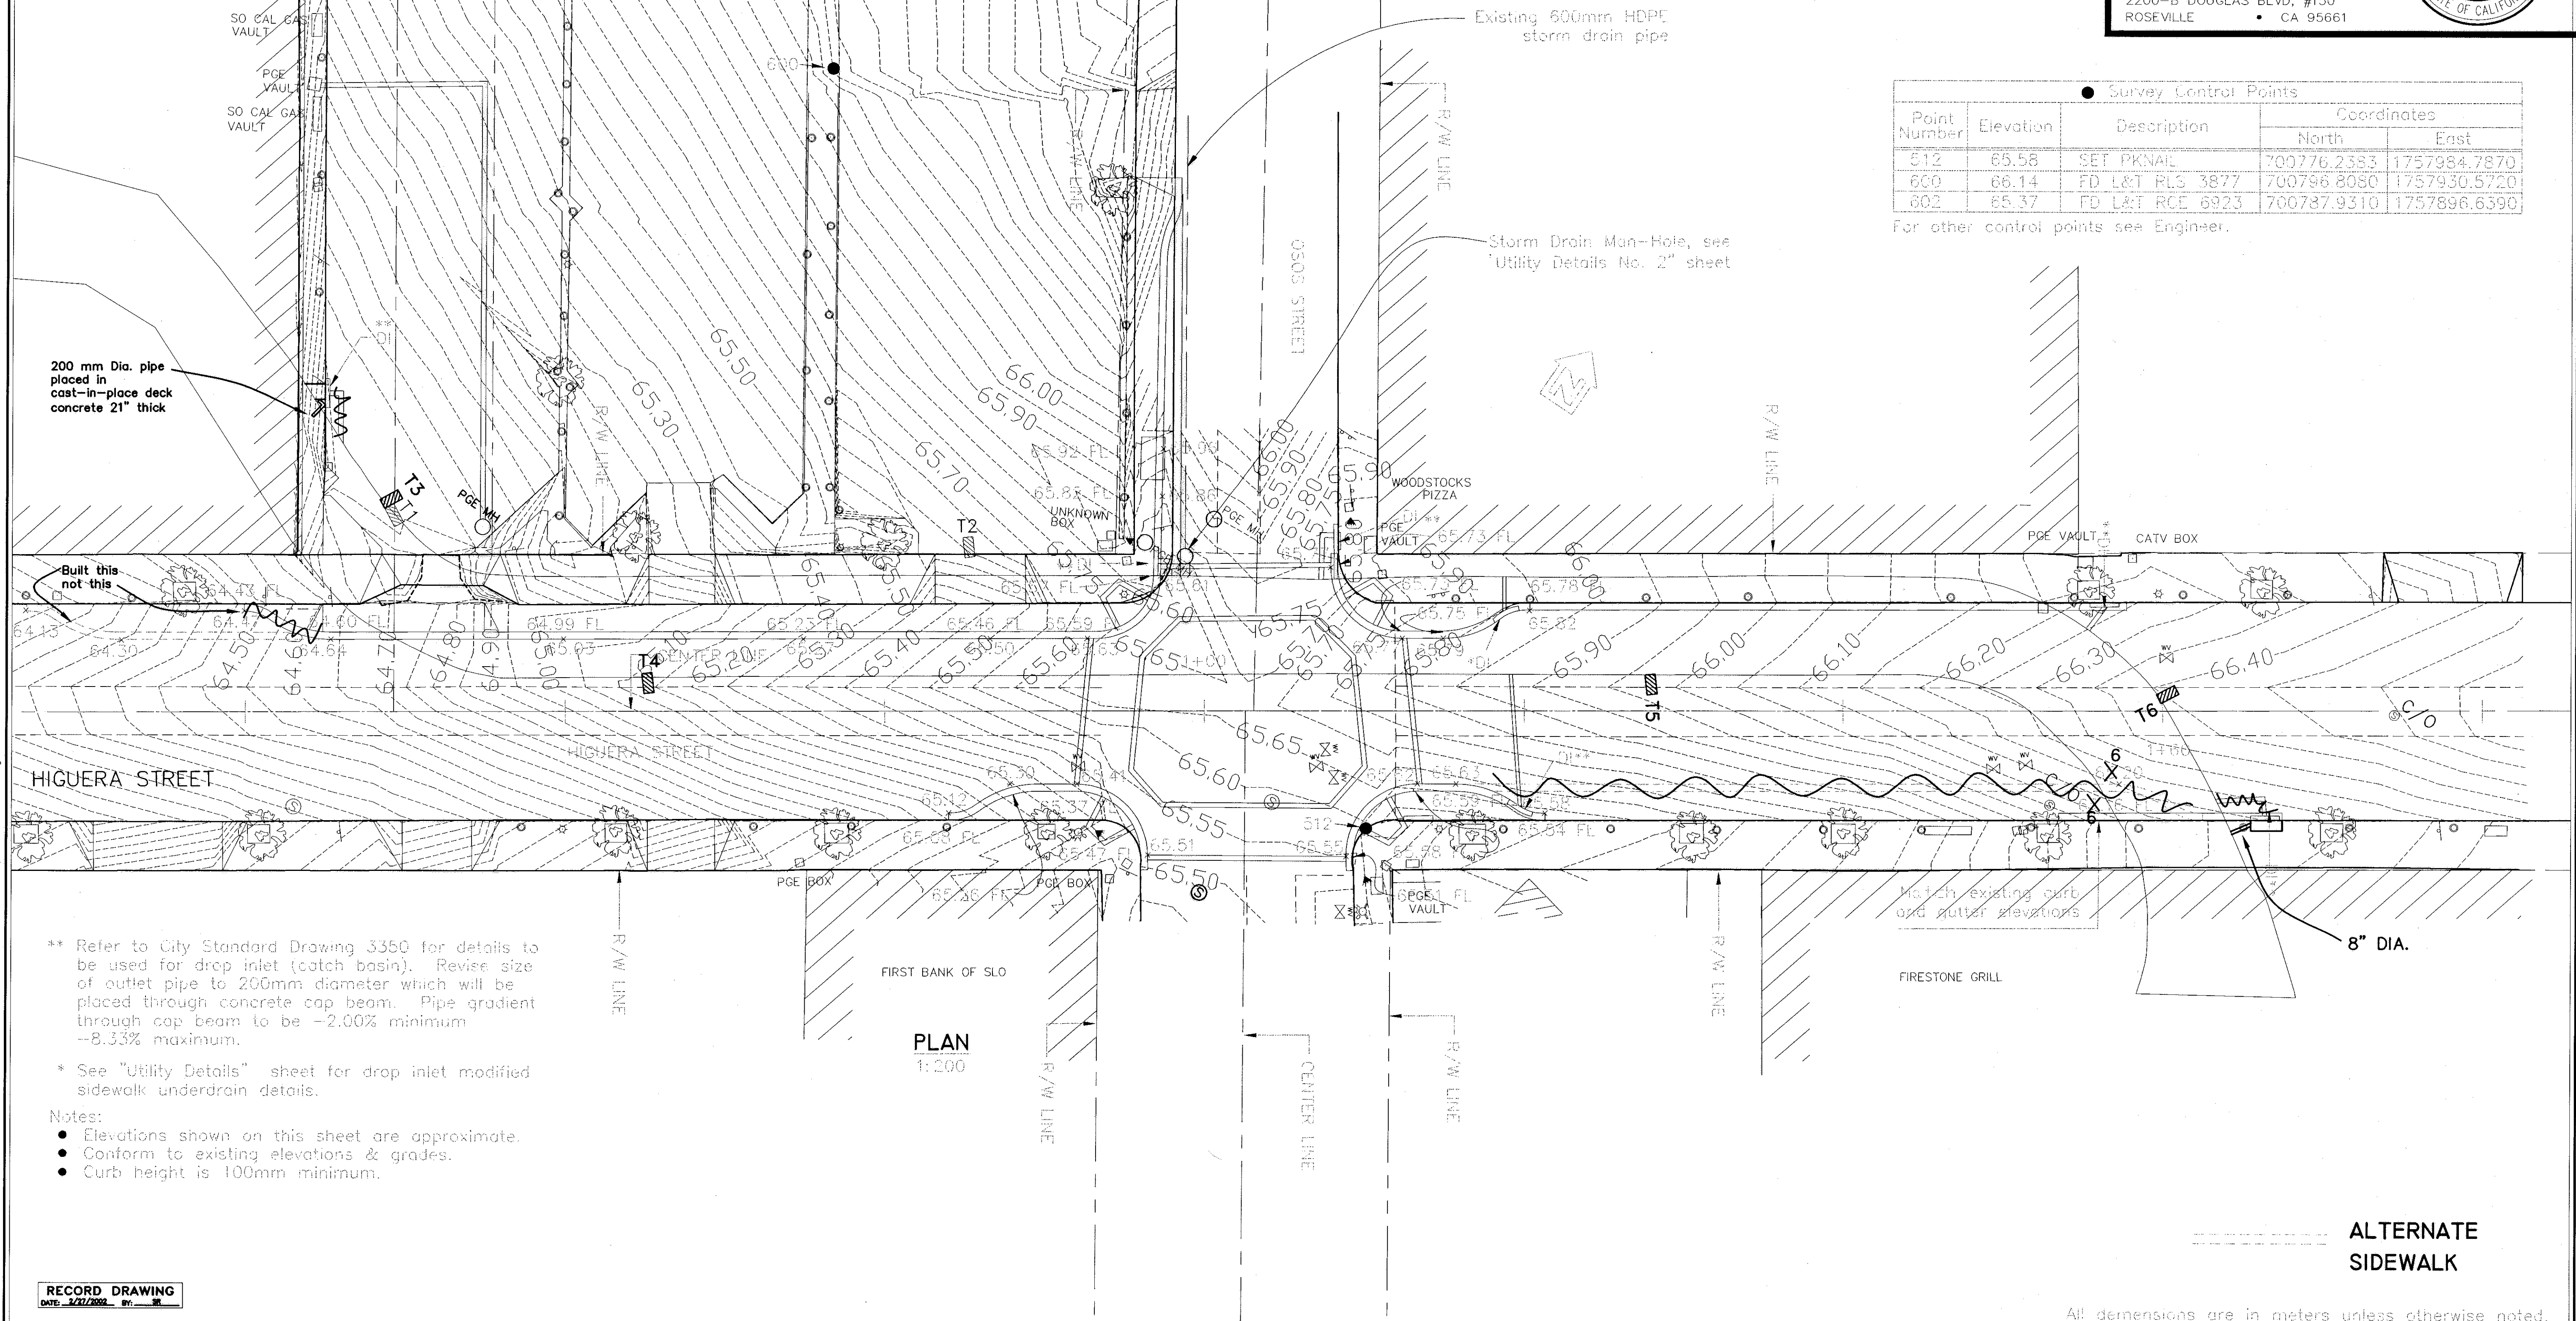


** Refer to City Standard Drawing 3350 for details to be used for drop inlet (catch basin). Revise size of outlet pipe to 200mm diameter which will be placed through concrete cap beam. Pipe gradient through cap beam to be -2.00% minimum -8.33% maximum.

* See "Utility Details" sheet for drop inlet modified sidewalk underdrain details.

Notes:

- Elevations shown on this sheet are approximate.
- Conform to existing elevations & grades.
- Curb height is 100mm minimum.

RECORD DRAWING
DATE: 1/27/2002 BY: [signature]

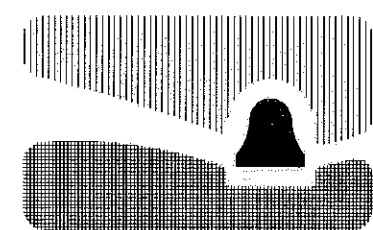

city of san luis obispo

HIGUERA STREET BRIDGE REPLACEMENT

FOR REDUCED PLANS
ORIGINAL SCALE IS IN MILLIMETERS



APPROVED BY
[signature]
CITY ENGINEER

DATE: 3/2000
SCALE: As Shown
DESIGNED BY: R.C.
DRAWN BY: K.B.
CHECKED BY: A.O.
APPROVED BY:
UTILITIES DEPARTMENT

ROADWAY LAYOUT (1)

SPECIFICATION NO.
9367
FILE NO./LOCATION
0060 B
SHEET
3R of 41

All dimensions are in meters unless otherwise noted.

N:\MSR\1\WK PROJECTS\1997\97017.00 HIGUERA STREET BRIDGE REHAB\100% Submittal\97017-SWP.dwg 3-17-00





DIST	COUNTY	ROUTE	POST MILES TOTAL PROJECT	SHEET NO.	TOTAL SHEETS
5	SLO		-	4	41

Ronald L. Rivett
REGISTERED CIVIL ENGINEER
4/5/00
PLANS APPROVAL DATE

MARTIN & KANE, INC.
2200-B DOUGLAS BLVD, #150
ROSEVILLE CA 95661

REGISTERED PROFESSIONAL ENGINEER
No. 31,269
EXP. 12/31/00
CIVIL
STATE OF CALIFORNIA

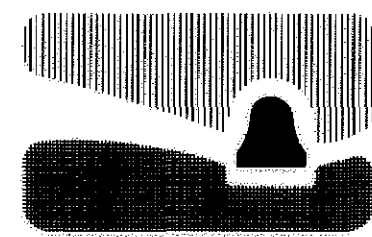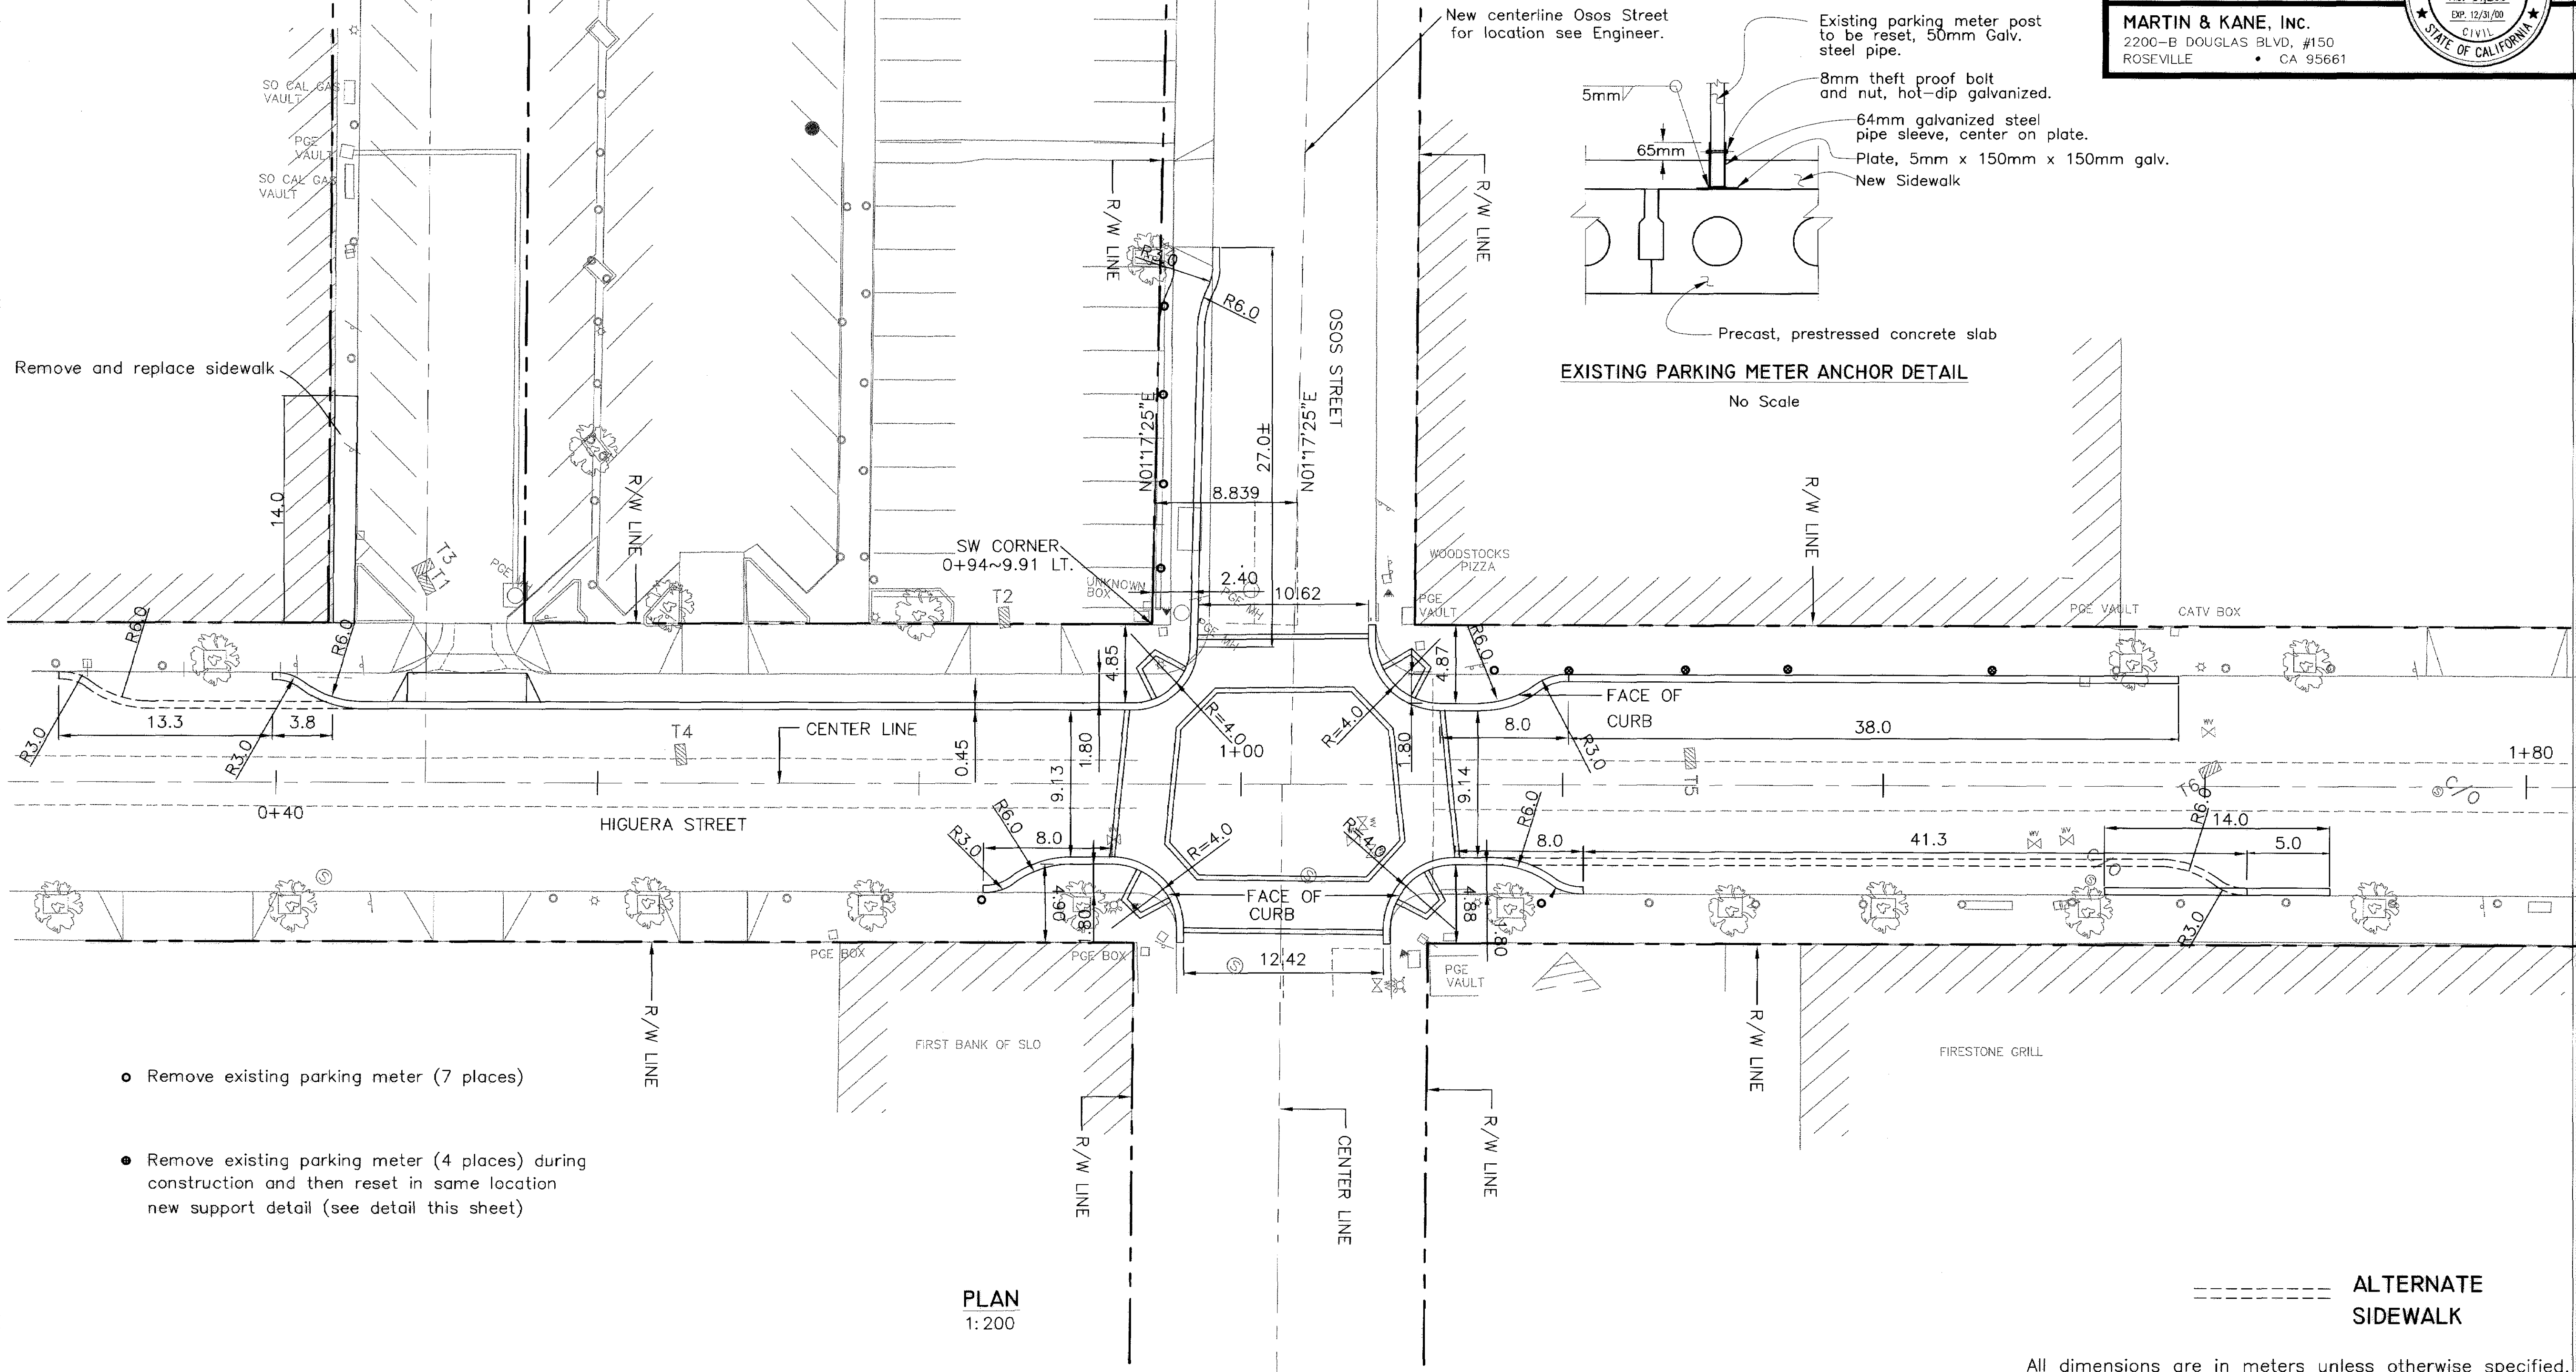

city of san luis obispo

HIGUERA STREET BRIDGE REPLACEMENT

FOR REDUCED PLANS
ORIGINAL SCALE IS IN MILLIMETERS



APPROVED BY

CITY ENGINEER

DATE 3/2000

SCALE As Shown

DESIGNED BY R.C.

DRAWN BY K.B.

CHECKED BY A.O.

APPROVED BY

UTILITIES DEPARTMENT

ROADWAY LAYOUT (2)

SPECIFICATION NO.

9367

FILE NO./LOCATION

0060 B

SHEET

4 of 41

N:\MSR\1\WK PROJECTS\1997\97017.00 HIGUERA STREET BRIDGE RELIAB\100% Submittal\9/01/-SWP.dwg 3-17-00





DIST	COUNTY	ROUTE	POST MILES TOTAL PROJECT	SHEET NO	TOTAL SHEETS
5	SLO			4	41

REGISTERED CIVIL ENGINEER

PLANS APPROVAL DATE

MARTIN & KANE, INC.
2200-B DOUGLAS BLVD, #150
ROSEVILLE CA 95661

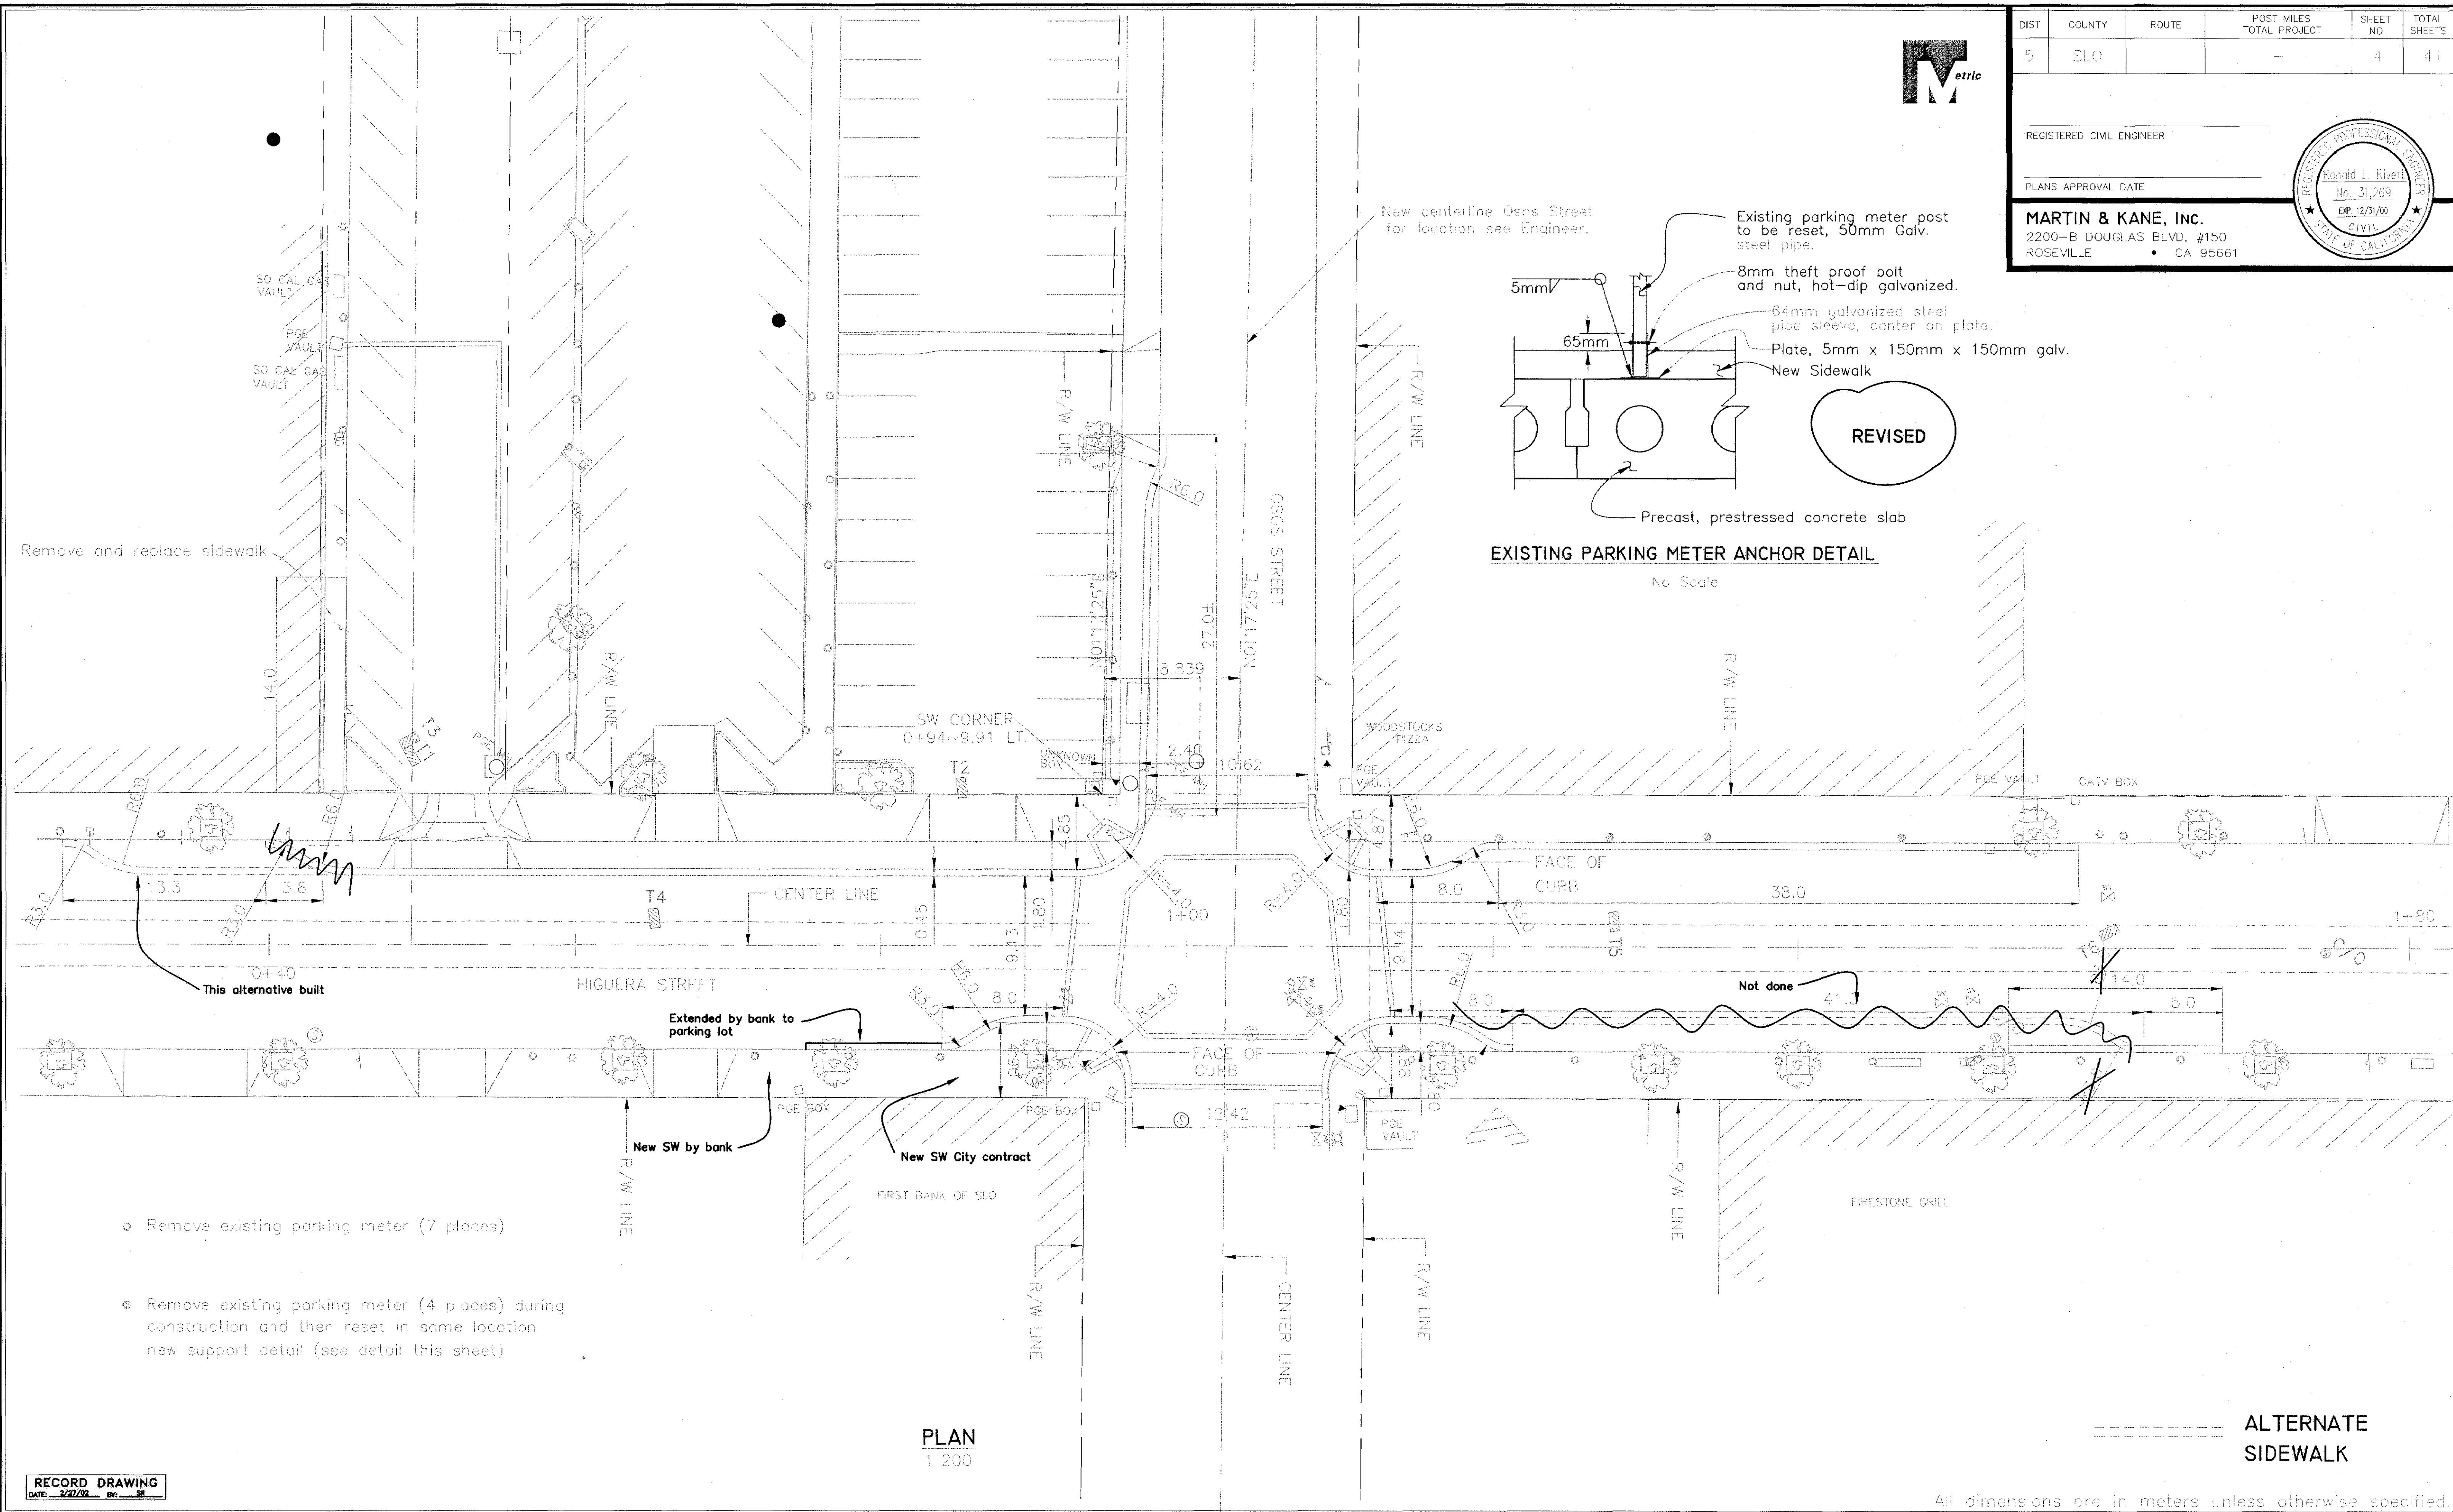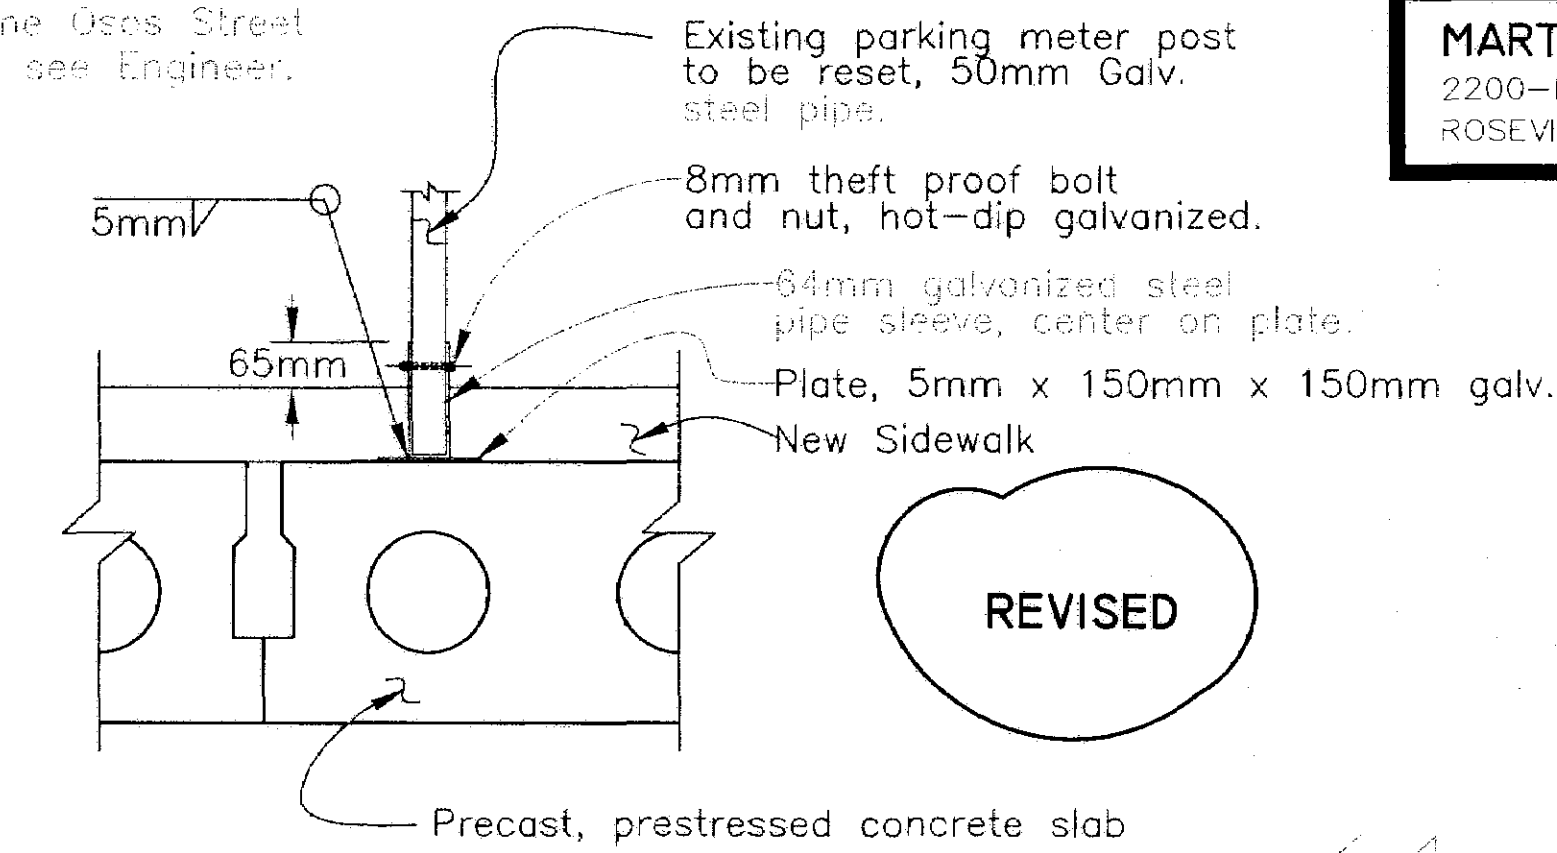

RECORD DRAWING
DATE: 2/27/02 BY: SE



city of san luis obispo

HIGUERA STREET BRIDGE REPLACEMENT

FOR REDUCED PLANS
ORIGINAL SCALE IS IN MILLIMETERS

0 20 40 60 80 100

APPROVED BY
CITY ENGINEER

DATE 3/2000
SCALE As Shown
DESIGNED BY R.C.
DRAWN BY K.B.
CHECKED BY A.O.
APPROVED BY
UTILITIES DEPARTMENT

ROADWAY LAYOUT (2)

SPECIFICATION NO. 9367
FILE NO./LOCATION 0060 B
SHEET 4R OF 41

All dimensions are in meters unless otherwise specified.

----- ALTERNATE SIDEWALK

N:\MKSRV\1\MK PROJECTS\1997\97017.00 HIGUERA STREET BRIDGE REHA\100% Submittal\97017-UP1.dwg 3-17-00




DIST	COUNTY	ROUTE	POST MILES TOTAL PROJECT	SHEET NO.	TOTAL SHEETS
5	SLO		—	5	41

Ronald L. Rivett
REGISTERED CIVIL ENGINEER


4/5/00
PLANS APPROVAL DATE

MARTIN & KANE, INC.
2200-B DOUGLAS BLVD, #150
ROSEVILLE • CA 95661

REGISTERED PROFESSIONAL ENGINEER
Ronald L. Rivett
No. 31,269
EXP. 12/31/00
CIVIL
STATE OF CALIFORNIA

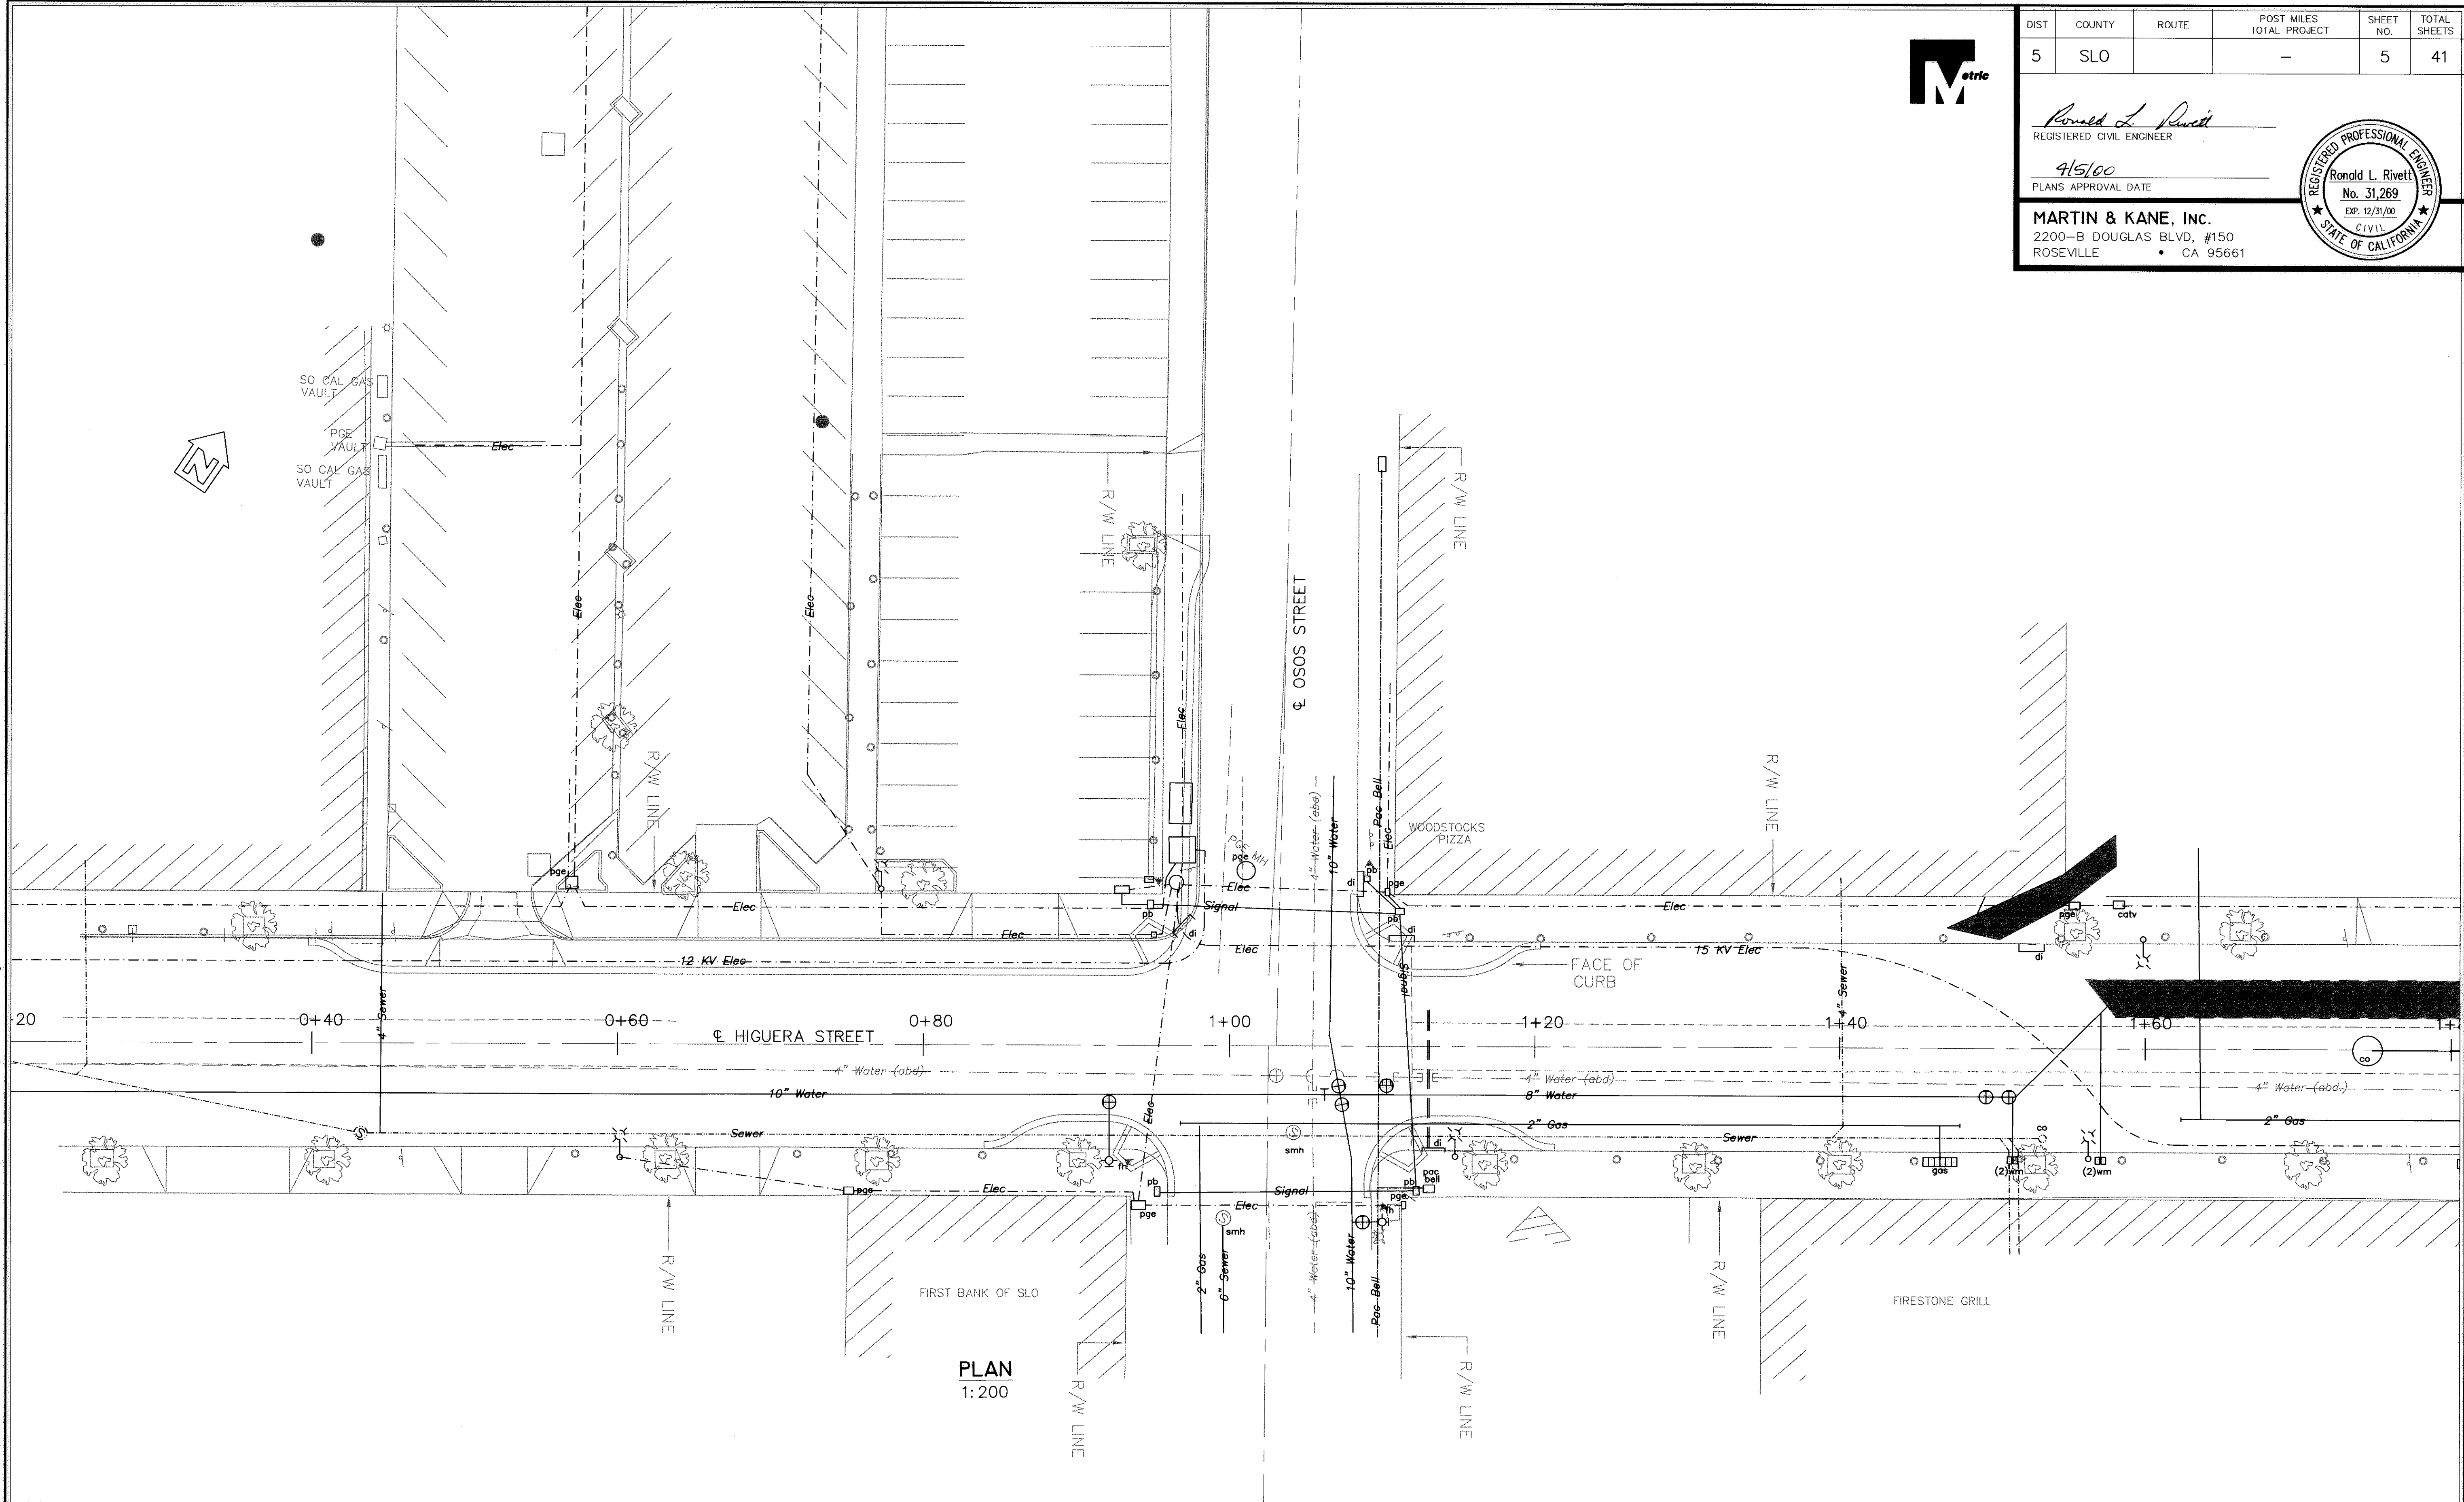

PLAN
1:200

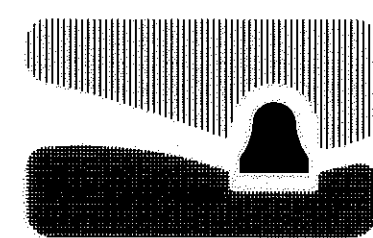

city of san luis obispo

HIGUERA STREET BRIDGE REPLACEMENT

FOR REDUCED PLANS
ORIGINAL SCALE IS IN MILLIMETERS

0 20 40 60 80 100

APPROVED BY

CITY ENGINEER

DATE 3/2000

SCALE As Shown

DESIGNED BY R.C.

DRAWN BY K.W.

CHECKED BY R.R.

APPROVED BY

UTILITIES DEPARTMENT

UTILITY PLAN NO. 1
(NOT INCLUDING UTILITIES UNDER BRIDGE)

SPECIFICATION NO.

9367

FILE NO./LOCATION

0000 B

SHEET

5 OF 41

N:\MKSRV\1\MK PROJECTS\1997\97017.00 HIGUERA STREET BRIDGE REHAB\100% Submittal\97017-UP1.dwg 3-17-00




DIST	COUNTY	ROUTE	POST MILES TOTAL PROJECT	SHEET NO.	TOTAL SHEETS
5	SLO		—	5	41

REGISTERED CIVIL ENGINEER


PLANS APPROVAL DATE

MARTIN & KANE, INC.
2200-B DOUGLAS BLVD, #150
ROSEVILLE • CA 95661

REGISTERED PROFESSIONAL ENGINEER
Ronald L. Rivett
No. 31,269
Exp. 12/31/00
CIVIL
STATE OF CALIFORNIA

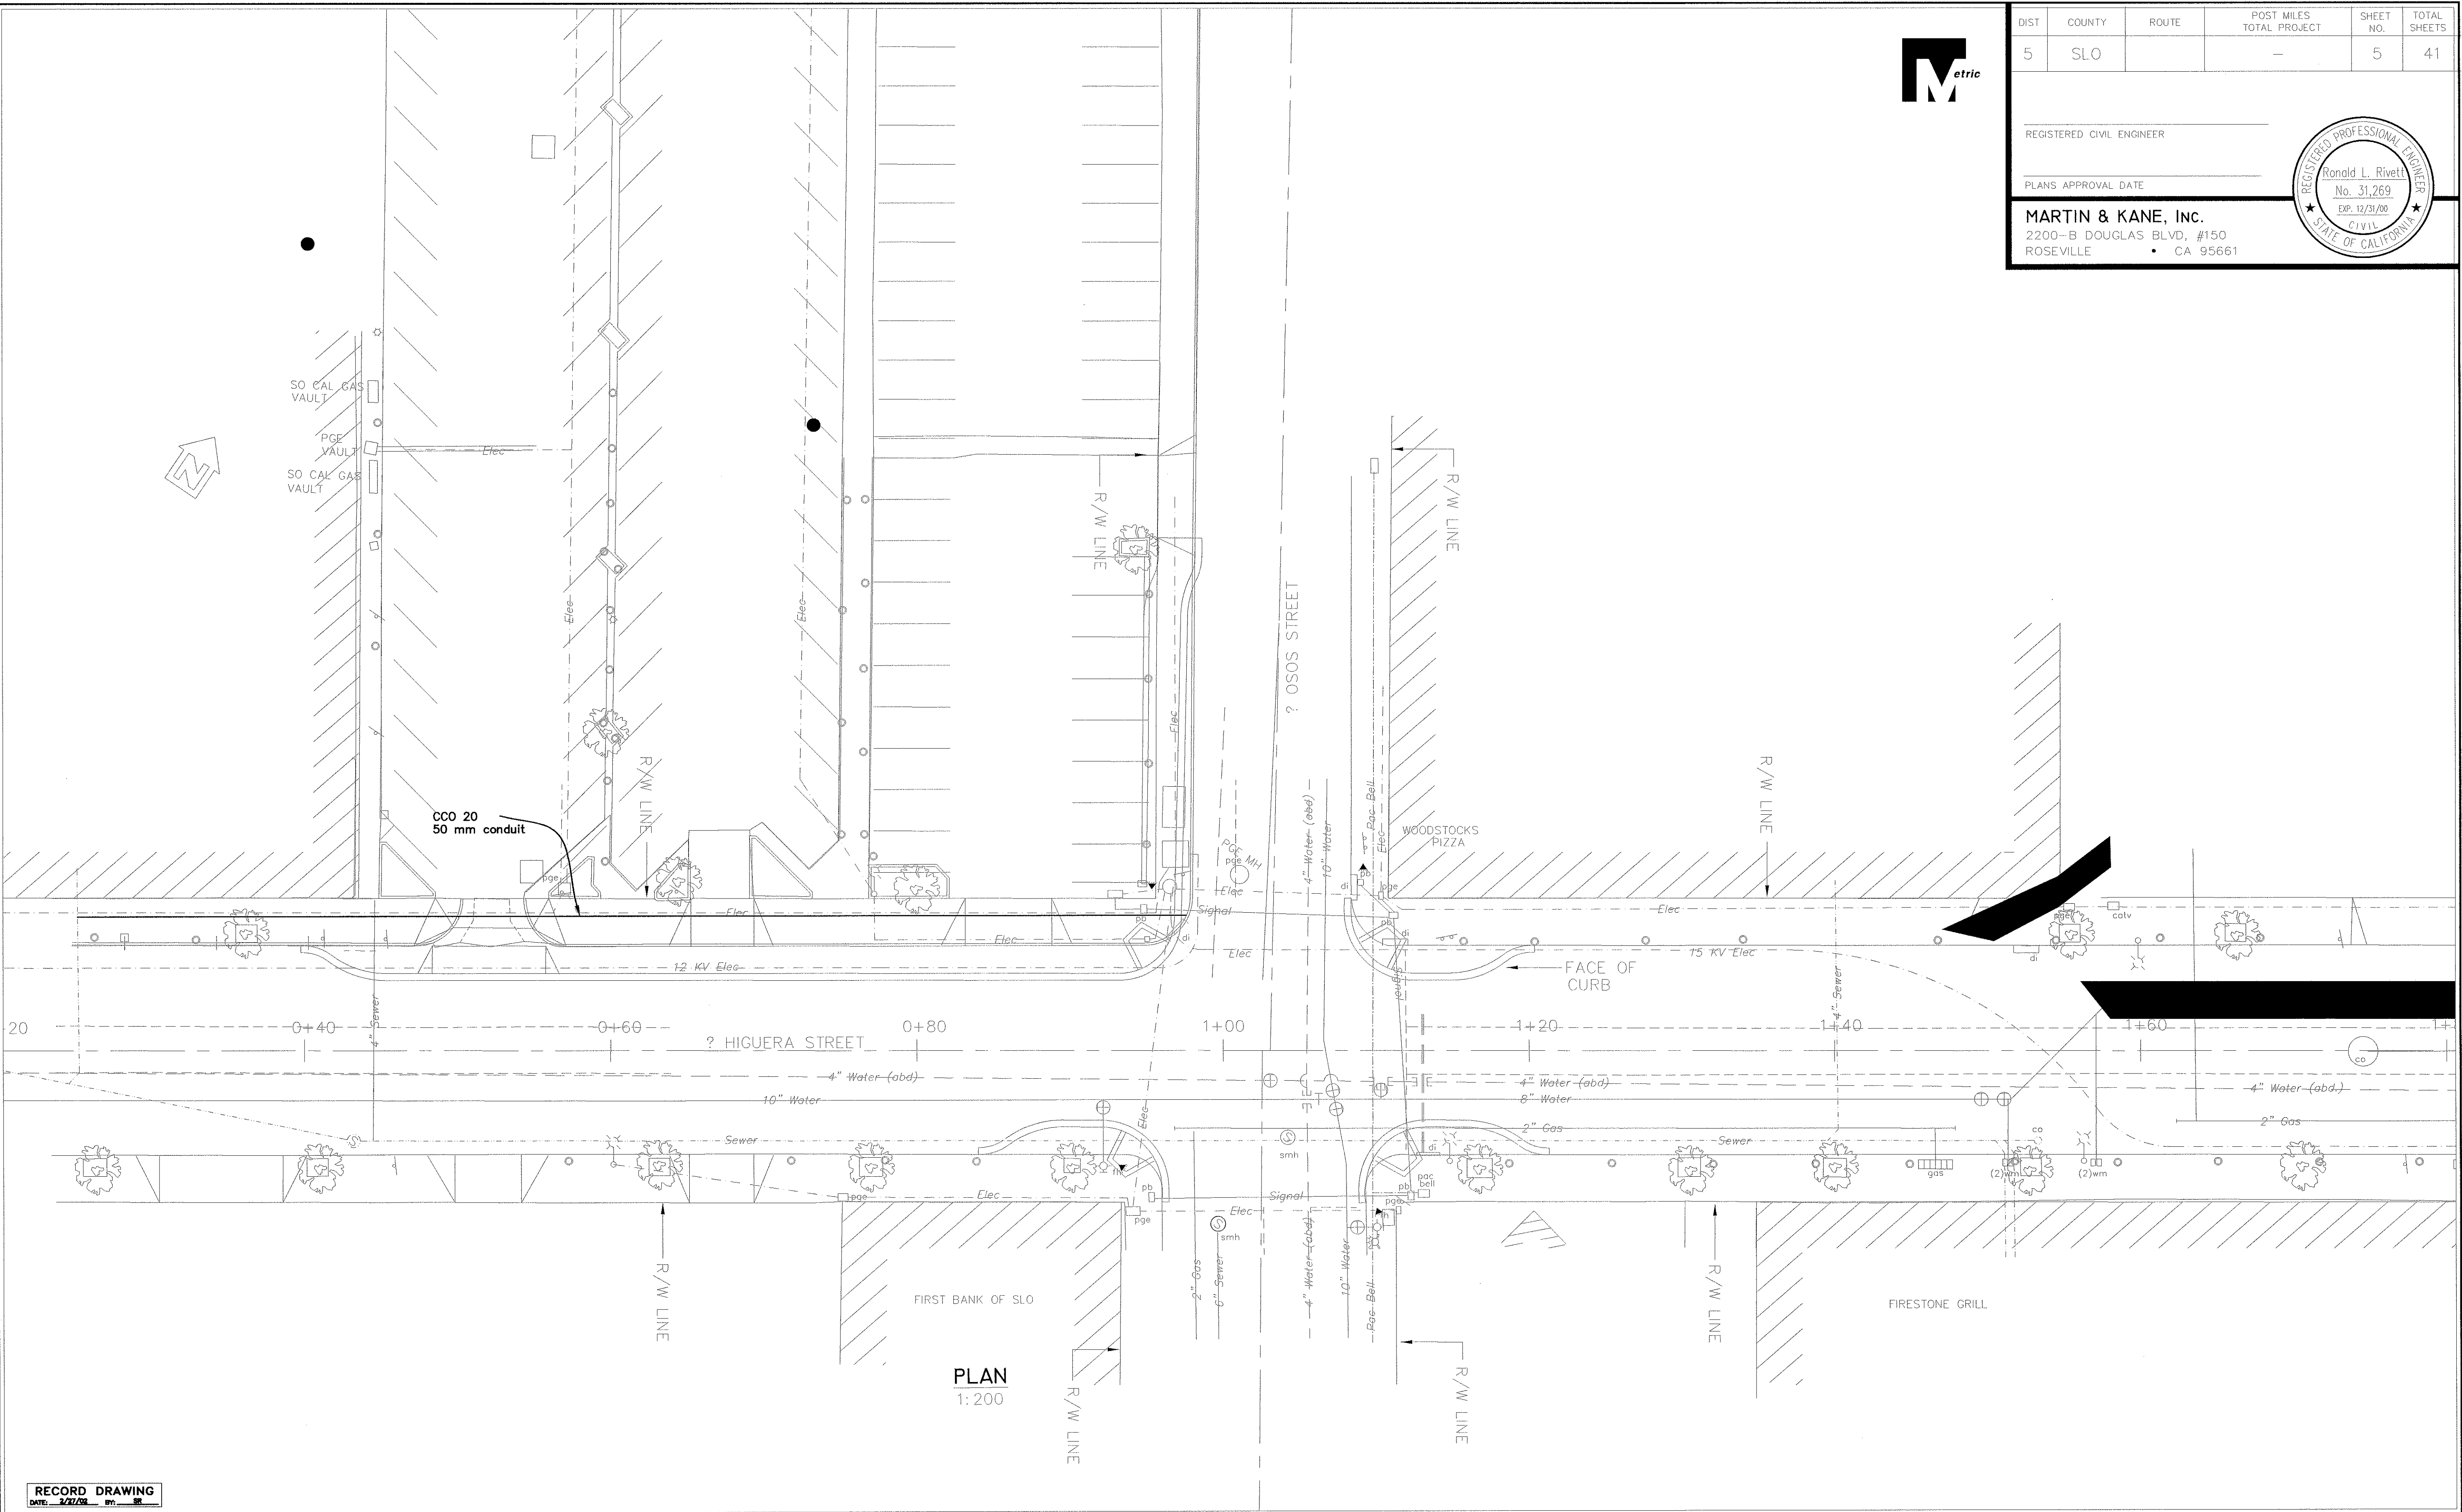

RECORD DRAWING
DATE: 3/27/00 BY: SR

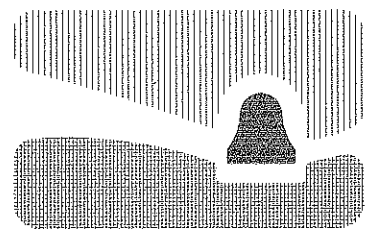

city of san luis OBISPO

HIGUERA STREET BRIDGE REPLACEMENT

FOR REDUCED PLANS
ORIGINAL SCALE IS IN MILLIMETERS

0 20 40 60 80 100

APPROVED BY

CITY ENGINEER

DATE 3/2000
SCALE As Shown
DESIGNED BY R.C.
DRAWN BY K.W.
CHECKED BY R.R.
APPROVED BY
UTILITIES DEPARTMENT

UTILITY PLAN NO. 1
(NOT INCLUDING UTILITIES UNDER BRIDGE)

SPECIFICATION NO.
9367
FILE NO./LOCATION
0060 B
SHEET
5R of 41

N:\WORK\PROJECTS\1997\97017.00 HIGUERA STREET BRIDGE REHAB\100% Submittal\97017-UP2.dwg 3-17-00




DIST	COUNTY	ROUTE	POST MILES TOTAL PROJECT	SHEET NO.	TOTAL SHEETS
5	SLO		-	6	41

Ronald L. Rivett
REGISTERED CIVIL ENGINEER

4/5/00
PLANS APPROVAL DATE

MARTIN & KANE, INC.
2200-B DOUGLAS BLVD, #150
ROSEVILLE • CA 95661

REGISTERED PROFESSIONAL ENGINEER
Ronald L. Rivett
No. 31,269
EXP. 12/31/00
CIVIL
STATE OF CALIFORNIA

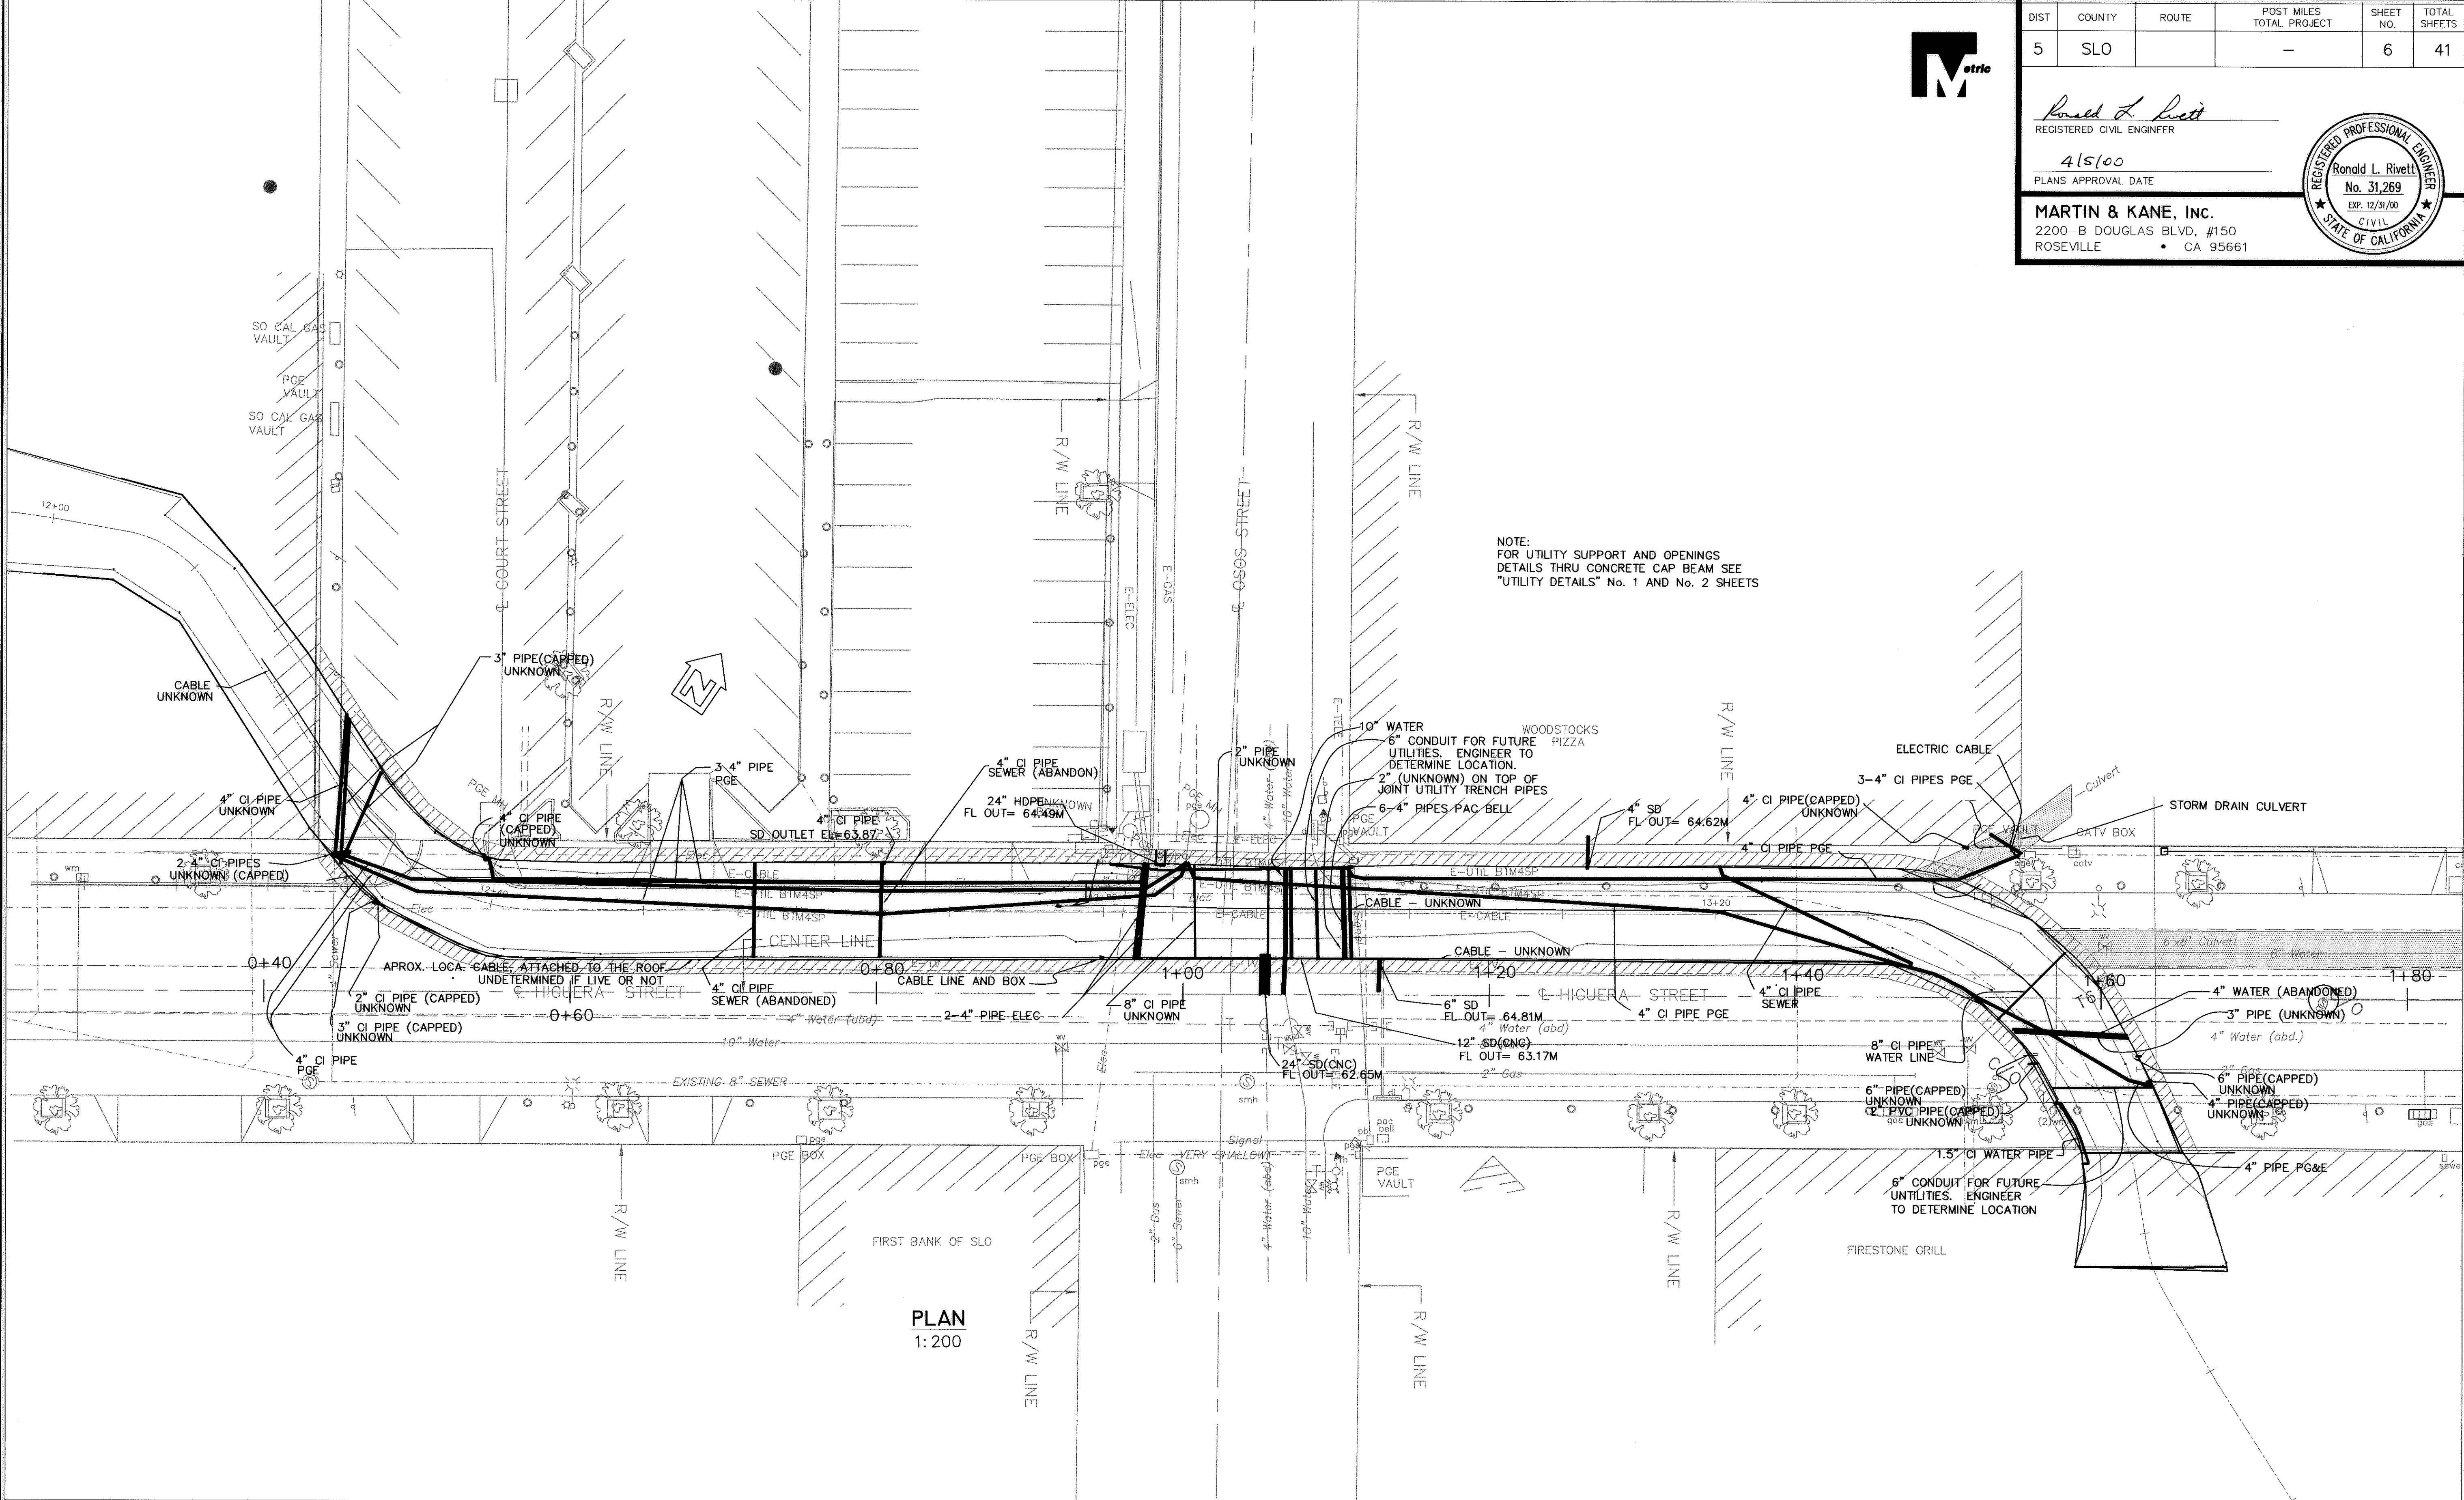


NOTE:
FOR UTILITY SUPPORT AND OPENINGS
DETAILS THRU CONCRETE CAP BEAM SEE
"UTILITY DETAILS" No. 1 AND No. 2 SHEETS

PLAN
1:200



HIGUERA STREET BRIDGE REPLACEMENT

 FOR REDUCED PLANS
ORIGINAL SCALE IS IN MILLIMETERS




CITY ENGINEER

DATE 3/2000
SCALE As Shown
DESIGNED BY R.C.
DRAWN BY K.W.
CHECKED BY M.L.
APPROVED BY
UTILITIES DEPARTMENT

UTILITY PLAN NO. 2
EXISTING UTILITIES UNDERNEATH BRIDGE

SPECIFICATION NO.
9367
FILE NO./LOCATION
0860 B
SHEET
6 of 41

N:\MSRVR\1\MK PROJECTS\1997\97017.00 HIGUERA STREET BRIDGE REHAB\100% Submittal\97017-UP2.dwg 3-17-00

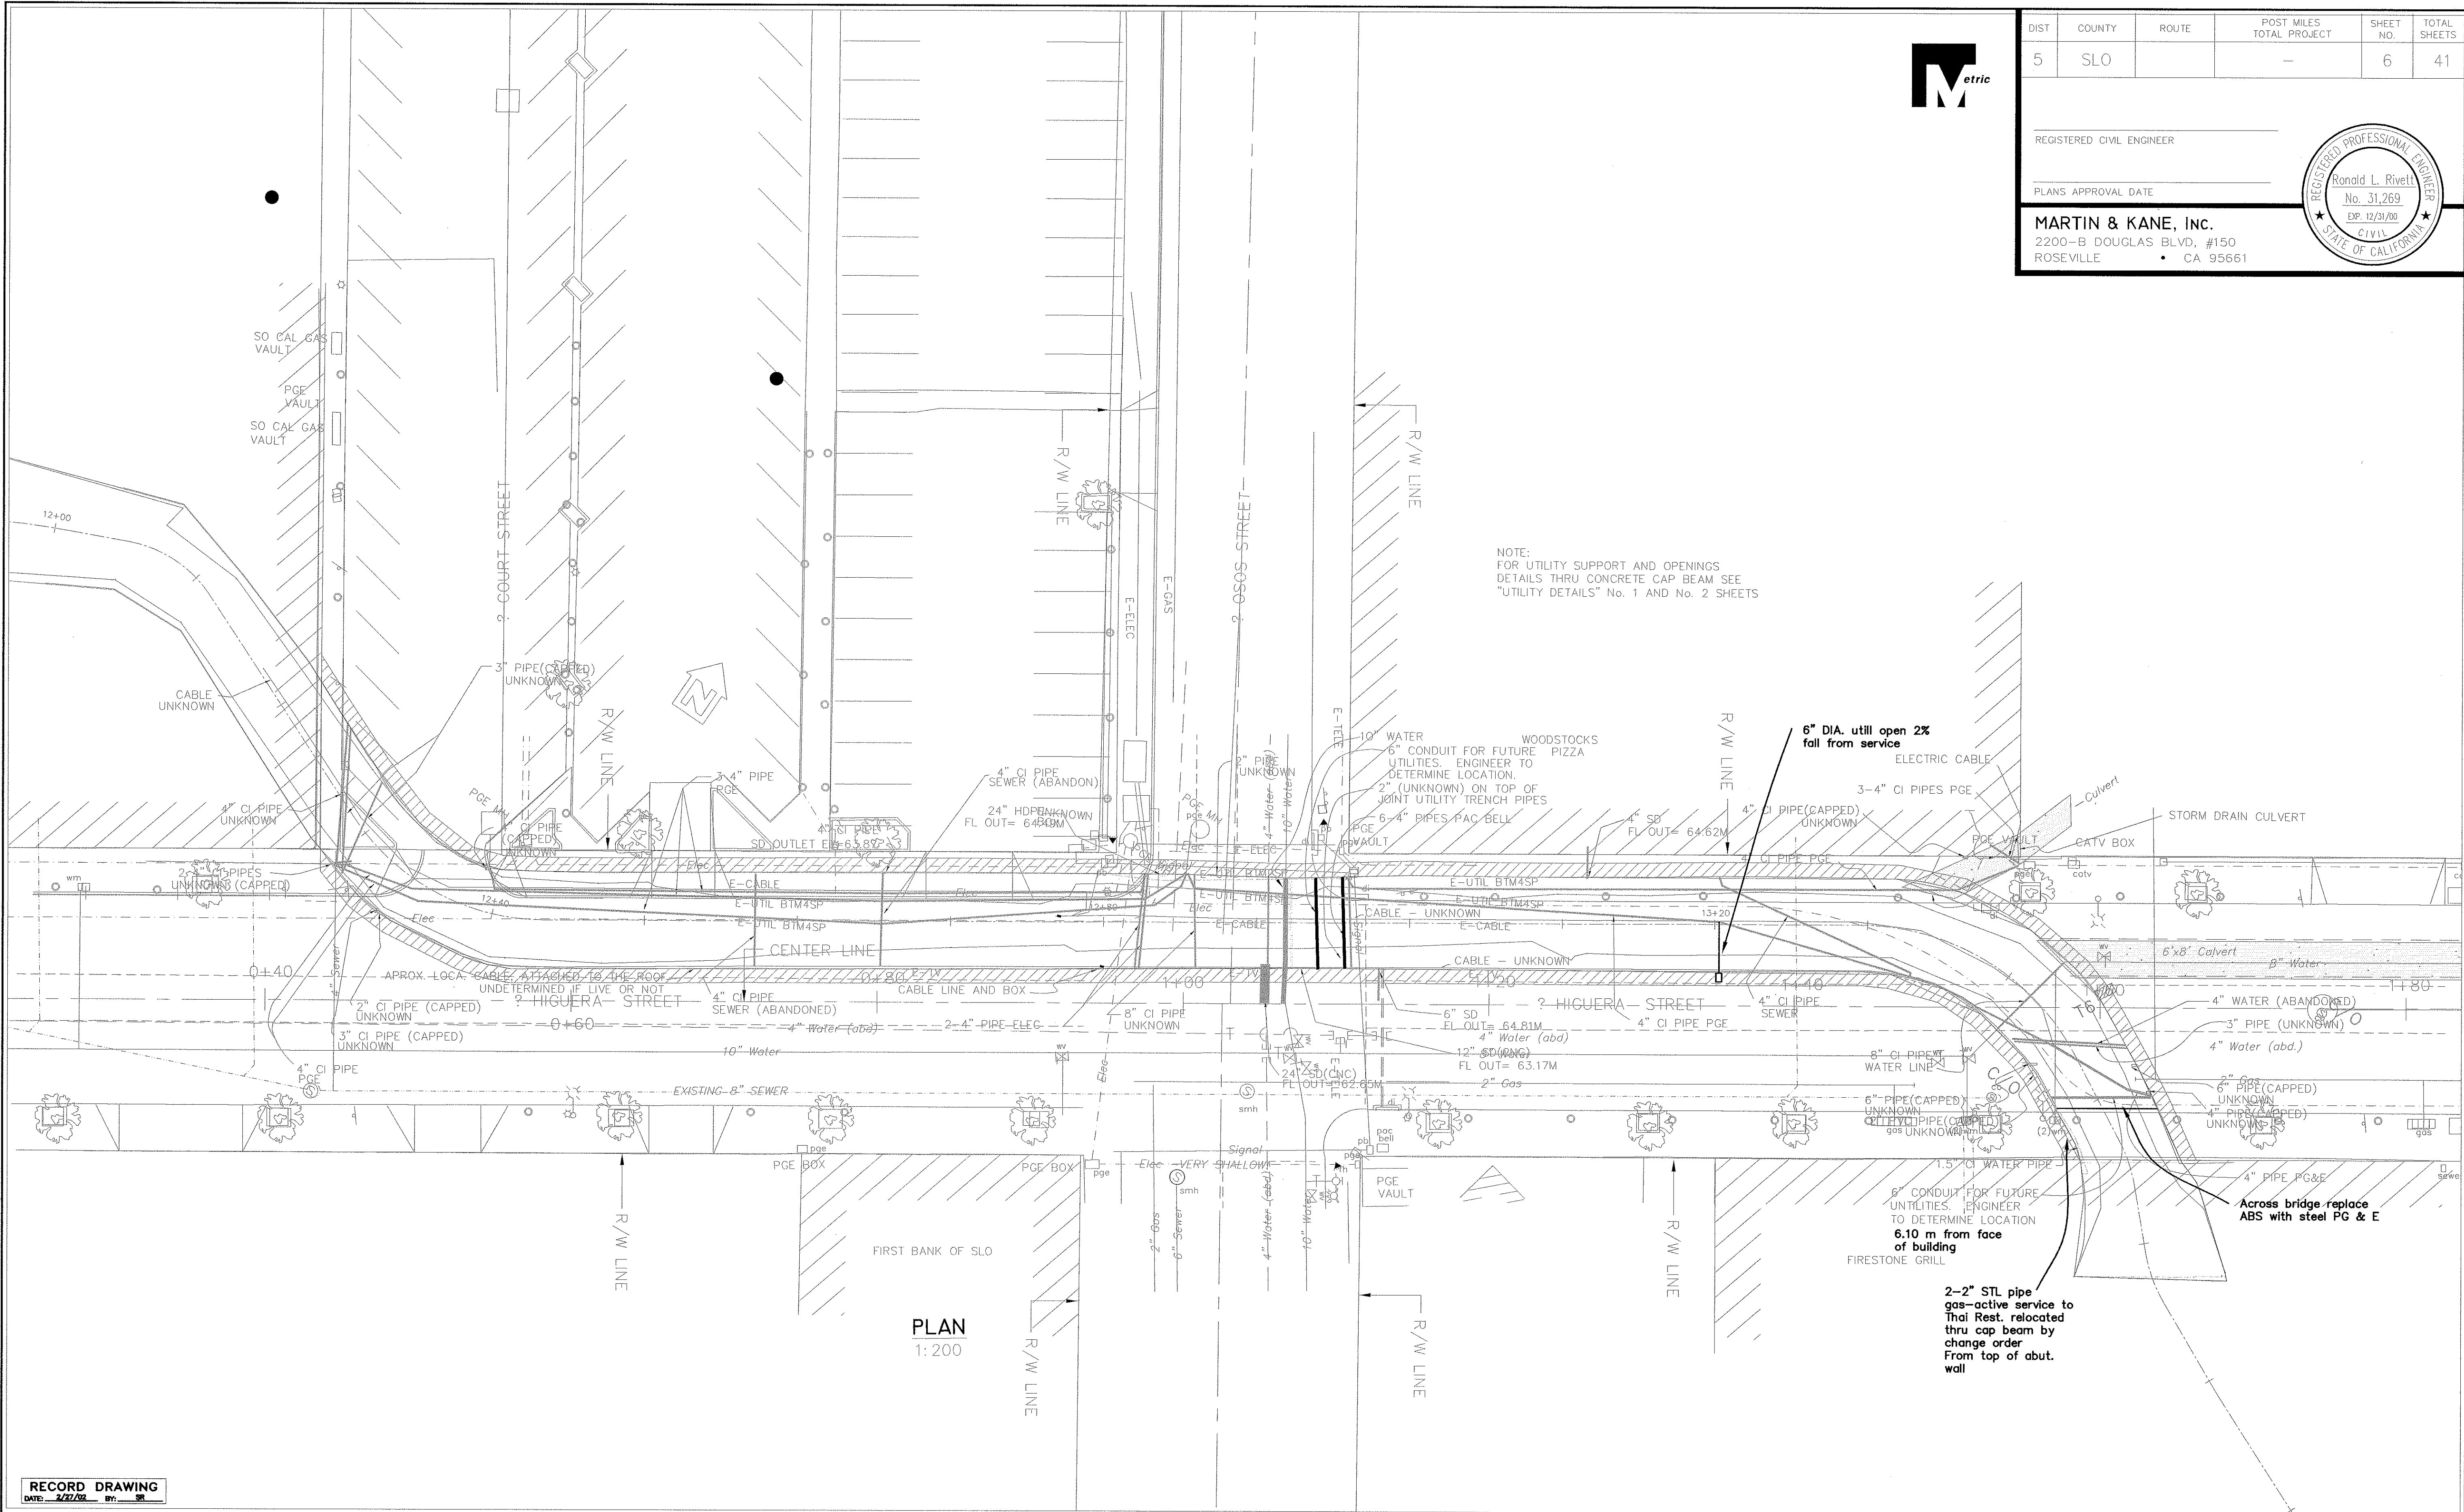

DIST	COUNTY	ROUTE	POST MILES TOTAL PROJECT	SHEET NO.	TOTAL SHEETS
5	SLO		-	6	41

REGISTERED CIVIL ENGINEER

PLANS APPROVAL DATE

MARTIN & KANE, INC.

2200-B DOUGLAS BLVD. #150
ROSEVILLE • CA 95661

REGISTERED PROFESSIONAL ENGINEER


Ronald L. Rivett

No. 31,269

EXP. 12/31/00

CIVIL


STATE OF CALIFORNIA

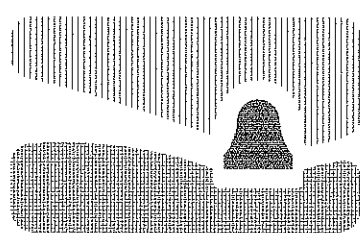

city of san luis obispo

HIGUERA STREET BRIDGE REPLACEMENT

 FOR REDUCED PLANS
ORIGINAL SCALE IS IN MILLIMETERS





CITY ENGINEER

DATE	3/2000
SCALE	As Shown
DESIGNED BY	R.C.
DRAWN BY	K.W.
CHECKED BY	M.L.
APPROVED BY	
UTILITIES DEPARTMENT	


UTILITY PLAN NO. 2
EXISTING UTILITIES UNDERNEATH BRIDGE

SPECIFICATION NO.	9367
FILE NO./LOCATION	0060 B
SHEET	6R of 41

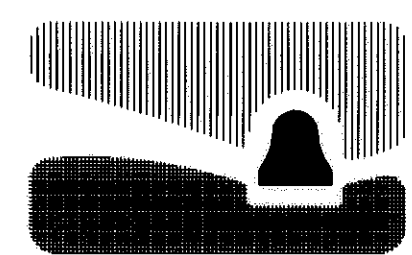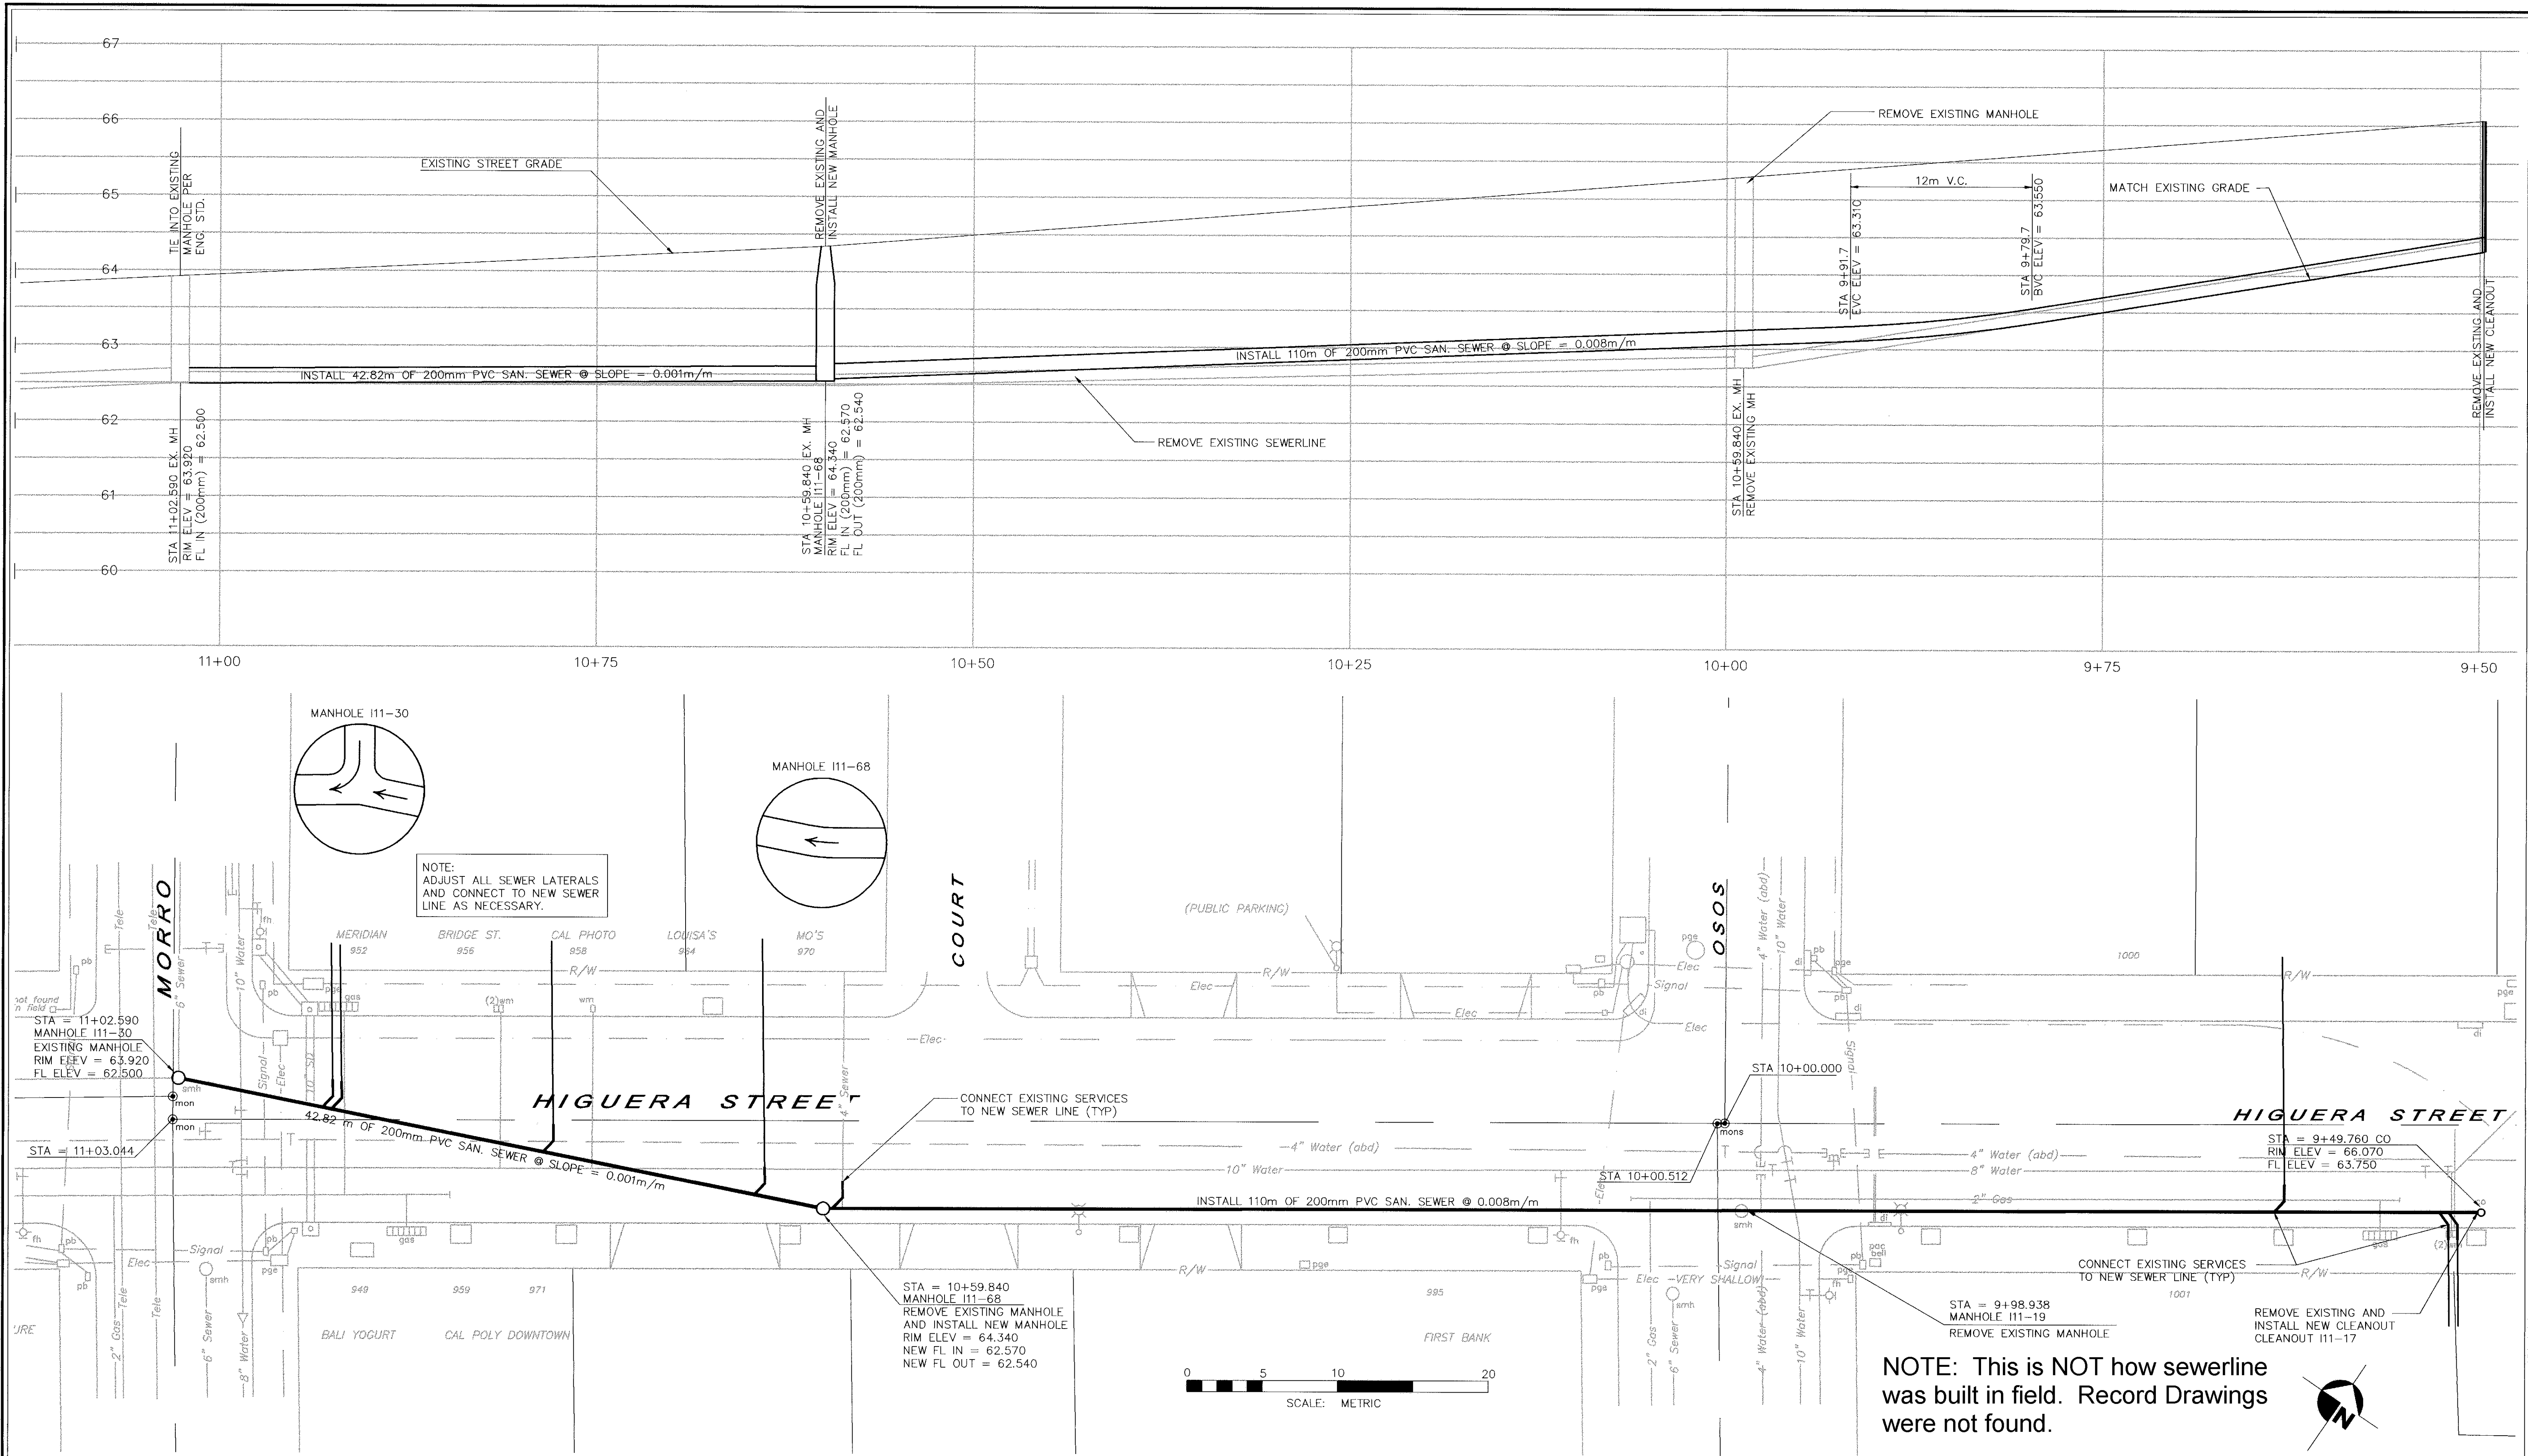

city of san luis obispo


HIGUERA STREET BRIDGE REPLACEMENT

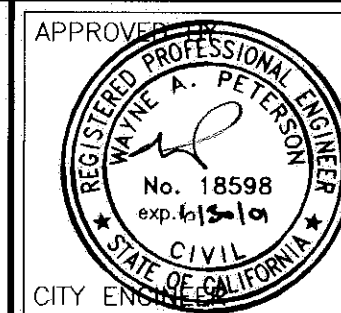


DATE mar 00
SCALE as shown
DESIGNED BY jv
DRAWN BY jv /sr
CHECKED BY bl
APPROVED BY
UTILITIES DEPARTMENT

SEWERMAIN


SPECIFICATION NO.
9367
FILE NO./LOCATION
0060 B
SHEET
7 of 40

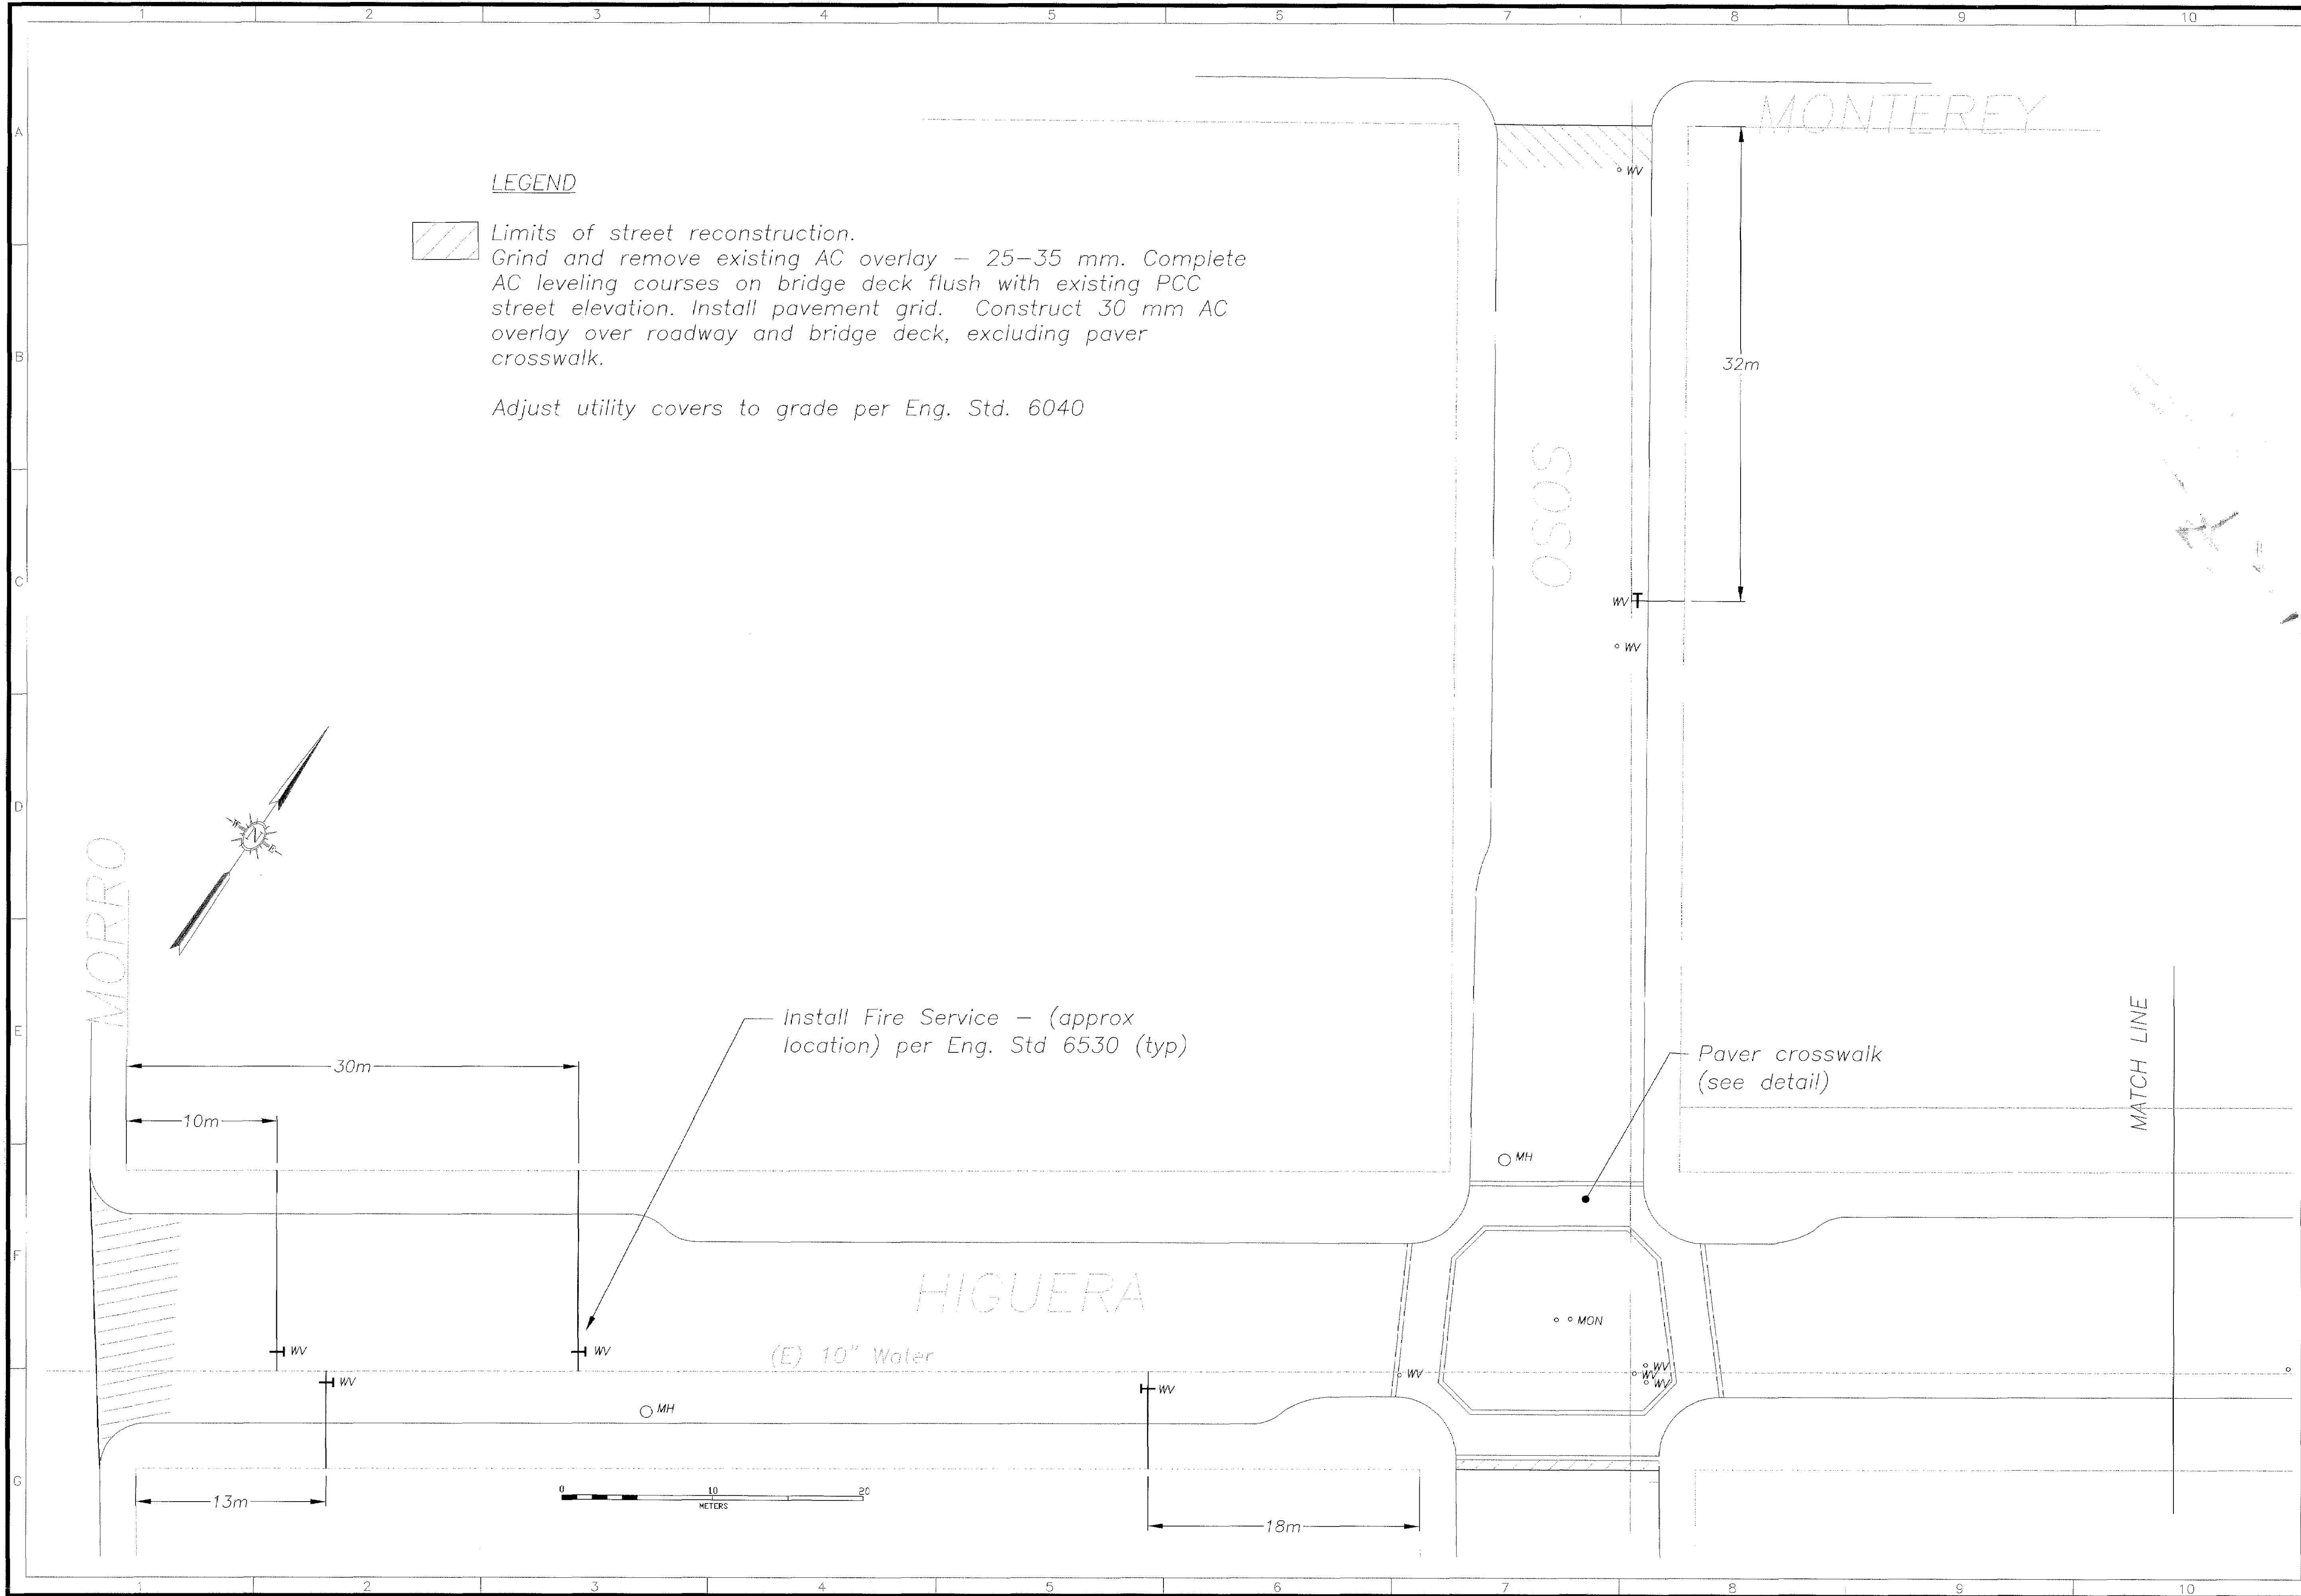

LEGEND

  Limits of street reconstruction.
Grind and remove existing AC overlay — 25–35 mm. Complete AC leveling courses on bridge deck flush with existing PCC street elevation. Install pavement grid. Construct 30 mm AC overlay over roadway and bridge deck, excluding paver crosswalk.

Adjust utility covers to grade per Eng. Std. 6040

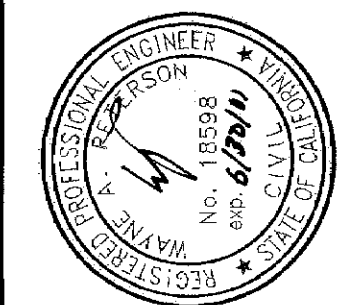

 city of
san luis obispo

REVISIONS:	Record Drawing
DATE:	05/01/20
BY:	AS SHOWN
W:	n/a


PROJECT TITLE:
HIGUERA BRIDGE REHABILITATION PROJECT

SHEET TITLE:
STREET RESURFACING — PLAN 1


DESIGNED BY:
bl
DRAWN BY:
bl
CHECKED BY:
xx
APPROVED BY:
wp

DATE:
mar 00
CITY SPECIFICATION NO.
9367
SHEET NO.
41

8 of 40


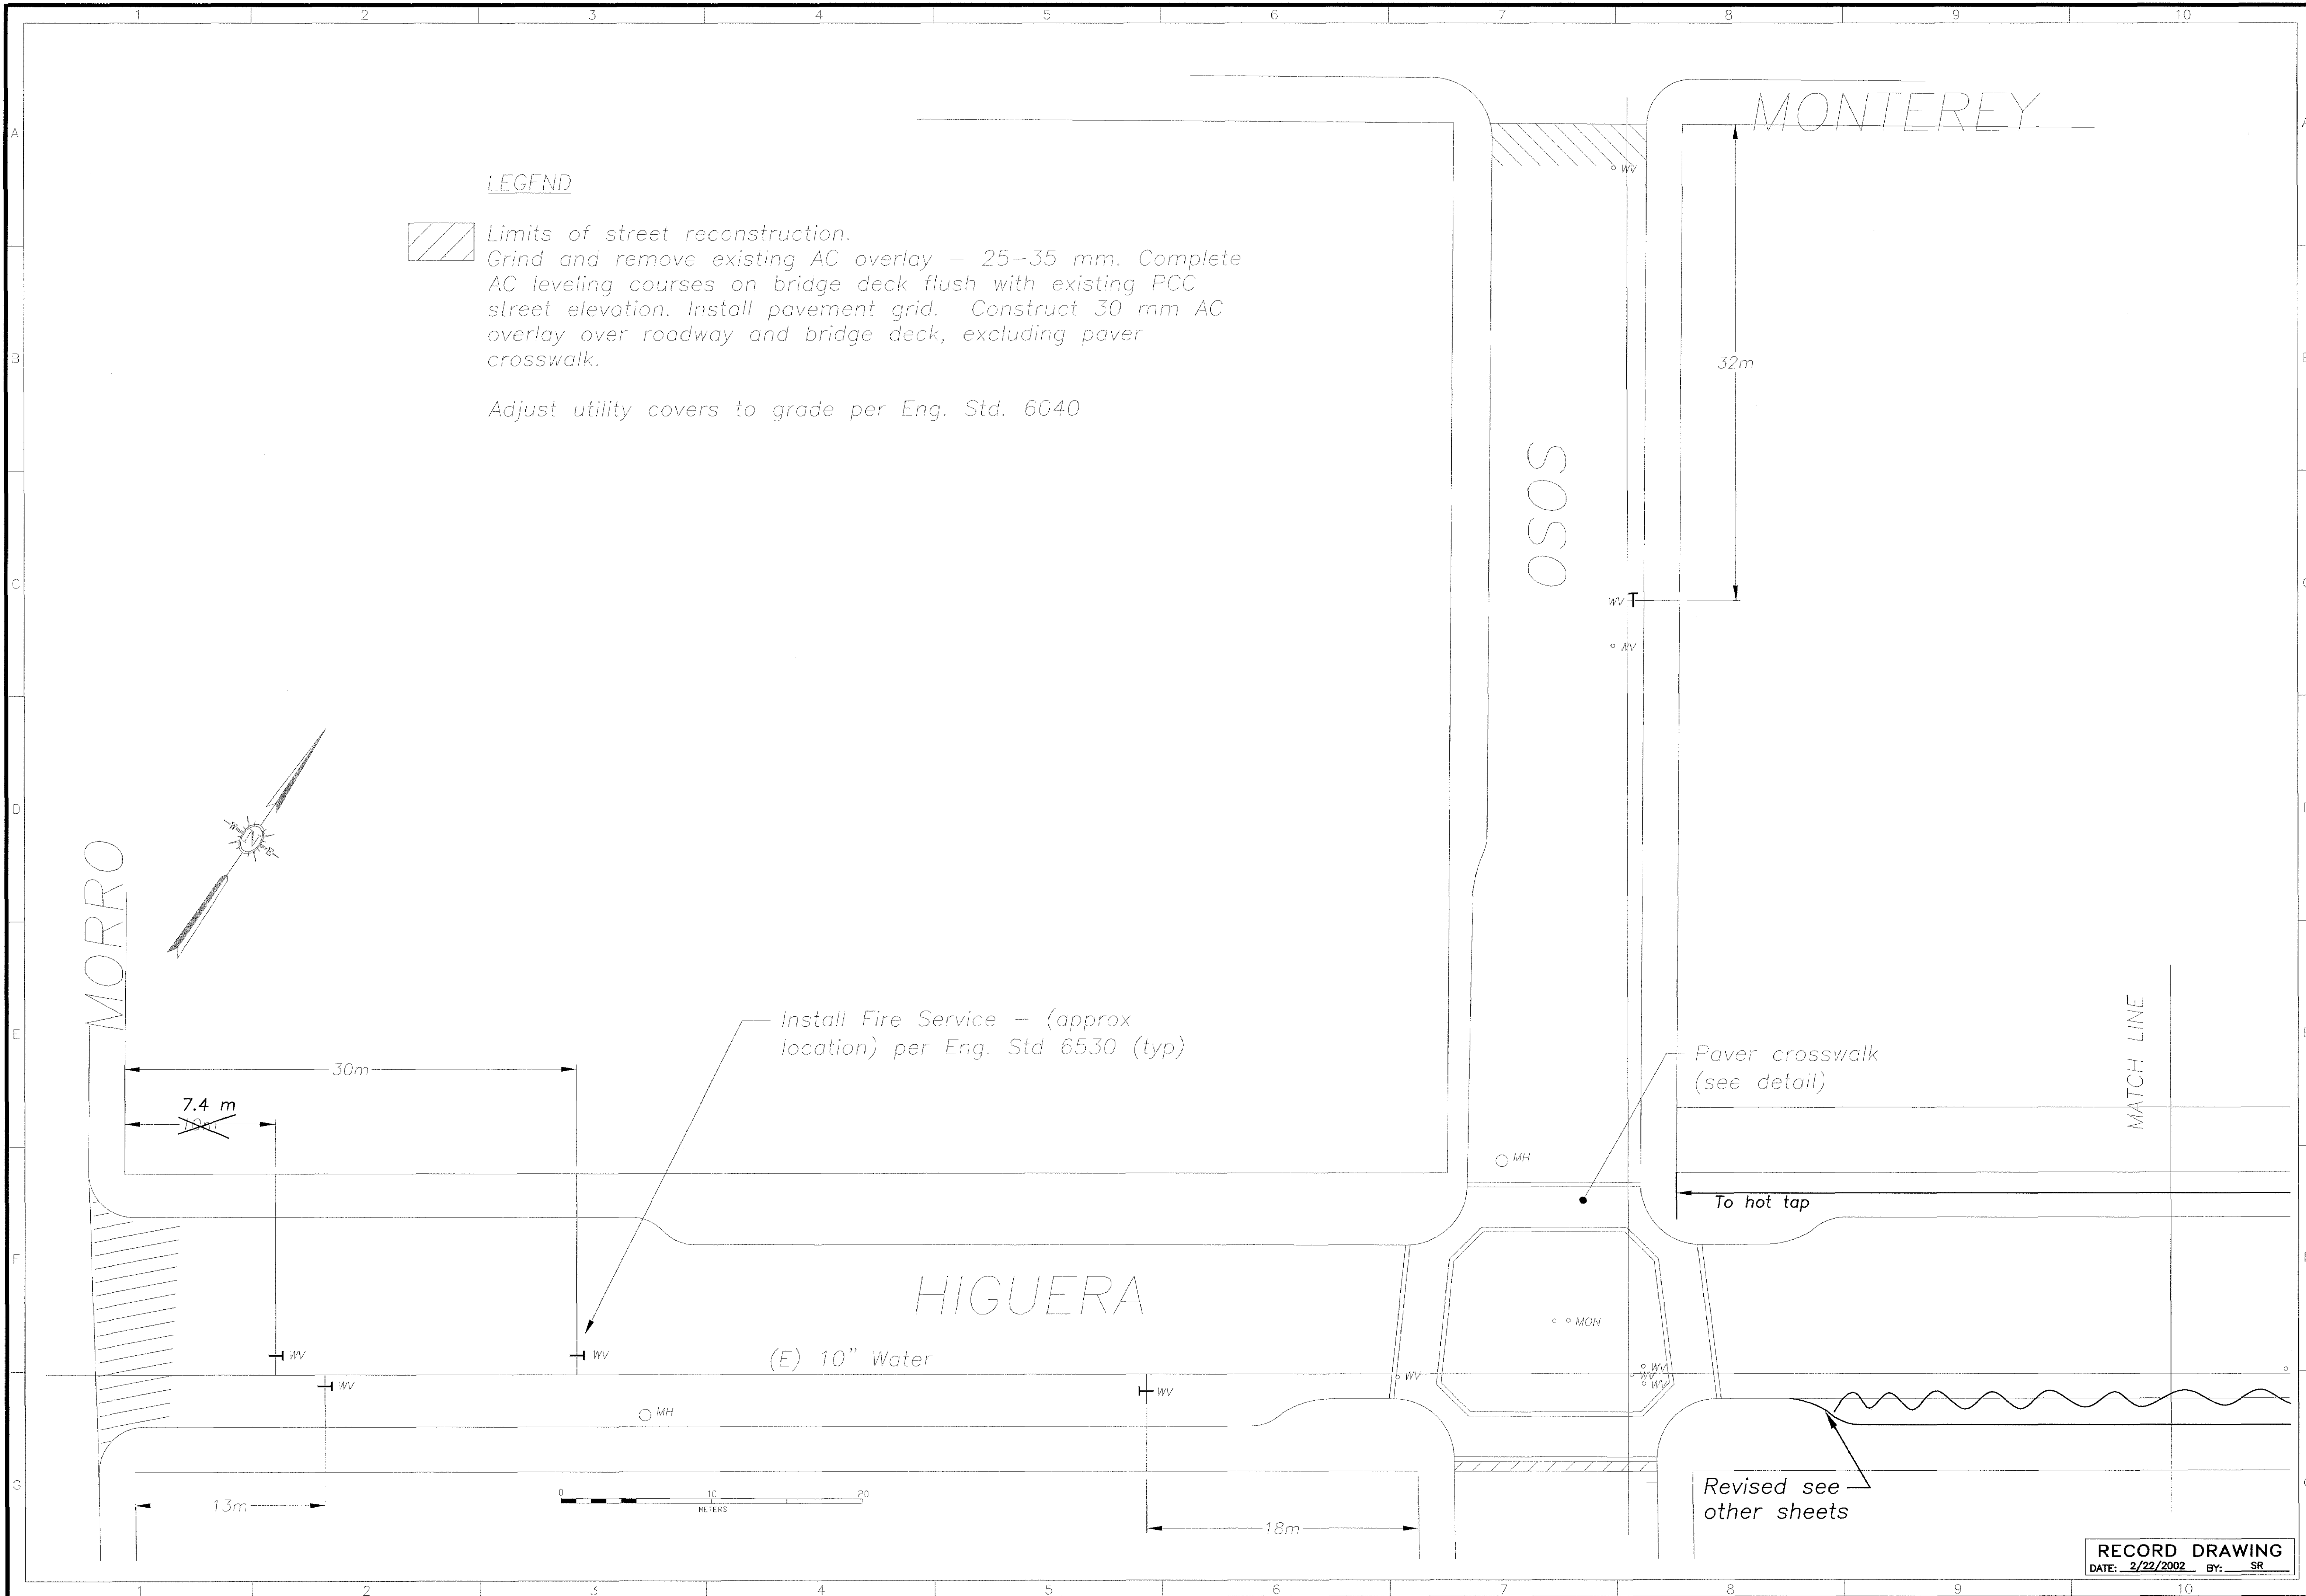


LEGEND

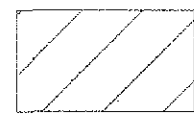

Limits of street reconstruction.
Grind and remove existing AC overlay – 25–35 mm. Complete AC leveling courses on bridge deck flush with existing PCC street elevation. Install pavement grid. Construct 30 mm AC overlay over roadway and bridge deck, excluding paver crosswalk.

Adjust utility covers to grade per Eng. Std. 6040

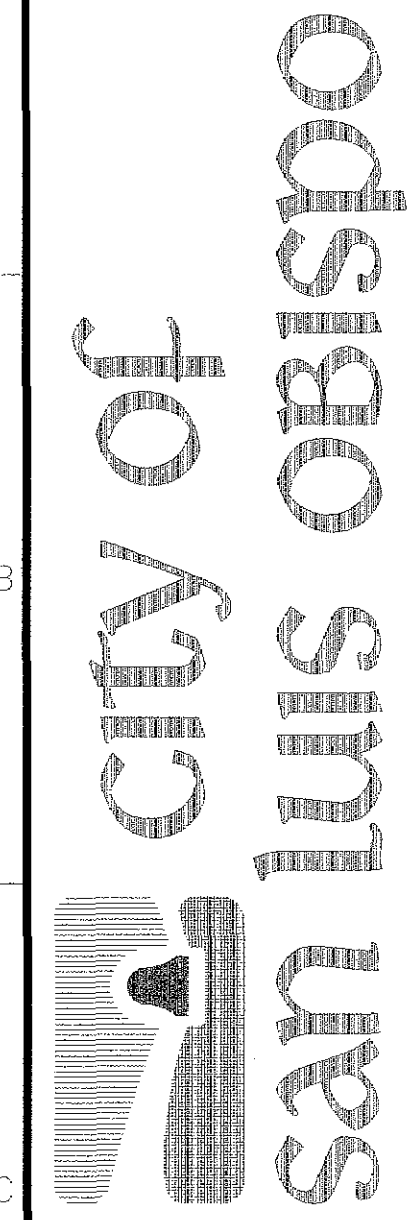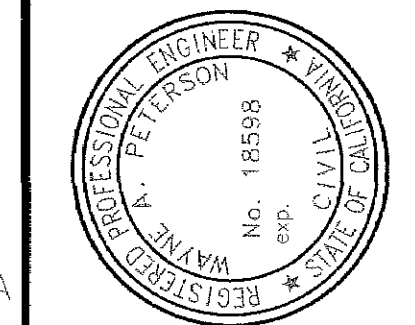




REVISIONS:	
Record Drawing	


PROJECT TITLE: HIGUERA BRIDGE REHABILITATION PROJECT	
SHEET TITLE: STREET RESURFACING – PLAN 1	

DESIGNED BY:	bl
DRAWN BY:	bl
CHECKED BY:	xx
APPROVED BY:	wd
DATE:	mo' 00
CITY SPECIFICATION NO.	9367
SHEET NO.	

RECORD DRAWING
DATE: 2/22/2002 BY: SR


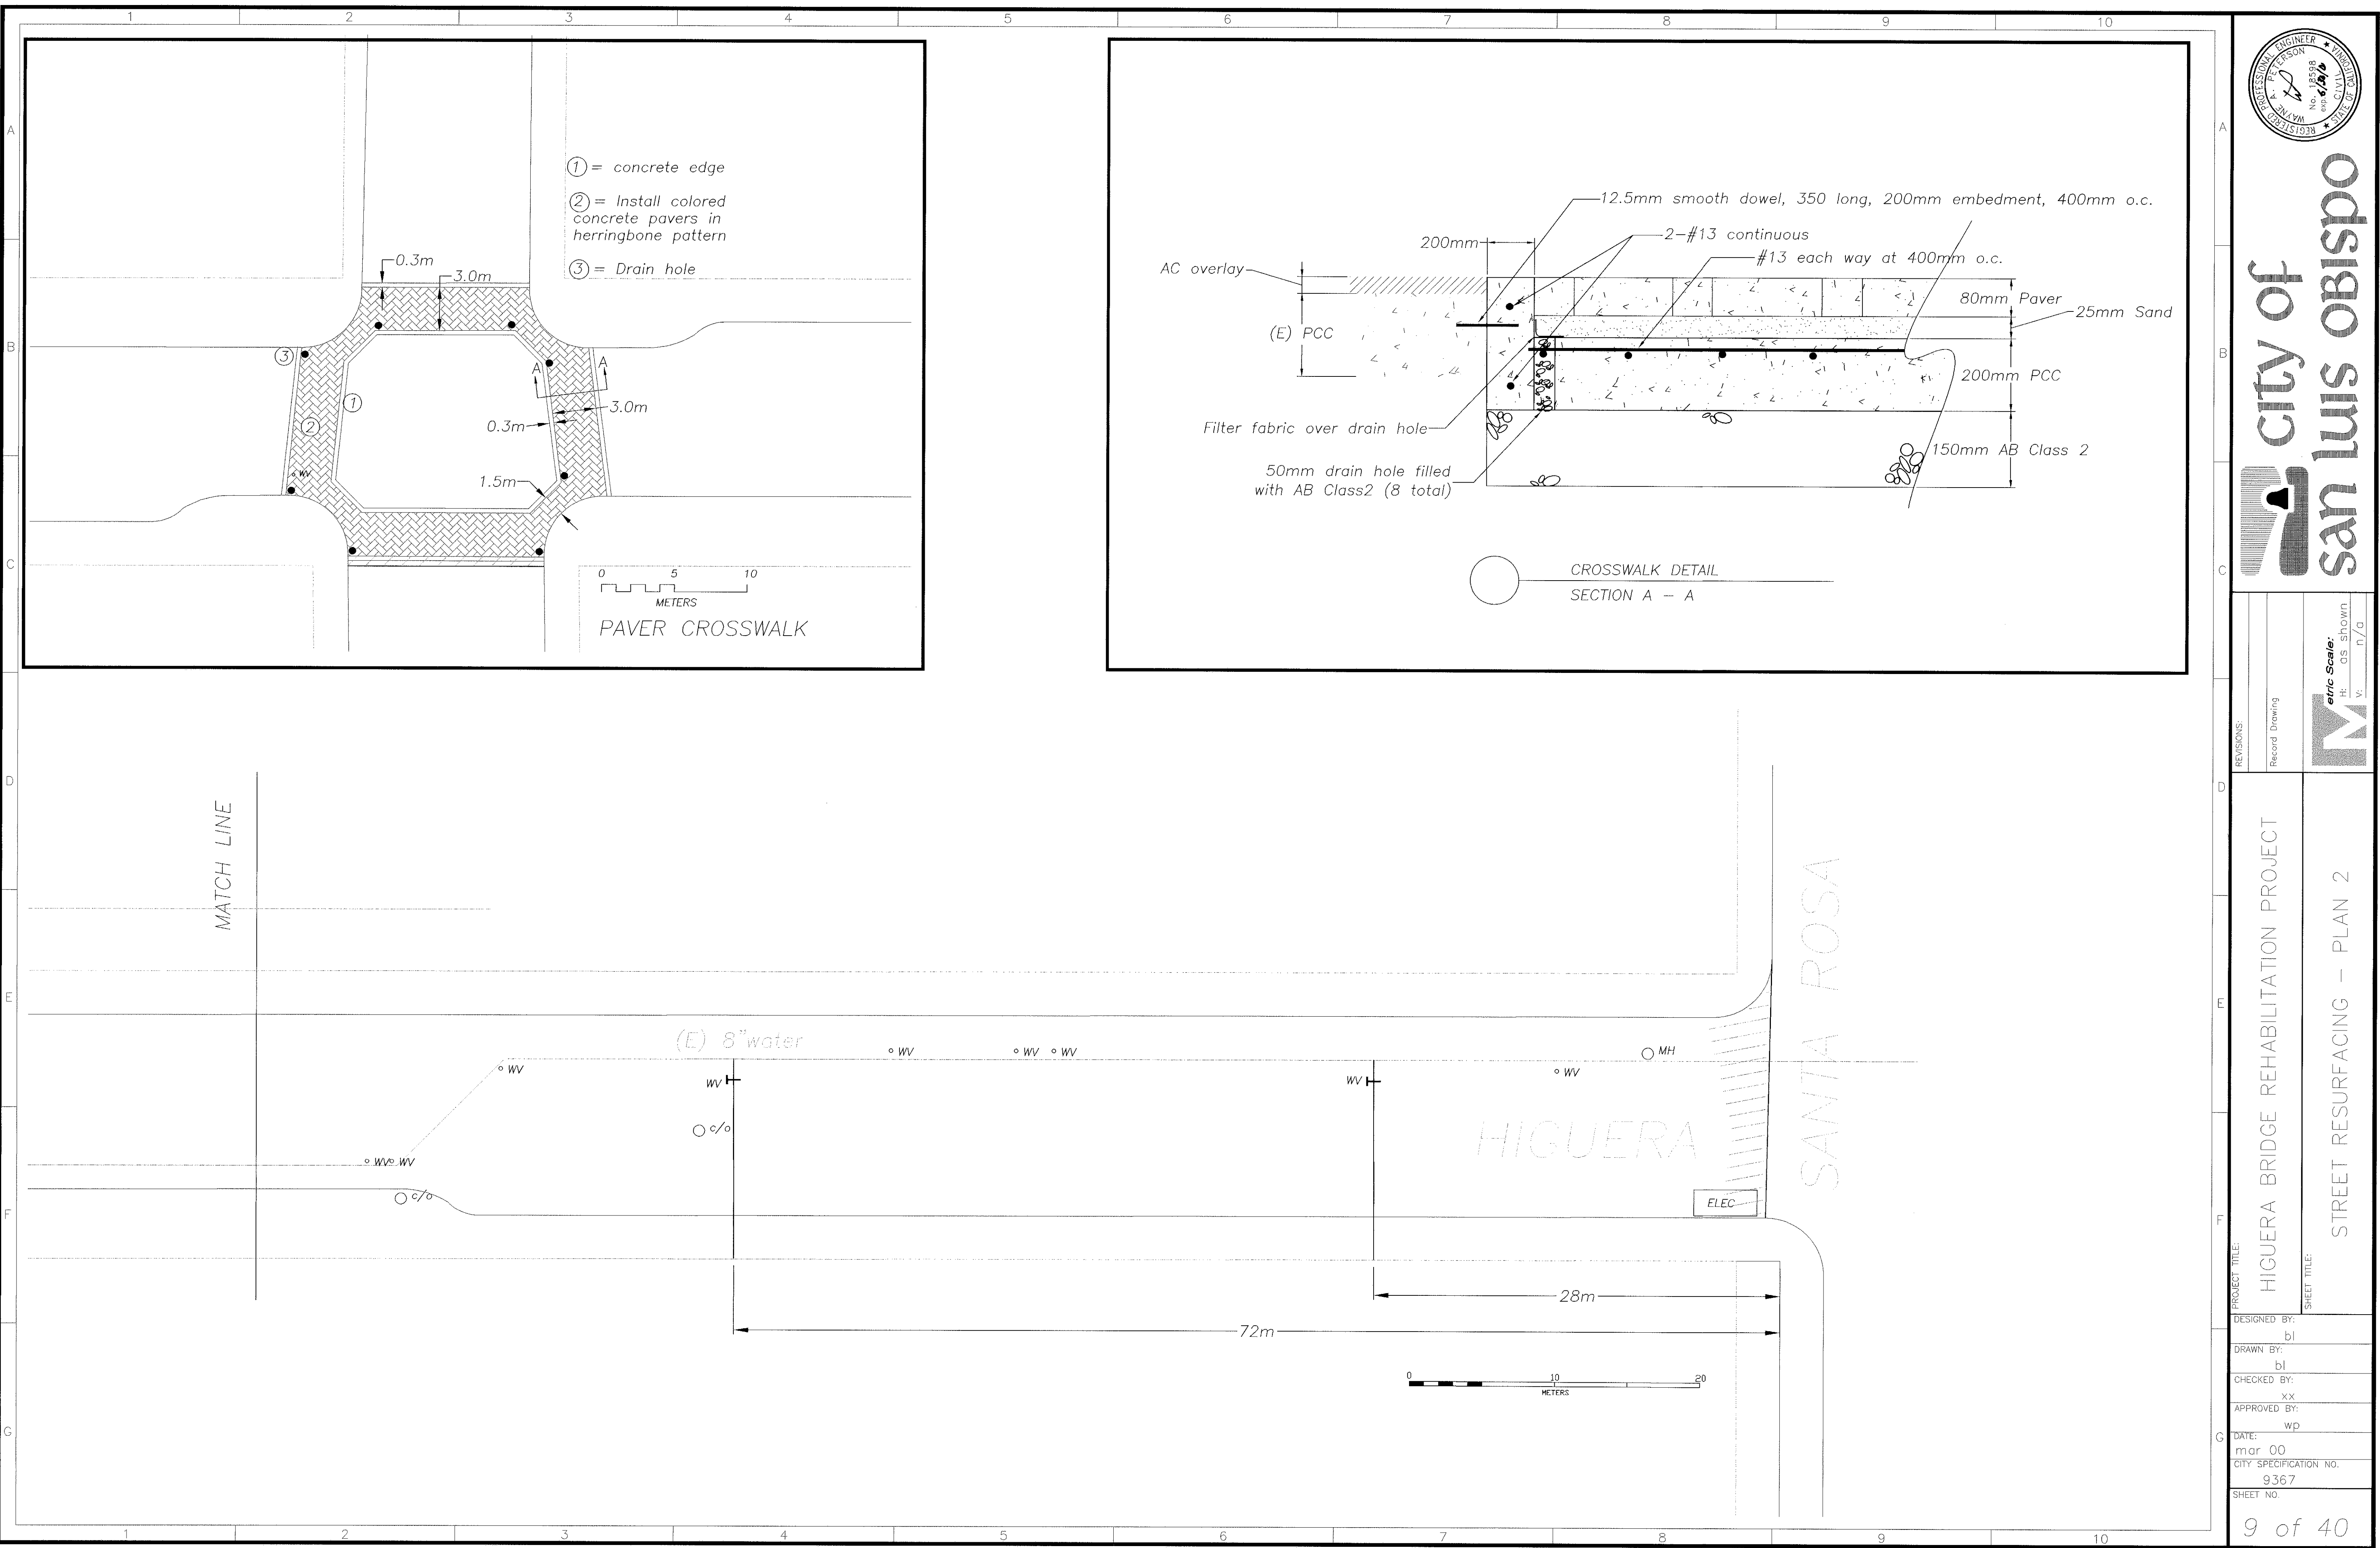


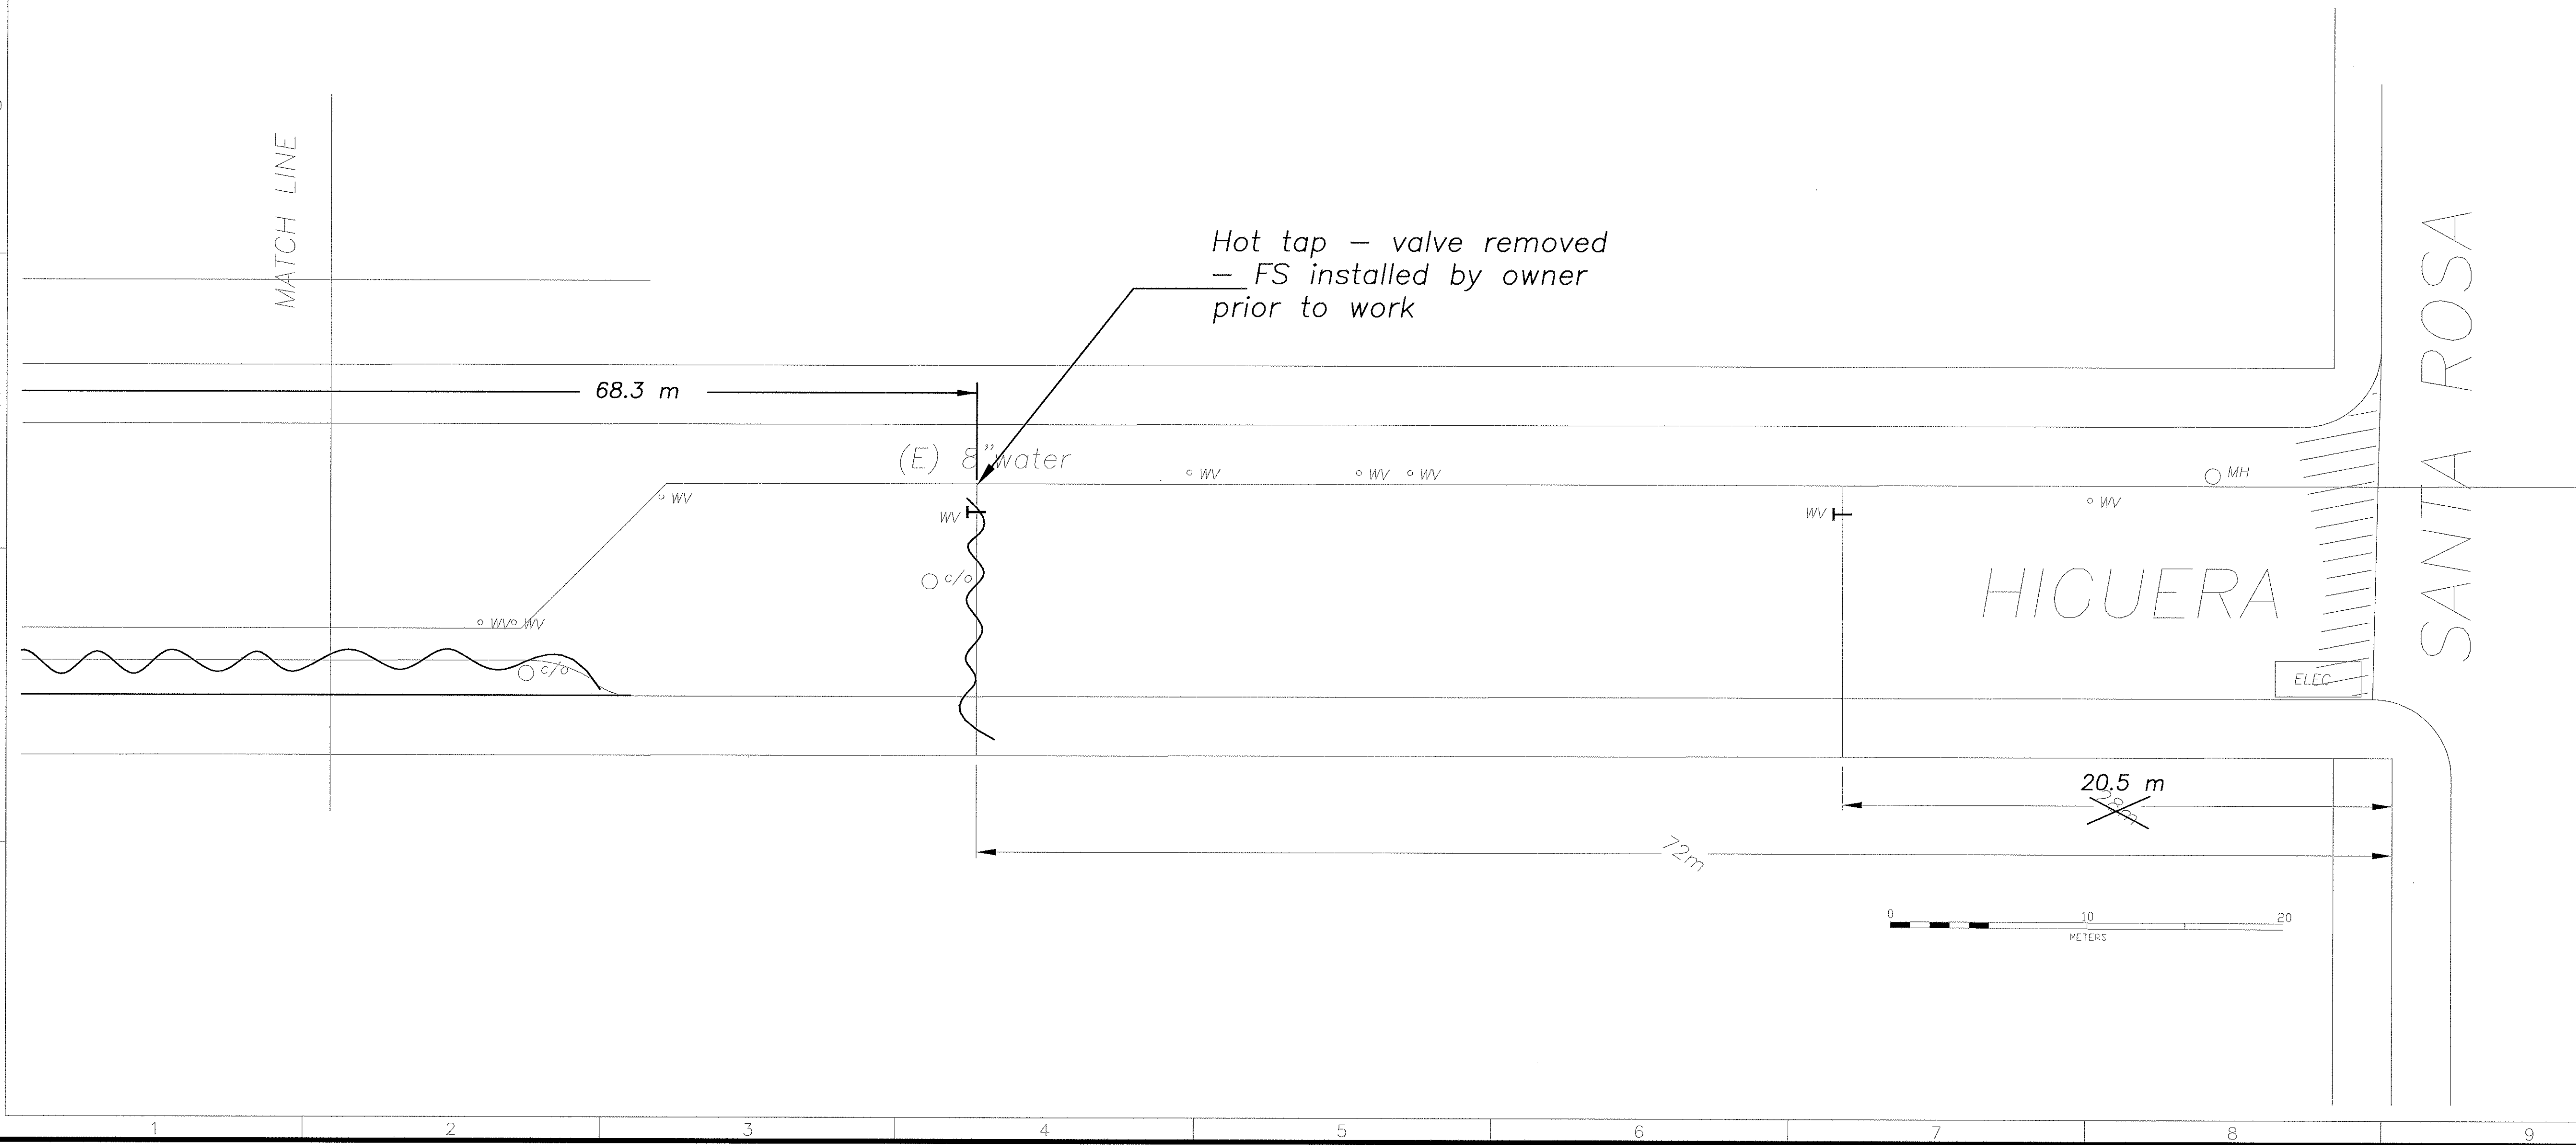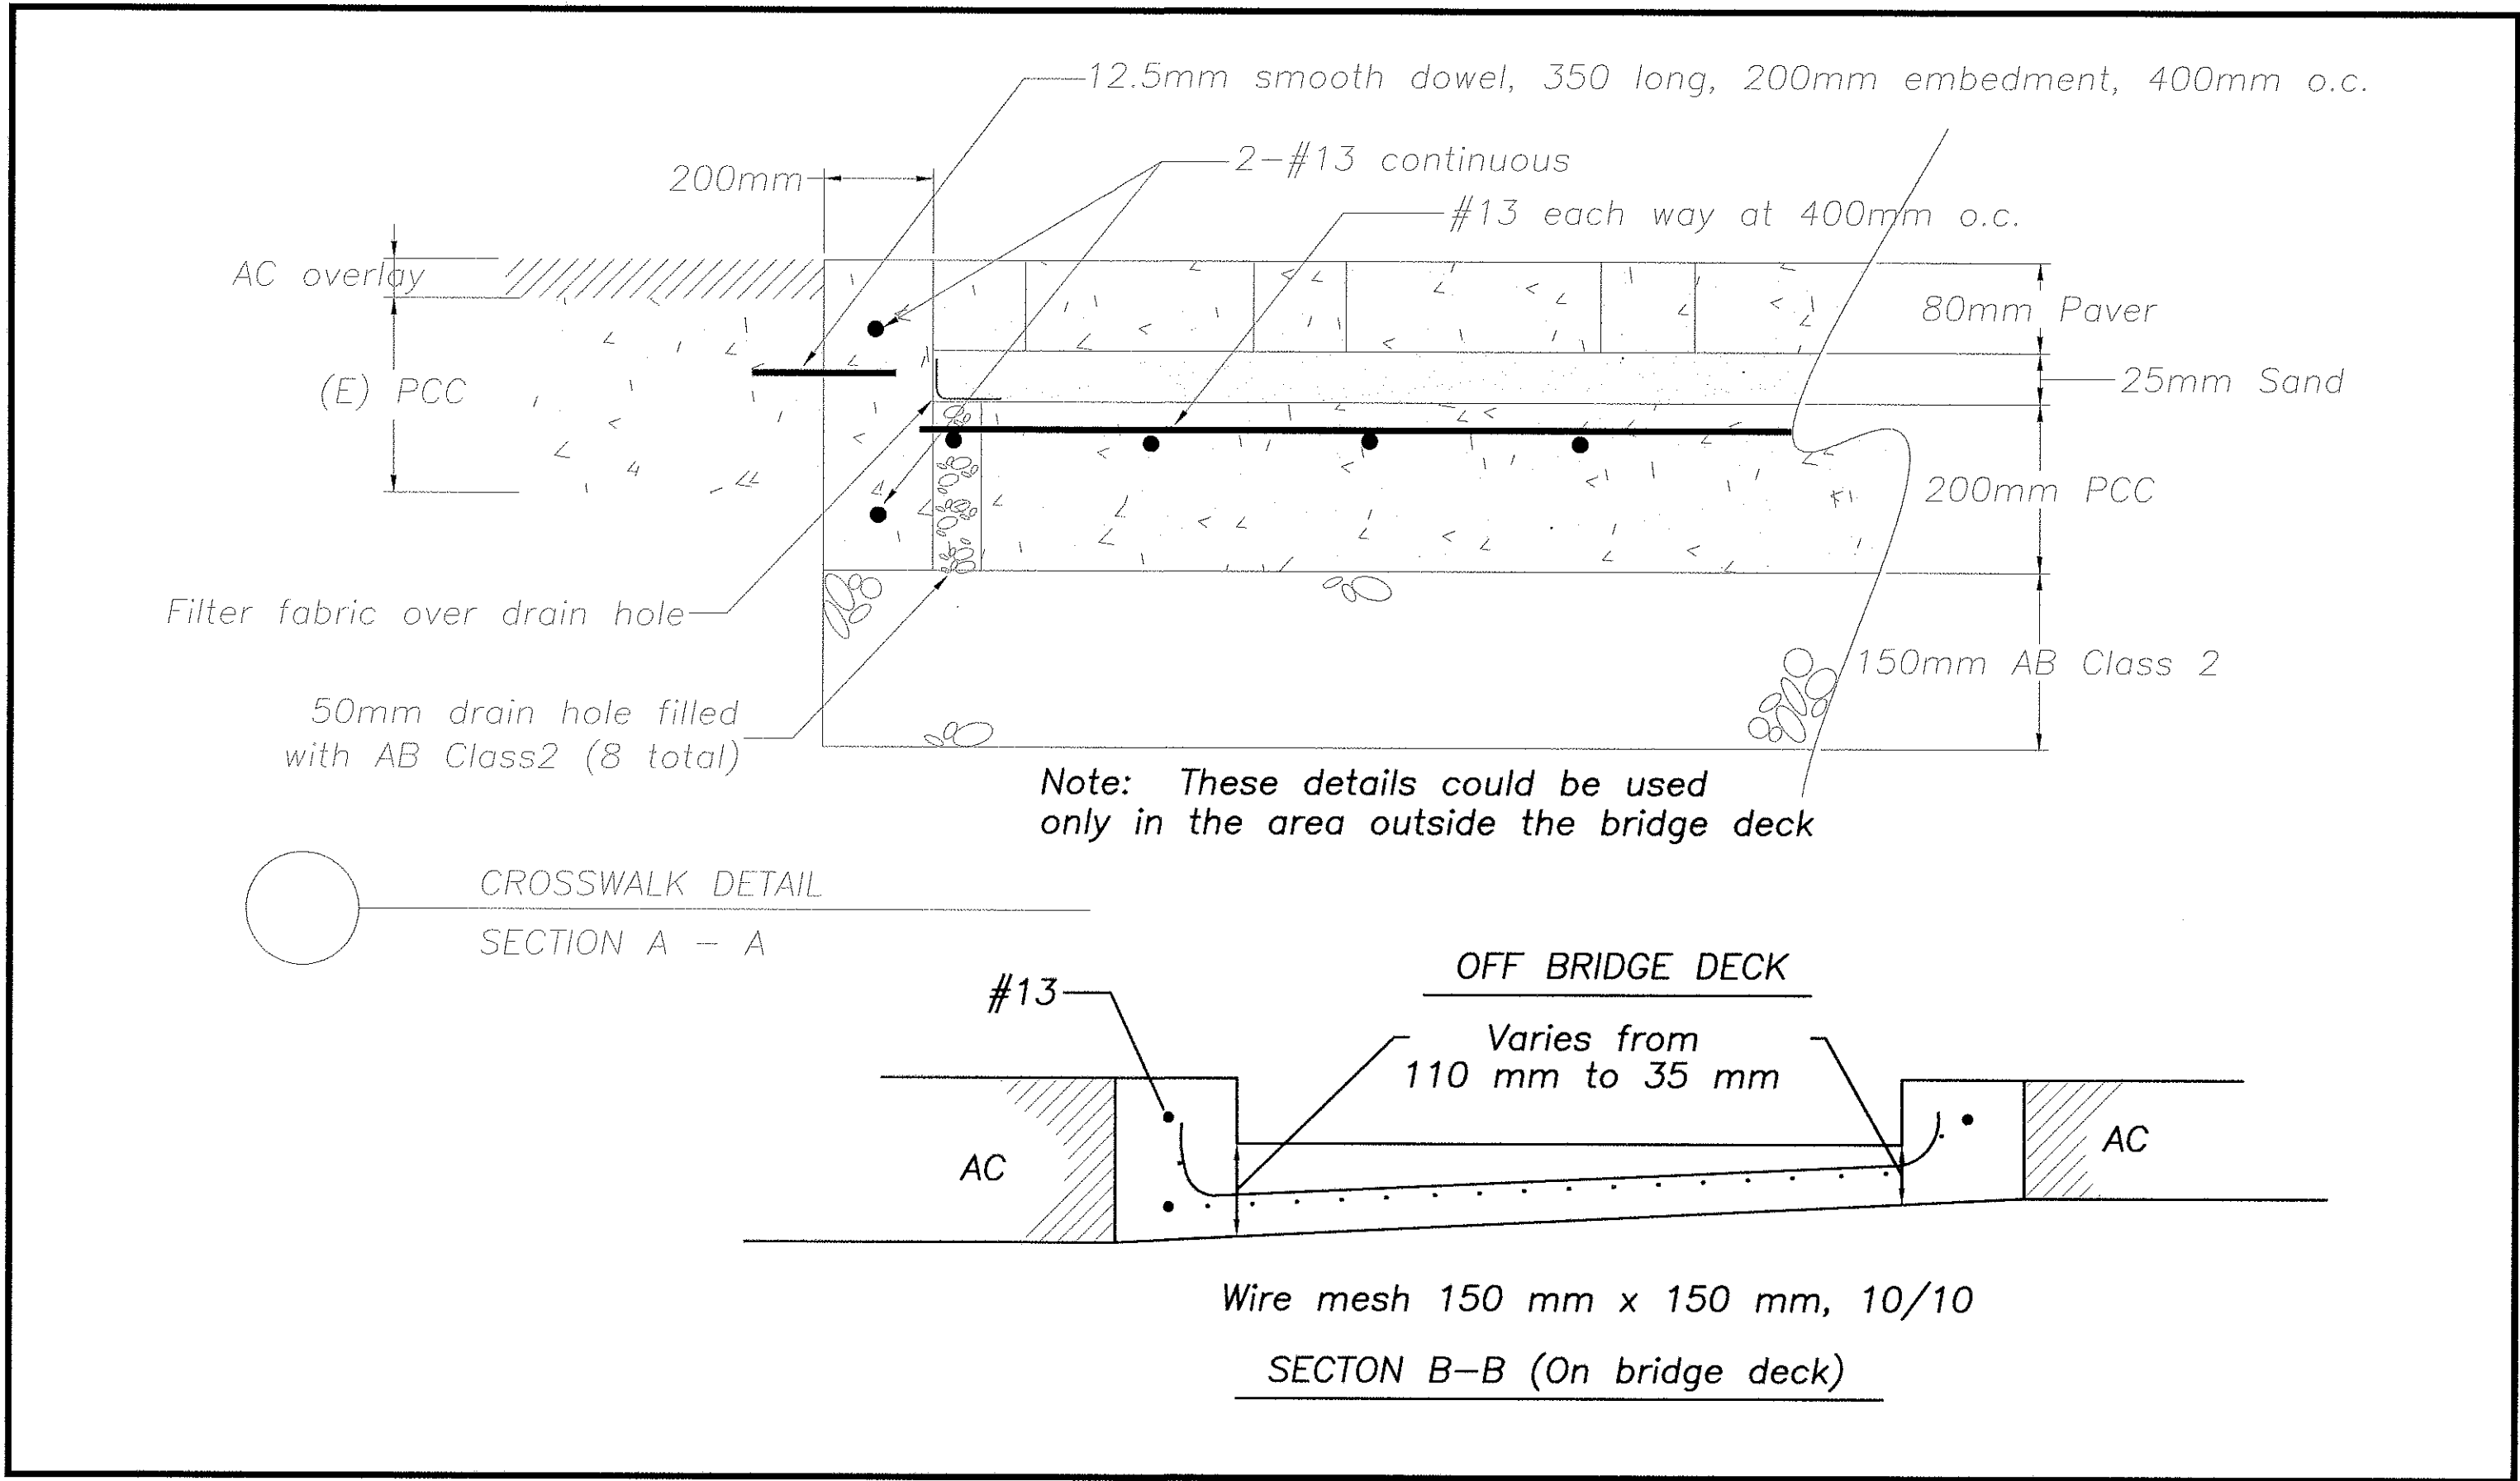

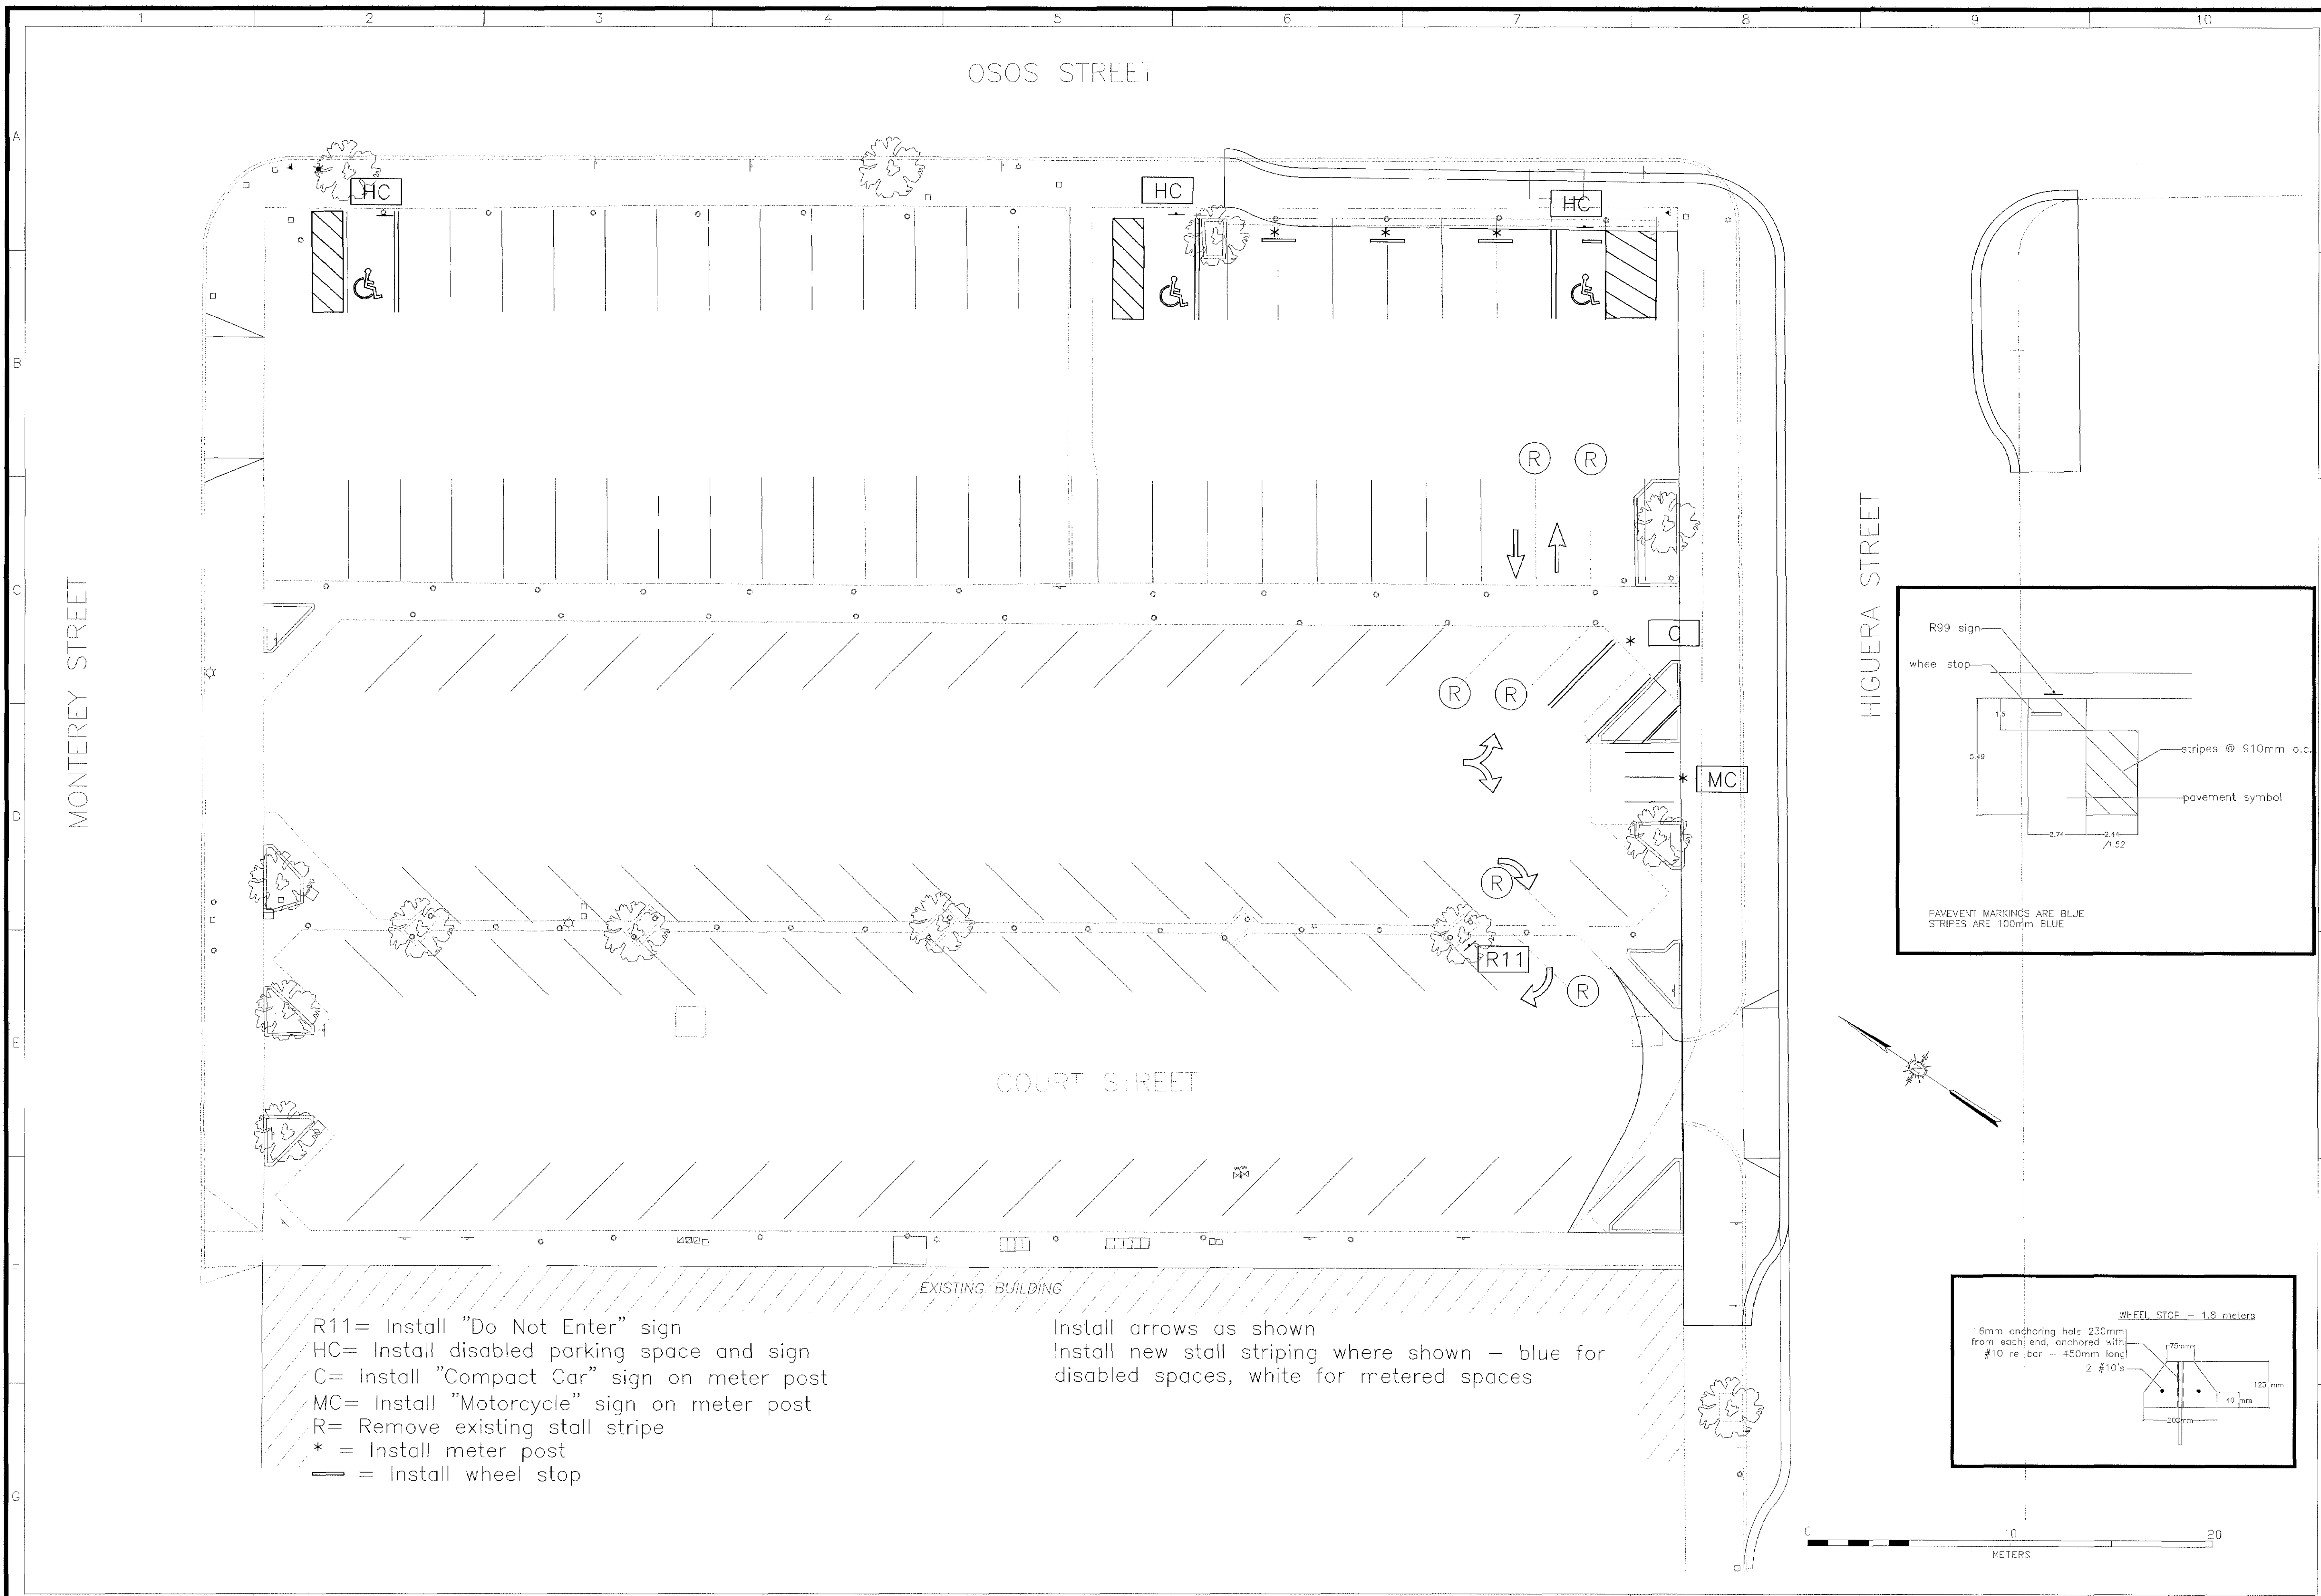

- R11= Install "Do Not Enter" sign
- HC= Install disabled parking space and sign
- C= Install "Compact Car" sign on meter post
- MC= Install "Motorcycle" sign on meter post
- R= Remove existing stall stripe
- * = Install meter post
- = Install wheel stop

Install arrows as shown
 Install new stall striping where shown — blue for disabled spaces, white for metered spaces

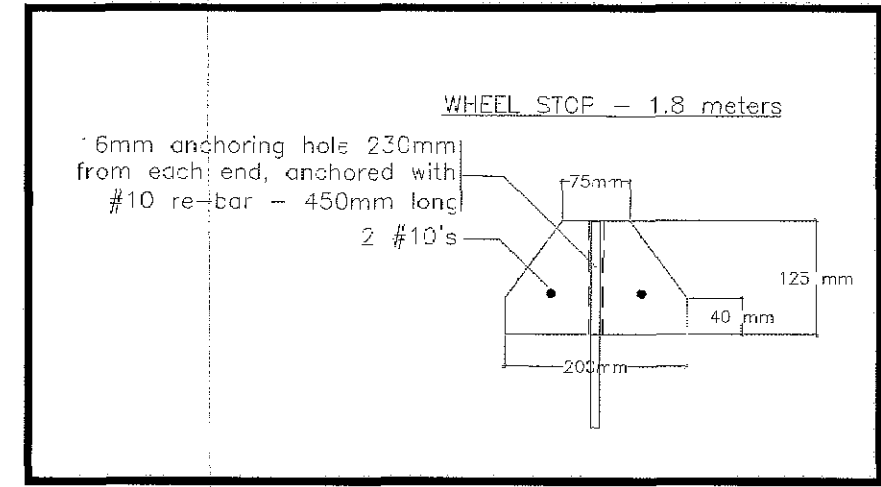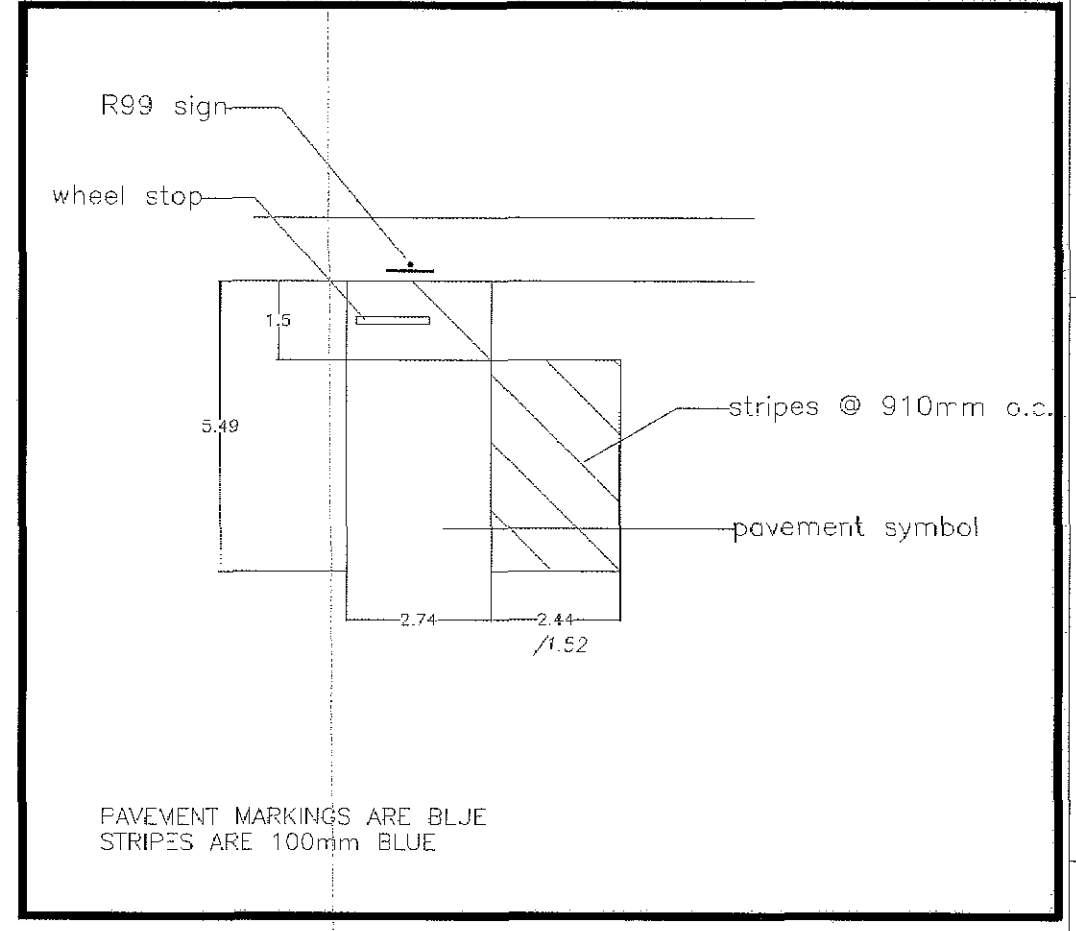

city of
san luis obispo

REVISIONS:

NO.	DESCRIPTION	DATE	BY	APP'D
1	Record Drawing		as shown	n/g

Scale: **1" = 40'**

PROJECT TITLE:
HIGUERA BRIDGE REHABILITATION PROJECT

SHEET TITLE:
LOT 6 STRIPING

DESIGNED BY:
 bl

DRAWN BY:
 bl


CHECKED BY:
 xx

APPROVED BY:
 wp

DATE:
 apr 00



CITY SPECIFICATION NO.
 9367

SHEET NO.
 10 of 40

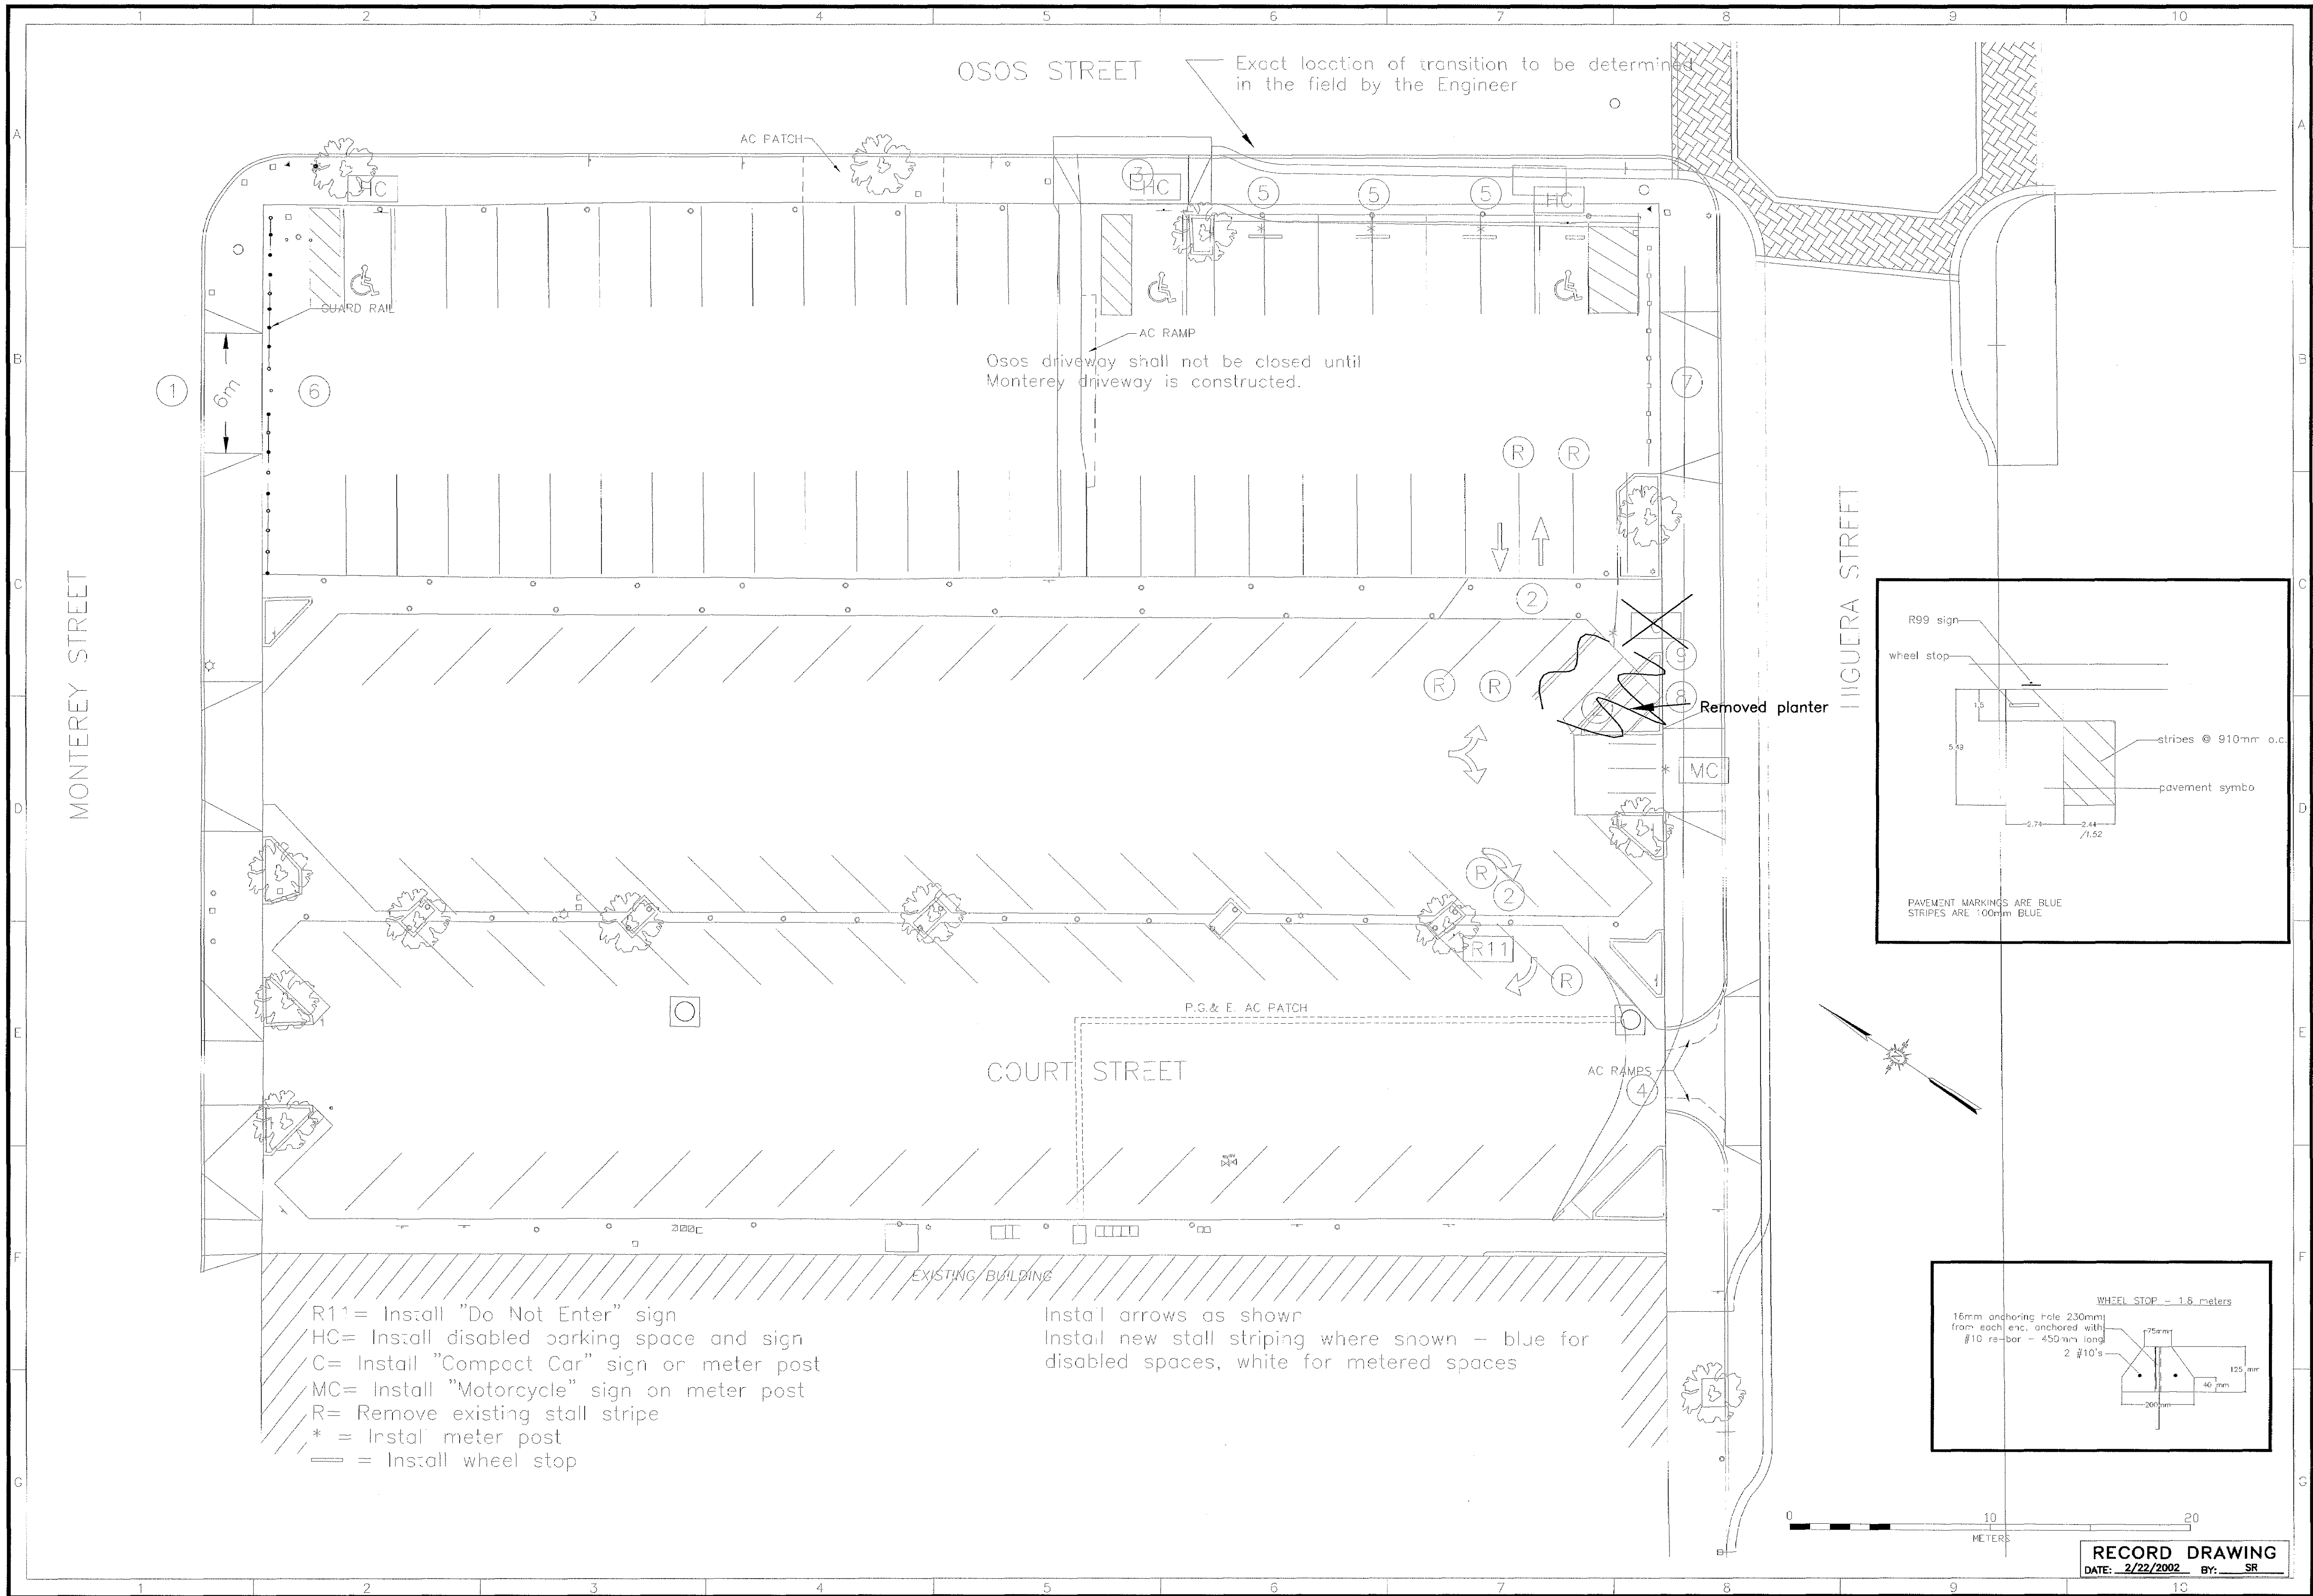

- R11= Install "Do Not Enter" sign
- HC= Install disabled parking space and sign
- C= Install "Compact Car" sign on meter post
- MC= Install "Motorcycle" sign on meter post
- R= Remove existing stall stripe
- * = Install meter post
- = Install wheel stop

Install arrows as shown
Install new stall striping where shown – blue for disabled spaces, white for metered spaces

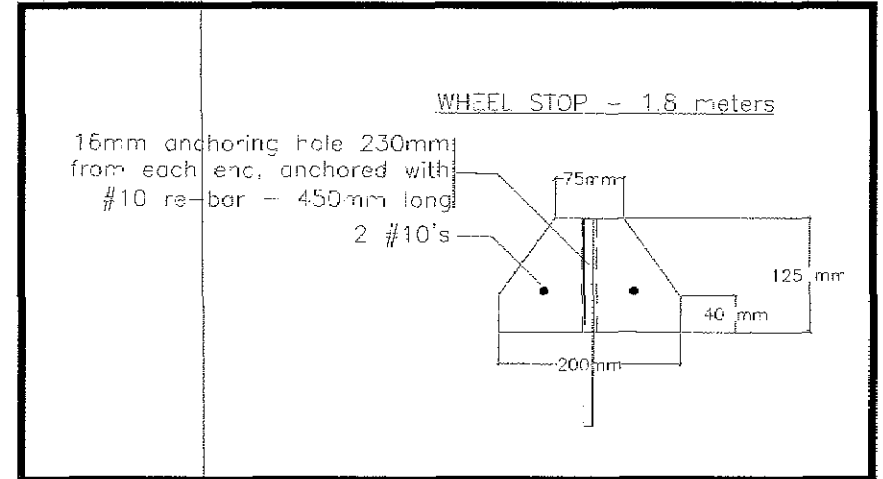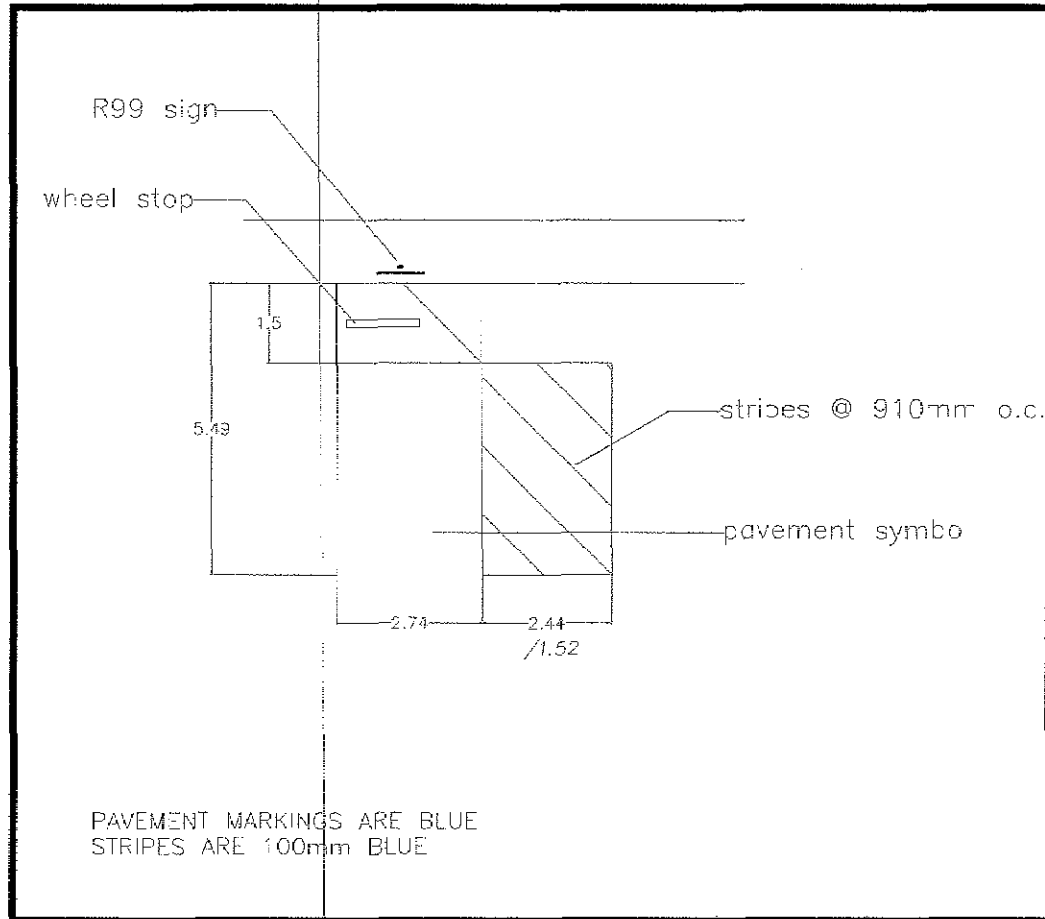

city of

san luis obispo

PROJECT TITLE: HIGUERA BRIDGE REHABILITATION PROJECT

DESIGNED BY: bl

DRAWN BY: bl

CHECKED BY: xx

APPROVED BY: wp

DATE: apr 00

CITY SPECIFICATION NO. 9367

SHEET NO. 10R of 41

LOT 6 STRIPING

PROJECT TITLE: LOT 6 STRIPING

DESIGNED BY: bl

DRAWN BY: bl

 
CHECKED BY: xx

APPROVED BY: wp

DATE: apr 00

CITY SPECIFICATION NO. 9367

SHEET NO. 10R of 41







DIST	COUNTY	ROUTE	KILOMETER POST TOTAL PROJECT	SHEET NO.	TOTAL SHEETS
05	SLO	-	-	12	41
REGISTERED CIVIL ENGINEER 3-28-06 M.K. FRANKLIN No. 15487 Exp. 3/31/01 CIVIL STATE OF CALIFORNIA					
PLANS APPROVAL DATE					
ASSOCIATED TRANSPORTATION ENGINEERS 100 N. Hope Ave, Suite 4 Santa Barbara, CA 93110					

INSTALL DIRECTIONAL SIGN AT LOCATION SHOWN.

SIGN SHALL BE 750mm x 750mm, WITH 50mm WHITE LETTERS ON A BLUE BACKGROUND, AND SHALL BE FULLY REFLECTORIZED WITH HIGH-INTENSITY REFLECTIVE SHEETING.

FOR ADDITIONAL PARKING, USE GARAGES AT MONTEREY & MORRO
← 1 BLOCK
MARSH & MORRO
← 3 BLOCKS

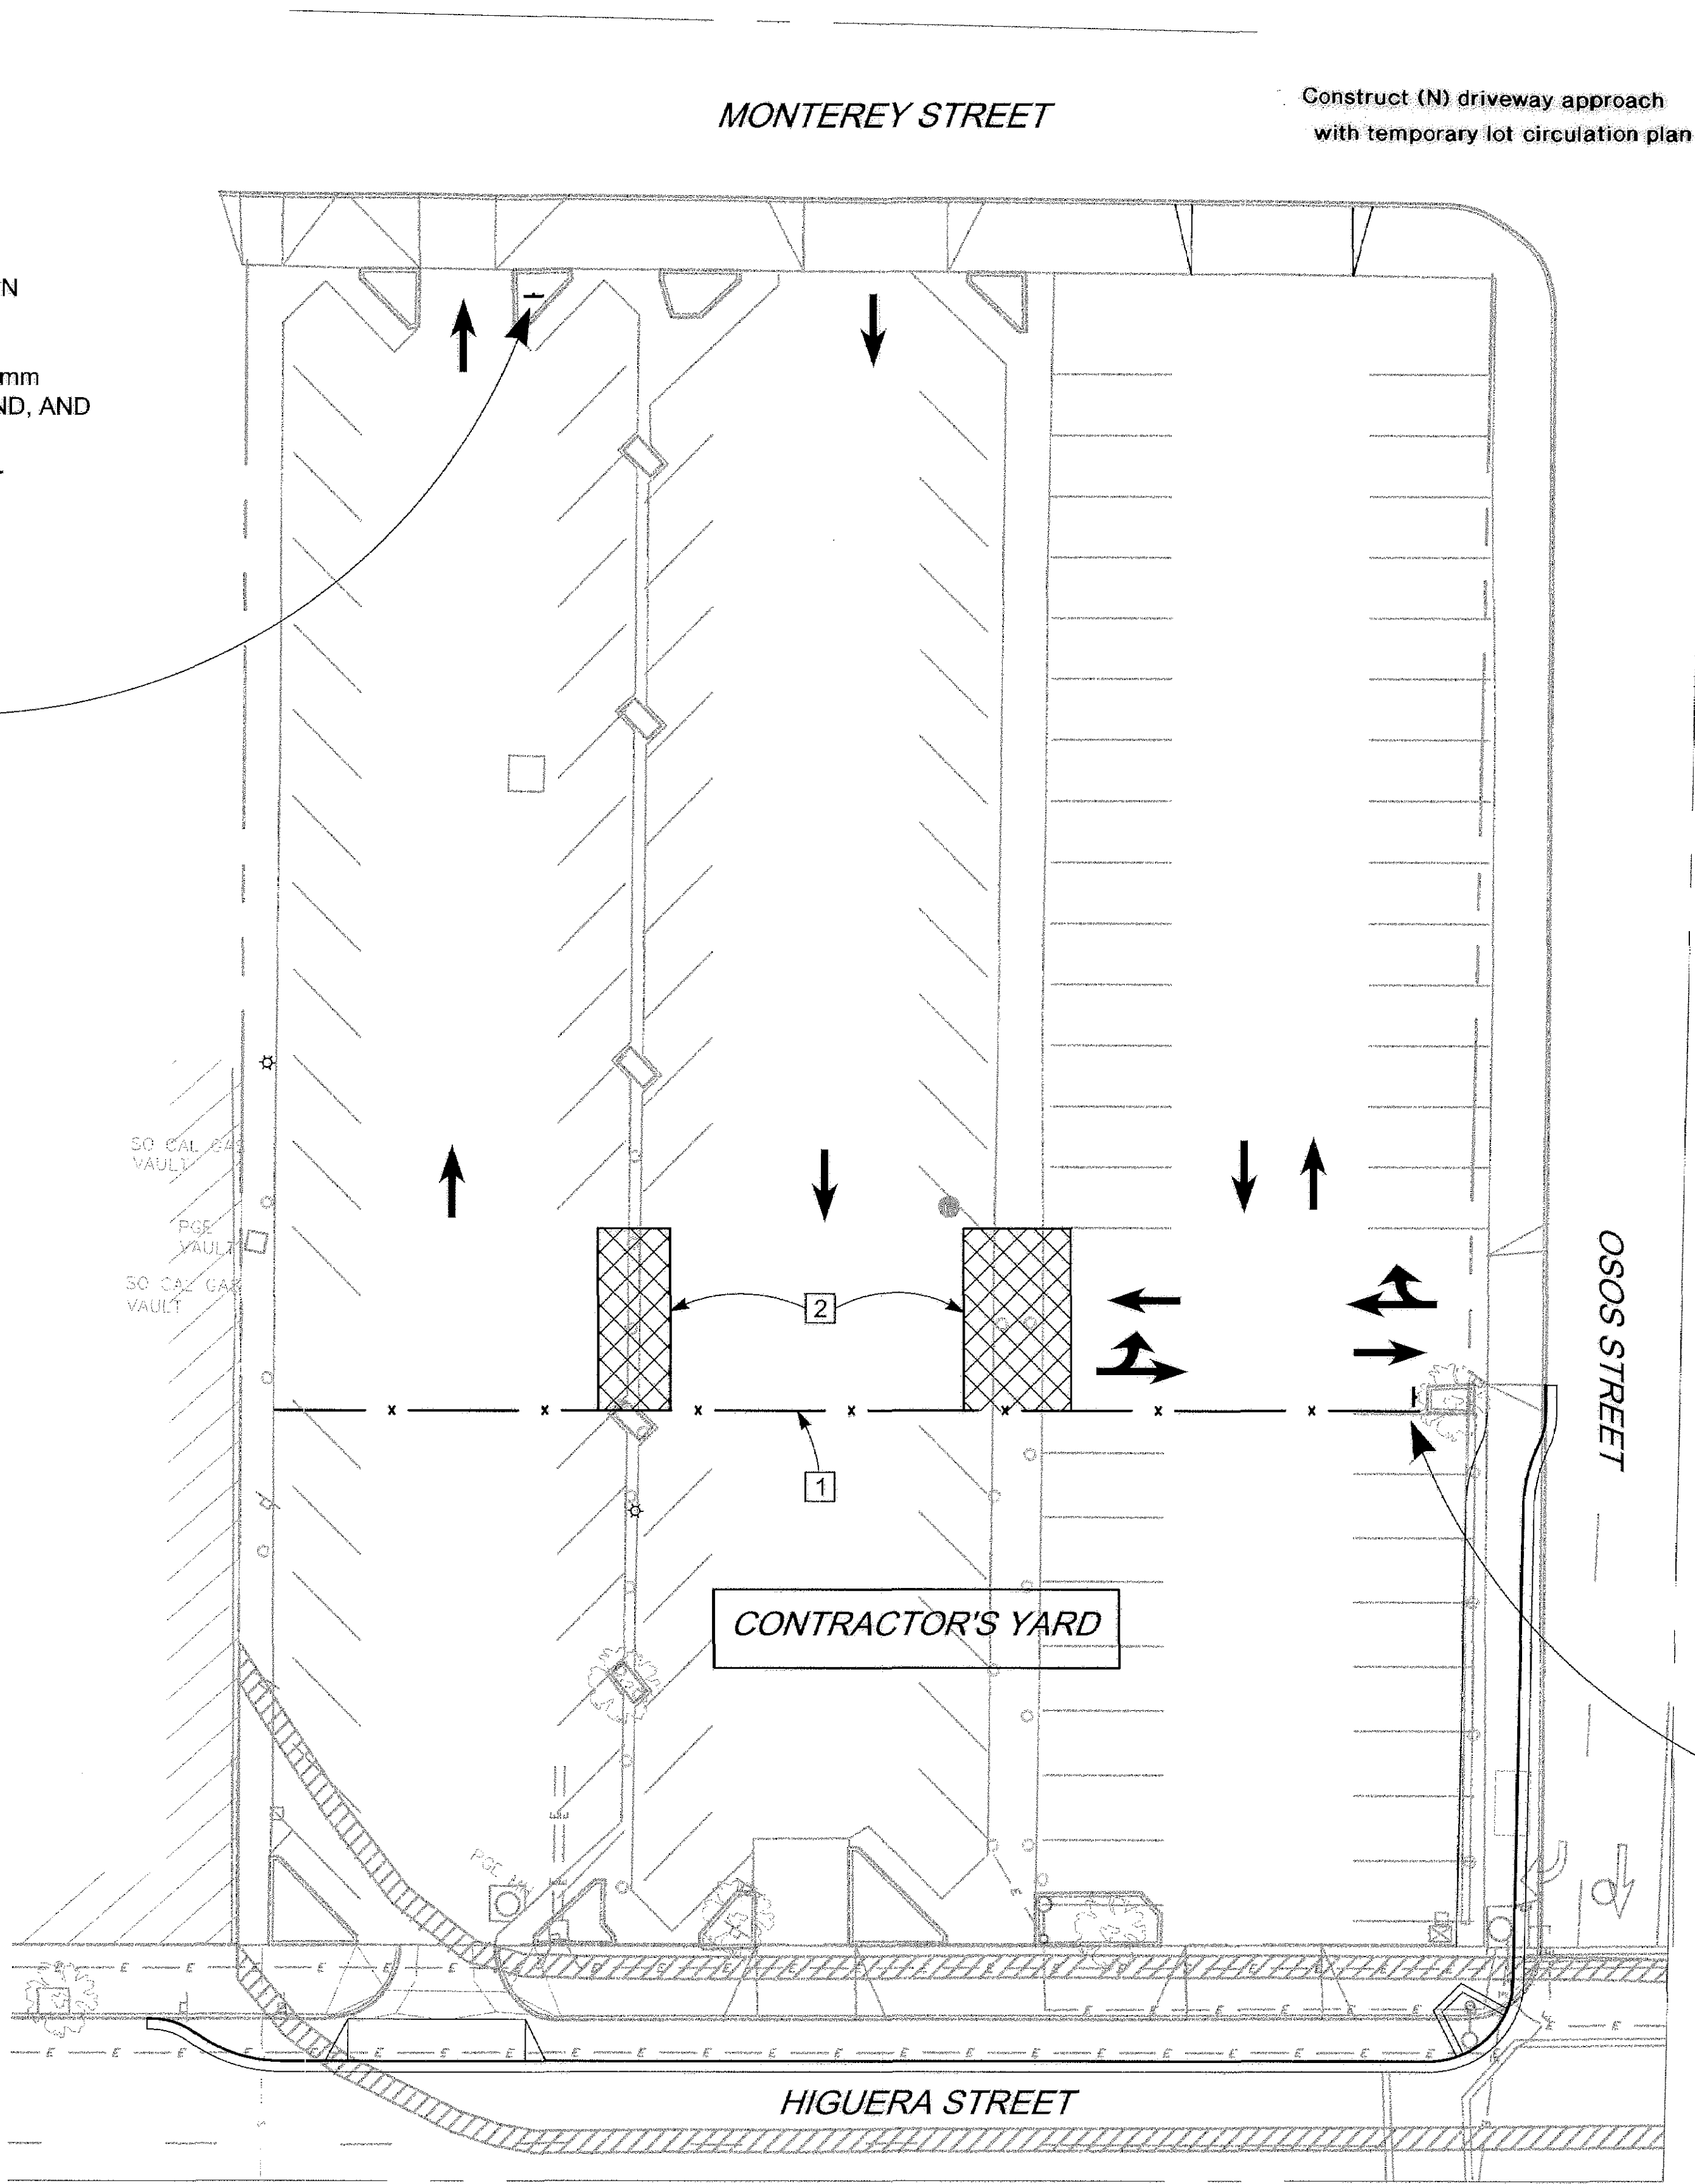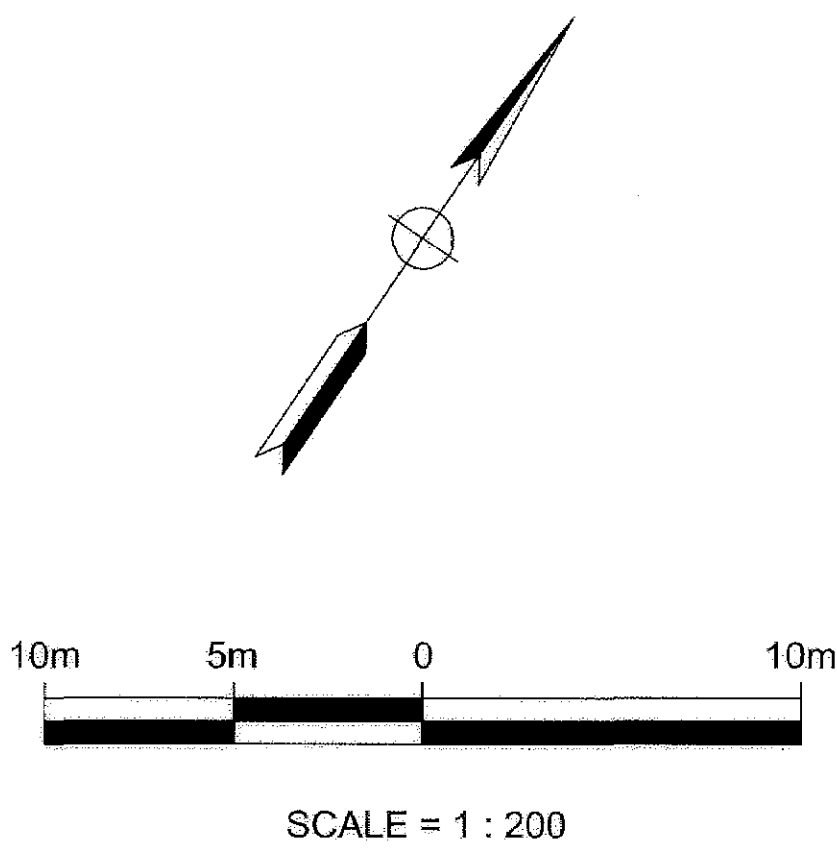

CONSTRUCTION NOTES

- 1 PRIOR TO COMMENCING CONSTRUCTION DEMOLITION, THE CONTRACTOR SHALL ESTABLISH HIS YARD BY FENCING OFF THE PARKING LOT AS SHOWN. ACCESS GATES MAY BE PLACED IN THE FENCING AS REQUIRED.
- 2 TO MAINTAIN PARKING CIRCULATION IN THE REMAINDER OF THE PARKING LOT, THE CONTRACTOR SHALL REMOVE CURBS, PARKING STALL LINES, AND PARKING METERS IN THE SHADED AREAS AND SHALL PROVIDE TEMPORARY PAVING TO PERMIT THE CIRCULATION PATTERN SHOWN. REMOVED METERS SHALL BE DELIVERED TO THE CITY MAINTENANCE YARD AS DIRECTED BY THE ENGINEER.

THE CONTRACTOR SHALL PAINT DIRECTIONAL ARROWS ON THE PARKING LOT PAVEMENT AS SHOWN TO DIRECT TRAFFIC WITHIN THE RECONFIGURED PARKING AREA.

UPON COMPLETION OF CONSTRUCTION, THE PARKING LOT SHALL BE RESTORED AS DIRECTED BY THE ENGINEER.


FOR PERMANENT PARKING LOT IMPROVEMENT DETAILS SEE "LOT 6 STRIPING" AND "LOT 6 EARTHWORK" PLAN SHEETS.

AT NO TIME SHALL THE CONTRACTOR PARK ANY VEHICLE WITHIN THE PUBLIC PARKING AREA OF THE LOT, OTHER THAN TO LOCK/UNLOCK ACCESS GATES.

INSTALL DIRECTIONAL SIGN AT LOCATION SHOWN.

SIGN SHALL BE 750mm x 750mm, WITH 50mm WHITE LETTERS ON A BLUE BACKGROUND, AND SHALL BE FULLY REFLECTORIZED WITH HIGH-INTENSITY REFLECTIVE SHEETING.

FOR ADDITIONAL PARKING, USE GARAGES AT MONTEREY & MORRO
← 2 BLOCKS
MARSH & MORRO
3 BLOCKS →

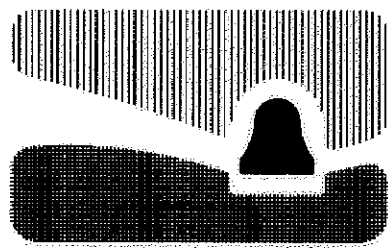

city of san luis obispo

HIGUERA STREET BRIDGE REPLACEMENT

APPROVED BY

CITY ENGINEER

DATE 3/2000

SCALE 1:200

DESIGNED BY MKF

DRAWN BY MCD

CHECKED BY MKF

APPROVED BY

UTILITIES DEPARTMENT

PARKING LOT CIRCULATION PLAN
HIGUERA STREET / OSOS STREET

SPECIFICATION NO.

9367

FILE NO./LOCATION

0060 B

SHEET

12 OF 41



DIST	COUNTY	ROUTE	KILOMETER POST TOTAL PROJECT	SHEET NO.	TOTAL SHEETS
05	SLO	-	-	12	38
REGISTERED CIVIL ENGINEER					
PLANS APPROVAL DATE					
ASSOCIATED TRANSPORTATION ENGINEERS					
100 N. Hope Ave, Suite 4					
Santa Barbara, CA 93110					

REGISTERED PROFESSIONAL ENGINEER

M.K. FRANKLIN

No. 15487

Exp. 3/31/01

CIVIL

STATE OF CALIFORNIA

CONSTRUCTION NOTES

- 1 PRIOR TO COMMENCING CONSTRUCTION DEMOLITION, THE CONTRACTOR SHALL ESTABLISH HIS YARD BY FENCING OFF THE PARKING LOT AS SHOWN. ACCESS GATES MAY BE PLACED IN THE FENCING AS REQUIRED.
- 2 TO MAINTAIN PARKING CIRCULATION IN THE REMAINDER OF THE PARKING LOT, THE CONTRACTOR SHALL REMOVE CURBS, PARKING STALL LINES, AND PARKING METERS IN THE SHADED AREAS AND SHALL PROVIDE TEMPORARY PAVING TO PERMIT THE CIRCULATION PATTERN SHOWN. REMOVED METERS SHALL BE DELIVERED TO THE CITY MAINTENANCE YARD AS DIRECTED BY THE ENGINEER.

THE CONTRACTOR SHALL PAINT DIRECTIONAL ARROWS ON THE PARKING LOT PAVEMENT AS SHOWN TO DIRECT TRAFFIC WITHIN THE RECONFIGURED PARKING AREA.

UPON COMPLETION OF CONSTRUCTION, THE PARKING LOT SHALL BE RESTORED AS DIRECTED BY THE ENGINEER.

 

FOR PERMANENT PARKING LOT IMPROVEMENT DETAILS SEE "LOT 6 STRIPING" AND "LOT 6 EARTHWORK" PLAN SHEETS.

AT NO TIME SHALL THE CONTRACTOR PARK ANY VEHICLE WITHIN THE PUBLIC PARKING AREA OF THE LOT, OTHER THAN TO LOCK/UNLOCK ACCESS GATES.


INSTALL DIRECTIONAL SIGN AT LOCATION SHOWN.

SIGN SHALL BE 750mm x 750mm, WITH 50mm WHITE LETTERS ON A BLUE BACKGROUND, AND SHALL BE FULLY REFLECTORIZED WITH HIGH-INTENSITY REFLECTIVE SHEETING.

FOR ADDITIONAL
PARKING, USE
GARAGES AT
~~PALM~~ & MORRO
← 1 BLOCK
MARSH & MORRO
← 3 BLOCKS

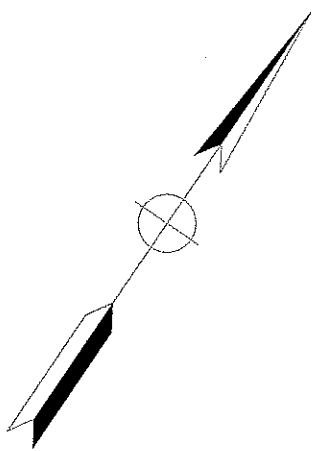

SCALE = 1 : 200

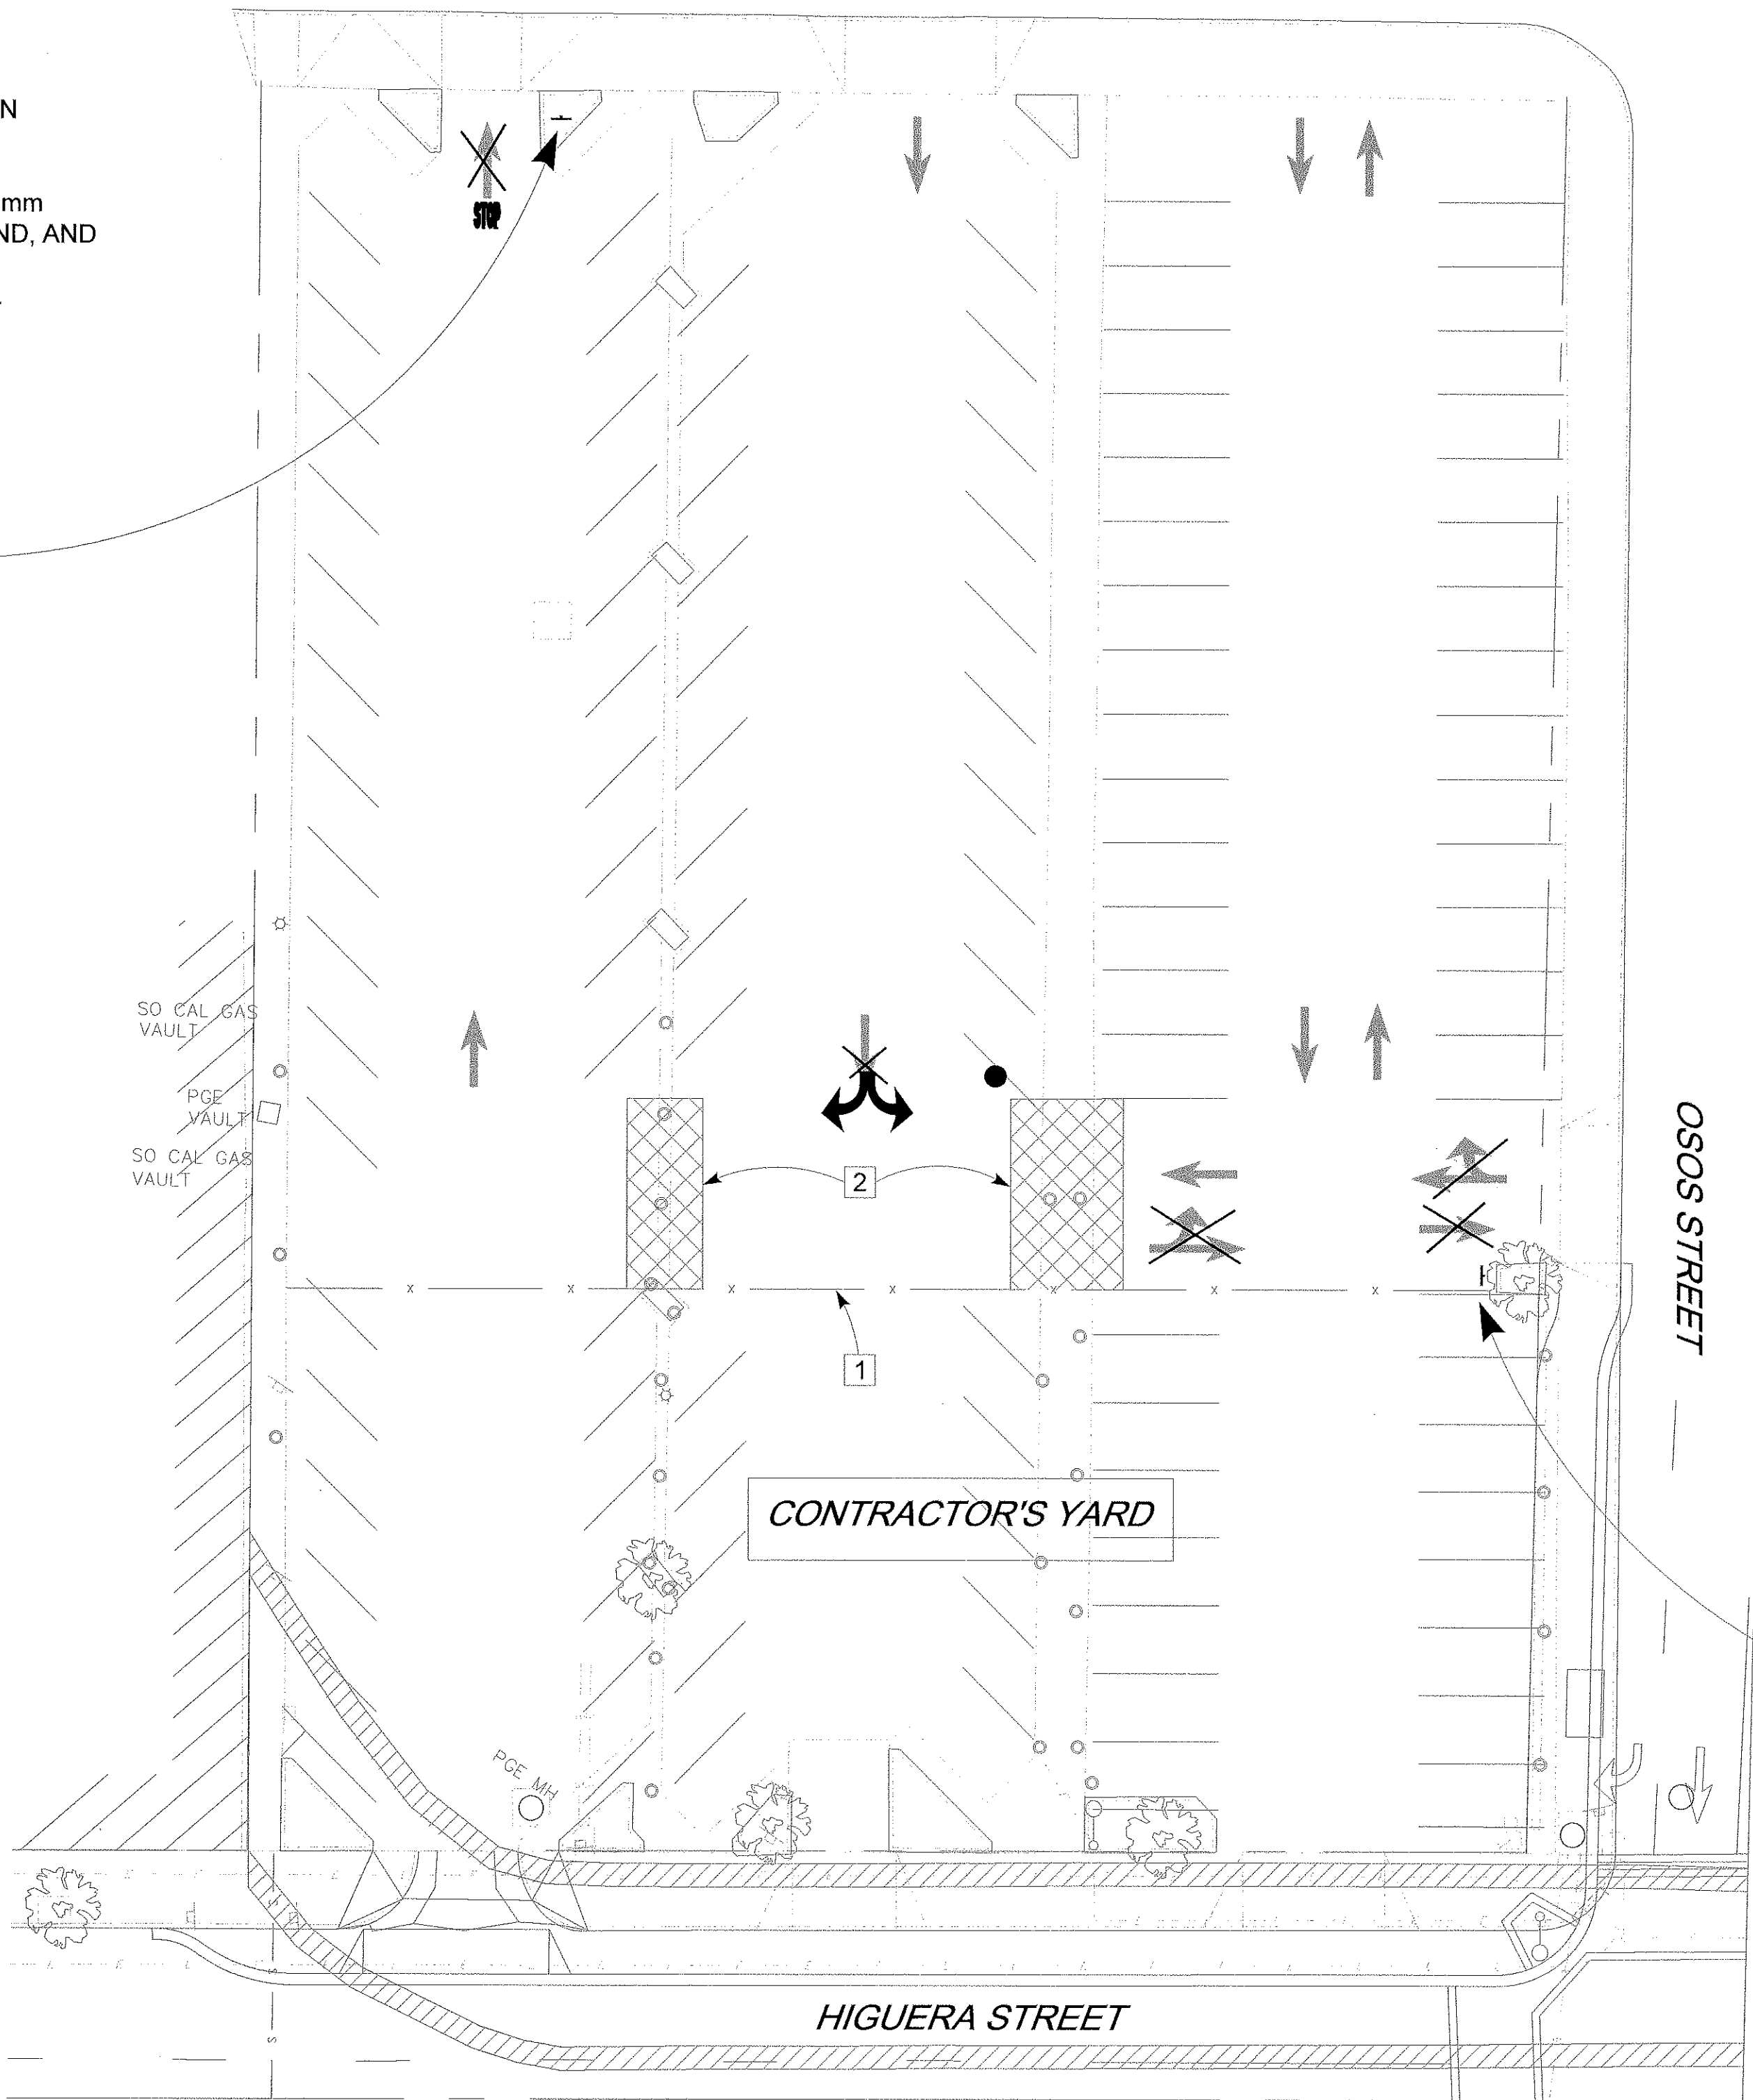


INSTALL DIRECTIONAL SIGN AT LOCATION SHOWN.

SIGN SHALL BE 750mm x 750mm, WITH 50mm WHITE LETTERS ON A ~~BLUE~~ ^{GREEN} BACKGROUND, AND SHALL BE FULLY REFLECTORIZED WITH HIGH-INTENSITY REFLECTIVE SHEETING.

FOR ADDITIONAL
PARKING, USE
GARAGES AT
~~PALM~~ & MORRO
← 2 BLOCKS
MARSH & MORRO
3 BLOCKS →

RECORD DRAWING

DATE: 2/27/02 BY: SR

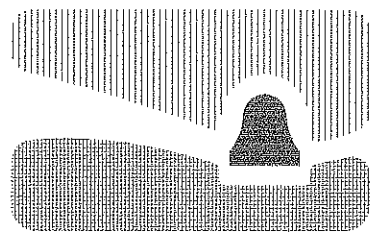

city of san luis obispo

HIGUERA STREET BRIDGE REPLACEMENT

APPROVED BY

CITY ENGINEER

DATE 3/2000

SCALE 1:200

DESIGNED BY MKF

DRAWN BY MCD

CHECKED BY MKF

APPROVED BY

UTILITIES DEPARTMENT

PARKING LOT CIRCULATION PLAN
HIGUERA STREET / OSOS STREET

SPECIFICATION NO.

9367

FILE NO./LOCATION


0060 B

SHEET

12R OF 41


GENERAL SIGNAL NOTES

- ALL SIGNAL AND LIGHTING WORK SHALL CONFORM TO THE STATE OF CALIFORNIA DEPARTMENT OF TRANSPORTATION STANDARD SPECIFICATIONS AND STANDARD PLANS DATED JULY 1999 (METRIC), AND THE SPECIAL PROVISIONS ACCOMPANYING THIS PLAN.
- THE CONTRACTOR SHALL MAINTAIN EXISTING LIGHTING CIRCUITS DURING CONSTRUCTION, EXCEPT AS DIRECTED BY THE ENGINEER. SEE SPECIAL PROVISIONS.
- ALL VEHICLE SIGNAL HEADS SHALL BE 300mm AND SHALL HAVE BACKPLATES.
- THE LOCATIONS OF ALL ELECTRICAL EQUIPMENT TO BE INSTALLED BY THE CONTRACTOR SHALL BE APPROVED BY THE ENGINEER PRIOR TO CONSTRUCTION.
- BONDING AND GROUNDING CONDUCTORS REQUIRED BY THE NATIONAL ELECTRICAL CODE AND BY THE STANDARD SPECIFICATIONS ARE NOT SHOWN ON CONDUCTOR SCHEDULES. THE CONTRACTOR SHALL ENSURE THAT THE ENTIRE MODIFIED SIGNAL AND LIGHTING SYSTEMS ARE BONDED AND GROUNDED AS REQUIRED BY THE STANDARD SPECIFICATIONS AND THE CODE.
- IN ADDITION TO THE STANDARD ABBREVIATIONS ON STANDARD PLAN ES-1A, NISNS INDICATES NON-ILLUMINATED STREET NAME SIGN.
- THE CONTRACTOR SHALL VERIFY THE SIZE AND SUITABILITY FOR USE OF ALL EXISTING CONDUITS TO BE REUSED. THE CONTRACTOR SHALL IMMEDIATELY NOTIFY THE ENGINEER IF ANY EXISTING CONDUIT IS FOUND TO BE UNSATISFACTORY FOR USE.
- CONDUITS INSTALLED IN STRUCTURES SHALL CONFORM TO THE DETAILS SHOWN ON THE STRUCTURES PLANS.

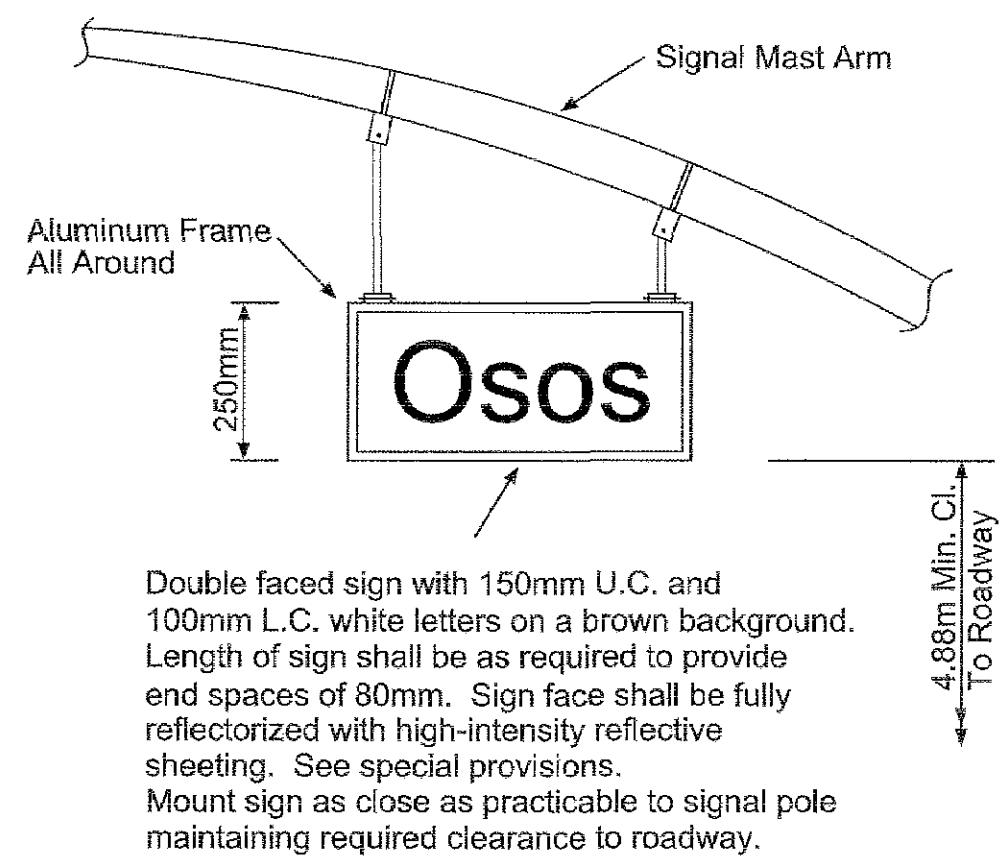

NISNS DETAIL

NTS

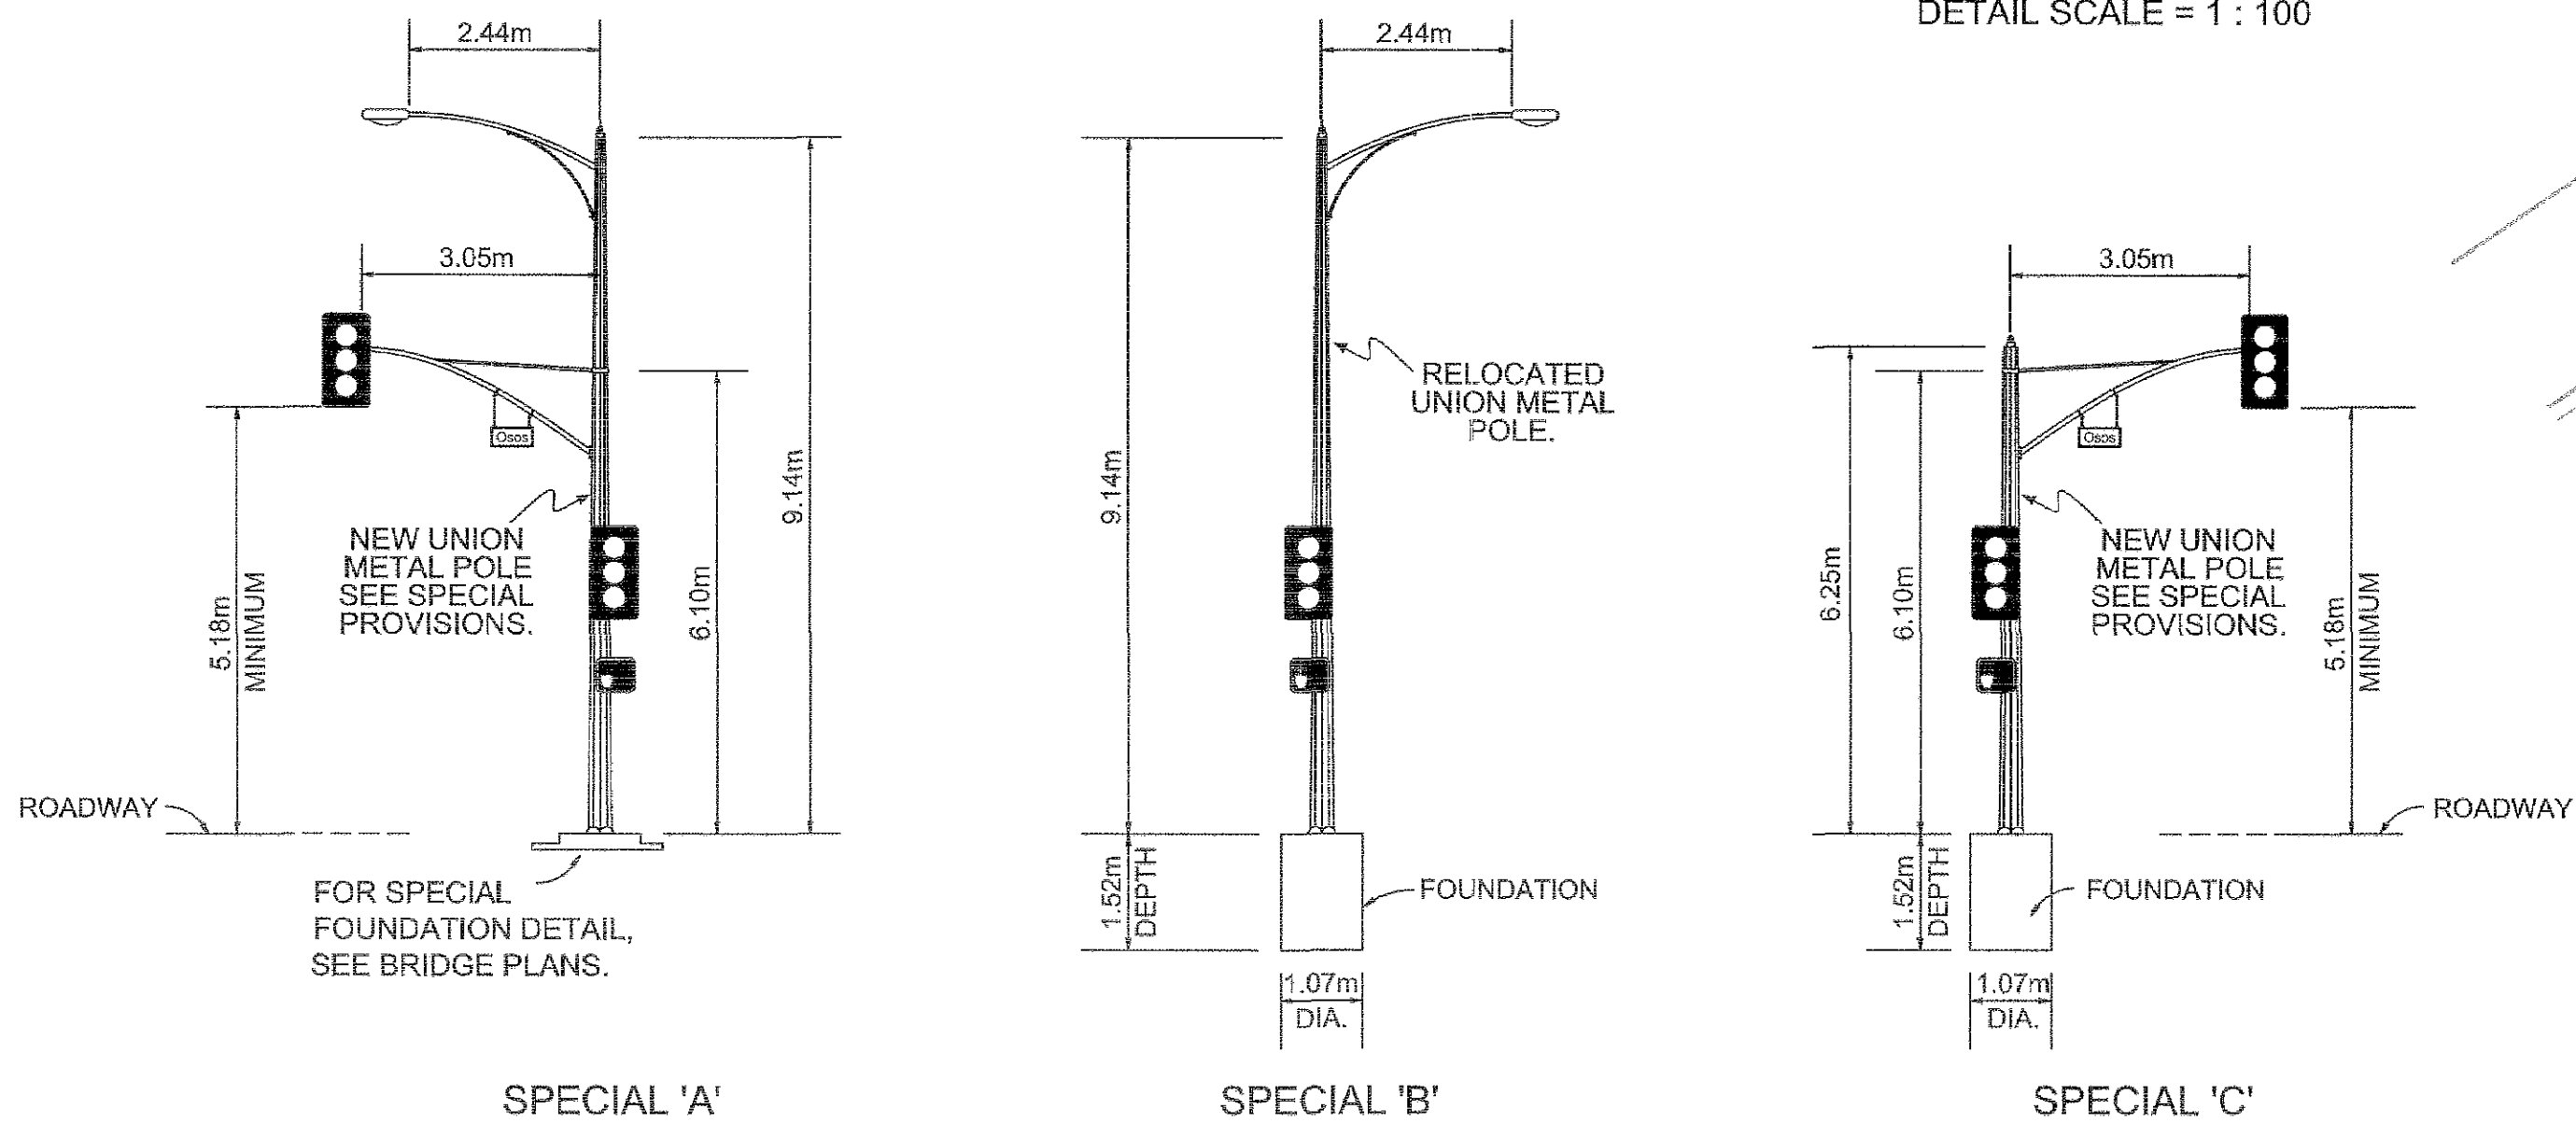


SPECIAL POLE DETAILS

NTS


POLE & EQUIPMENT SCHEDULE

LOC	STANDARDS			VEH. SIG. MTG.		PED. SIG.	HPS	NISNS LEGEND		LOCATION		REMARKS
	TYPE	SIG. M.A.	L.M.A.	M.A.	POLE	MOUNTING		FRONT	BACK	A	B	
(A)	Special 'A'	3.05m	2.44m	MAS	SV-1-T	SP-1-T	200 W	Osos	Osos	0.35m	1.00m	ALL NEW [3] [6] [7]
(B)	1-A-3.05m	-	-	-	TV-1-T	SP-1-T	-	-	-	1.97m	2.20m	ALL NEW
(C)	1-A-3.05m(E)	-	-	-	TV-1-T(N)	SP-1-T(N)	-	-	-	EXISTING		EXIST. POLE, NEW SIGNALS [4]
(D)	1-A-2.13m	-	-	-	-	TP-1-T	-	-	-	0.27m	1.00m	ALL NEW [6]
(E)	1-A-2.13m	-	-	-	-	TP-1-T	-	-	-	0.00m	1.00m	ALL NEW
(F)	Special 'B'	-	2.44m	-	SV-1-T	SP-1-T	200 W	-	-	1.19m	0.67m	[RL] EXIST. POLE, NEW SIGNALS [5] [7]
(G)	1-A-3.05m	-	-	-	TV-1-T	SP-1-T	-	-	-	0.00m	1.00m	ALL NEW
(H)	Special 'C'	3.05m	-	MAS	SV-1-T	SP-1-T	-	Osos	Osos	0.39m	1.00m	ALL NEW [3]

After locating standard per dimensions noted above, ensure compliance with General Note 4. For "A" and "B" dimensions see detail this sheet. Red vehicle indications and Portland Orange Don't Walk symbols shall be LED. See Special Provisions. For Special Poles (A) (B) & (C), see details this sheet and special provisions. All poles and mast arms shall be painted "Slate Green" per City Standards.

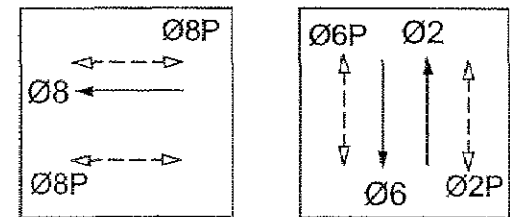

PHASE DIAGRAM

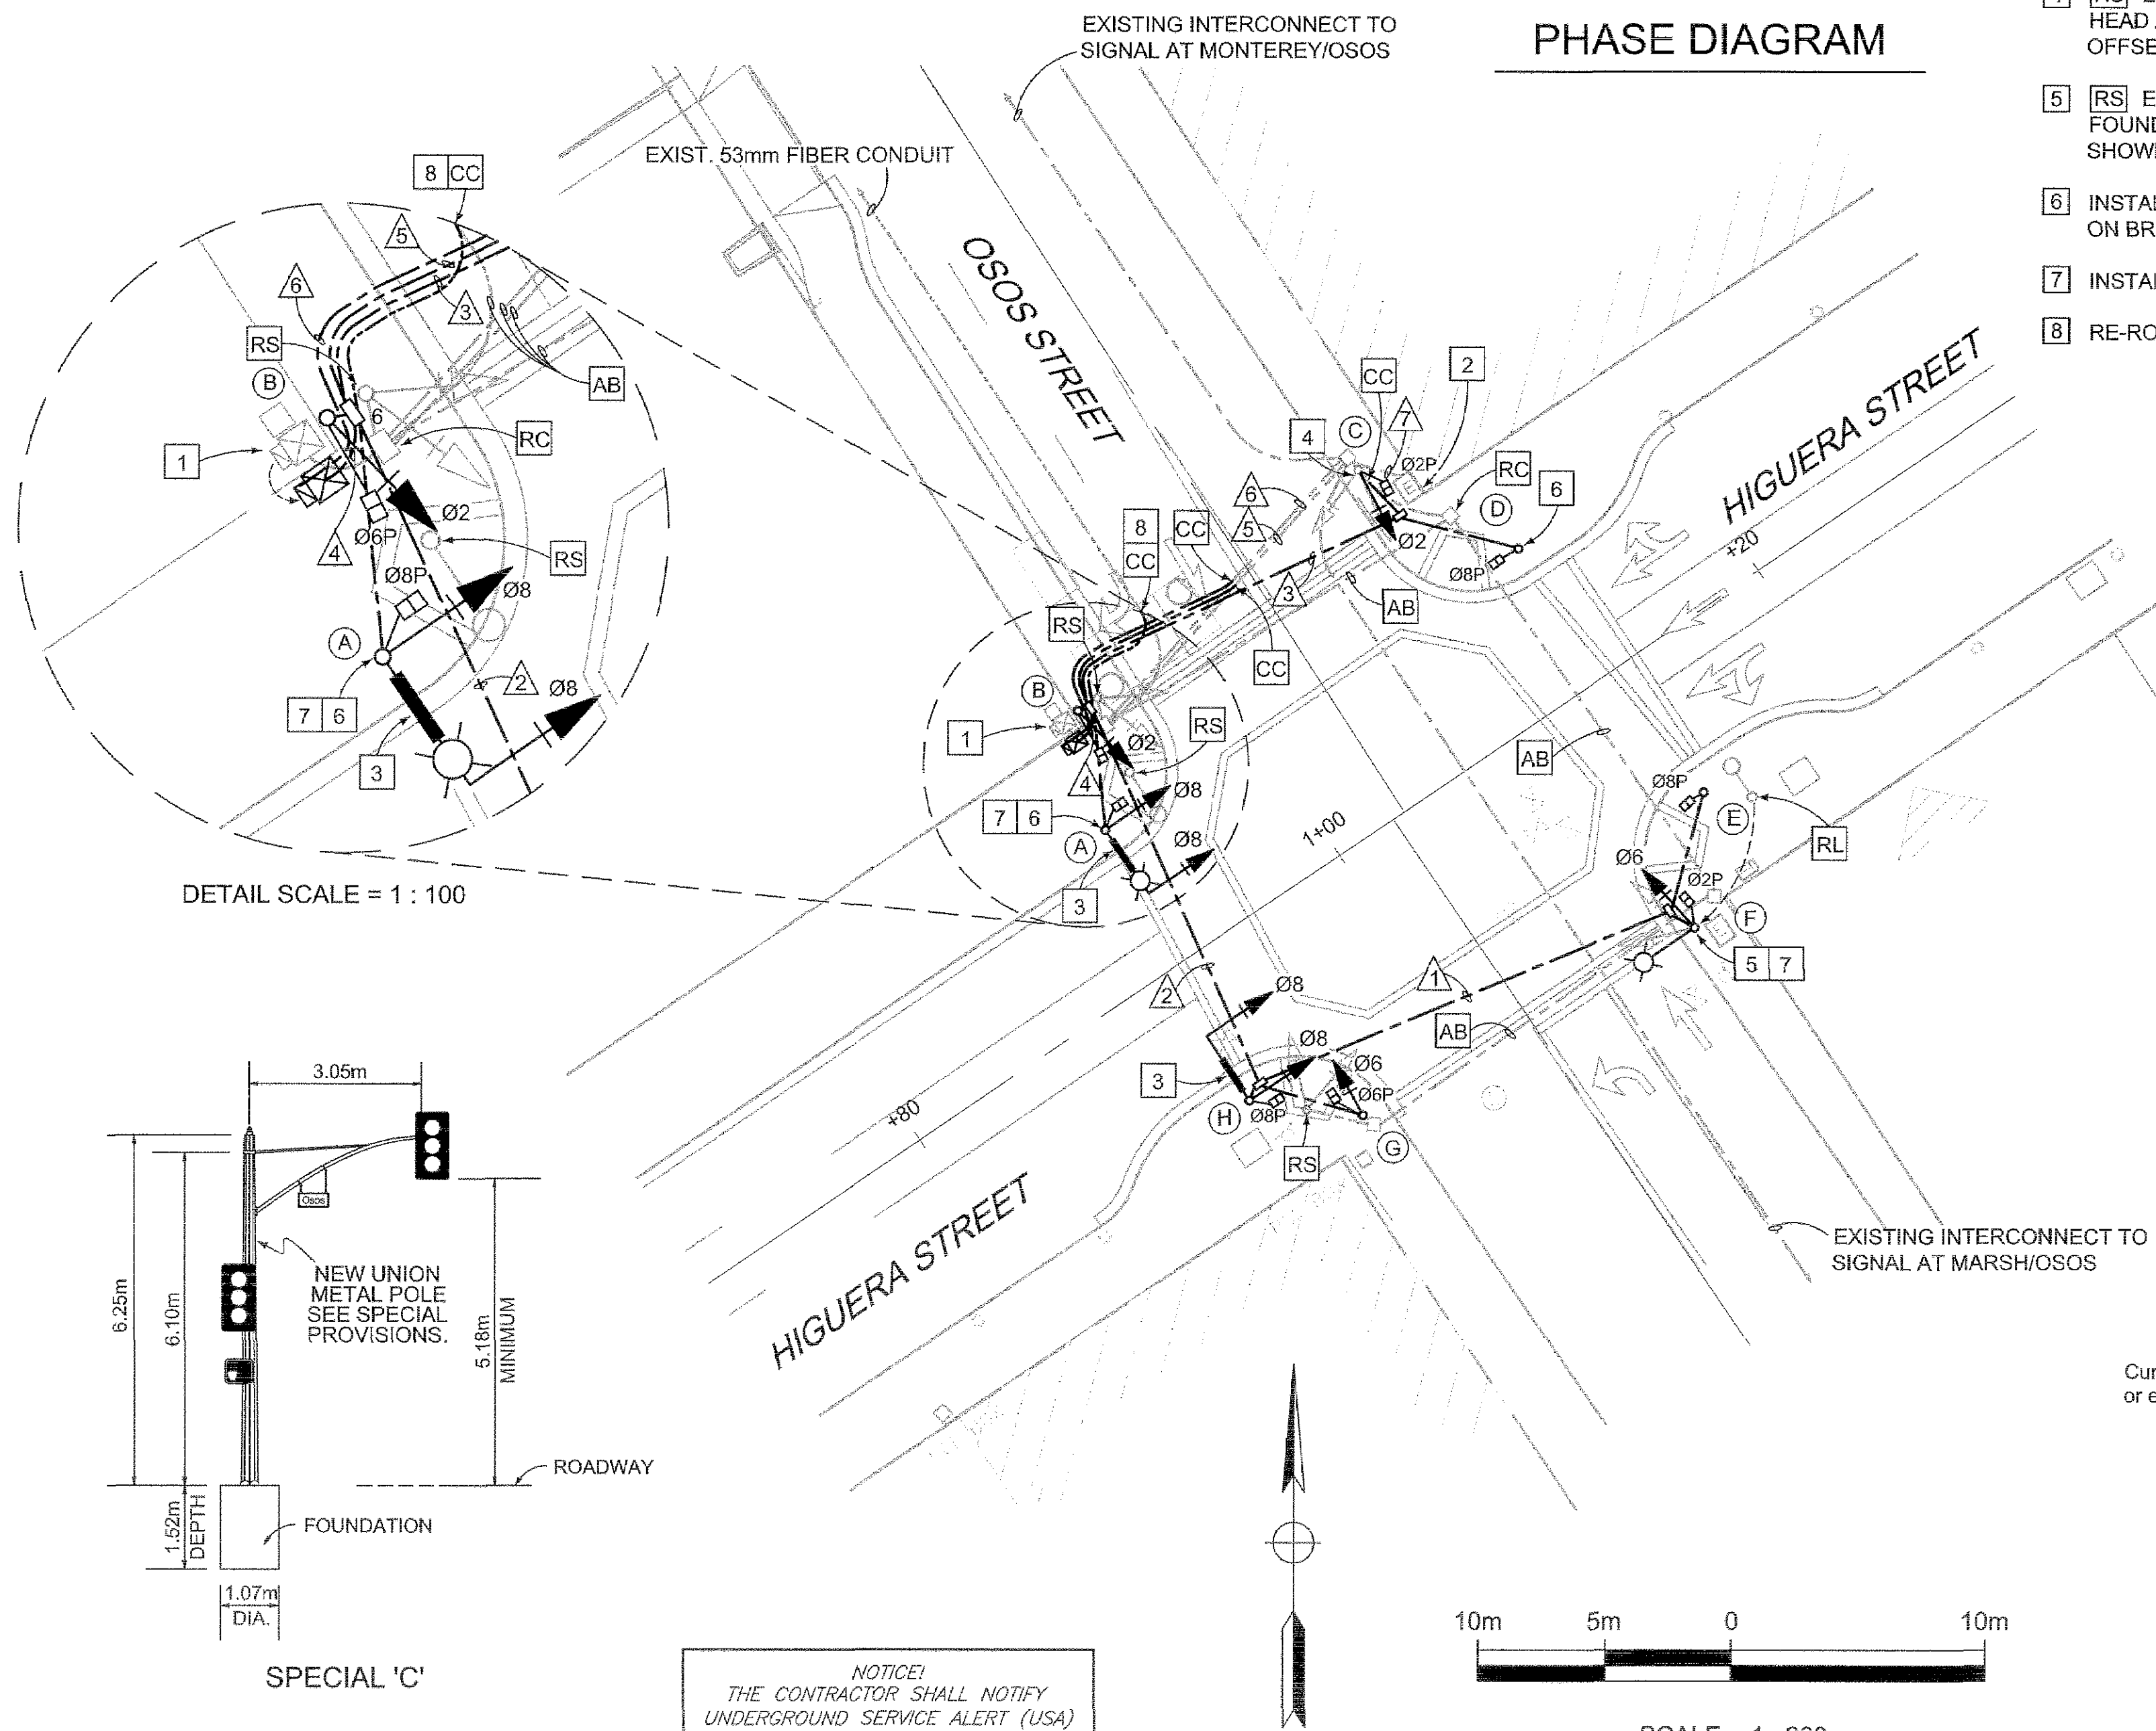

NOTICE:
THE CONTRACTOR SHALL NOTIFY
UNDERGROUND SERVICE ALERT (USA)
1-800-422-4133
NOT LESS THAN 2 WORKING DAYS
PRIOR TO START OF CONSTRUCTION

DIST	COUNTY	ROUTE	KILOMETER POST TOTAL PROJECT	SHEET NO.	TOTAL SHEETS
05	SLO	-	-	13	41

REGISTERED CIVIL ENGINEER
M.K. FRANKLIN
No. 15487
Exp. 3/31/01
CIVIL
STATE OF CALIFORNIA

PLANS APPROVAL DATE
ASSOCIATED TRANSPORTATION ENGINEERS
100 N. Hope Ave, Suite 4
Santa Barbara, CA 93110


INSTALLATION NOTES

- RELOCATE EXISTING MODEL 170 CONTROLLER ASSEMBLY, MODEL 303 CABINET AND PEDESTAL, AND TYPE II SERVICE EQUIPMENT ENCLOSURE TO NEW LOCATION AT BACK OF SIDEWALK, WITHIN RIGHT OF WAY. [RC] CONDUITS TO EXISTING SERVICE AND CONTROLLER, AND INSTALL OR EXTEND CONDUITS TO NEW LOCATION AS SHOWN.
- EXISTING PG&E SERVICE POINT AT PG&E HAND HOLE.
- FURNISH AND INSTALL NISNS ON SIGNAL MAST ARM PER DETAIL THIS SHEET. SEE SPECIAL PROVISIONS. LEGEND SHALL BE AS SHOWN ON POLE & EQUIPMENT SCHEDULE.
- [RS] EXISTING SIGNAL HEADS AND TV-2-T MOUNTING. FURNISH AND INSTALL SIGNAL HEAD AND TV-1-T MOUNTING, PEDESTRIAN HEAD AND SP-1-T MOUNTING, AS SHOWN. OFFSET VEHICLE SIGNAL HEAD AWAY FROM CURB LINE.
- [RS] EXISTING TYPE 1-A POLE AND SIGNAL EQUIPMENT. REMOVE EXISTING FOUNDATION. [RL] EXISTING SPECIAL TYPE B ELECTROLIER TO NEW LOCATION SHOWN. INSTALL VEHICLE AND PEDESTRIAN SIGNAL HEADS ON POLE AS SHOWN.
- INSTALL SIGNAL POLE ON SPECIAL FOUNDATION ON BRIDGE STRUCTURE AS SHOWN ON BRIDGE PLANS. (SEE "ABUTMENT DETAILS NO. 2" SHEET.)
- INSTALL DUPLEX RECEPTACLE IN WEATHER PROOF BOX AT TOP OF POLE.
- RE-ROUTE EXISTING 53mm FIBER CONDUIT TO NEW PULL BOX LOCATION.

CONDUIT AND CONDUCTOR SCHEDULE

AWG or CABLE	CIRCUIT	CONDUIT RUN AND SIZE						
		1	2	3	4	5	6	7
	CONDUIT	N	N	N	N	X	X	X
	CONDUCTORS	N	N	N	N	R	R	R
28 COND. CABLE	SIGNAL CIRCUITS	1	1	1	1			
#10	LUMINAIRES	2	2		2			
#10	RECEPTACLES	2	2		2			
#2	SERVICE					3		3
SIC	INTERCONNECT				2		2	

N Denote new conduit or conductors to be furnished and installed.
X Denotes existing conduit to be extended/rerouted to new pull box/foundation.
R Denotes existing conduit or conductors to be removed and replaced with new conductors.
See General Signal Notes & Special Provisions.
The contractor shall verify all existing conduit sizes. See General Signal Notes & Special Provisions.

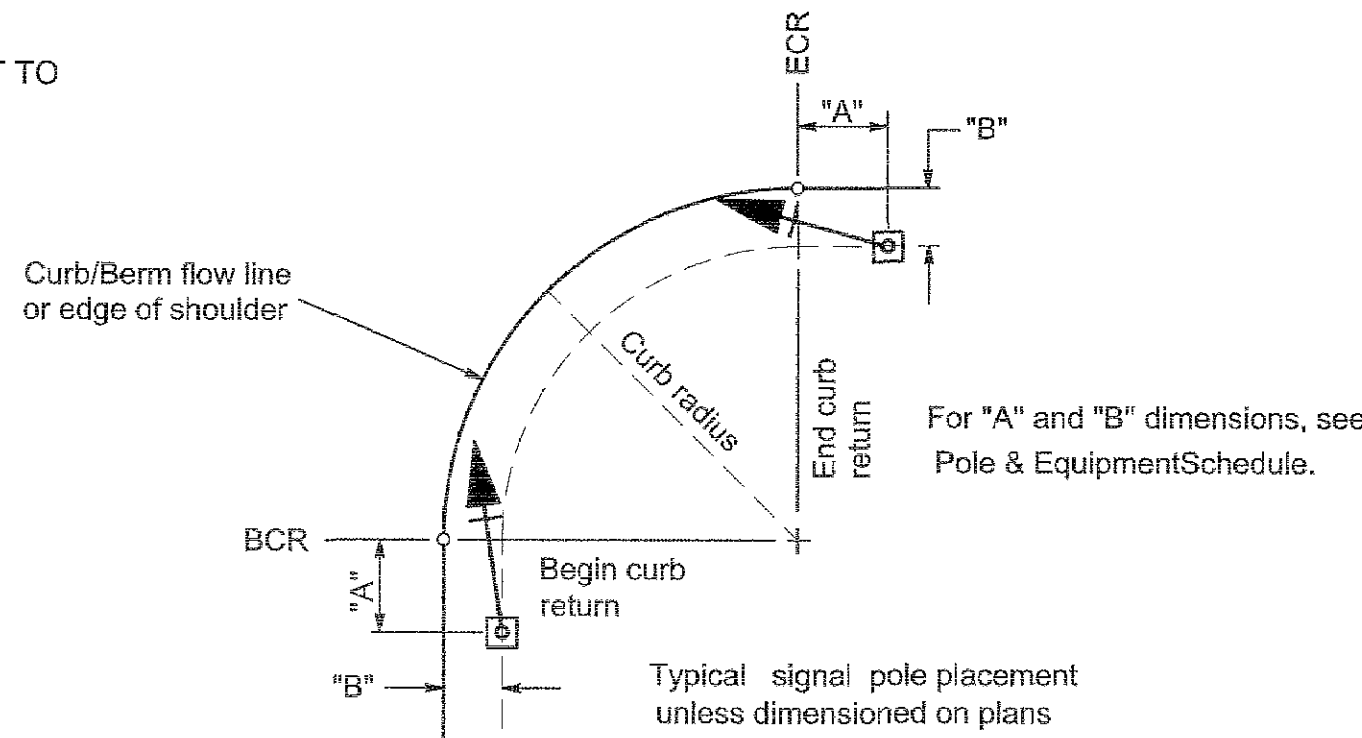

SIGNAL STANDARD PLACEMENT DIMENSIONS AND EQUIPMENT LOCATIONS



HIGUERA STREET BRIDGE REPLACEMENT

APPROVED BY	DATE 3/2000
CITY ENGINEER	SCALE 1:200
	DESIGNED BY MCD
	DRAWN BY MCD
	CHECKED BY MKF
	APPROVED BY
	UTILITIES DEPARTMENT

TRAFFIC SIGNAL AND LIGHTING PLAN
HIGUERA STREET / OSOS STREET


SPECIFICATION NO.	9367
FILE NO./LOCATION	0600 B
SHEET	13 OF 41

1. ALL SIGNAL AND LIGHTING WORK SHALL CONFORM TO THE STATE OF CALIFORNIA DEPARTMENT OF TRANSPORTATION STANDARD SPECIFICATIONS AND STANDARD PLANS DATED JULY 1999 (METRIC), AND THE SPECIAL PROVISIONS ACCOMPANYING THIS PLAN.
2. THE CONTRACTOR SHALL MAINTAIN EXISTING LIGHTING CIRCUITS DURING CONSTRUCTION, EXCEPT AS DIRECTED BY THE ENGINEER. SEE SPECIAL PROVISIONS.
3. ALL VEHICLE SIGNAL HEADS SHALL BE 300mm AND SHALL HAVE BACKPLATES.
4. THE LOCATIONS OF ALL ELECTRICAL EQUIPMENT TO BE INSTALLED BY THE CONTRACTOR SHALL BE APPROVED BY THE ENGINEER PRIOR TO CONSTRUCTION.
5. BONDING AND GROUNDING CONDUCTORS REQUIRED BY THE NATIONAL ELECTRICAL CODE AND BY THE STANDARD SPECIFICATIONS ARE NOT SHOWN ON CONDUCTOR SCHEDULES. THE CONTRACTOR SHALL ENSURE THAT THE ENTIRE MODIFIED SIGNAL AND LIGHTING SYSTEMS ARE BONDED AND GROUNDED AS REQUIRED BY THE STANDARD SPECIFICATIONS AND THE CODE.
6. IN ADDITION TO THE STANDARD ABBREVIATIONS ON STANDARD PLAN ES-1A, NISNS INDICATES NON-ILLUMINATED STREET NAME SIGN.
7. THE CONTRACTOR SHALL VERIFY THE SIZE AND SUITABILITY FOR USE OF ALL EXISTING CONDUITS TO BE REUSED. THE CONTRACTOR SHALL IMMEDIATELY NOTIFY THE ENGINEER IF ANY EXISTING CONDUIT IS FOUND TO BE UNSATISFACTORY FOR USE.
8. CONDUITS INSTALLED IN STRUCTURES SHALL CONFORM TO THE DETAILS SHOWN ON THE STRUCTURES PLANS.



POLE & EQUIPMENT SCHEDULE												
LOC	STANDARDS		VEH. SIG. MTG.			PED. SIG. MOUNTING	HPS LUMINAIRE	NISNS LEGEND		LOCATION		REMARKS
	TYPE	SIG. M.A.	L.M.A.	M.A.	POLE			FRONT	BACK	A	B	
(A)	Special 'A'	3.05m	2.44m	MAS	SV-1-T	SP-1-T	200 W	Osos	Osos	0.35m	1.00m	ALL NEW 3 6 7
(B)	1-A-3.05m	-	-	-	TV-1-T	SP-1-T	-	-	-	1.97m	2.20m	ALL NEW
(C)	1-A-3.05m(E)	-	-	-	TV-1-T(N)	SP-1-T(N)	-	-	-	EXISTING		EXIST. POLE, NEW SIGNALS 4
(D)	1-A-2.13m	-	-	-	-	TP-1-T	-	-	-	0.27m	1.00m	ALL NEW 6
(E)	1-A-2.13m	-	-	-	-	TP-1-T	-	-	-	0.00m	1.00m	ALL NEW
(F)	Special 'B'	-	2.44m	-	SV-1-T	SP-1-T	200 W	-	-	1.19m	0.67m	RL EXIST. POLE, NEW SIGNALS 5 7
(G)	1-A-3.05m	-	-	-	TV-1-T	SP-1-T	-	-	-	0.00m	1.00m	ALL NEW
(H)	Special 'C'	3.05m	-	MAS	SV-1-T	SP-1-T	-	Osos	Osos	0.39m	1.00m	ALL NEW 3

After locating standard per dimensions noted above, ensure compliance with General Note 4. For "A" and "B" dimensions see detail this sheet. Red vehicle indications and Portland Orange Don't Walk symbols shall be LED. See Special Provisions. For Special Poles (A), (B) & (C), see details this sheet and special provisions. All poles and mast arms shall be painted "Slate Green" per City Standards.

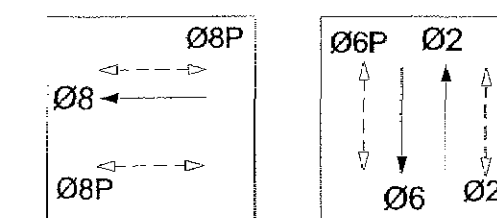

PHASE DIAGRAM

EXIST. 53mm FIBER CONDUIT

OSOS STREET

HIGUERA STREET

DETAIL SCALE = 1 : 100

NEW UNION METAL POLE
SEE SPECIAL PROVISIONS.

MINIMUM

ROADWAY

FOUNDATION

DEPTH

1.07m DIA.

3.05m

6.25m

6.10m


5.18m

MOVED TO LOCATION OF EXISTING
(CONFLICT WITH SEWER LINE)

EXISTING INTERCONNECT
SIGNAL AT MARSH/OSOS

NOTICE!
THE CONTRACTOR SHALL NOTIFY
UNDERGROUND SERVICE ALERT (USA)

10m 5m 0 10m

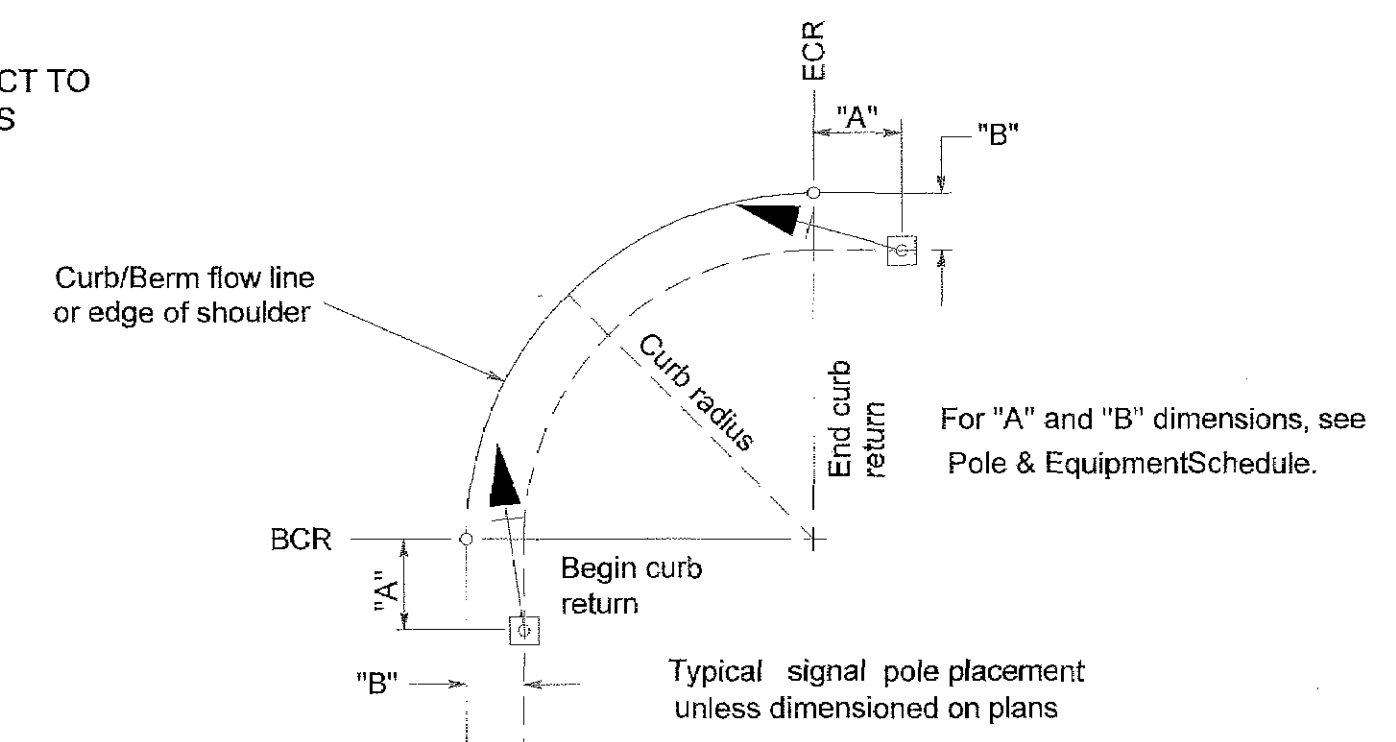

AFFIC SIGNAL AND LIGHTING PLAN

HIGUERA STREET / OSOS STREET

DIST	COUNTY	ROUTE	KILOMETER POST TOTAL PROJECT	SHEET NO.	TOTAL SHEETS
05	SLO	-	-	13	38

REGISTERED CIVIL ENGINEER

PLANS APPROVAL DATE

ASSOCIATED TRANSPORTATION ENGINEERS
 100 N. Hope Ave, Suite 4
 Santa Barbara, CA 93110



A circular professional engineer seal for the State of California. The outer ring contains the text "REGISTERED PROFESSIONAL ENGINEER" at the top and "STATE OF CALIFORNIA" at the bottom, separated by two stars. The center of the seal contains the following information: the name "M.K. FRANKLIN", the license number "No. 15487", the expiration date "Exp. 3/31/01", and the word "CIVIL" below the expiration date.

- 1 RELOCATE EXISTING MODEL 170 CONTROLLER ASSEMBLY, MODEL 303 CABINET AND PEDESTAL, AND TYPE II SERVICE EQUIPMENT ENCLOSURE TO NEW LOCATION AT BACK OF SIDEWALK, WITHIN RIGHT OF WAY. [RC] CONDUITS TO EXISTING SERVICE AND CONTROLLER, AND INSTALL OR EXTEND CONDUITS TO NEW LOCATION AS SHOWN.
- 2 EXISTING PG&E SERVICE POINT AT PG&E HAND HOLE.
- 3 FURNISH AND INSTALL NISNS ON SIGNAL MAST ARM PER DETAIL THIS SHEET. SEE SPECIAL PROVISIONS. LEGEND SHALL BE AS SHOWN ON POLE & EQUIPMENT SCHEDULE.
- 4 [RS] EXISTING SIGNAL HEADS AND TV-2-T MOUNTING. FURNISH AND INSTALL SIGNAL HEAD AND TV-1-T MOUNTING, PEDESTRIAN HEAD AND SP-1-T MOUNTING, AS SHOWN. OFFSET VEHICLE SIGNAL HEAD AWAY FROM CURB LINE.
- 5 [RS] EXISTING TYPE 1-A POLE AND SIGNAL EQUIPMENT. REMOVE EXISTING FOUNDATION. [RL] EXISTING SPECIAL TYPE B ELECTROLIER TO NEW LOCATION SHOWN. INSTALL VEHICLE AND PEDESTRIAN SIGNAL HEADS ON POLE AS SHOWN.
- 6 INSTALL SIGNAL POLE ON SPECIAL FOUNDATION ON BRIDGE STRUCTURE AS SHOWN ON BRIDGE PLANS. (SEE "ABUTMENT DETAILS NO.2" SHEET.)
- 7 INSTALL DUPLEX RECEPTACLE IN WEATHER PROOF BOX AT TOP OF POLE.
- 8 RE-ROUTE EXISTING 53mm FIBER CONDUIT TO NEW PULL BOX LOCATION.

AWG or CABLE	CIRCUIT	CONDUIT RUN AND SIZE						
		1	2	3	4	5	6	7
		78	78	78	78	53	41	53
28 COND. CABLE	CONDUIT	N	N	N	N	X	X	X
	CONDUCTORS	N	N	N	N	R	R	R
	SIGNAL CIRCUITS	1	1	1	1			
	#10	LUMINAIRES	2	2		2		
#10	RECEPTACLES	2	2		2			
#2	SERVICE					3		3
SIC	INTERCONNECT				2		2	


N Denote new conduit or conductors to be furnished and installed.
X Denotes existing conduit to be extended/rerouted to new pull box/foundation.
R Denotes existing conduit or conductors to be removed and replaced with new conductors.
See General Signal Notes & Special Provisions.
The contractor shall verify all existing conduit sizes. See General Signal Notes
& Special Provisions.

NOTES:

- 1 USE MODIFIED CALTRANS DETAIL 9 (WITH TYPE C RED-CLEAR REFLECTORS IN LIEU OF TYPE G ONE-WAY CLEAR REFLECTORS).


GENERAL NOTES:

1. EXACT LOCATION AND COLOR OF CURBS SHALL BE DETERMINED BY THE ENGINEER.
2. EXACT LOCATIONS OF PAVEMENT MARKINGS TO BE DETERMINED BY THE ENGINEER.

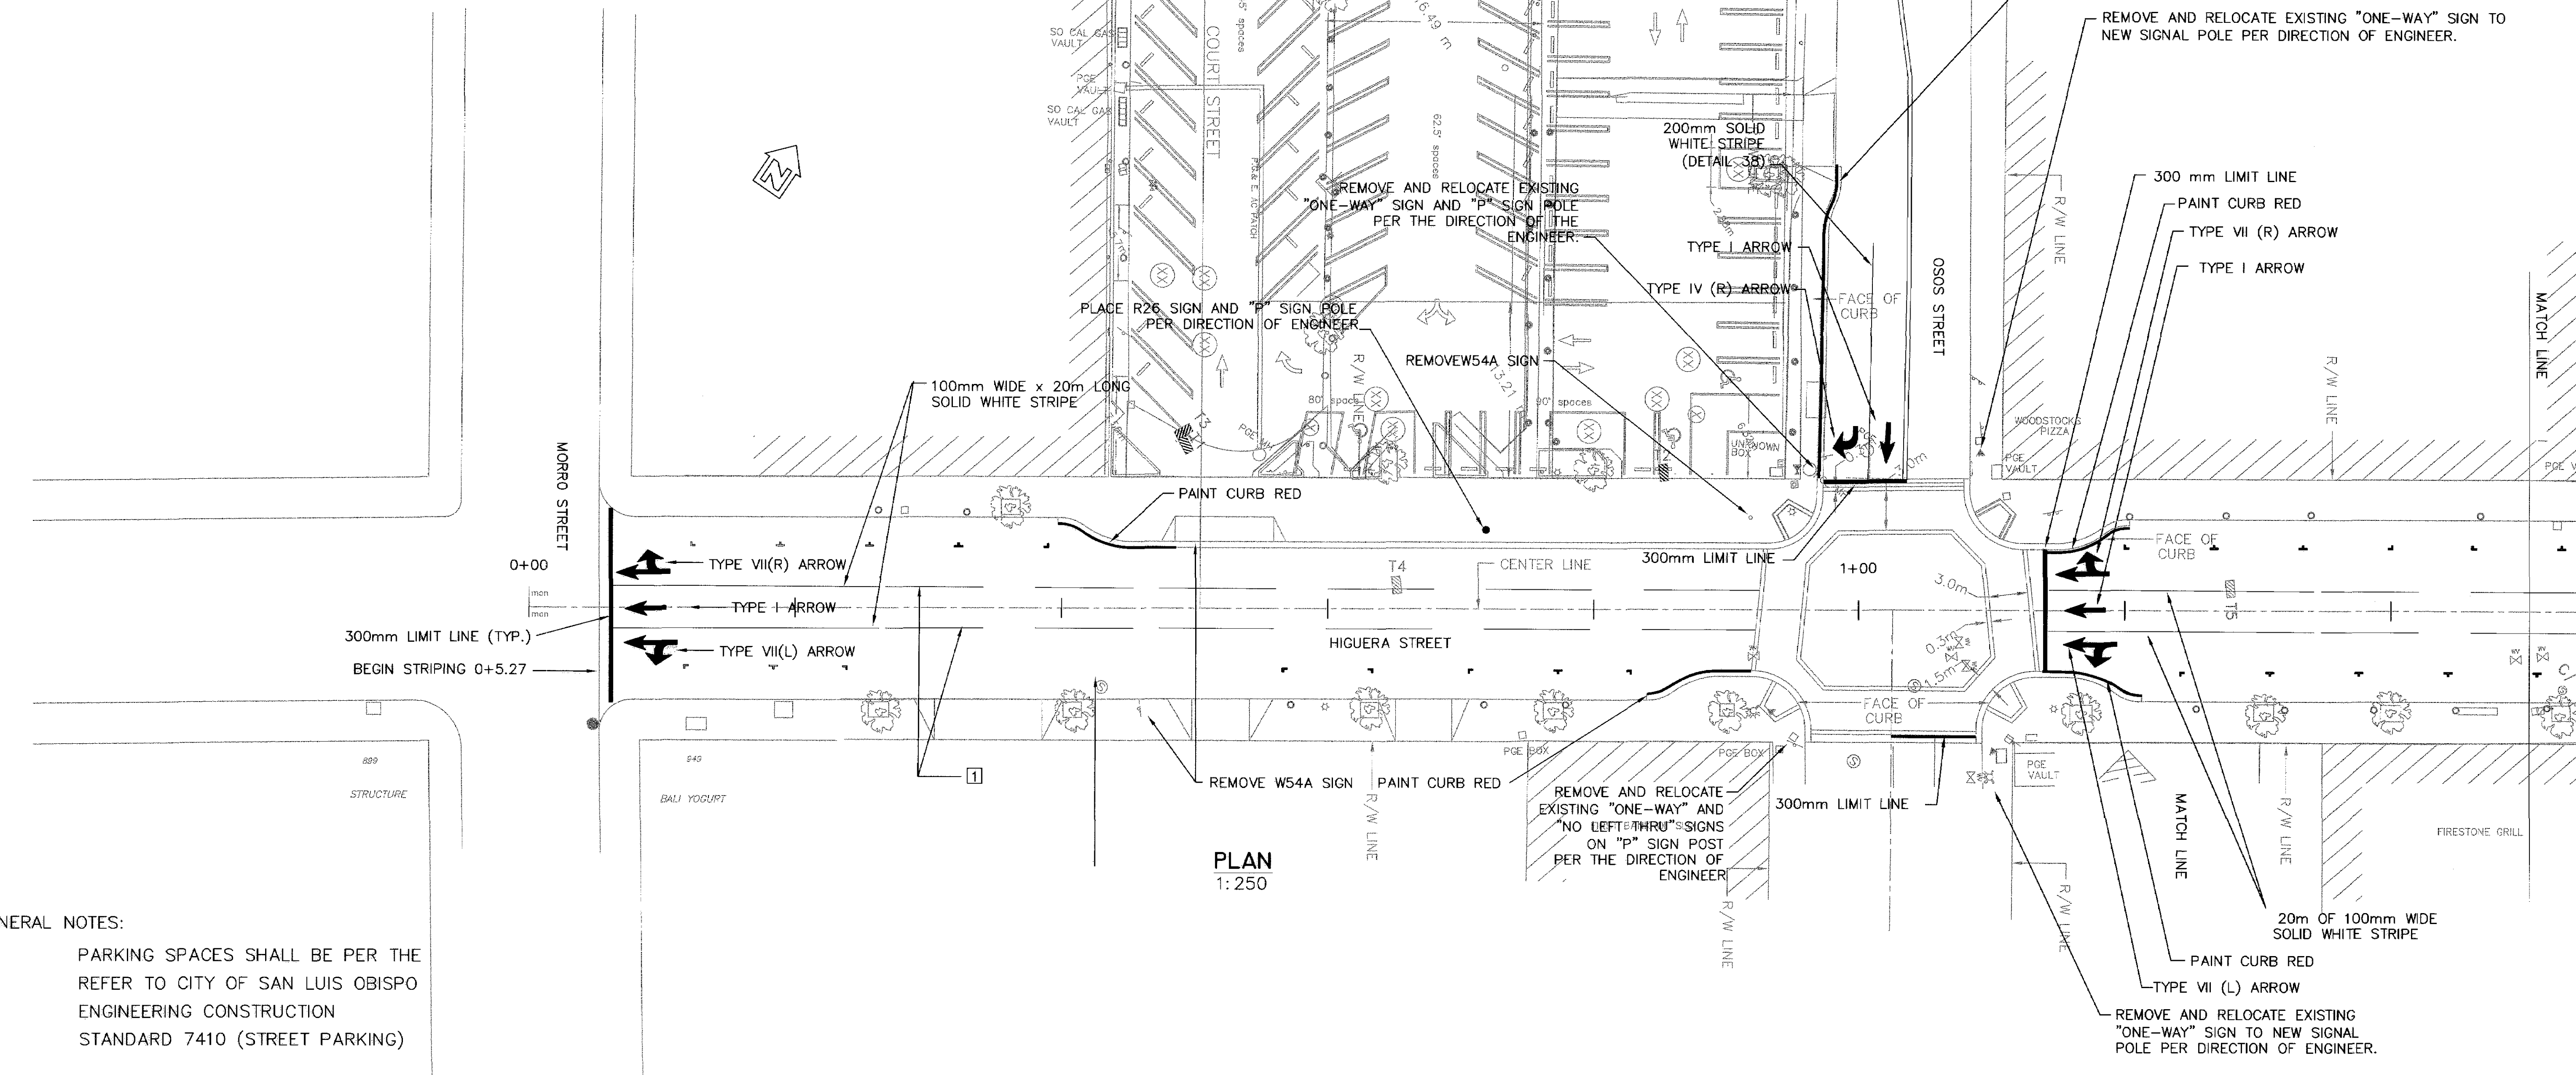

GENERAL NOTES:

PARKING SPACES SHALL BE PER THE REFER TO CITY OF SAN LUIS OBISPO ENGINEERING CONSTRUCTION STANDARD 7410 (STREET PARKING)

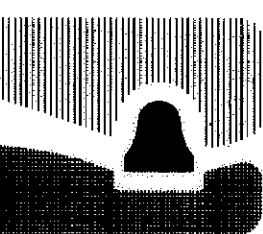

city of san luis obispo

HIGUERA STREET BRIDGE REPLACEMENT

FOR REDUCED PLANS
ORIGINAL SCALE IS IN MILLIMETERS

APPROVED BY

CITY ENGINEER

DATE 3/2000

SCALE 1:250

DESIGNED BY A.O.

DRAWN BY K.B.

CHECKED BY R.C.

APPROVED BY UTILITIES DEPARTMENT

SIGNING & STRIPING
PLAN NO. 1

SPECIFICATION NO.

9367

FILE NO./LOCATION

0060 B

SHEET

14 OF 41

DIST	COUNTY	ROUTE	POST MILES TOTAL PROJECT	SHEET NO.	TOTAL SHEETS
5	SLO		-	14	41

REGISTERED CIVIL ENGINEER
4/6/2000
PLANS APPROVAL DATE

MARTIN & KANE, Inc.
2200-B DOUGLAS BLVD, #150
ROSEVILLE • CA 95661


REGISTERED PROFESSIONAL ENGINEER
Ann Conner Olson
No. C034496
EXP. 9/30/03
CIVIL
STATE OF CALIFORNIA

NOTES:

- 1 USE MOIFIED CALTRANS DETAIL 9 (WITH TYPE C RED-CLEAR REFLECTORS IN LIEU OF TYPE G ONE-WAY CLEAR REFLECTORS).

GENERAL NOTES:

1. EXACT LOCATION AND COLOR OF CURBS SHALL BE DETERMINED BY THE ENGINEER.
2. EXACT LOCATIONS OF PAVEMENT MARKINGS TO BE DETERMINED BY THE ENGINEER.

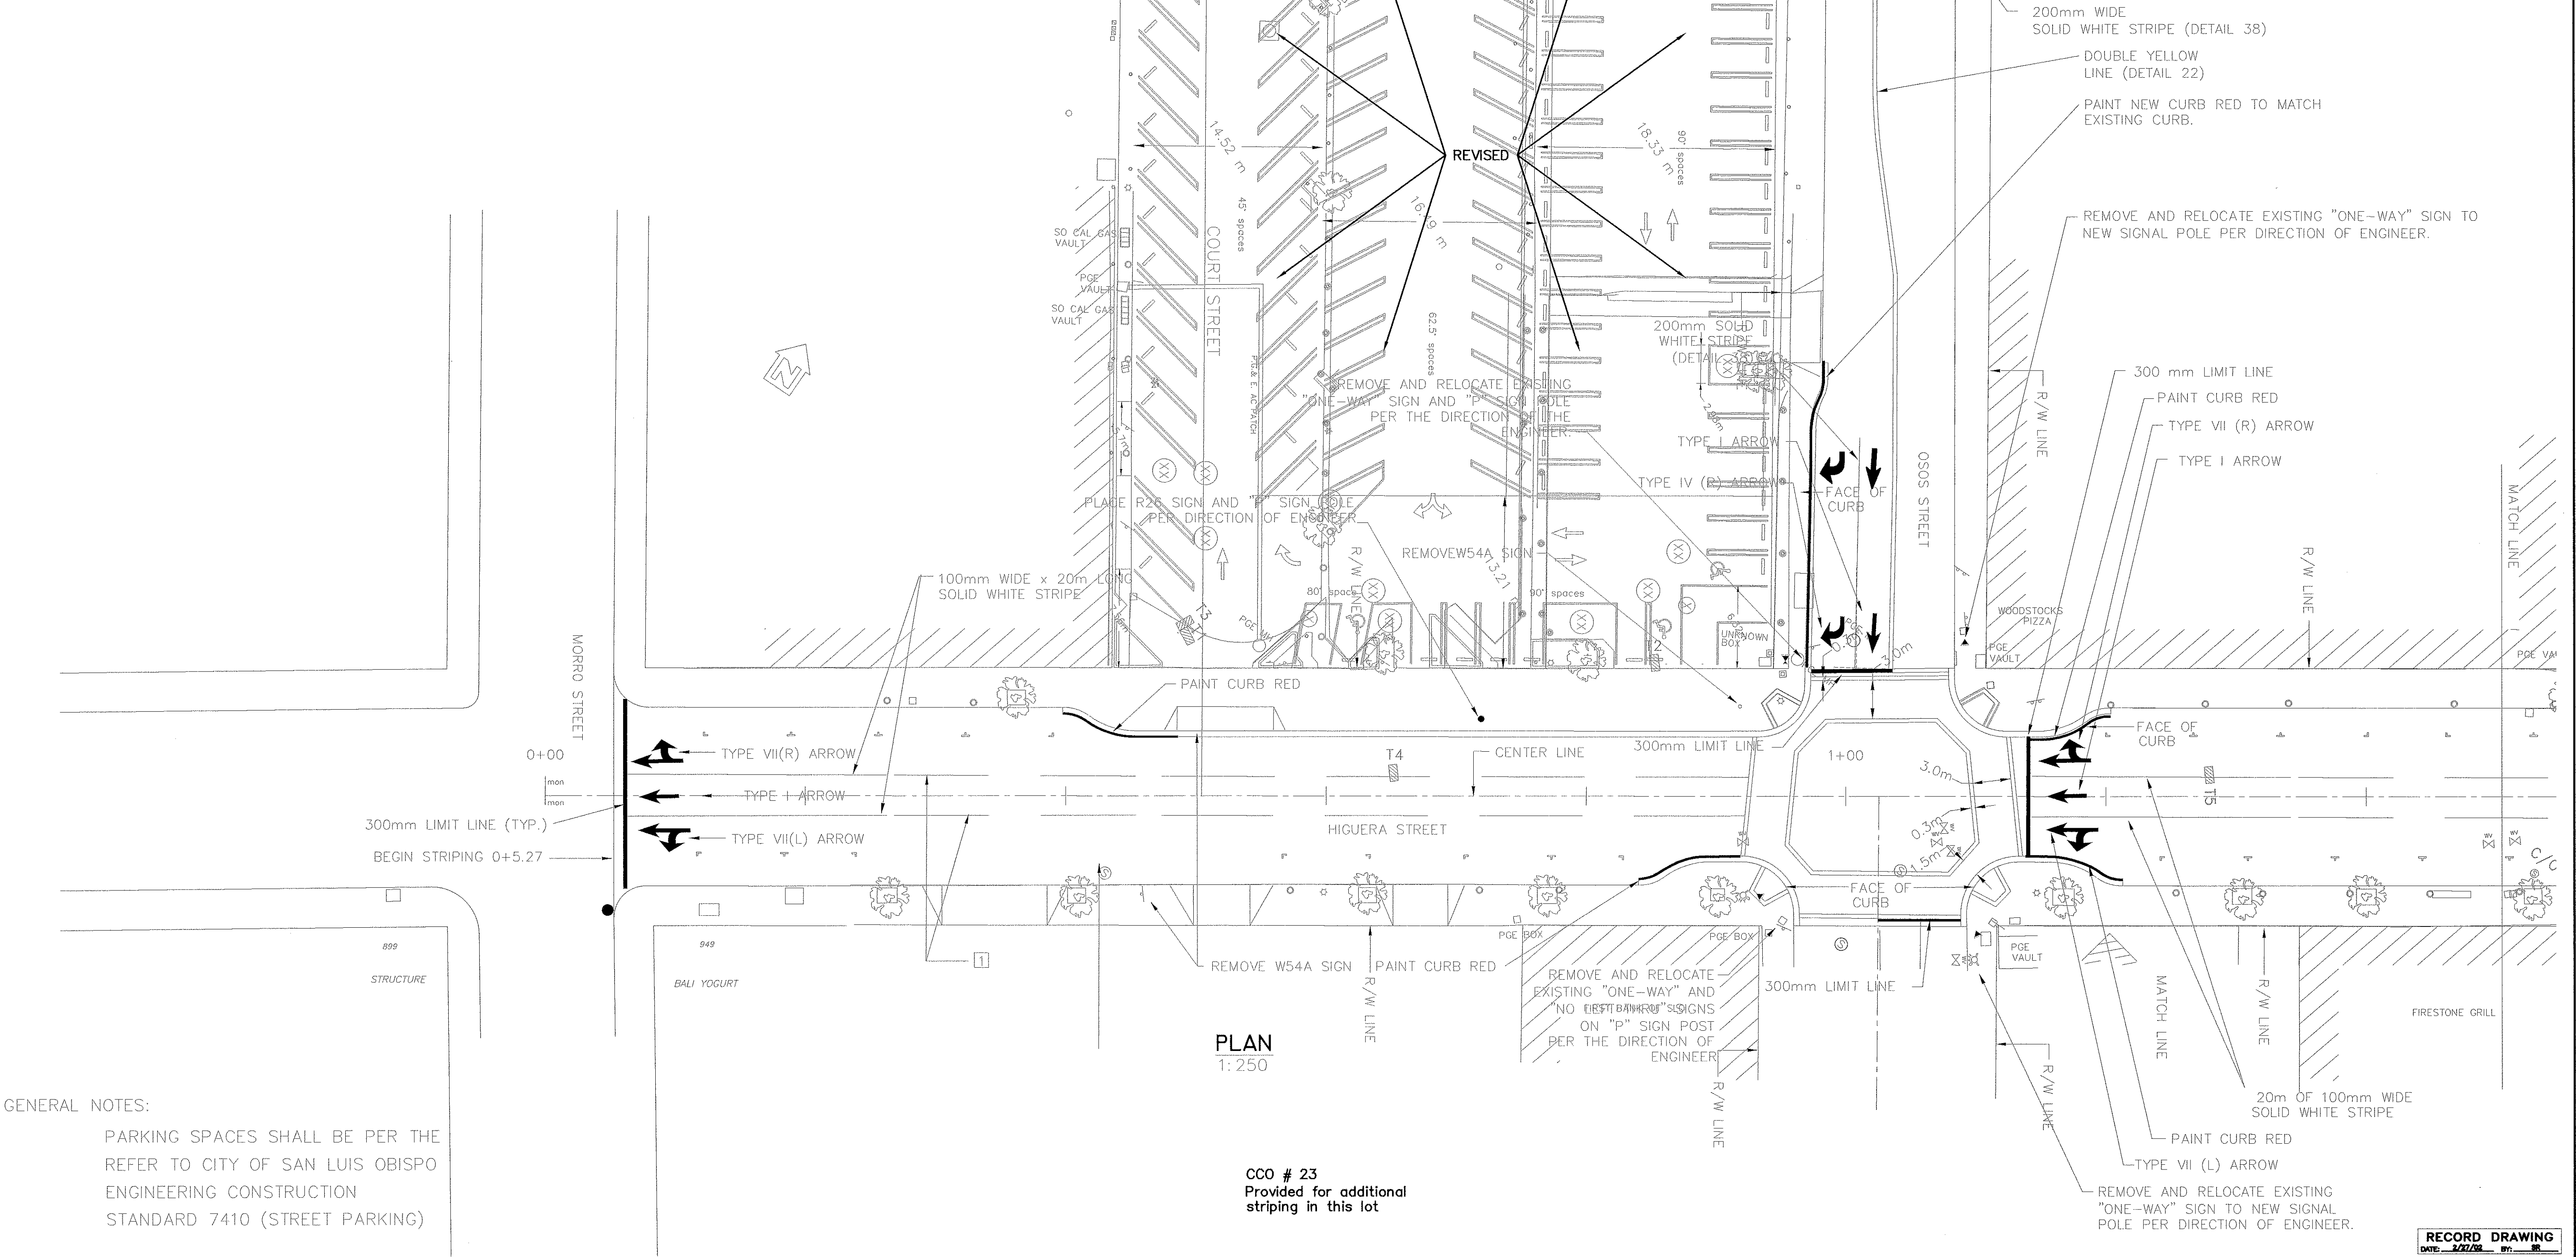


GENERAL NOTES:

PARKING SPACES SHALL BE PER THE REFER TO CITY OF SAN LUIS OBISPO ENGINEERING CONSTRUCTION STANDARD 7410 (STREET PARKING)

CCO # 23
Provided for additional striping in this lot

N:\MKS\RV\WK PROJECTS\1997\97017.00 HIGUERA STREET BRIDGE REHAB\DRAWINGS\100% Submittal\97017-SP.dwg 3-17-00

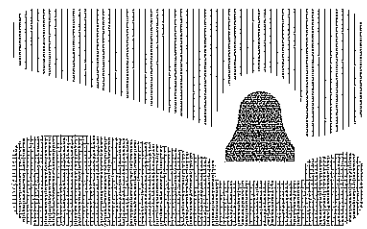

city of san luis obispo

HIGUERA STREET BRIDGE REPLACEMENT

FOR REDUCED PLANS
ORIGINAL SCALE IS IN MILLIMETERS

0 20 40 60 80 100

APPROVED BY

CITY ENGINEER

DATE 3/2000

SCALE 1:250

DESIGNED BY A.O.

DRAWN BY K.B.

CHECKED BY R.C.

APPROVED BY

UTILITIES DEPARTMENT

SIGNING & STRIPING
PLAN NO. 1

RECORD DRAWING

DATE 3/27/00 BY 00

SPECIFICATION NO.

9367

FILE NO./LOCATION

0060 B

SHEET

14R of 41



DIST	COUNTY	ROUTE	POST MILES TOTAL PROJECT	SHEET NO.	TOTAL SHEETS
5	SLO		—	15	41

REGISTERED CIVIL ENGINEER
4/5/2000
PLANS APPROVAL DATE


MARTIN & KANE, Inc.
2200-B DOUGLAS BLVD. #150
ROSEVILLE • CA 95661

NOTES:

- 1 USE MODIFIED CALTRANS DETAIL 9 (WITH TYPE C RED-CLEAR REFLECTORS IN LIEU OF TYPE G ONE-WAY CLEAR REFLECTORS).

GENERAL NOTES:


1. EXACT LOCATION AND COLOR OF CURBS SHALL BE DETERMINED BY THE ENGINEER.
2. EXACT LOCATIONS OF PAVEMENT MARKINGS TO BE DETERMINED BY THE ENGINEER.

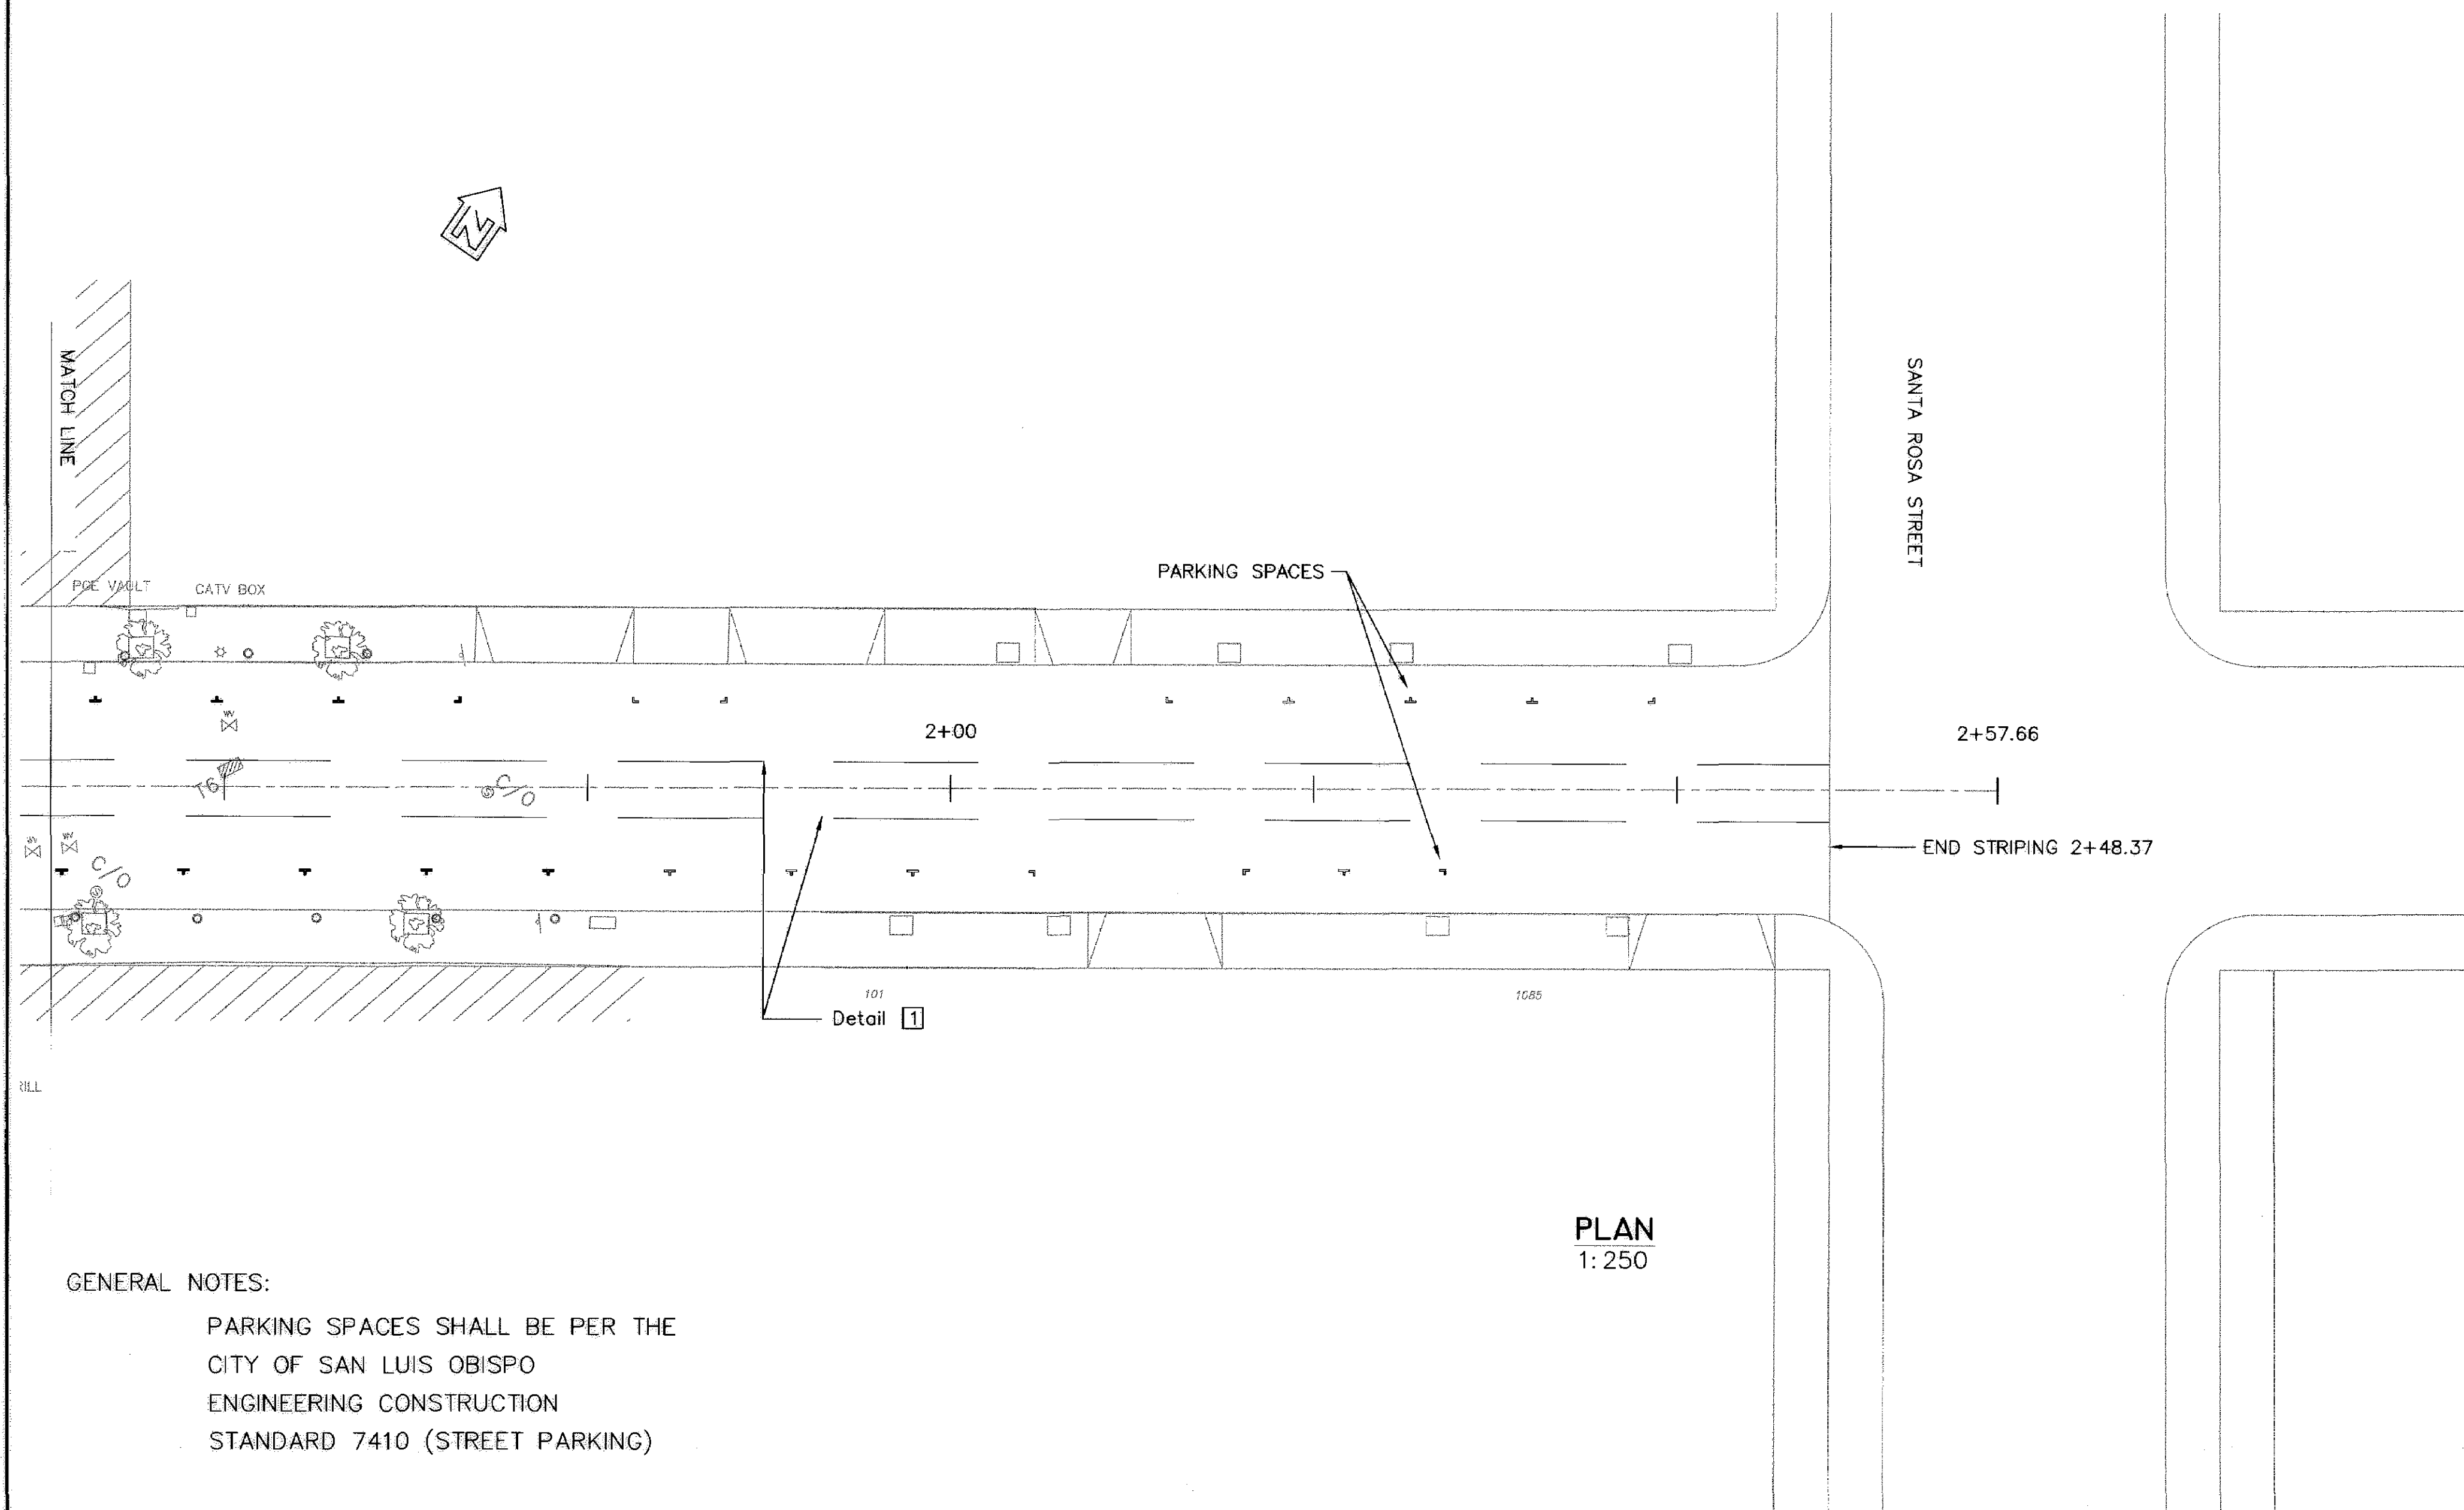

PLAN
1:250

GENERAL NOTES:

PARKING SPACES SHALL BE PER THE
CITY OF SAN LUIS OBISPO
ENGINEERING CONSTRUCTION
STANDARD 7410 (STREET PARKING)

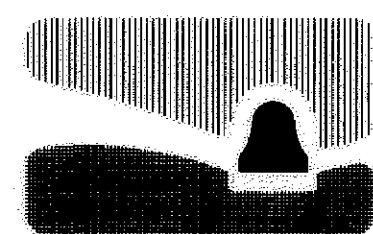

city of san luis obispo

HIGUERA STREET BRIDGE REPLACEMENT

FOR REDUCED PLANS
ORIGINAL SCALE IS IN MILLIMETERS

APPROVED BY

CITY ENGINEER

DATE 3/2000

SCALE 1:250

DESIGNED BY A.O.

DRAWN BY K.B.

CHECKED BY R.C.

APPROVED BY

UTILITIES DEPARTMENT

SIGNING & STRIPING
PLAN NO. 2

SPECIFICATION NO.

9367

FILE NO./LOCATION

0066 B

SHEET

15 OF 41



DIST	COUNTY	ROUTE	POST MILES TOTAL PROJECT	SHEET NO.	TOTAL SHEETS
5	SLO		—	16	41

Ann Conner Olson
REGISTERED CIVIL ENGINEER
4/5/2000
PLANS APPROVAL DATE

MARTIN & KANE, Inc.
2200-B DOUGLAS BLVD, #150
ROSEVILLE • CA 95661

REGISTERED PROFESSIONAL ENGINEER
Ann Conner Olson
No. C034496
EXP. 9/30/03
CIVIL
STATE OF CALIFORNIA

CONSTRUCTION AREA SIGNS

TYPE	PANEL SIZE	EACH	REMARKS
(A) C19	1200mm x 1200mm	3	MOUNT ON POST
(B) C1	1200mm x 1200mm	3	MOUNT ON POST
(C) C5 (L)	1200mm x 450mm	4	MOUNT ON POST
(D) R17B	750mm x 900mm	4	MOUNT ON POST
(E) R16B	750mm x 900mm	2	MOUNT ON POST
(F) C7	750mm x 600mm	3	MOUNT ON POST
(G) C2	1200mm x 750mm	3	(ON BARRIER)
(H) C3A	1500mm x 750mm	8	(4 ON BARRIER, 4 ON POST)
(I) C5 (R)	1200mm x 450mm	8	(4 ON BARRIER, 4 ON POST)
(J) C14	1200mm x 600mm	4	MOUNT ON POST
(K) C23	1200mm x 1200mm	3	MOUNT ON POST
(L) G7-1 (MODIFIED)	400mm x 150mm	2	HIGUERA STREET MOUNT ON POST

NOTES:

- CONTRACTOR SHALL PLACE CALTRANS STANDARD PLAN A73 TYPE III BARRICADES ACROSS ENTIRE WIDTH OF STREET OR DRIVEWAY. SIGN C2 SHALL BE ATTACHED TO THE MIDDLE OF THE BARRICADE.
- CONTRACTOR SHALL PLACE CALTRANS STANDARD PLAN A73 STAGGERED TYPE III BARRICADES ACROSS WIDTH OF STREET TO ALLOW FOR LOCAL TRAFFIC MOVEMENT (INCLUDING PROVIDING ACCESS TO LOADING ZONES FOR LOCAL BUSINESSES). SIGNS C3A AND C5 (R) SHALL BE ATTACHED TO THE CENTER OF THE BARRICADE.


GENERAL NOTES:

ALL SIGNS SHOWN ON THIS PLAN, EXCEPT FOR THOSE MOUNTED ON BARRICADES, SHALL BE MAINTAINED ONLY AS LONG AS DETOUR OR ROAD CONSTRUCTION IS IN EFFECT. WHEN THE SIGNS ARE NO LONGER NEEDED, THEY WILL BE COMPLETELY COVERED OR REMOVED BY THE CONTRACTOR.

ALL TEMPORARY SIGNS ON THIS PLAN INTENDED FOR NIGHTTIME USE SHALL HAVE REFLECTORIZED BACKGROUND AND/OR LEGEND AND BORDER DEPENDING ON THE STANDARDS FOR THAT PARTICULAR SIGN.

LEGEND:

- PLACE CONSTRUCTION AREA SIGN (AS SHOWN). EXACT SIGN LOCATIONS, AND TIMING OF PLACEMENT, TO BE DETERMINED BY THE RESIDENT ENGINEER.
- PLACE CALTRANS STANDARD PLAN A73 TEMPORARY TYPE III BARRICADE WITH TEMPORARY SIGN (AS SHOWN)

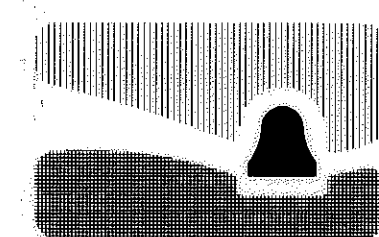

city of san luis obispo

HIGUERA STREET BRIDGE REPLACEMENT

APPROVED BY

CITY ENGINEER

DATE 3/2000

SCALE NONE

DESIGNED BY C. EBELING

DRAWN BY C. EBELING

CHECKED BY A. OLSON

APPROVED BY

UTILITIES DEPARTMENT

TRAFFIC DETOUR PLAN
HIGUERA STREET CLOSED
OSOS STREET CLOSED

SPECIFICATION NO.

9367

FILE NO./LOCATION

0060 B

SHEET

16 of 41



DIST	COUNTY	ROUTE	POST MILES TOTAL PROJECT	SHEET NO.	TOTAL SHEETS
5	SLO		-	17	41

Ann. Conner Olson
REGISTERED CIVIL ENGINEER
4/5/2000
PLANS APPROVAL DATE

MARTIN & KANE, Inc.
2200-B DOUGLAS BLVD. #150
ROSEVILLE • CA 95661

REGISTERED PROFESSIONAL ENGINEER
Ann. Conner Olson
No. C034496
EXP. 9/30/03
CIVIL
STATE OF CALIFORNIA

CONSTRUCTION AREA SIGNS

TYPE	PANEL SIZE	EACH	REMARKS
A C19	1200mm x 1200mm	2	MOUNT ON POST
B C1	1200mm x 1200mm	1	MOUNT ON POST
C C5 (L)	1200mm x 450mm	3	MOUNT ON POST
D R17B	750mm x 900mm	3	MOUNT ON POST
E R16B	750mm x 900mm	2	MOUNT ON POST
F C7	750mm x 600mm	1	MOUNT ON POST
G C2	1200mm x 750mm	3	(ON BARRIER)
H C3A	1500mm x 750mm	4	(2 ON BARRIER, 2 ON POST)
I C5 (R)	1200mm x 450mm	4	(2 ON BARRIER, 2 ON POST)
J C14	1200mm x 600mm	1	MOUNT ON POST
K C23	1200mm x 1200mm	3	MOUNT ON POST
L G7-1 (MODIFIED)	400mm x 150mm	4	HIGUERA STREET MOUNT ON POST
M G36	400mm x 280mm	1	MOUNT ON POST
N C5A	1200mm x 450mm	1	MOUNT ON POST

NOTES:

- 1 CONTRACTOR SHALL PLACE CALTRANS STANDARD PLAN A73 TYPE III BARRICADES ACROSS ENTIRE WIDTH OF STREET OR DRIVEWAY. SIGN C2 SHALL BE ATTACHED TO THE MIDDLE OF THE BARRICADE.
- 2 CONTRACTOR SHALL PLACE CALTRANS STANDARD PLAN A73 STAGGERED TYPE III BARRICADES ACROSS WIDTH OF STREET TO ALLOW FOR LOCAL TRAFFIC MOVEMENT (INCLUDING PROVIDING ACCESS TO LOADING ZONES FOR LOCAL BUSINESSES). SIGNS C3A AND C5 (R) SHALL BE ATTACHED TO THE CENTER OF THE BARRICADE.


GENERAL NOTES:

ALL SIGNS SHOWN ON THIS PLAN, EXCEPT FOR THOSE MOUNTED ON BARRICADES, SHALL BE MAINTAINED ONLY AS LONG AS DETOUR OR ROAD CONSTRUCTION IS IN EFFECT. WHEN THE SIGNS ARE NO LONGER NEEDED, THEY WILL BE COMPLETELY COVERED OR REMOVED BY THE CONTRACTOR.

ALL TEMPORARY SIGNS ON THIS PLAN INTENDED FOR NIGHTTIME USE SHALL HAVE REFLECTORIZED BACKGROUND AND/OR LEGEND AND BORDER DEPENDING ON THE STANDARDS FOR THAT PARTICULAR SIGN.

LEGEND:

- PLACE CONSTRUCTION AREA SIGN (AS SHOWN). EXACT SIGN LOCATIONS, AND TIMING OF PLACEMENT, TO BE DETERMINED BY THE RESIDENT ENGINEER.
- PLACE CALTRANS STANDARD PLAN A73 TEMPORARY TYPE III BARRICADE WITH TEMPORARY SIGN (AS SHOWN)

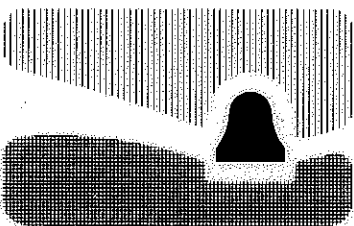

city of san luis obispo

HIGUERA STREET BRIDGE REPLACEMENT

APPROVED BY

CITY ENGINEER

DATE 3/2000

SCALE NONE

DESIGNED BY C. EBELING

DRAWN BY C. EBELING

CHECKED BY A. OLSON

APPROVED BY

UTILITIES DEPARTMENT

TRAFFIC DETOUR PLAN
HIGUERA STREET CLOSED
OSOS STREET OPEN

SPECIFICATION NO.

9367

FILE NO./LOCATION

0060 B

SHEET

17 of 41



DIST	COUNTY	ROUTE	POST MILES TOTAL PROJECT	SHEET NO.	TOTAL SHEETS
5	SLO		—	18	41

Ann Conner Olson
REGISTERED CIVIL ENGINEER
4/3/2000
PLANS APPROVAL DATE

MARTIN & KANE, Inc.
2200-B DOUGLAS BLVD, #150
ROSEVILLE • CA 95661



CONSTRUCTION AREA SIGNS

TYPE	PANEL SIZE	EACH	REMARKS
(A) C19	1200mm x 1200mm	2	MOUNT ON POST
(B) C1	1200mm x 1200mm	2	MOUNT ON POST
(C) C5 (L)	1200mm x 450mm	7	(2 ON BARRIER, 5 ON POST)
(D) R17B	750mm x 900mm	1	MOUNT ON POST
(E) R16B	750mm x 900mm	2	MOUNT ON POST
(F) C7	750mm x 600mm	2	MOUNT ON POST
(G) C2	1200mm x 750mm	4	1 ON POST, 1 ON BARRICADE, 2 ON K-RAIL
(H) C3A	1500mm x 750mm	2	1 ON POST, 1 ON BARRICADE
(I) C5 (R)	1200mm x 450mm	5	4 ON POST, 1 ON BARRICADE
(J) C14	1200mm x 600mm	2	MOUNT ON POST
(K) C23	1200mm x 1200mm	5	MOUNT ON POST
(L) G7-1 (MODIFIED)	400mm x 150mm	0	HIGUERA STREET MOUNT ON POST

NOTES:

- CONTRACTOR SHALL PLACE CALTRANS STANDARD PLAN A73 TYPE III BARRICADES ACROSS ENTIRE WIDTH OF STREET OR DRIVEWAY. SIGN C2 SHALL BE ATTACHED TO THE MIDDLE OF THE BARRICADE.
- CONTRACTOR SHALL PLACE CALTRANS STANDARD PLAN A73 STAGGERED TYPE III BARRICADES ACROSS WIDTH OF STREET TO ALLOW FOR LOCAL TRAFFIC MOVEMENT (INCLUDING PROVIDING ACCESS TO LOADING ZONES FOR LOCAL BUSINESSES). SIGNS C3A AND C5 (R) SHALL BE ATTACHED TO THE CENTER OF THE BARRICADE.
- TEMPORARY K-RAIL TO BE PLACED WHEN OSOS IS CLOSED (WITH C2 SIGNS). SEE STAGE 1 TRAFFIC STAGING PLANS FOR DETAILS.


GENERAL NOTES:

ALL SIGNS SHOWN ON THIS PLAN, EXCEPT FOR THOSE MOUNTED ON BARRICADES, SHALL BE MAINTAINED ONLY AS LONG AS DETOUR OR ROAD CONSTRUCTION IS IN EFFECT. WHEN THE SIGNS ARE NO LONGER NEEDED, THEY WILL BE COMPLETELY COVERED OR REMOVED BY THE CONTRACTOR.

ALL TEMPORARY SIGNS ON THIS PLAN INTENDED FOR NIGHTTIME USE SHALL HAVE REFLECTORIZED BACKGROUND AND/OR LEGEND AND BORDER DEPENDING ON THE STANDARDS FOR THAT PARTICULAR SIGN.

LEGEND:

- PLACE CONSTRUCTION AREA SIGN (AS SHOWN). EXACT SIGN LOCATIONS, AND TIMING OF PLACEMENT, TO BE DETERMINED BY THE RESIDENT ENGINEER.
- PLACE CALTRANS STANDARD PLAN A73 TEMPORARY TYPE III BARRICADE WITH TEMPORARY SIGN (AS SHOWN)

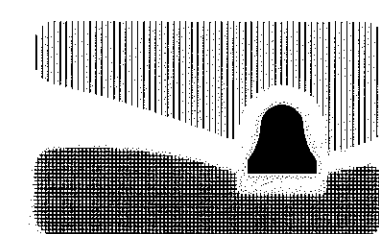

city of san luis obispo

HIGUERA STREET BRIDGE REPLACEMENT

APPROVED BY


CITY ENGINEER

DATE 3/2000
SCALE NONE
DESIGNED BY C. EBELING
DRAWN BY C. EBELING
CHECKED BY A. OLSON
APPROVED BY
UTILITIES DEPARTMENT

**TRAFFIC DETOUR PLAN
HIGUERA STREET OPEN
OSOS STREET CLOSED**

SPECIFICATION NO.
9367
FILE NO./LOCATION
6060 B
SHEET
18 of 41

\\NETWORK\NEIGHBORHOOD\WORKSERVER\PROJECTS\199\19/01/00 HIGUERA STREET BRIDGE REHAB\BRIDGE DRAWINGS\9/01/19/ISP-1.DWG March 1, 1999

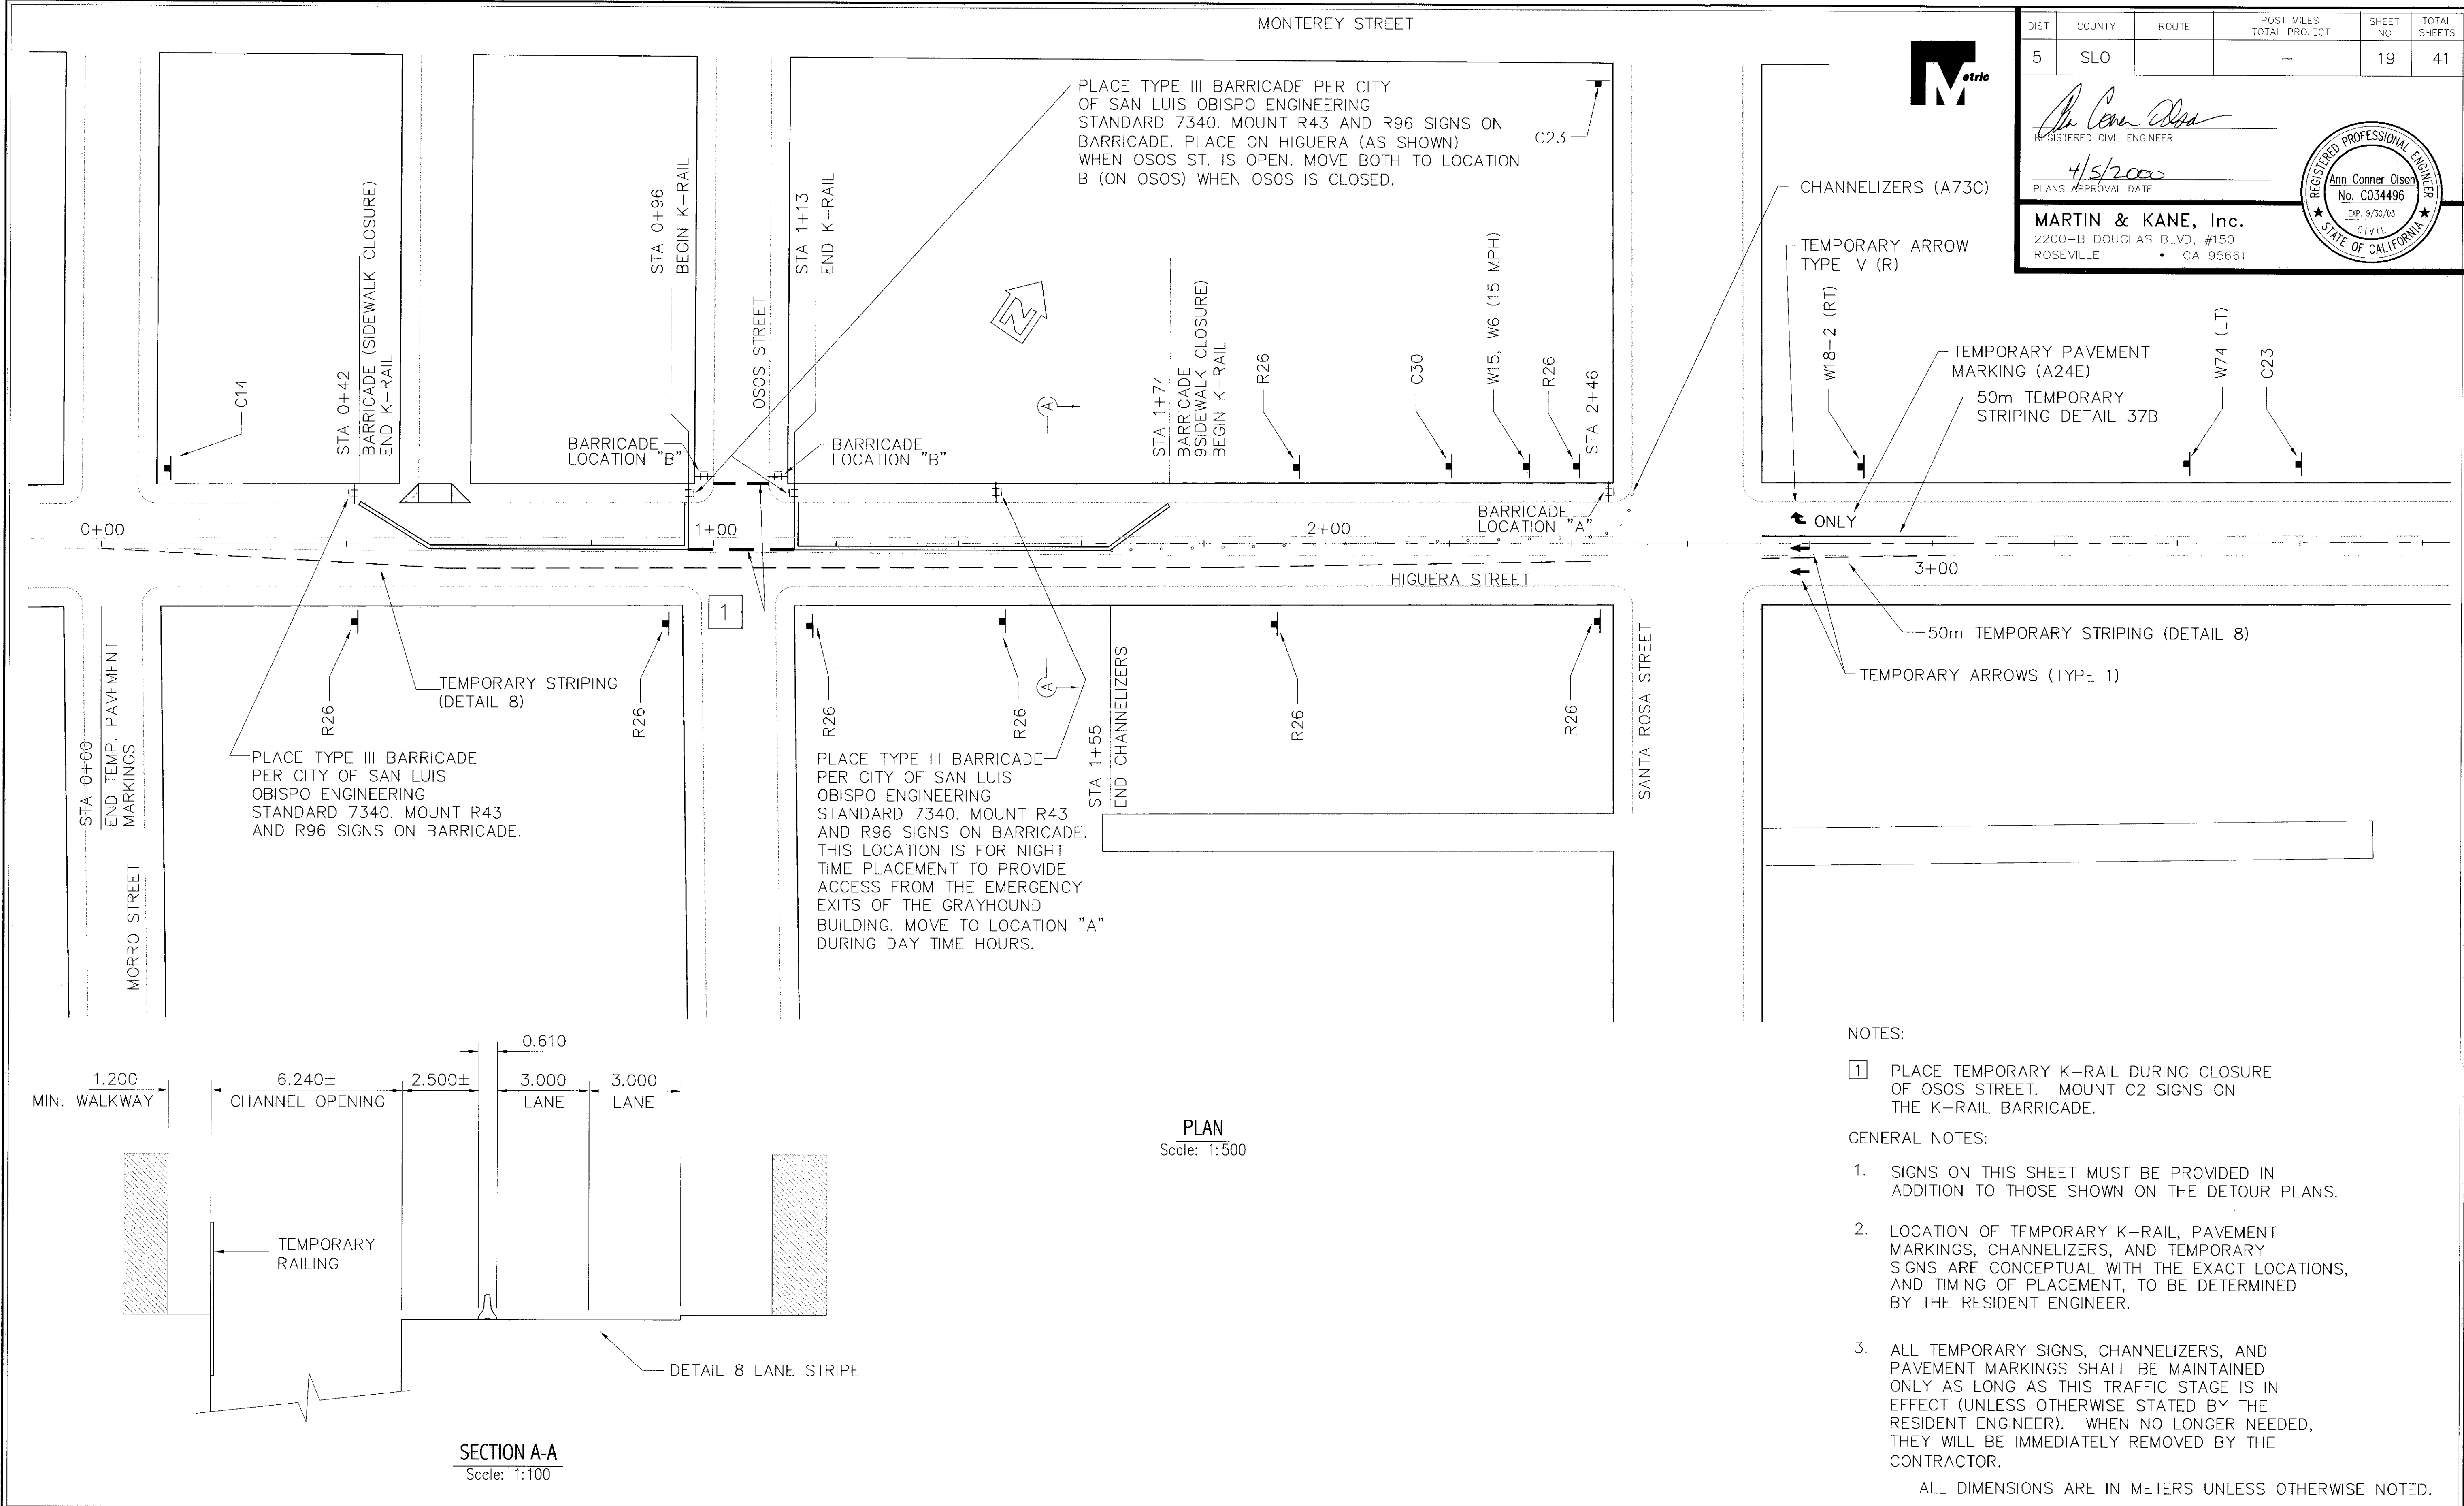

DIST	COUNTY	ROUTE	POST MILES TOTAL PROJECT	SHEET NO.	TOTAL SHEETS
5	SLO		—	19	41

REGISTERED CIVIL ENGINEER

4/5/2000

PLANS APPROVAL DATE

MARTIN & KANE, Inc.

2200-B DOUGLAS BLVD, #150
ROSEVILLE • CA 95661

REGISTERED PROFESSIONAL ENGINEER

Ann Conner Olson
No. C034496
EXP. 9/30/03
CIVIL
STATE OF CALIFORNIA



HIGUERA STREET BRIDGE REPLACEMENT

APPROVED BY

CITY ENGINEER

DATE 3/2000

SCALE 1:500

DESIGNED BY C. EBELING

DRAWN BY C. EBELING

CHECKED BY A. OLSON

APPROVED BY

UTILITIES DEPARTMENT

TRAFFIC STAGING PLAN

STAGE #1

SPECIFICATION NO. 9367

FILE NO./LOCATION 0060 B

SHEET 19 OF 41





NETWORK: NEIGHBORHOOD\WKSERVER\PROJECTS\1997\97017.00 HIGUERA STREET BRIDGE REHAB\BRIDGE DRAWINGS\97017-TSP-2.DWG March 1, 1999



DIST	COUNTY	ROUTE	POST MILES TOTAL PROJECT	SHEET NO.	TOTAL SHEETS
5	SLO		-	20	41

REGISTERED CIVIL ENGINEER
4/5/2000
PLANS APPROVAL DATE

MARTIN & KANE, Inc.
2200-B DOUGLAS BLVD., #150
ROSEVILLE • CA 95661

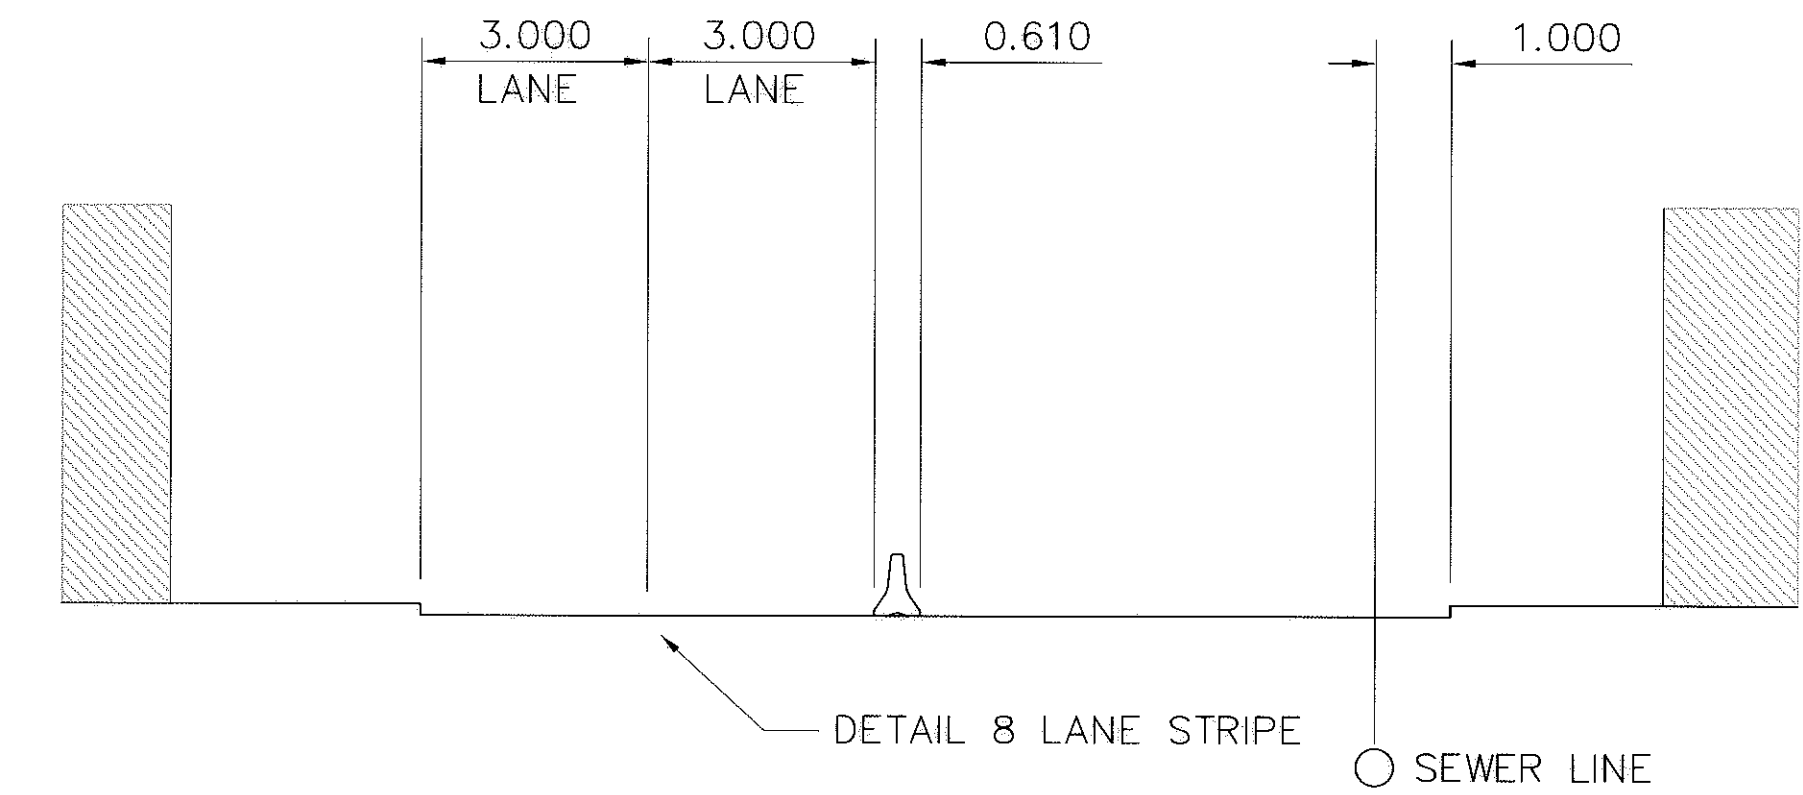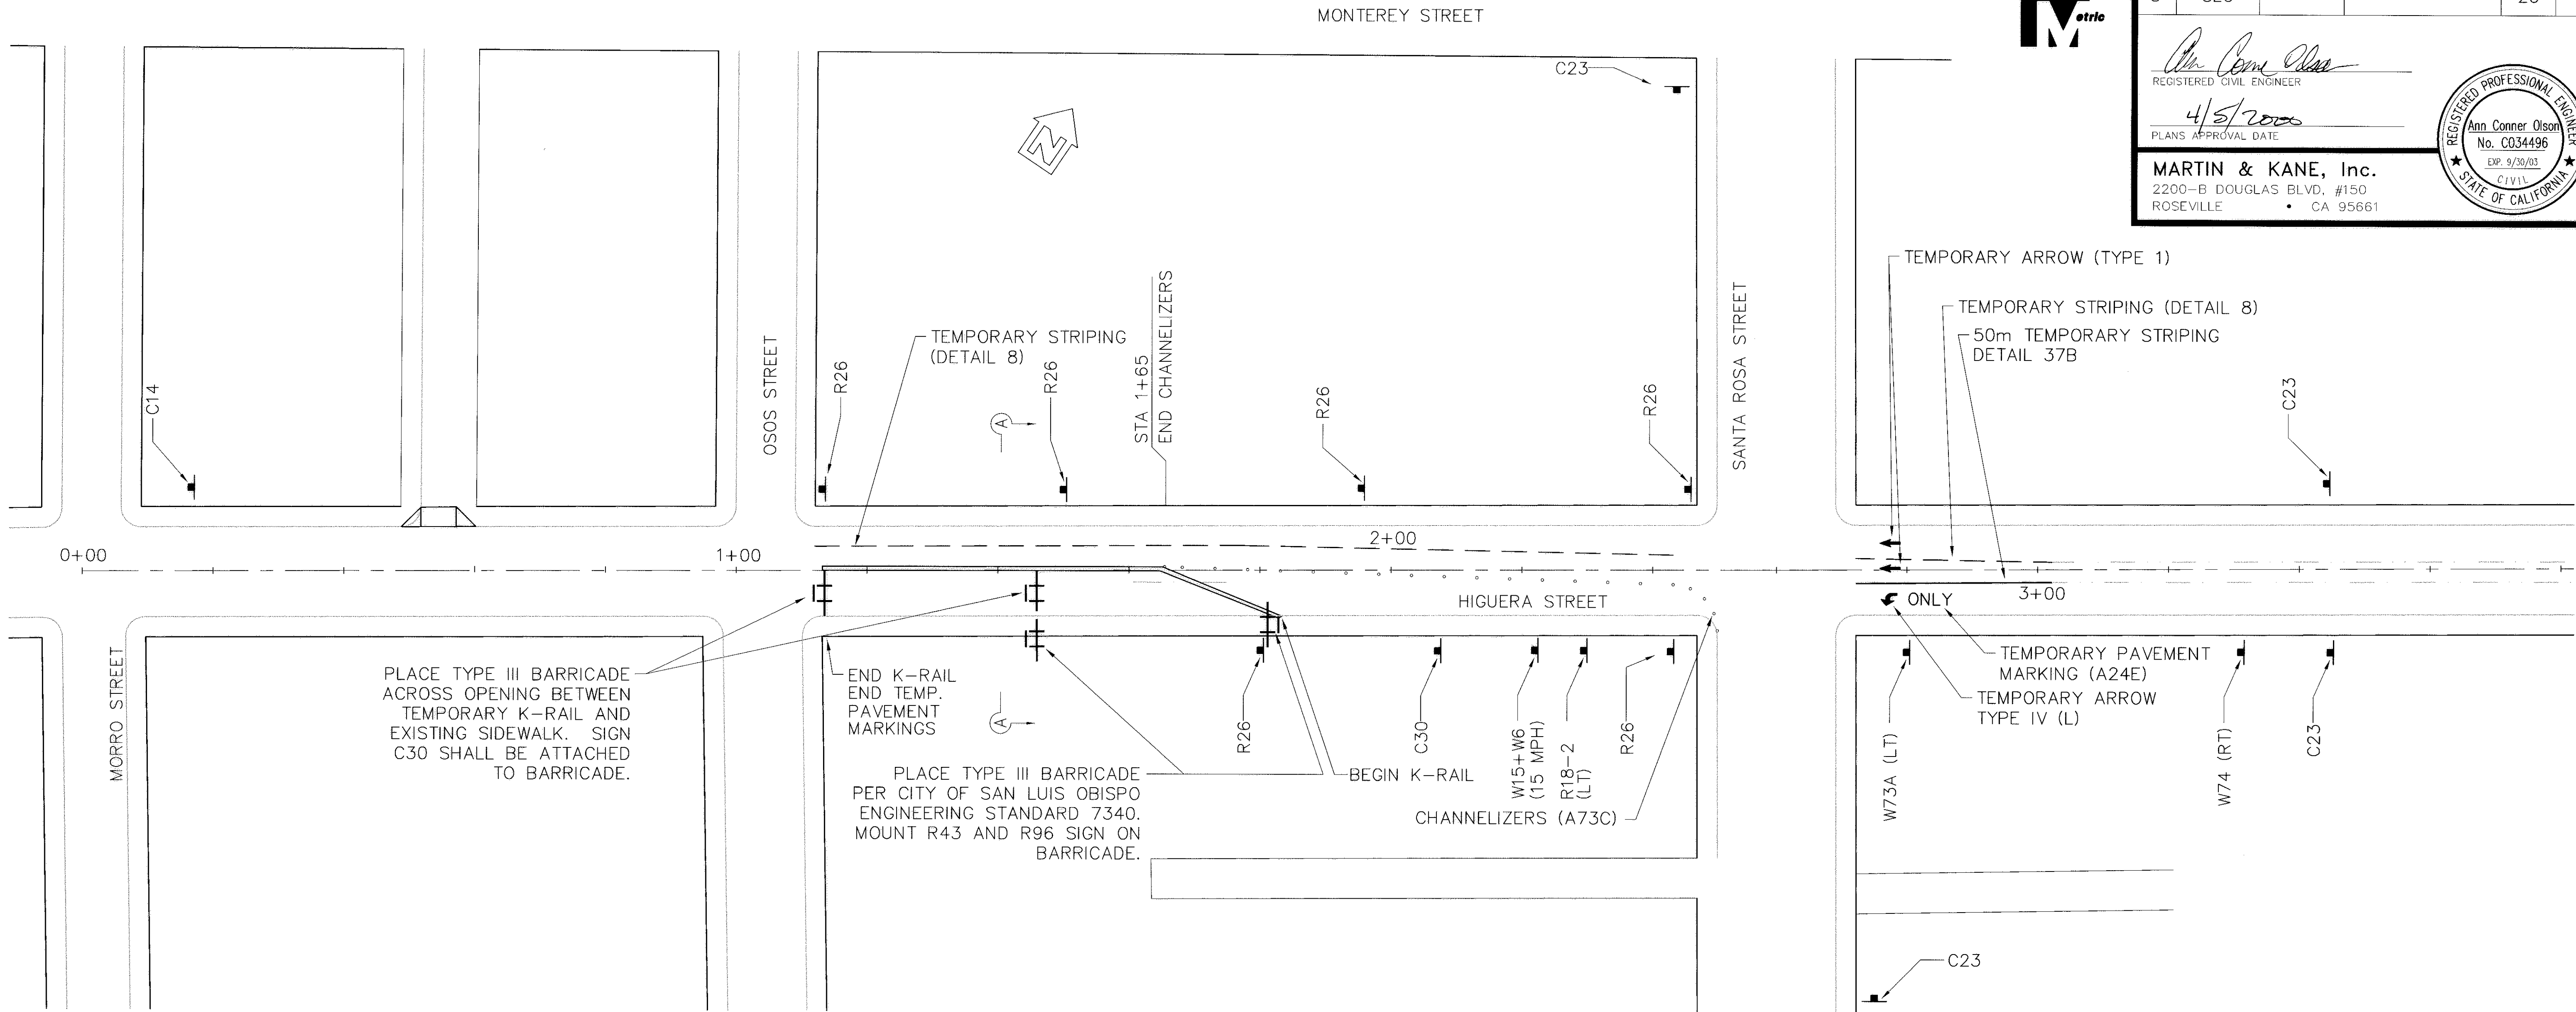


SECTION A-A
Scale: 1:100

PLAN
Scale: 1:500

- GENERAL NOTES:
- SIGNS ON THIS SHEET MUST BE PROVIDED IN ADDITION TO THOSE SHOWN ON THE DETOUR PLANS.
 - LOCATION OF TEMPORARY K-RAIL, PAVEMENT MARKINGS, CHANNELIZERS, AND TEMPORARY SIGNS ARE CONCEPTUAL WITH THE EXACT LOCATIONS, AND TIMING OF PLACEMENT, TO BE DETERMINED BY THE RESIDENT ENGINEER.
 - ALL TEMPORARY SIGNS, CHANNELIZERS, AND PAVEMENT MARKINGS SHALL BE MAINTAINED ONLY AS LONG AS THIS TRAFFIC STAGE IS IN EFFECT (UNLESS OTHERWISE STATED BY THE RESIDENT ENGINEER). WHEN NO LONGER NEEDED, THEY WILL BE IMMEDIATELY REMOVED BY THE CONTRACTOR.

ALL DIMENSIONS ARE IN METERS UNLESS OTHERWISE NOTED.

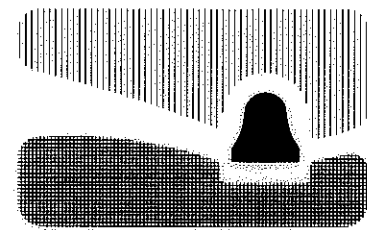

city of san luis obispo

HIGUERA STREET BRIDGE REPLACEMENT

APPROVED BY

CITY ENGINEER

DATE 3/2000
SCALE 1:500
DESIGNED BY C. EBELING
DRAWN BY C. EBELING
CHECKED BY A. OLSON
APPROVED BY
UTILITIES DEPARTMENT

TRAFFIC STAGING PLAN
STAGE #2

SPECIFICATION NO.
9367
FILE NO./LOCATION
0060 B
SHEET
20 OF 41

NETWORK: NEIGHBORHOOD\MSERVER\PROJECTS\1997\97017.00: HIGUERA STREET BRIDGE REHAB\BRIDGE DRAWINGS\97017-TSP-2.DWG March 1, 1999



DIST	COUNTY	ROUTE	POST MILES TOTAL PROJECT	SHEET NO.	TOTAL SHEETS
5	SLO		—	20	41



REGISTERED CIVIL ENGINEER

PLANS APPROVAL DATE

MARTIN & KANE, Inc.
2200-B DOUGLAS BLVD, #150
ROSEVILLE • CA 95661

REGISTERED PROFESSIONAL ENGINEER

Ann Conner Olson
No. C034496
Exp. 9/30/03
CIVIL
STATE OF CALIFORNIA

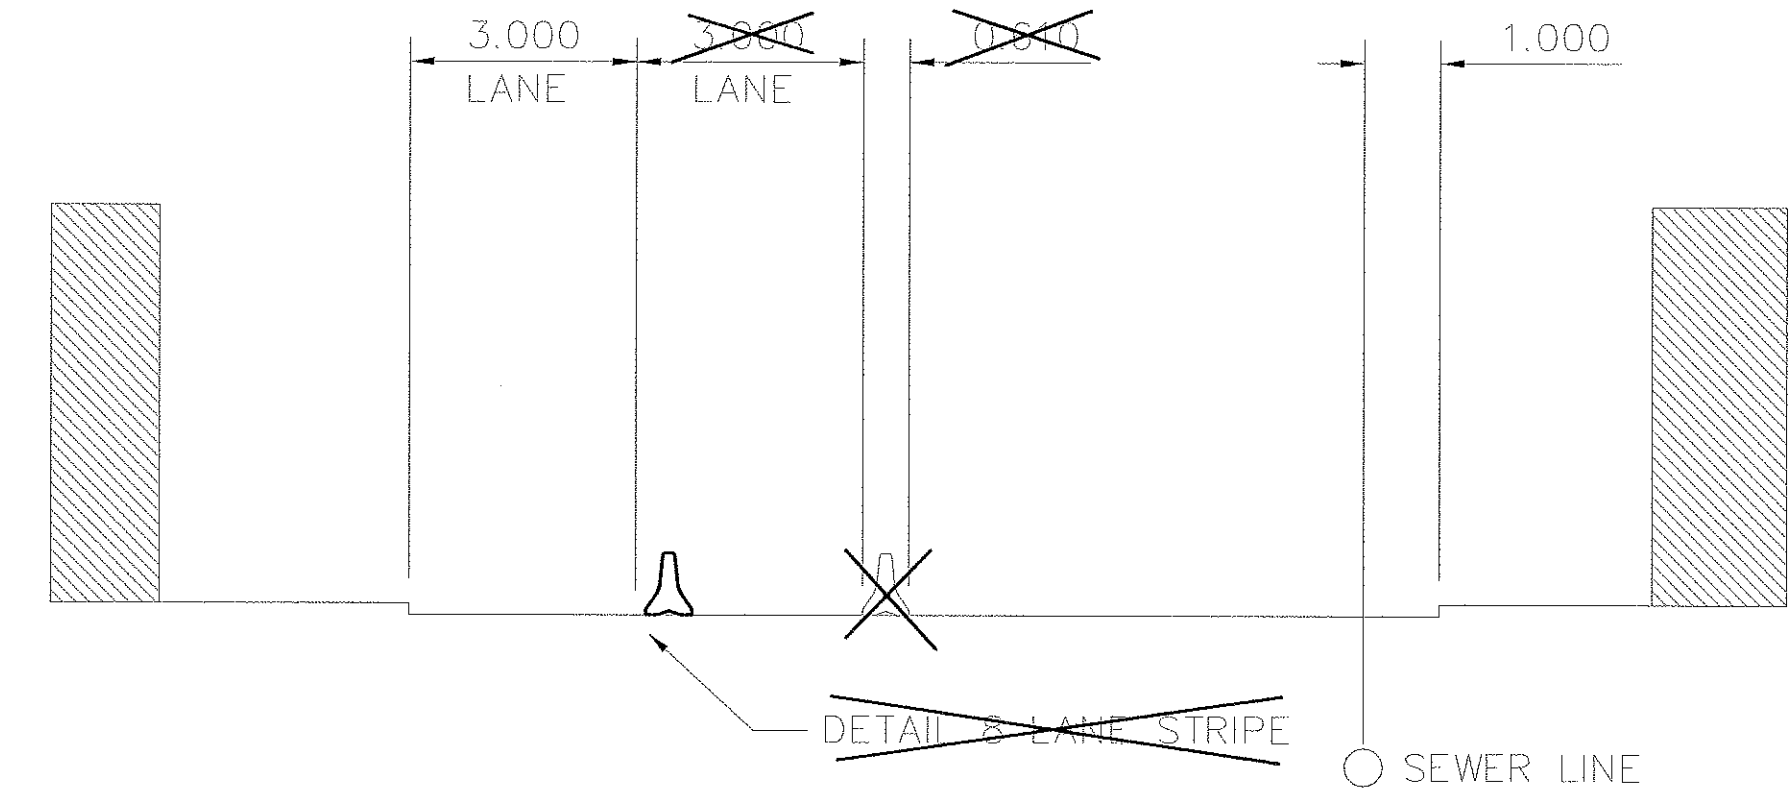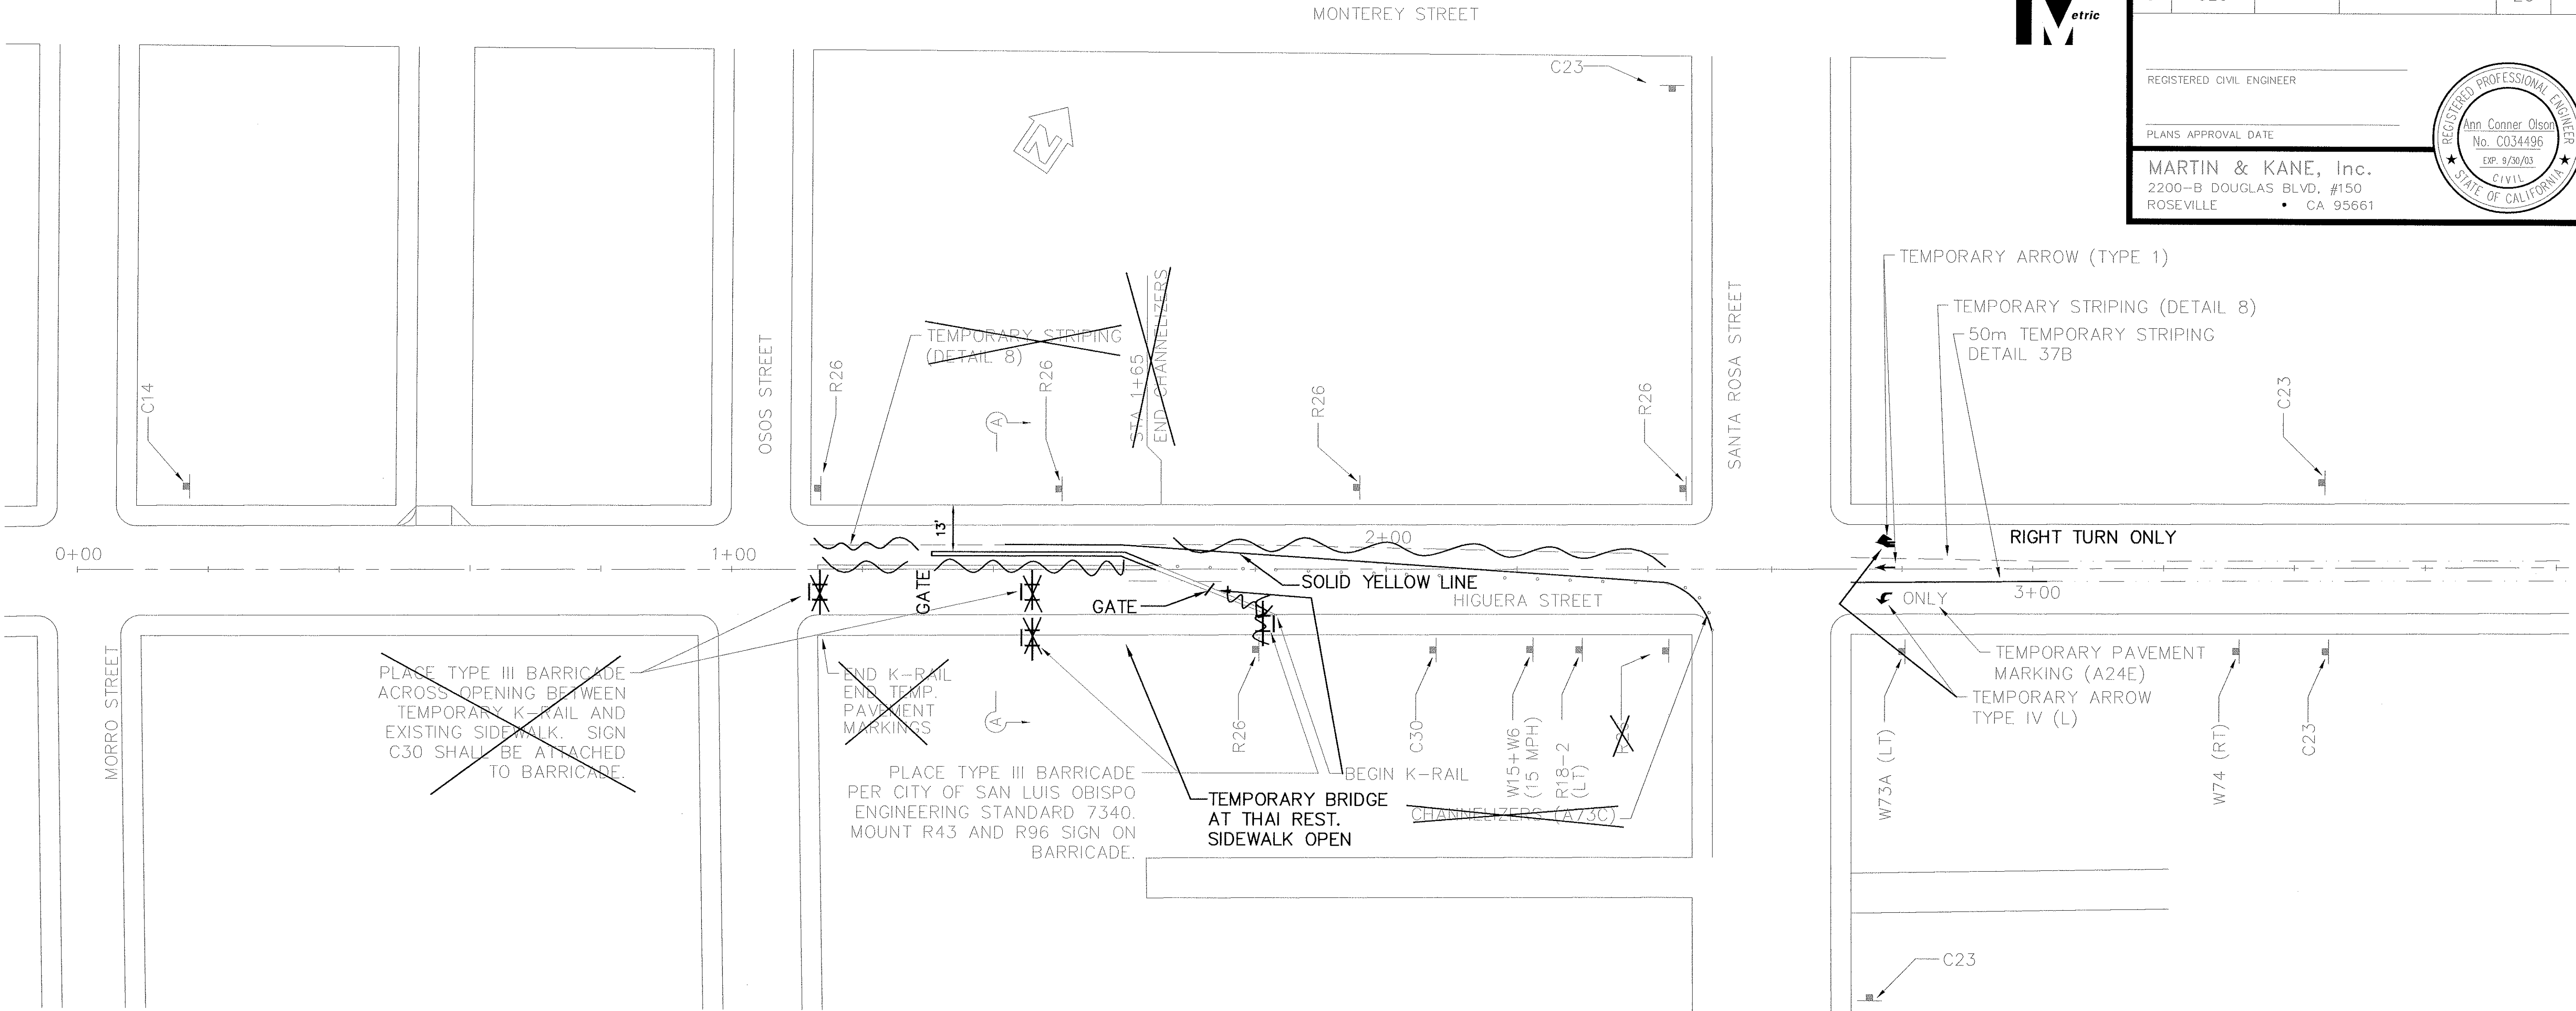

SECTION A-A
Scale: 1:100

PHASE 2
STAGE 1

PLAN
Scale: 1:500

- GENERAL NOTES:
1. SIGNS ON THIS SHEET MUST BE PROVIDED IN ADDITION TO THOSE SHOWN ON THE DETOUR PLANS.
 2. LOCATION OF TEMPORARY K-RAIL, PAVEMENT MARKINGS, CHANNELIZERS, AND TEMPORARY SIGNS ARE CONCEPTUAL WITH THE EXACT LOCATIONS, AND TIMING OF PLACEMENT, TO BE DETERMINED BY THE RESIDENT ENGINEER.
 3. ALL TEMPORARY SIGNS, CHANNELIZERS, AND PAVEMENT MARKINGS SHALL BE MAINTAINED ONLY AS LONG AS THIS TRAFFIC STAGE IS IN EFFECT (UNLESS OTHERWISE STATED BY THE RESIDENT ENGINEER). WHEN NO LONGER NEEDED, THEY WILL BE IMMEDIATELY REMOVED BY THE CONTRACTOR.

ALL DIMENSIONS ARE IN METERS UNLESS OTHERWISE NOTED.



HIGUERA STREET BRIDGE REPLACEMENT

APPROVED BY

CITY ENGINEER

DATE 3/2000
SCALE 1:500
DESIGNED BY C. EBELING
DRAWN BY C. EBELING
CHECKED BY A. OLSON
APPROVED BY
UTILITIES DEPARTMENT

TRAFFIC STAGING PLAN
STAGE #1
PHASE #2

SPECIFICATION NO. 9367
FILE NO./LOCATION 0060 B
SHEET 20R of 41

N:\WORK\1\WK PROJECTS\1997\97017.00 HIGUERA STREET BRIDGE REHAB DRAWINGS (NOVEMBER 1999)\BRIDGE DRAWINGS (11-23-99)\97017-1-GP.dwg 1/18/00




DIST	COUNTY	ROUTE	POST MILES TOTAL PROJECT	SHEET NO.	TOTAL SHEETS
5	SLO		-	21	41

Ronald L. Rivett
REGISTERED CIVIL ENGINEER

4/9/00
PLANS APPROVAL DATE

MARTIN & KANE, Inc.
2200-B DOUGLAS BLVD, #150
ROSEVILLE • CA 95661

REGISTERED PROFESSIONAL ENGINEER
Ronald L. Rivett
No. 31,269
EXP. 12/31/00
CIVIL
STATE OF CALIFORNIA


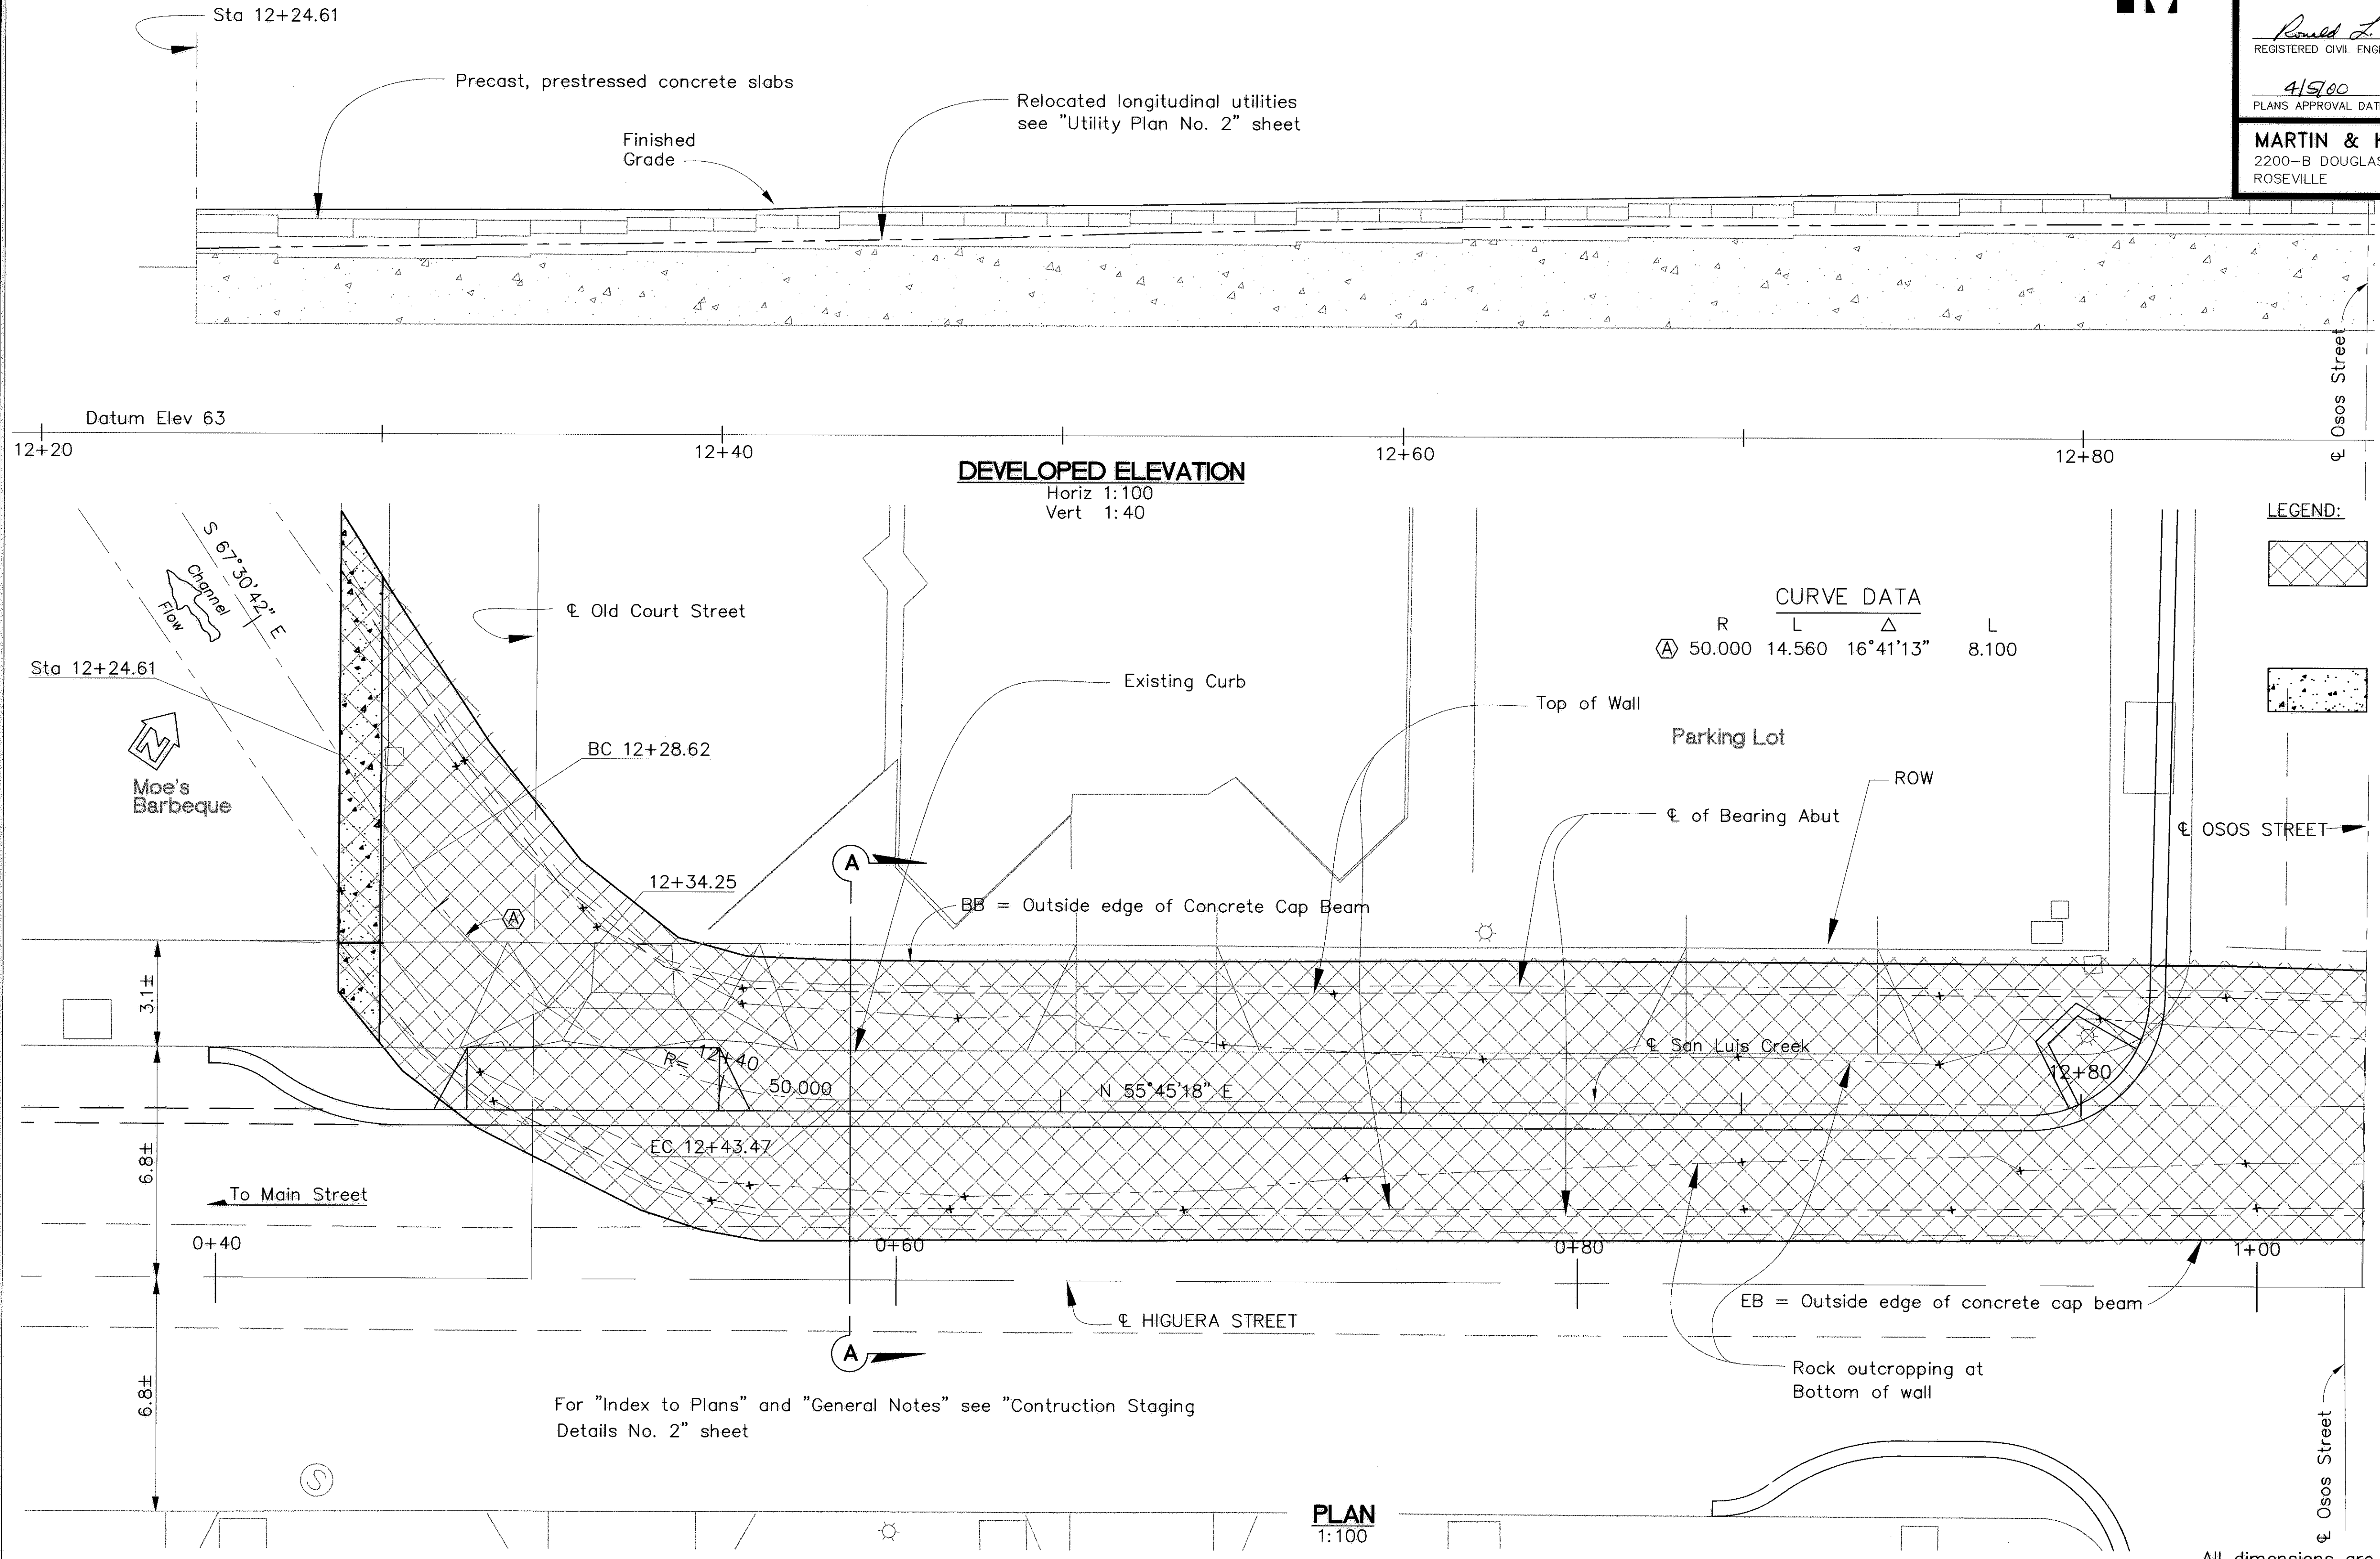


DIST	COUNTY	ROUTE	POST MILES TOTAL PROJECT	SHEET NO.	TOTAL SHEETS
5	SLO		—	22	41

Ronald L. Swett
REGISTERED CIVIL ENGINEER


4/5/00
PLANS APPROVAL DATE

MARTIN & KANE, Inc.
2200-B DOUGLAS BLVD, #150
ROSEVILLE • CA 95661

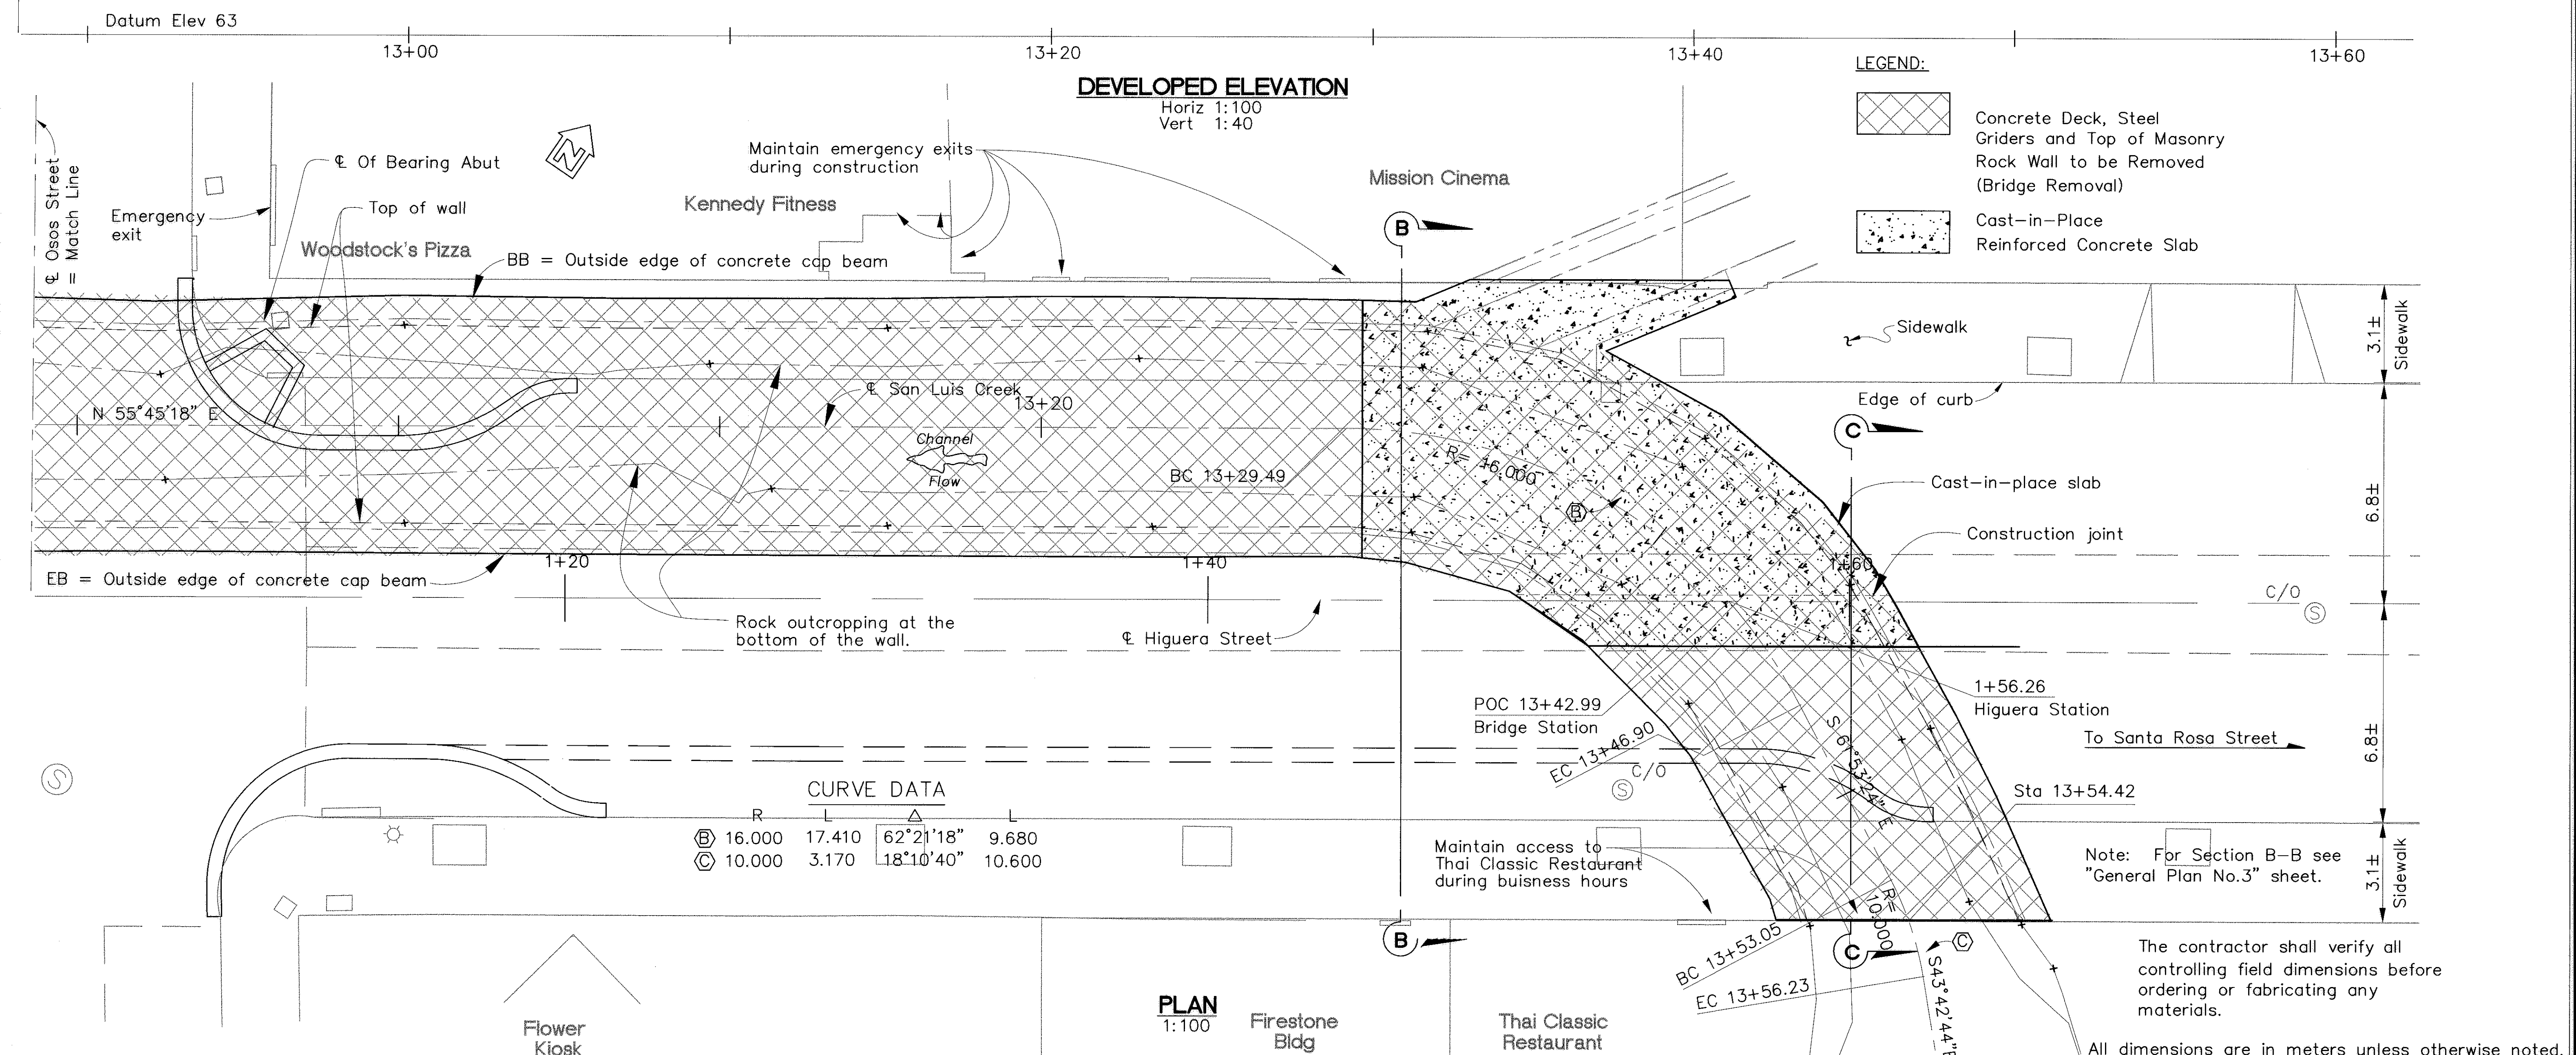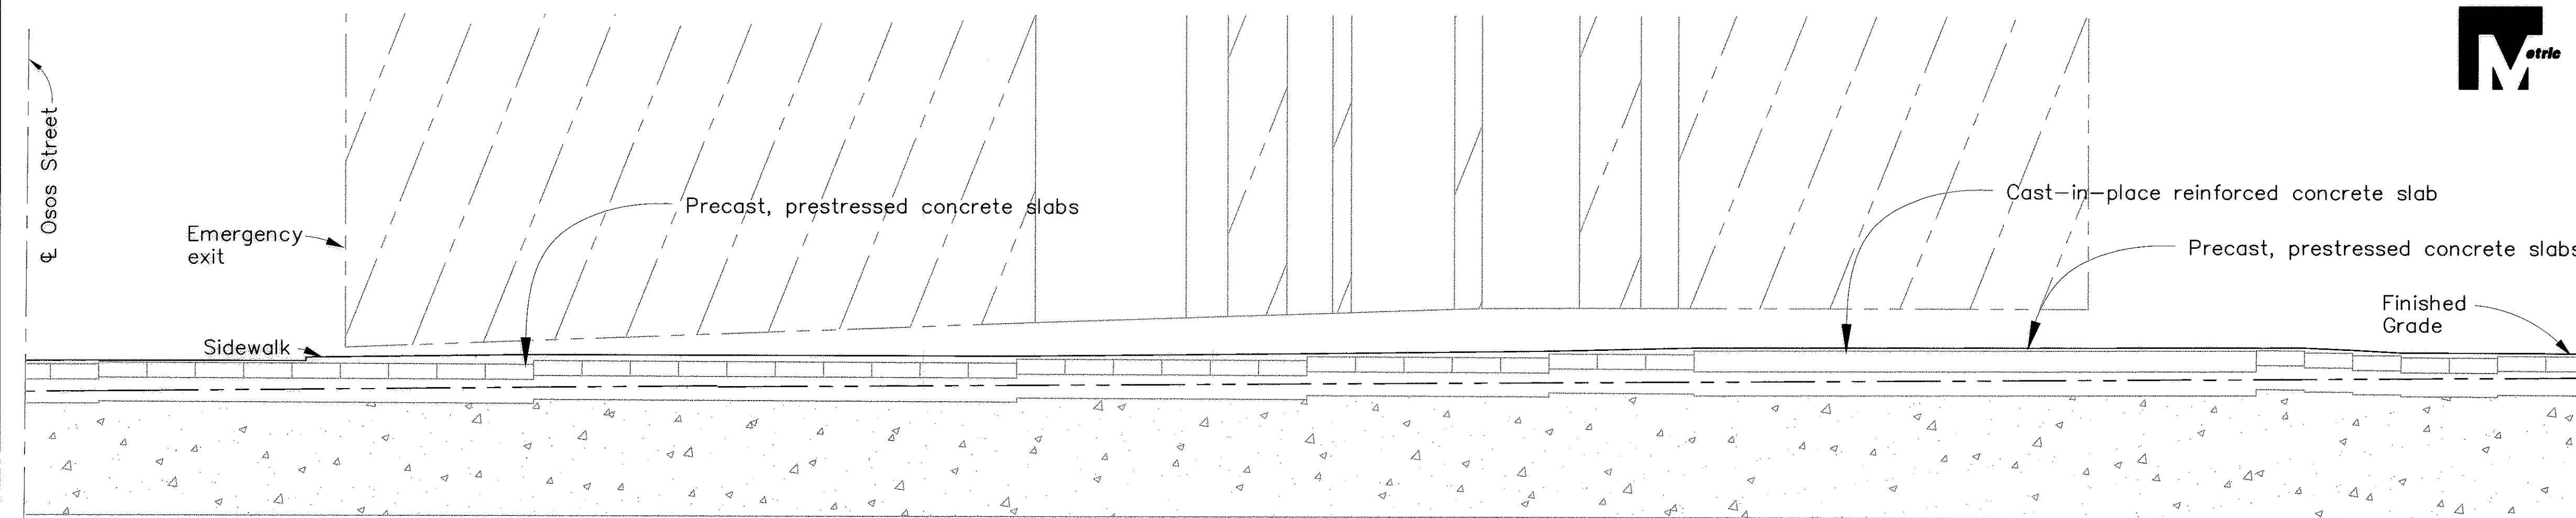

HIGUERA STREET BRIDGE REPLACEMENT

 FOR REDUCED PLANS
ORIGINAL SCALE IS IN MILLIMETERS



0 20 40 60 80 100

APPROVED BY

CITY ENGINEER

DATE	3/2000
SCALE	As Noted
DESIGNED BY	R.F.
DRAWN BY	R.D., K.W.
CHECKED BY	R.R.
APPROVED BY	
UTILITIES DEPARTMENT	


GENERAL PLAN NO. 2

SPECIFICATION NO.
9367

FILE NO./LOCATION
0060 B

SHEET
22 OF 41


N:\MKSRV1\WK PROJECTS\1997\97017.00 HIGUERA STREET BRIDGE REHAB\DRAWINGS (11-23-99)\97017-1-GP.dwg 1/18/00

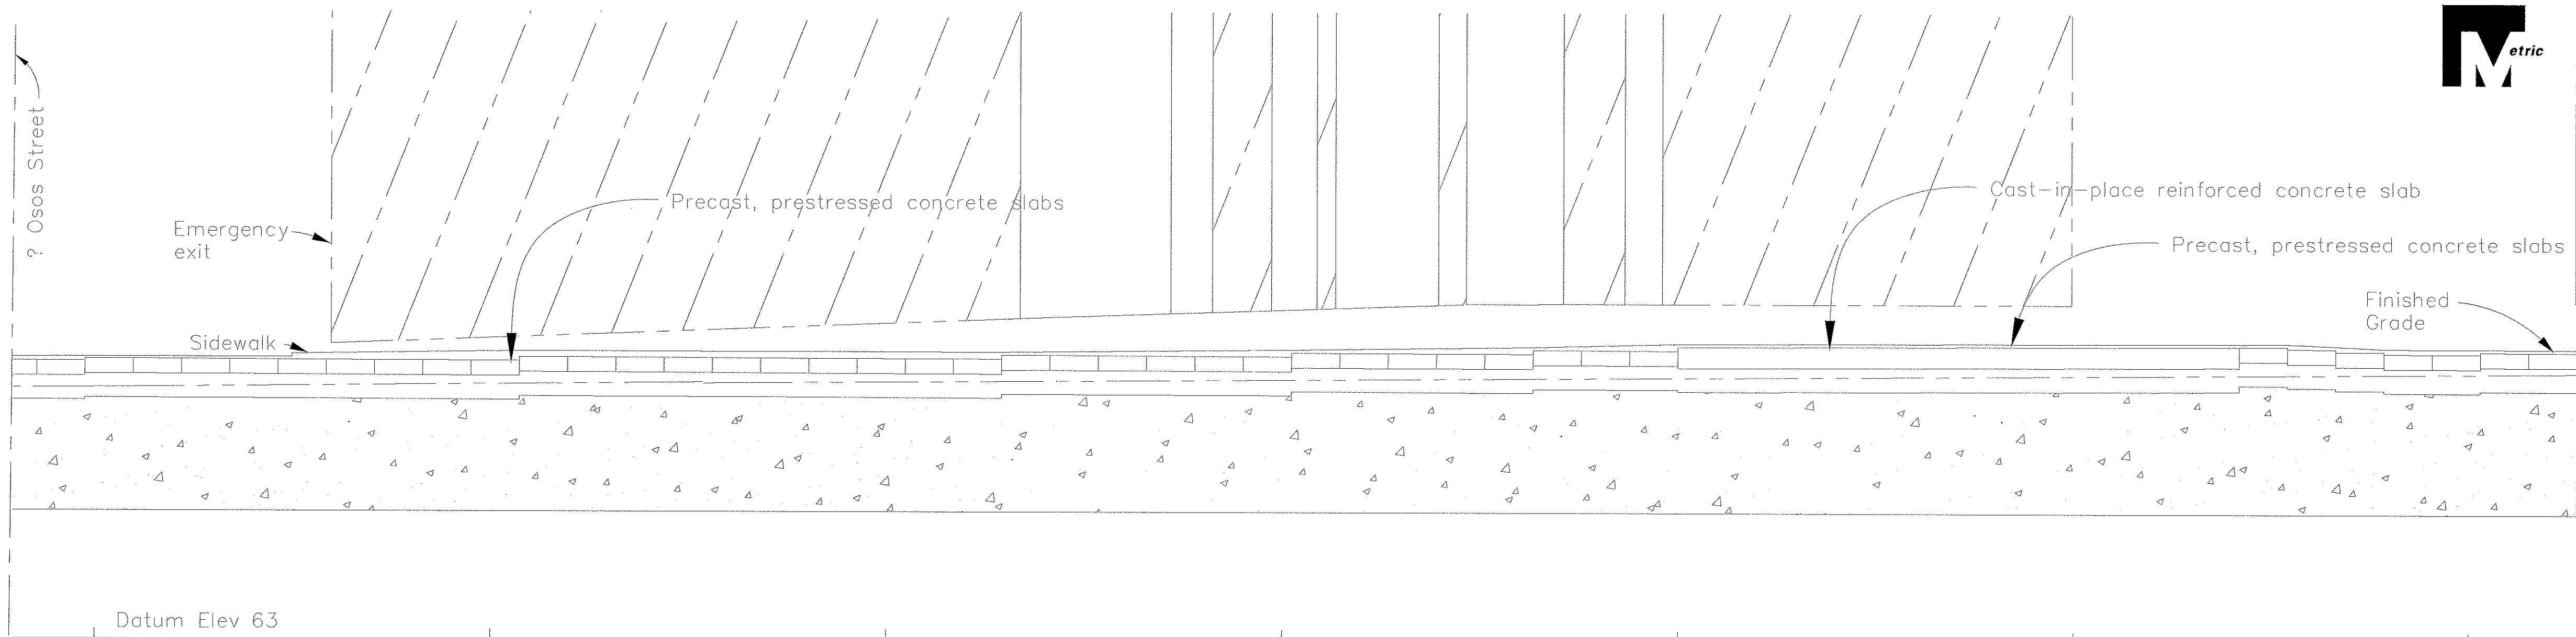

DEVELOPED ELEVATION

Horiz 1:100
Vert 1:40


LEGEND:

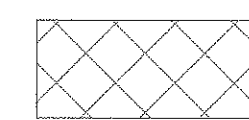

Concrete Deck, Steel
Grids and Top of Masonry
Rock Wall to be Removed
(Bridge Removal)




Cast-in-Place
Reinforced Concrete Slab

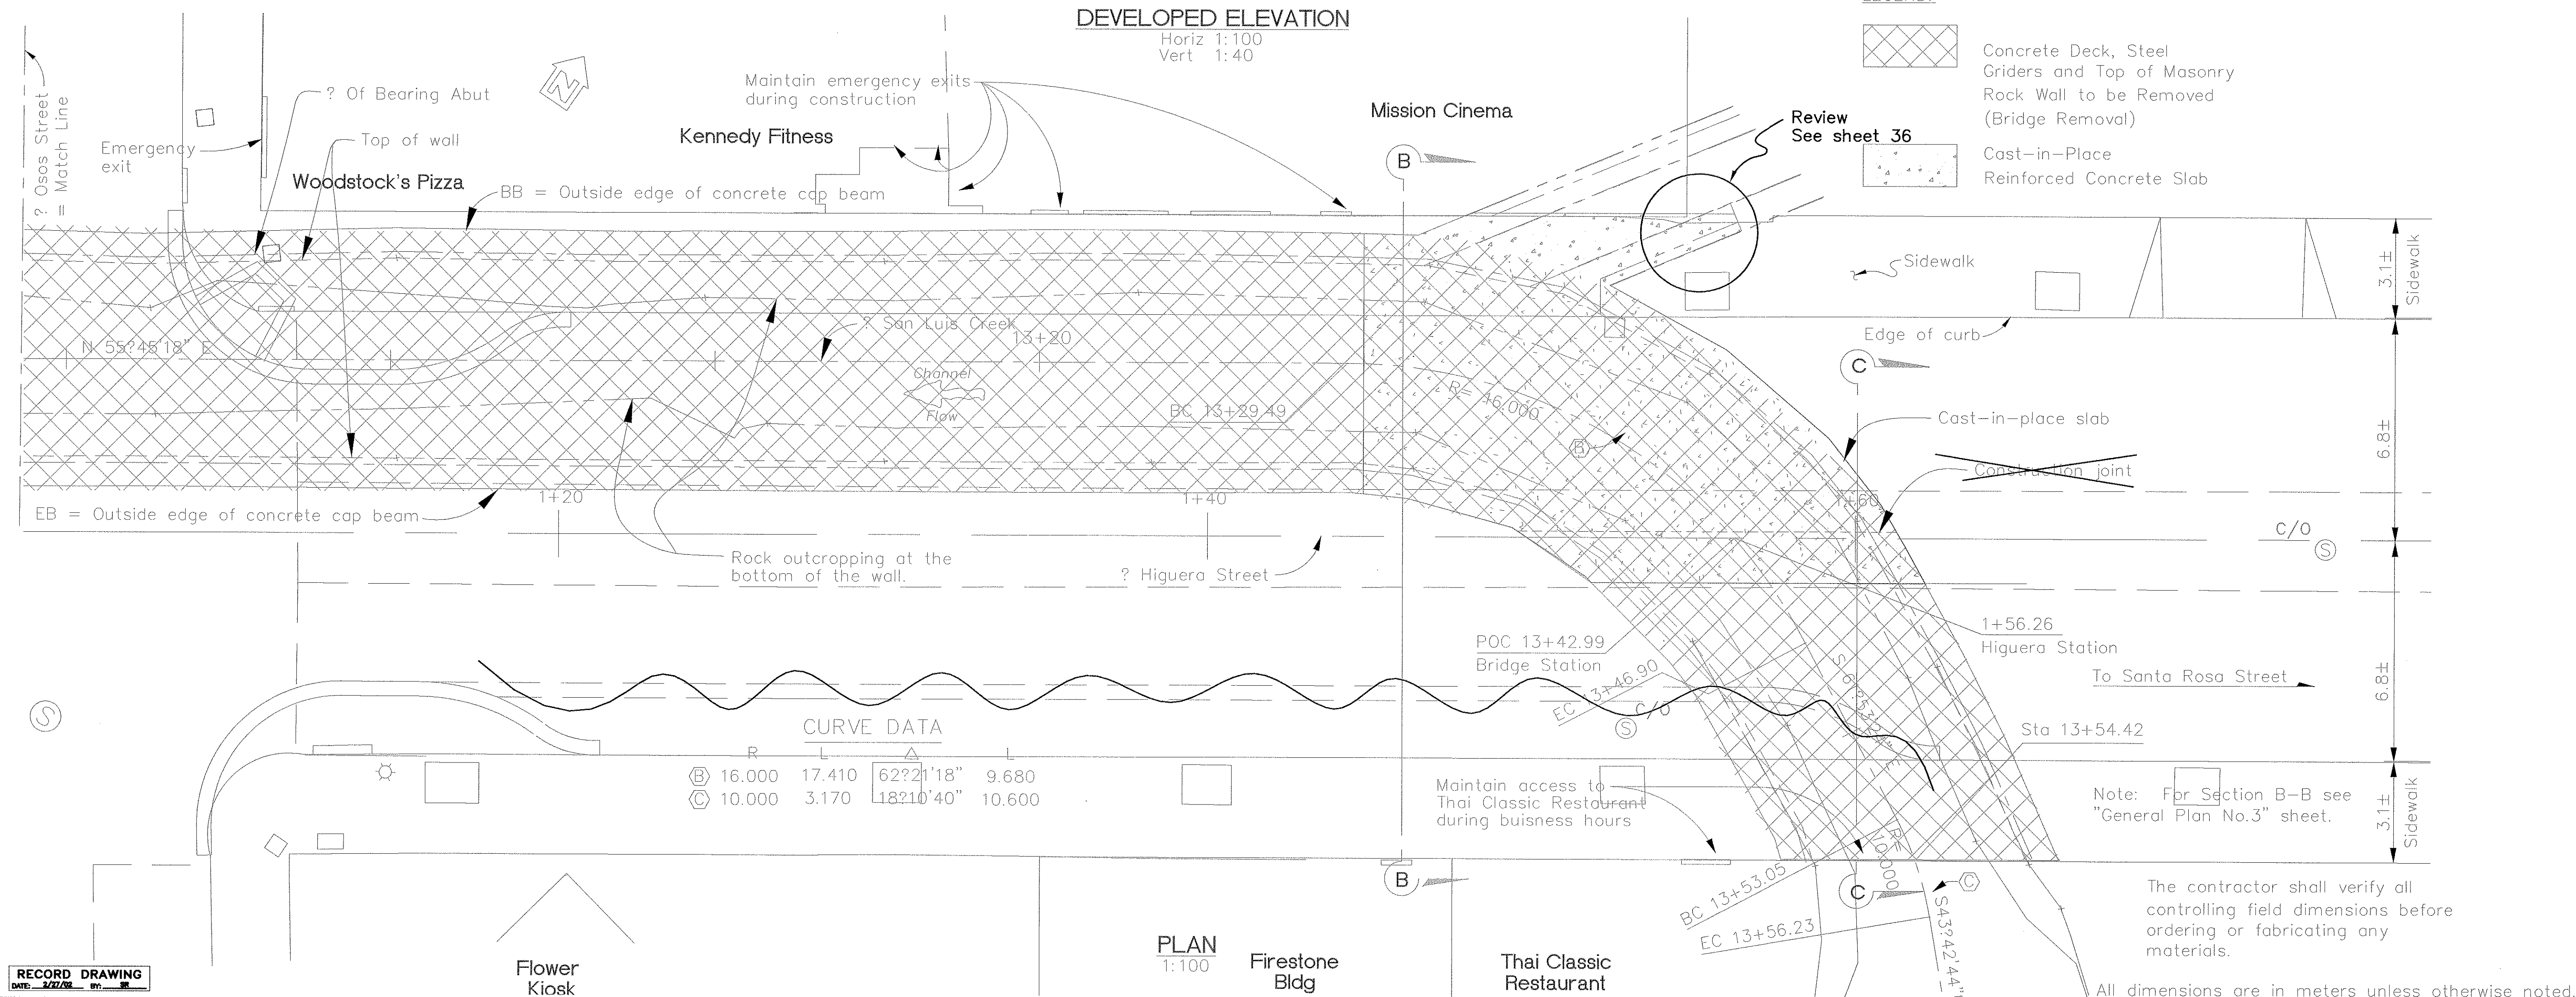

CURVE DATA

	R	L	Δ	L
B	16.000	17.410	62°21'18"	9.680
C	10.000	3.170	182°10'40"	10.600

RECORD DRAWING
DATE: 9/2/00 BY: [signature]

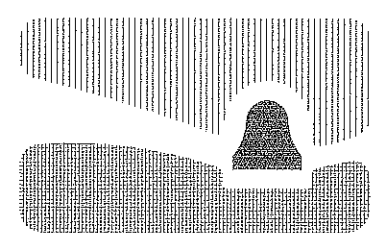

city of san luis OBISPO

HIGUERA STREET BRIDGE REPLACEMENT

FOR REDUCED PLANS
ORIGINAL SCALE IS IN MILLIMETERS



APPROVED BY

CITY ENGINEER

DATE 3/2000
SCALE As Noted
DESIGNED BY R.F.
DRAWN BY R.D., K.W.
CHECKED BY R.R.
APPROVED BY
UTILITIES DEPARTMENT

GENERAL PLAN NO. 2

SPECIFICATION NO.

9367


FILE NO./LOCATION

0060 B


SHEET

22 R of 41


N:\MSR\RT\WK PROJECTS\1997\97017.00 HIGUERA STREET BRIDGE REHA\DRAWINGS (11-23-99)\97017-1-GP.dwg 1/18/00

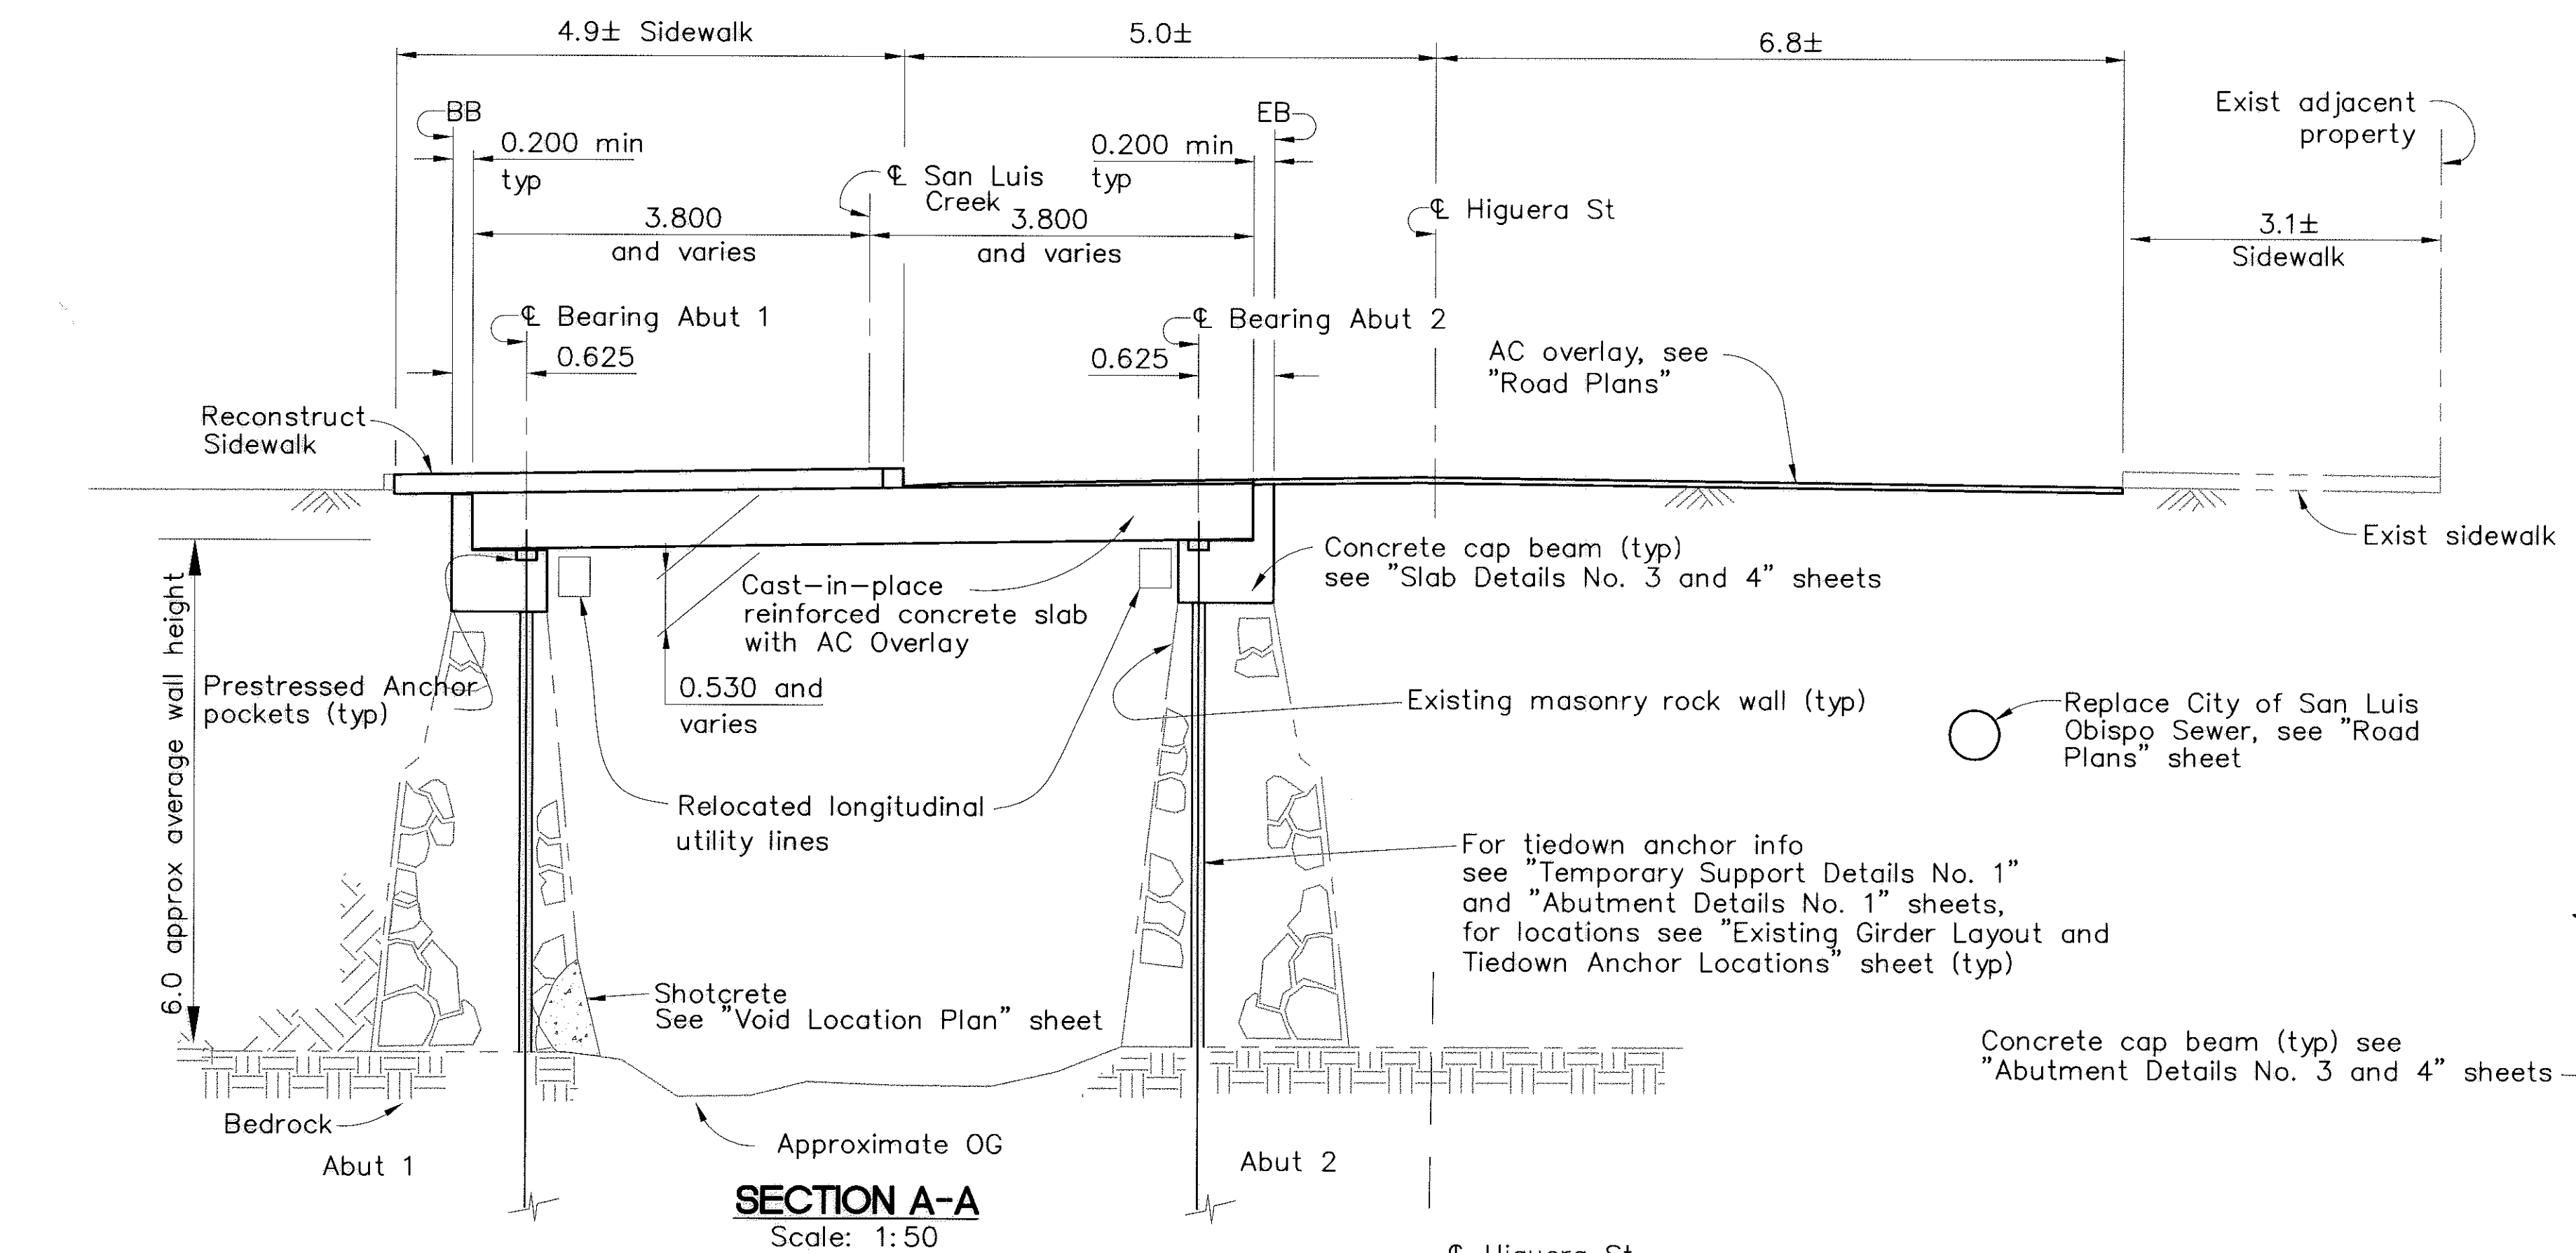

SECTION A-A
Scale: 1:50

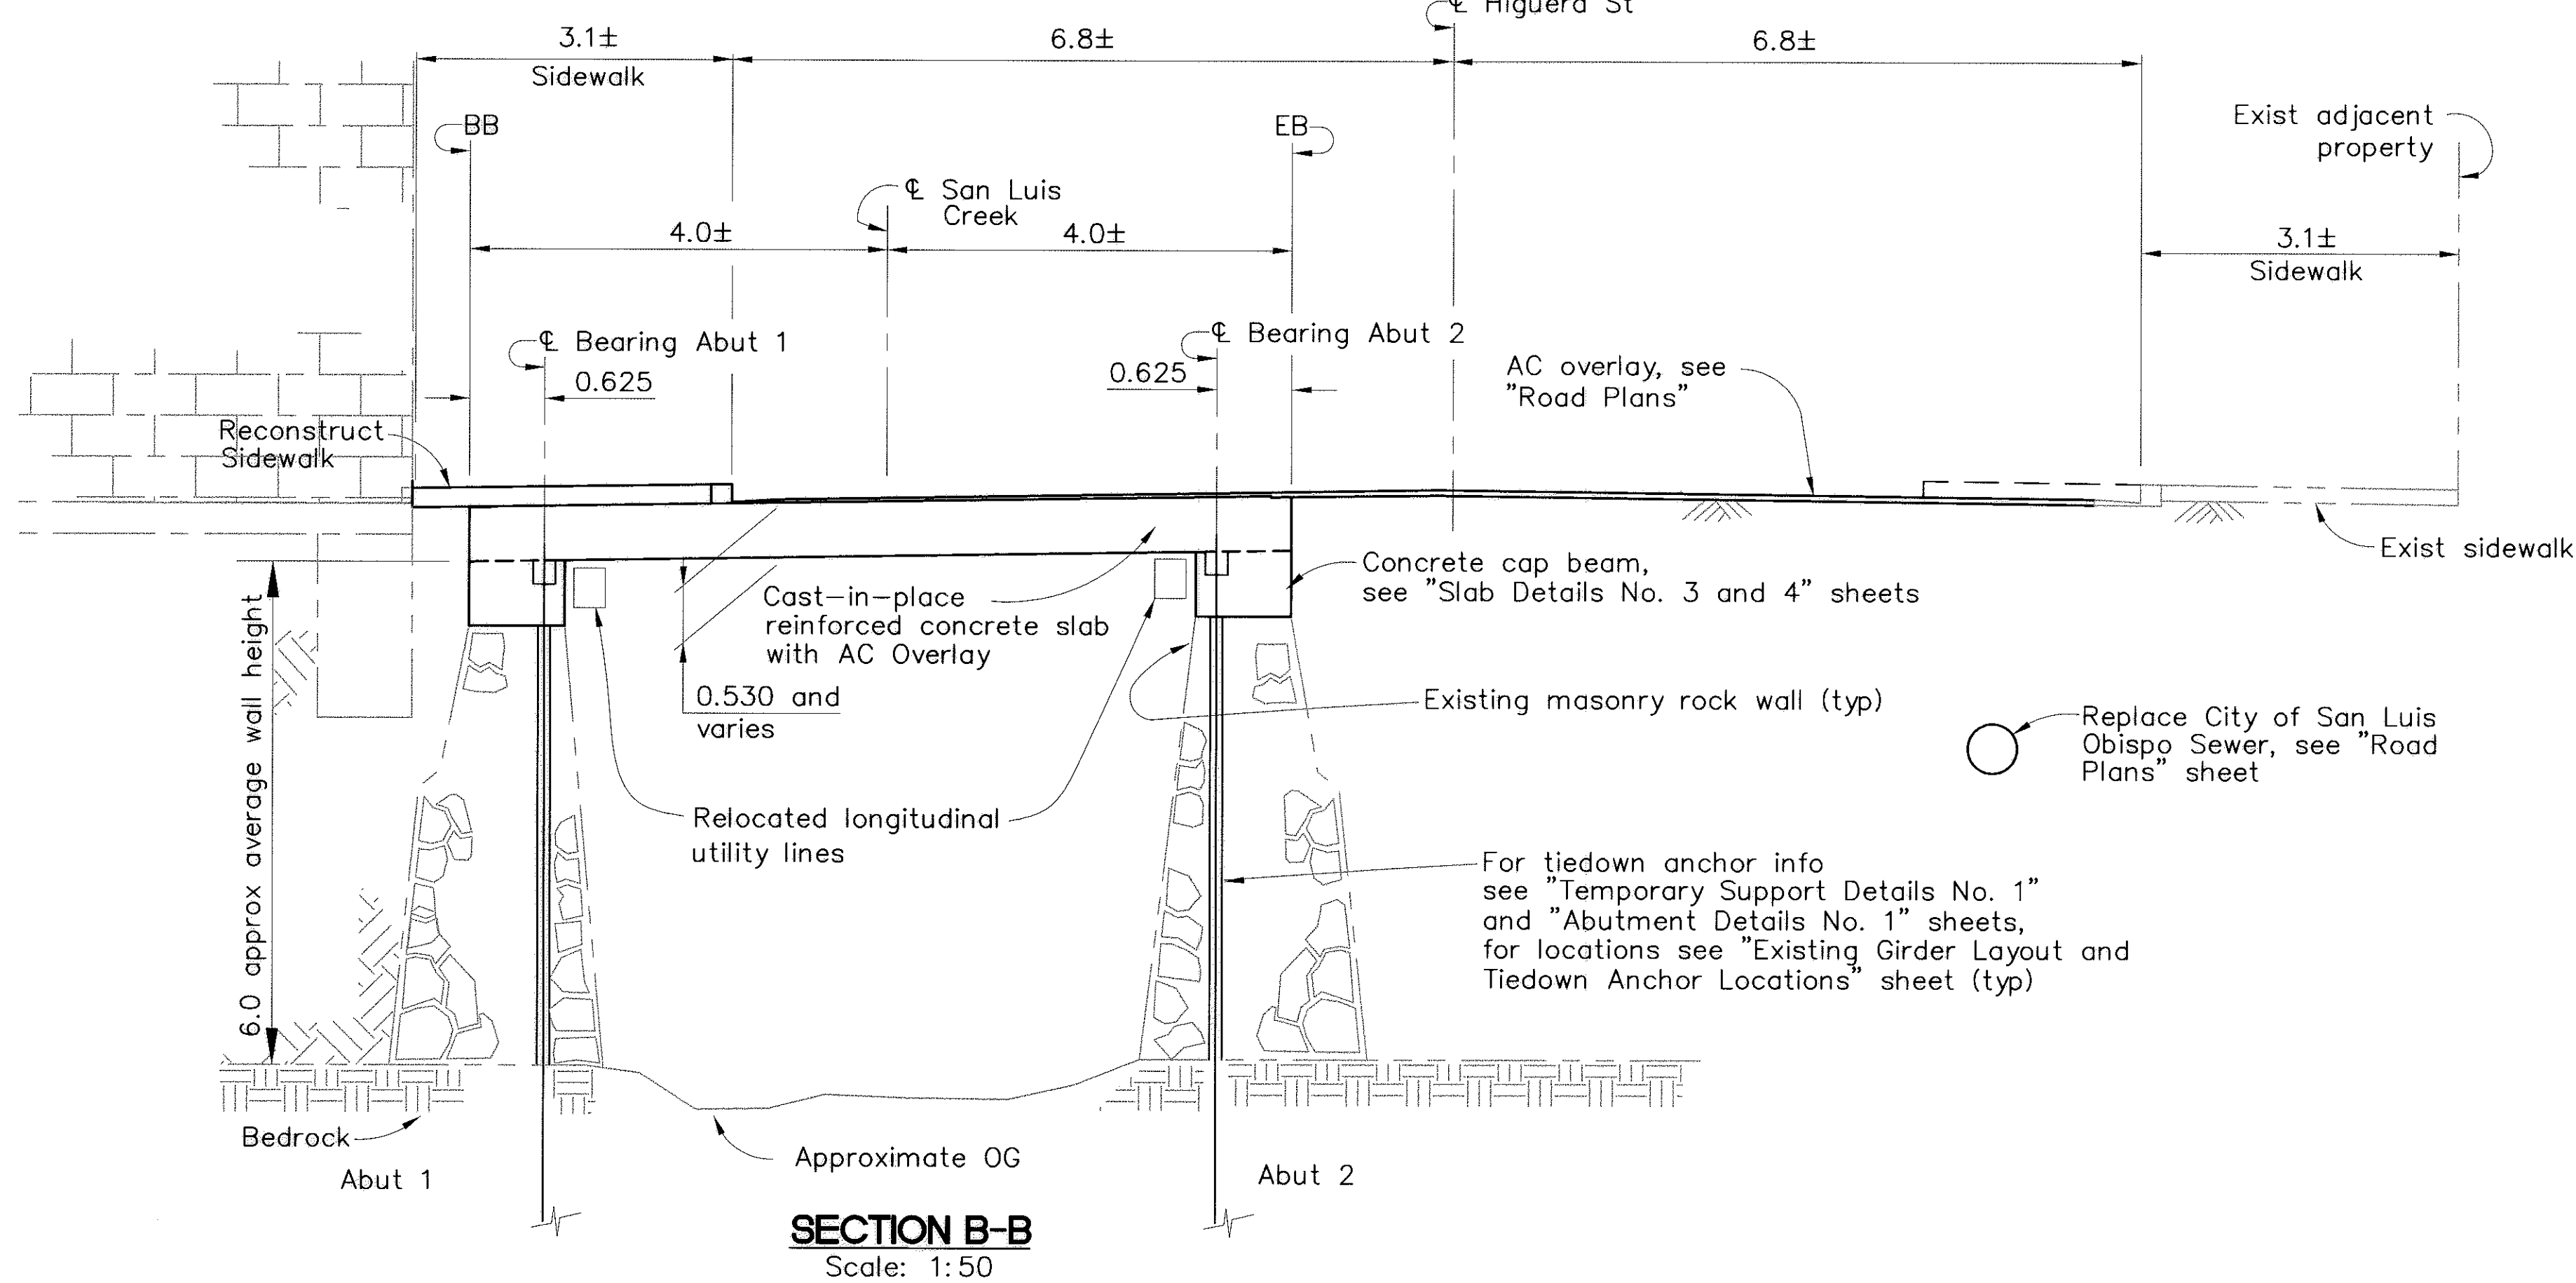

SECTION B-B
Scale: 1:50

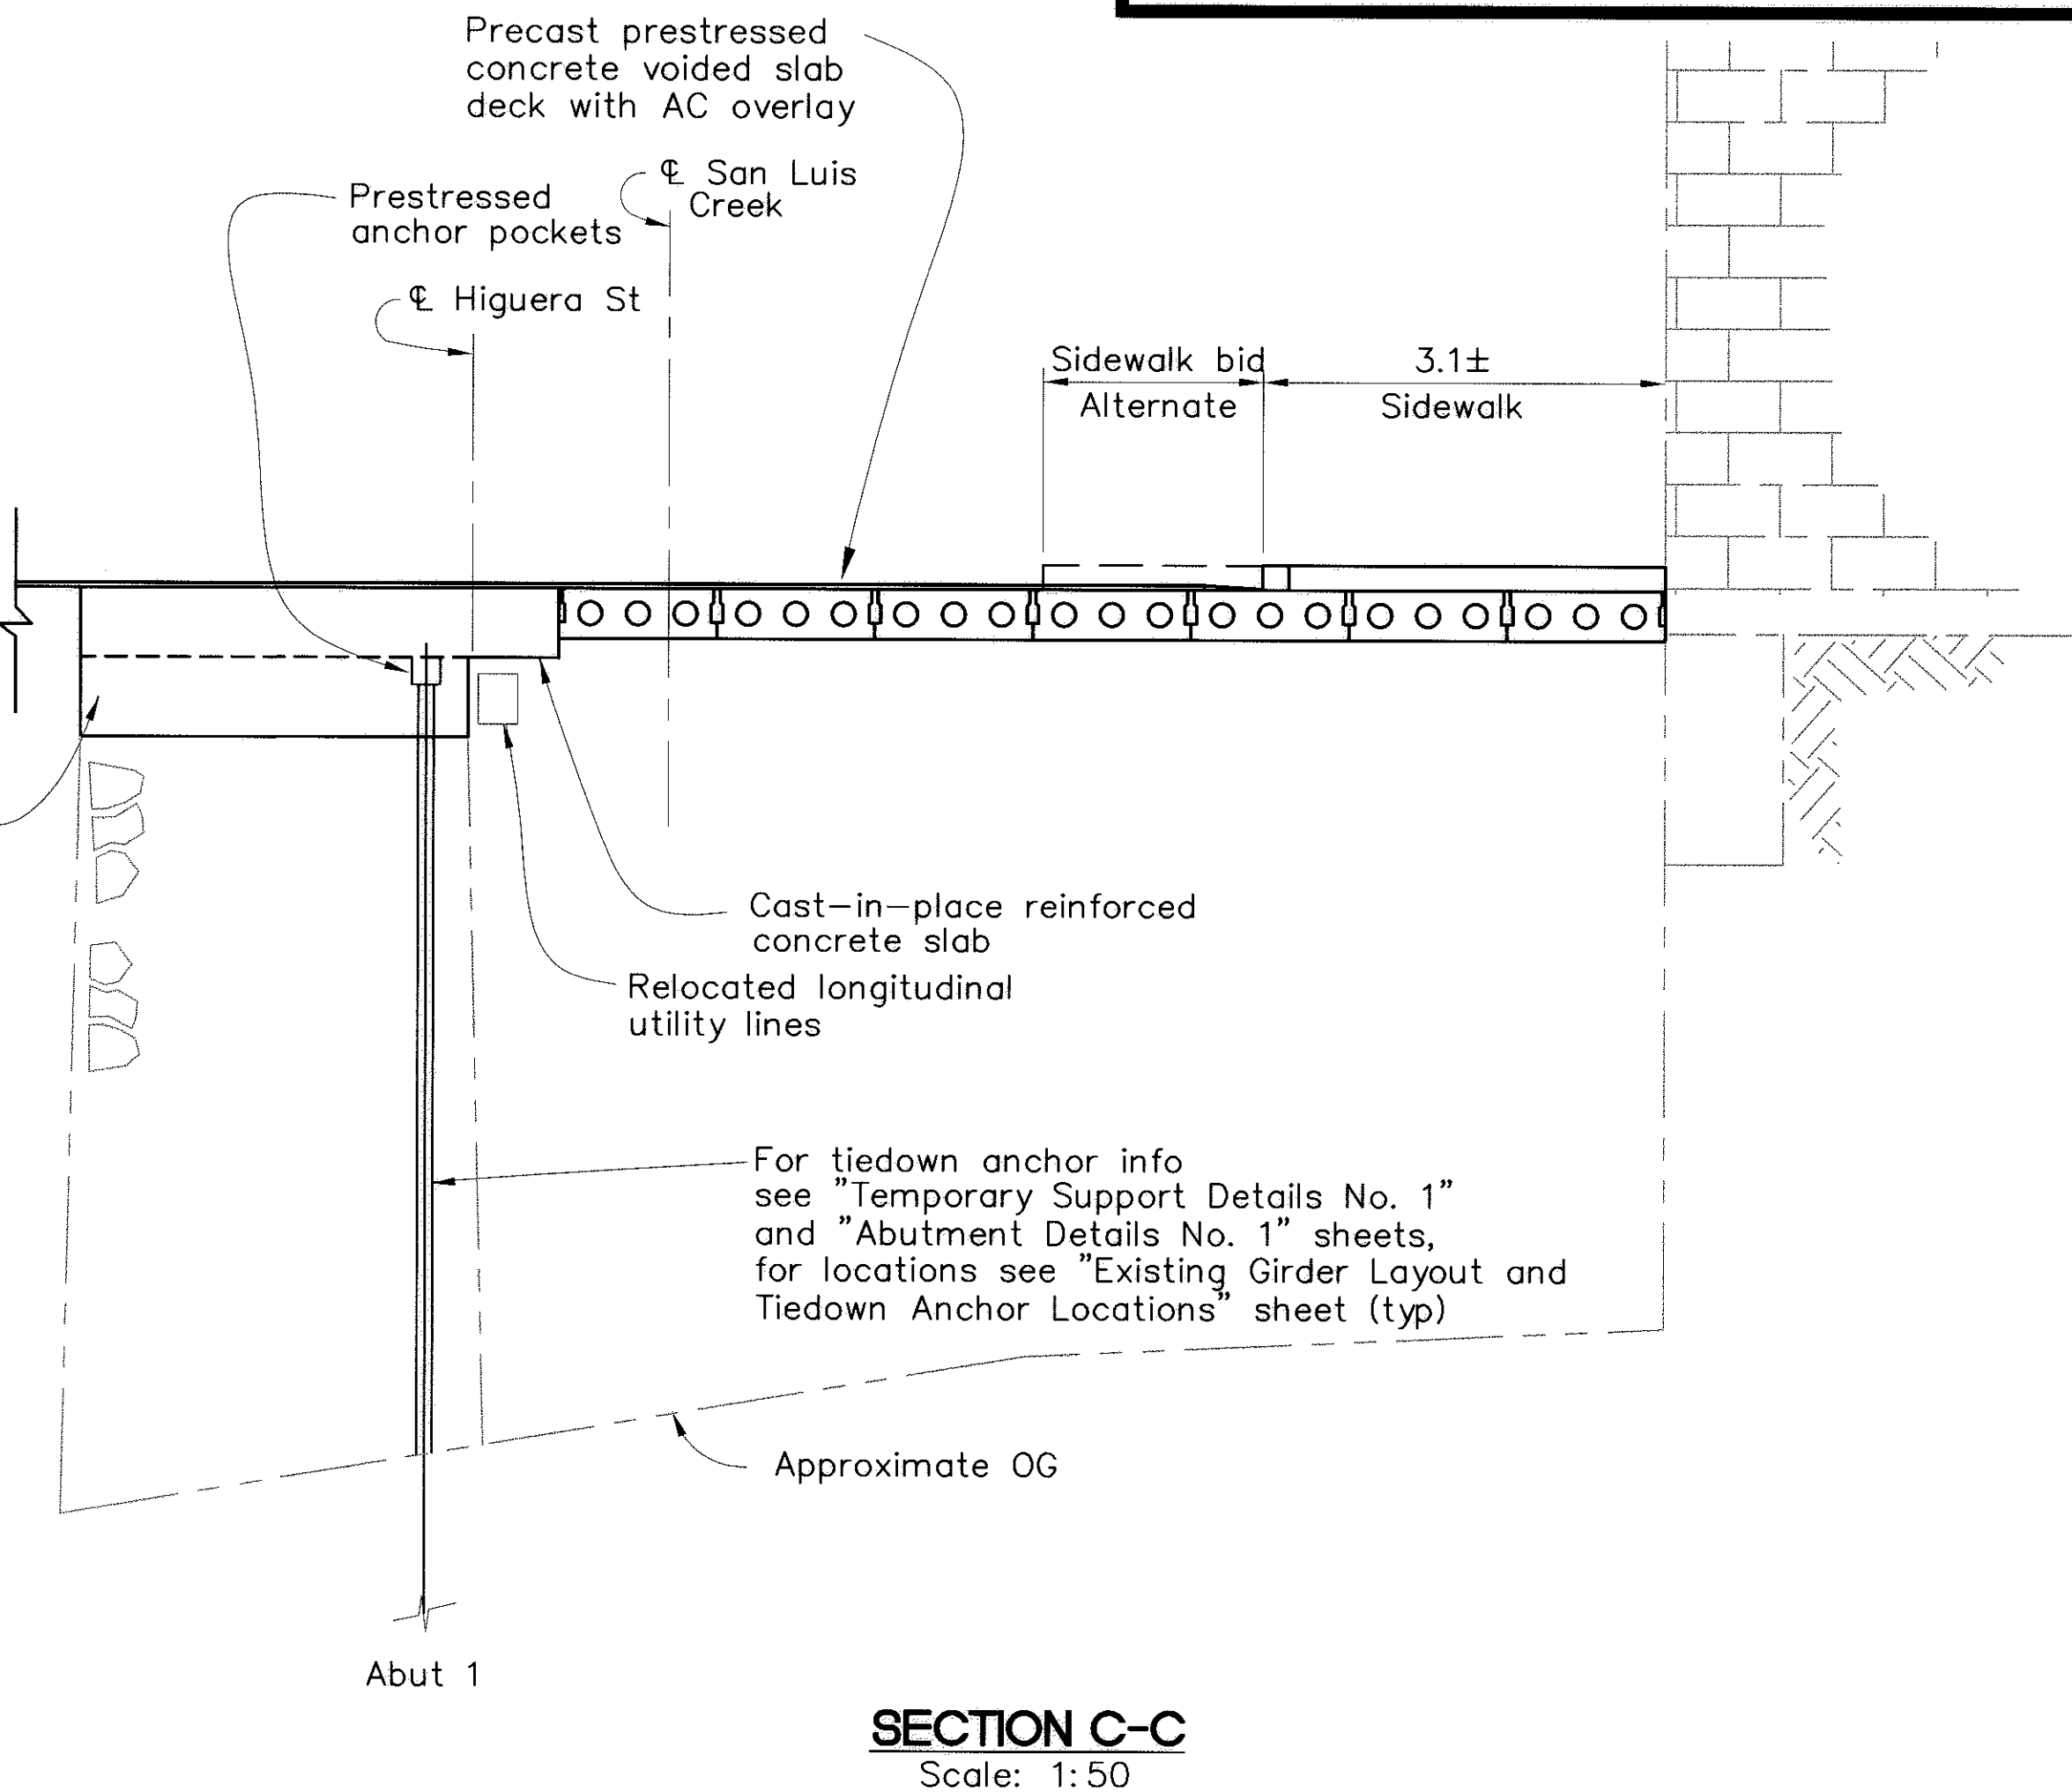

SECTION C-C
Scale: 1:50

Note: For construction staging, see "CONSTRUCTION STAGING DETAILS NO. 1, 2 & 3" sheets

The contractor shall verify all controlling field dimensions before ordering or fabricating any materials.

All dimensions are in meters unless otherwise noted.

DIST	COUNTY	ROUTE	POST MILES TOTAL PROJECT	SHEET NO.	TOTAL SHEETS
5	SLO		-	23	41

Ronald L. Rivett
REGISTERED CIVIL ENGINEER
4/5/00
PLANS APPROVAL DATE

MARTIN & KANE, Inc.
2200-B DOUGLAS BLVD, #150
ROSEVILLE • CA 95661

REGISTERED PROFESSIONAL ENGINEER
No. 31,269
EXP. 12/31/00
CIVIL
STATE OF CALIFORNIA



HIGUERA STREET BRIDGE REPLACEMENT

FOR REDUCED PLANS
ORIGINAL SCALE IS IN MILLIMETERS

0 20 40 60 80 100

APPROVED BY	DATE
CITY ENGINEER	3/2000
DESIGNED BY	As Noted
DRAWN BY	R.F.
CHECKED BY	R.D., K.W.
APPROVED BY	R.R.
UTILITIES DEPARTMENT	

GENERAL PLAN NO. 3


SPECIFICATION NO.
9367
FILE NO./LOCATION
066 B
SHEET
23 OF 41

N:\MSR\1\MK PROJECTS\1997\97017.00 HIGUERA STREET BRIDGE REHA\DRAWINGS (11-23-99)\97017-SC.dwg 1/18/00


DIST	COUNTY	ROUTE	POST MILES TOTAL PROJECT	SHEET NO.	TOTAL SHEETS
5	SLO		-	24	41



Ronald L. Rivett
REGISTERED CIVIL ENGINEER
4/5/00
PLANS APPROVAL DATE
MARTIN & KANE, Inc.
2200-B DOUGLAS BLVD, #150
ROSEVILLE • CA 95661

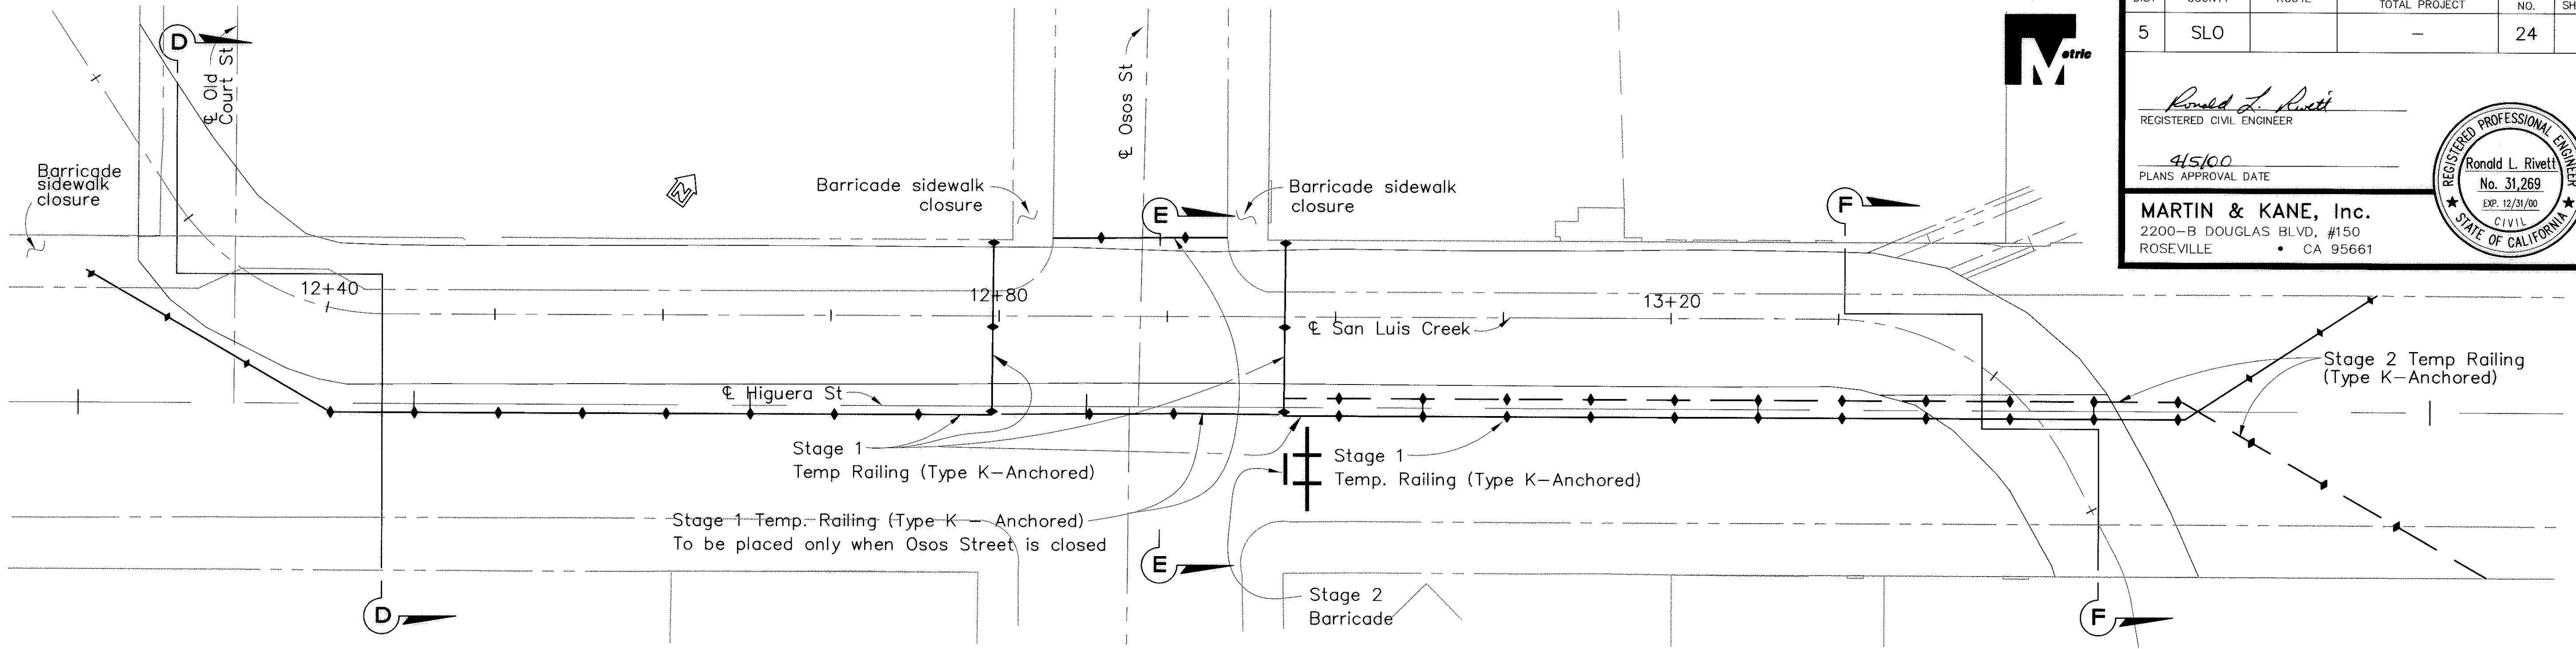

PLAN
Scale: 1:200

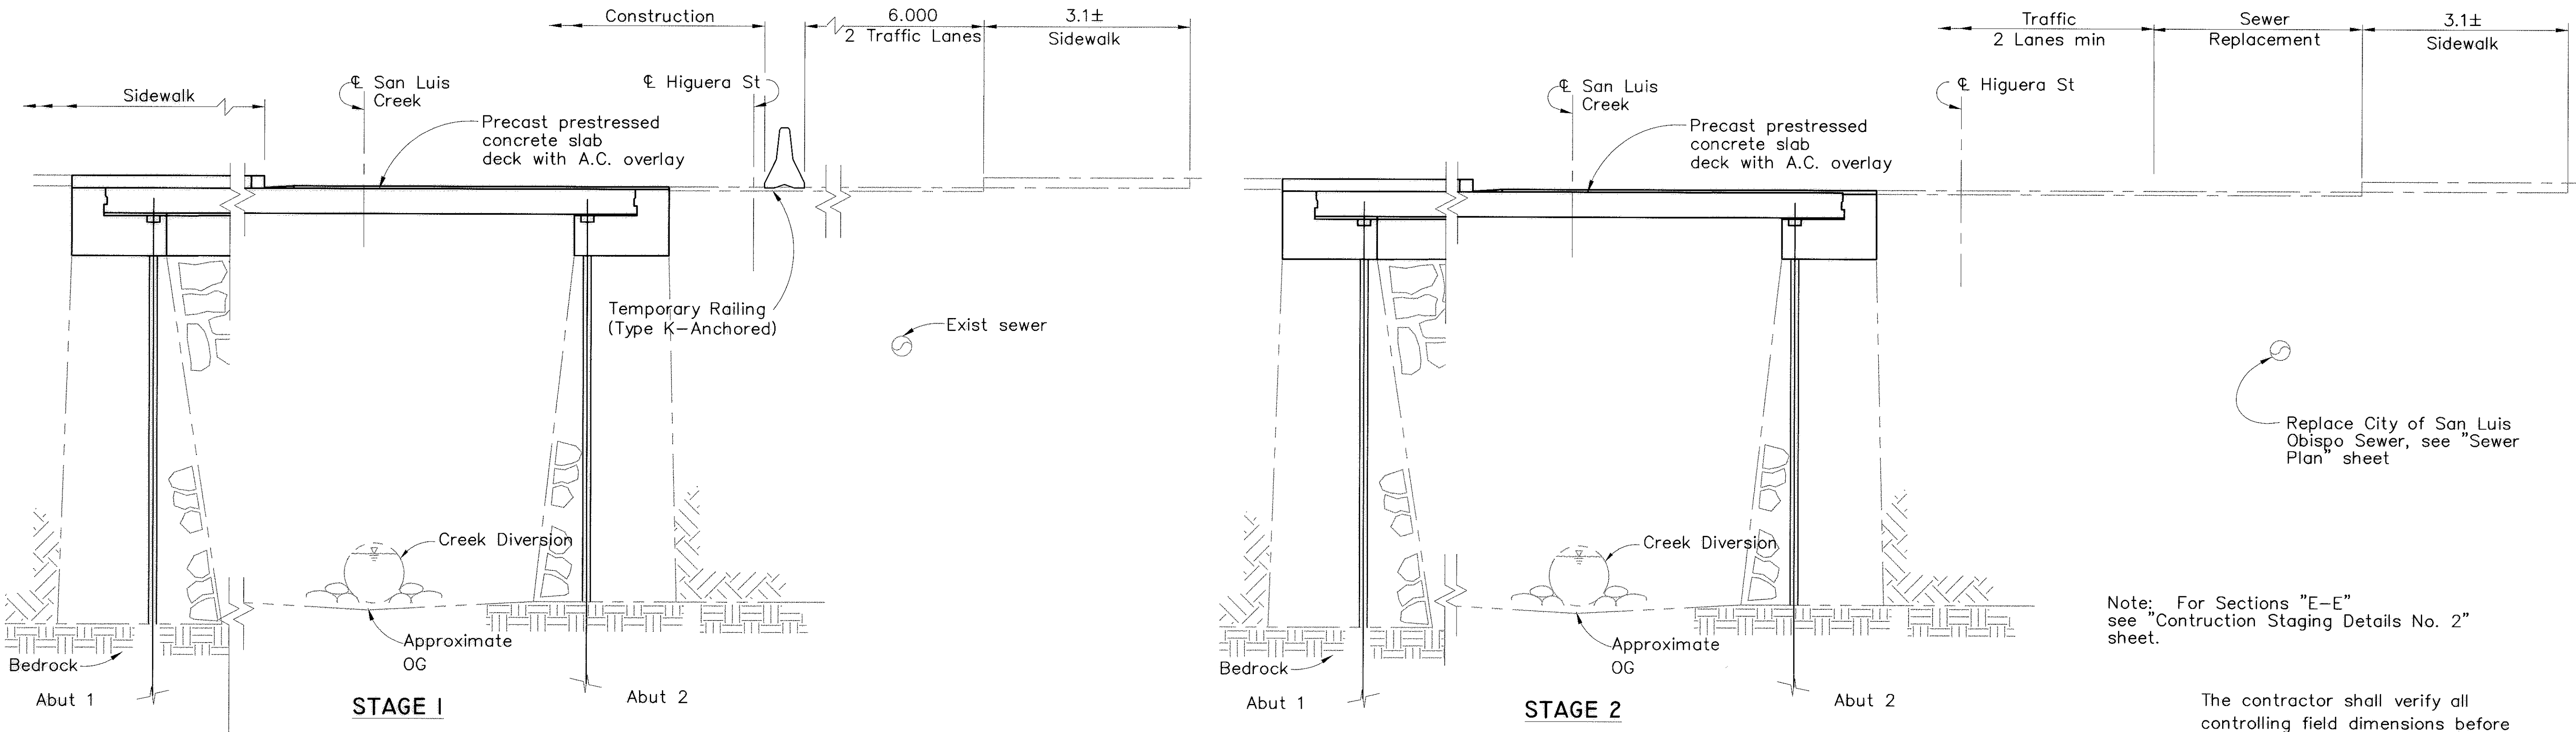

SECTION D-D
Scale: 1:50

Note: For Sections "E-E"
see "Construction Staging Details No. 2"
sheet.

The contractor shall verify all
controlling field dimensions before
ordering or fabricating any
materials.

All dimensions are in meters unless otherwise noted.



HIGUERA STREET BRIDGE REPLACEMENT

FOR REDUCED PLANS
ORIGINAL SCALE IS IN MILLIMETERS



APPROVED BY

CITY ENGINEER

DATE 3/2000
SCALE As Noted
DESIGNED BY R.F.
DRAWN BY R.D., K.W.
CHECKED BY R.R.
APPROVED BY
UTILITIES DEPARTMENT

CONSTRUCTION STAGING
DETAILS NO. 1

SPECIFICATION NO.
9367
FILE NO./LOCATION
0060 B
SHEET
24 of 41

N:\MKSERV\1\WK PROJECTS\1997\97017.00 HIGUERA STREET BRIDGE REHAB\DRAWINGS (11-23-99)\97017-SC.dwg 1/18/00

General Notes Load Factor Design

Design: Bridge Design Specifications
(1983 AASHTO with Interims and Revisions by CALTRANS)

Dead Load: Includes 1.68 KPa for future wearing surface.

Live Loading: HS20-44 and alternative and permit design load.

Seismic Loading: Peak Rock Acceleration = 0.5g
Depth of Alluvium = 0-3m

Reinforced Concrete:

$f_y = 414 \text{ MPa}$
 $f'_c = 22.4 \text{ MPa}$
 $n = g$

Prestressed Concrete:

See "Prestressing General Notes" on "Precast Concrete Slab
Details" sheet.





DIST	COUNTY	ROUTE	POST MILES TOTAL PROJECT	SHEET NO.	TOTAL SHEETS
5	SLO		—	25	41


Ronald L. Rivett
REGISTERED CIVIL ENGINEER

4/5/00
PLANS APPROVAL DATE

MARTIN & KANE, Inc.
2200-B DOUGLAS BLVD., #150
ROSEVILLE • CA 95661

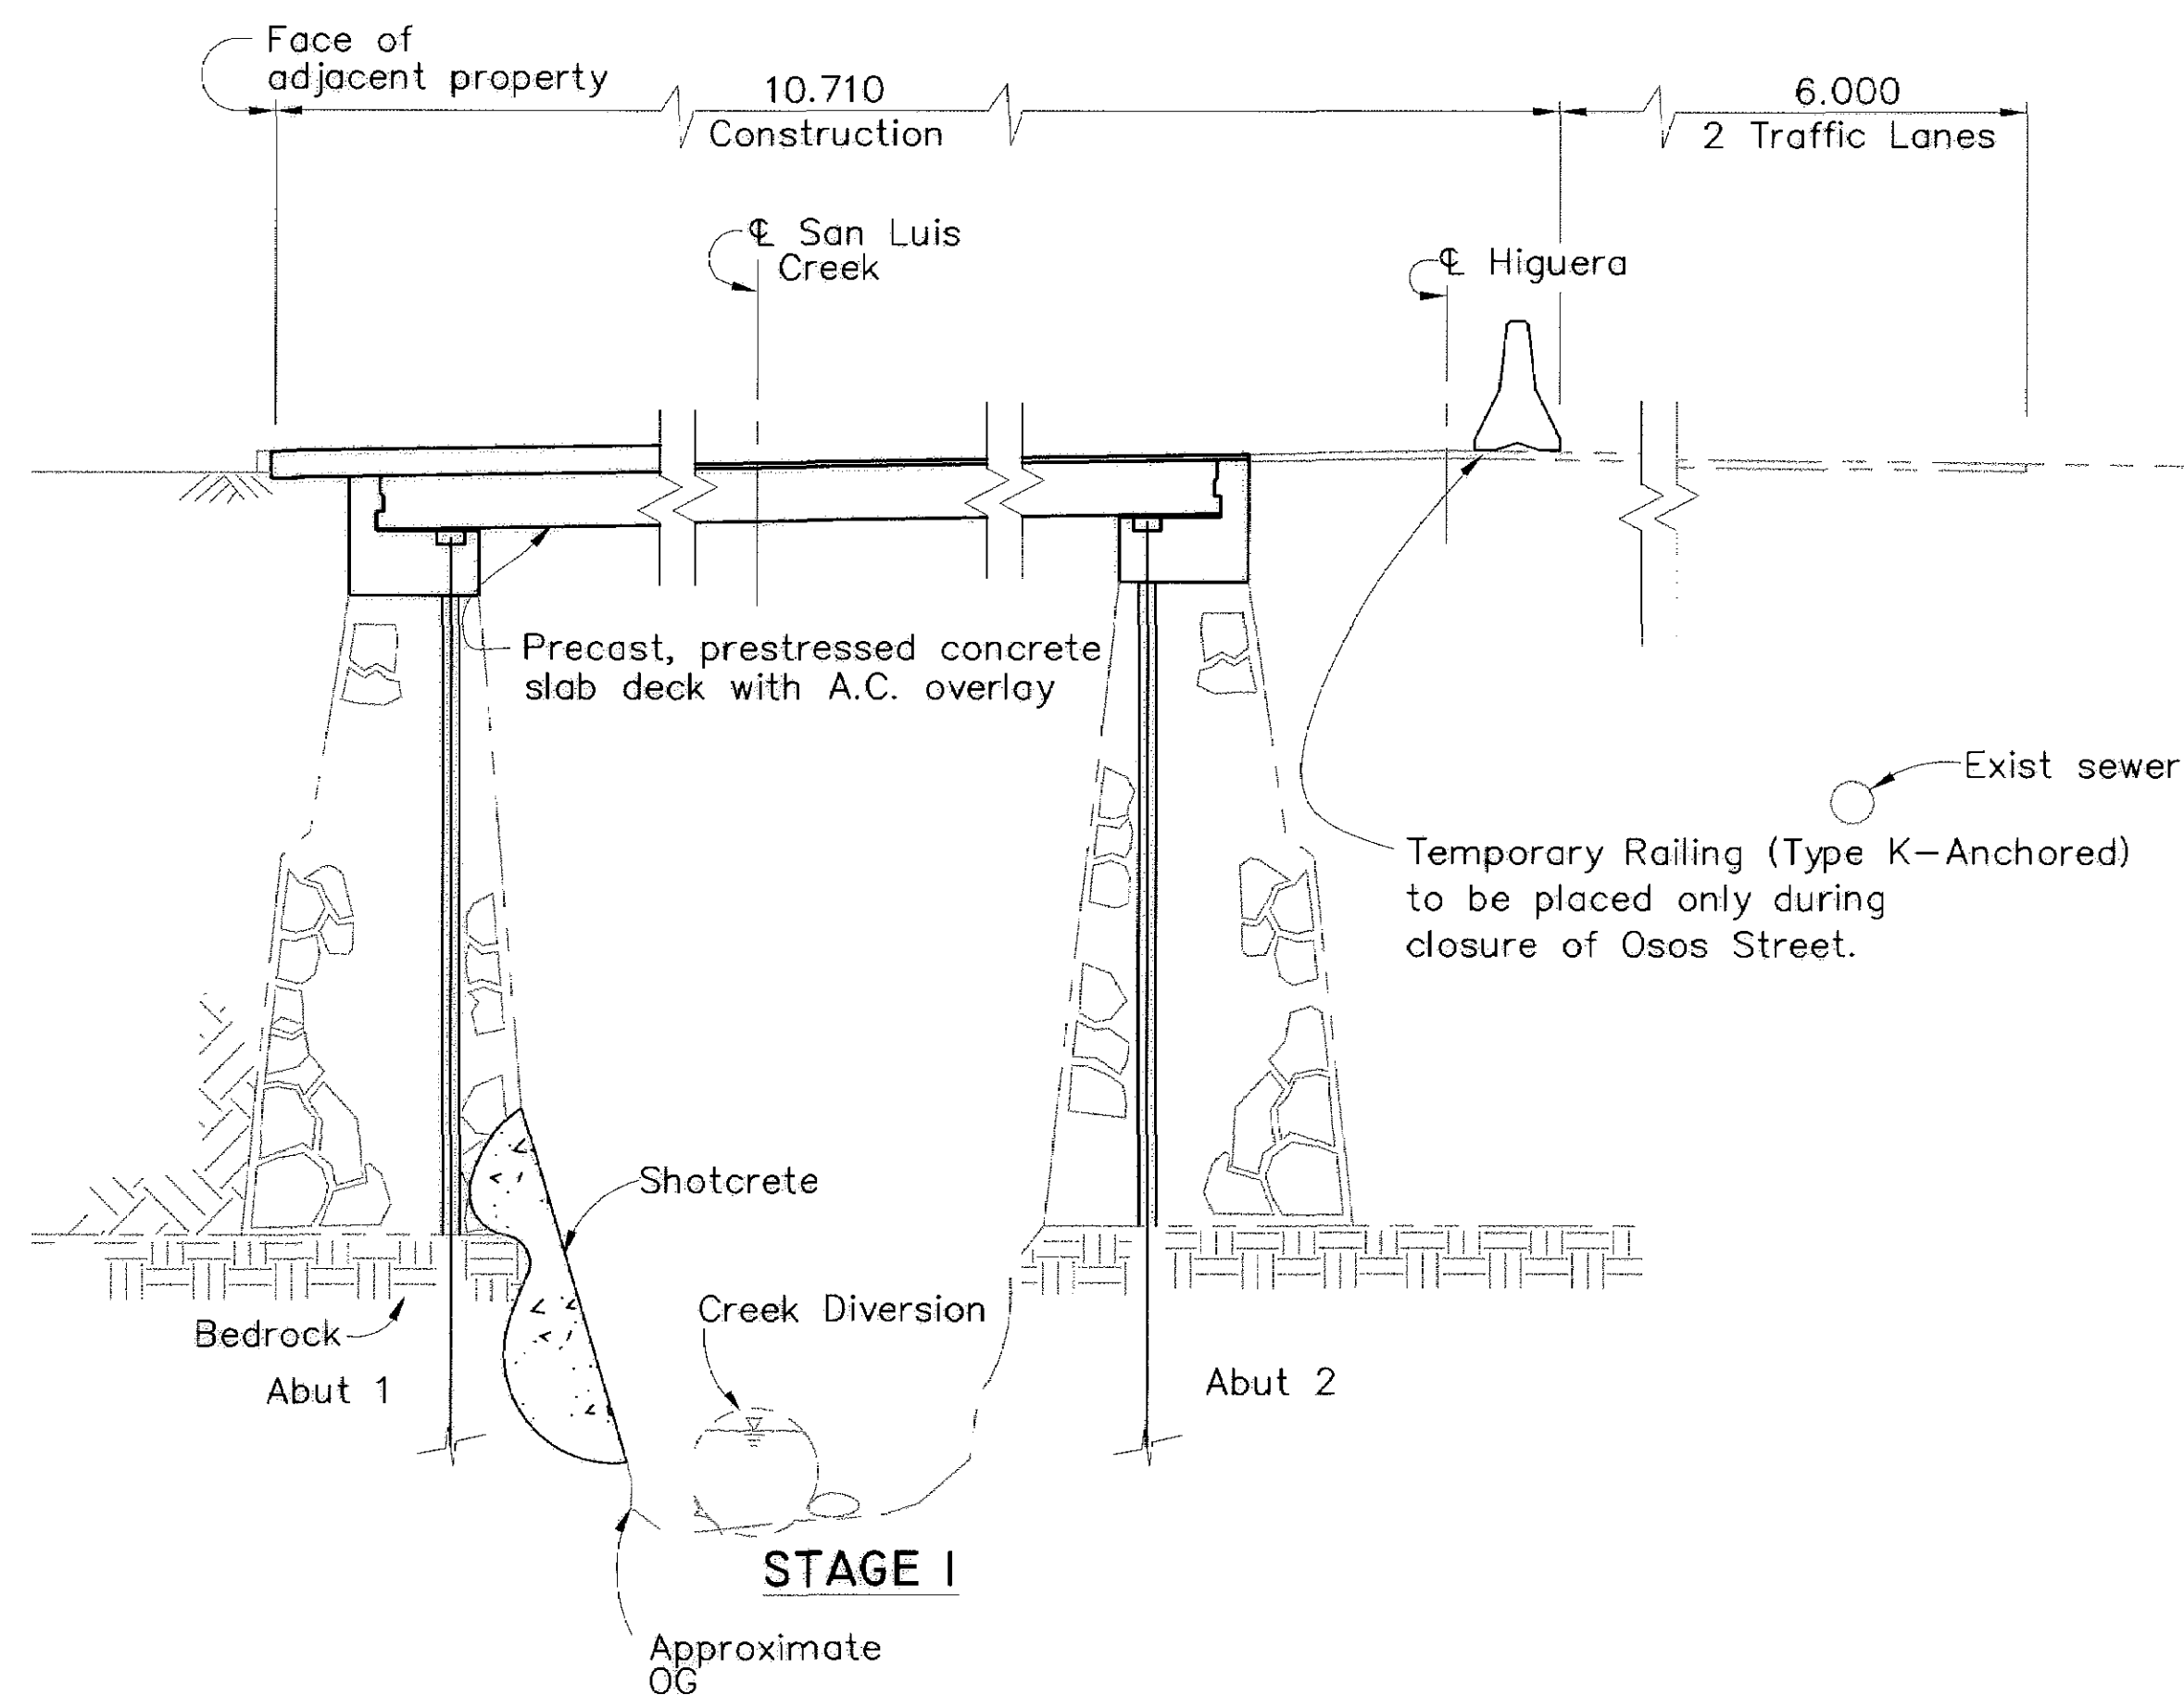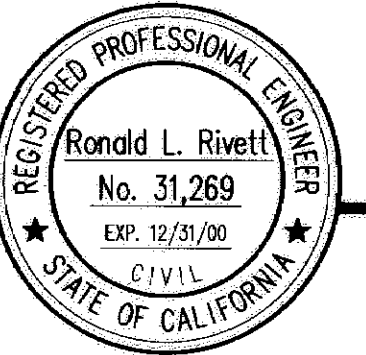


SECTION E-E
Scale: 1:50

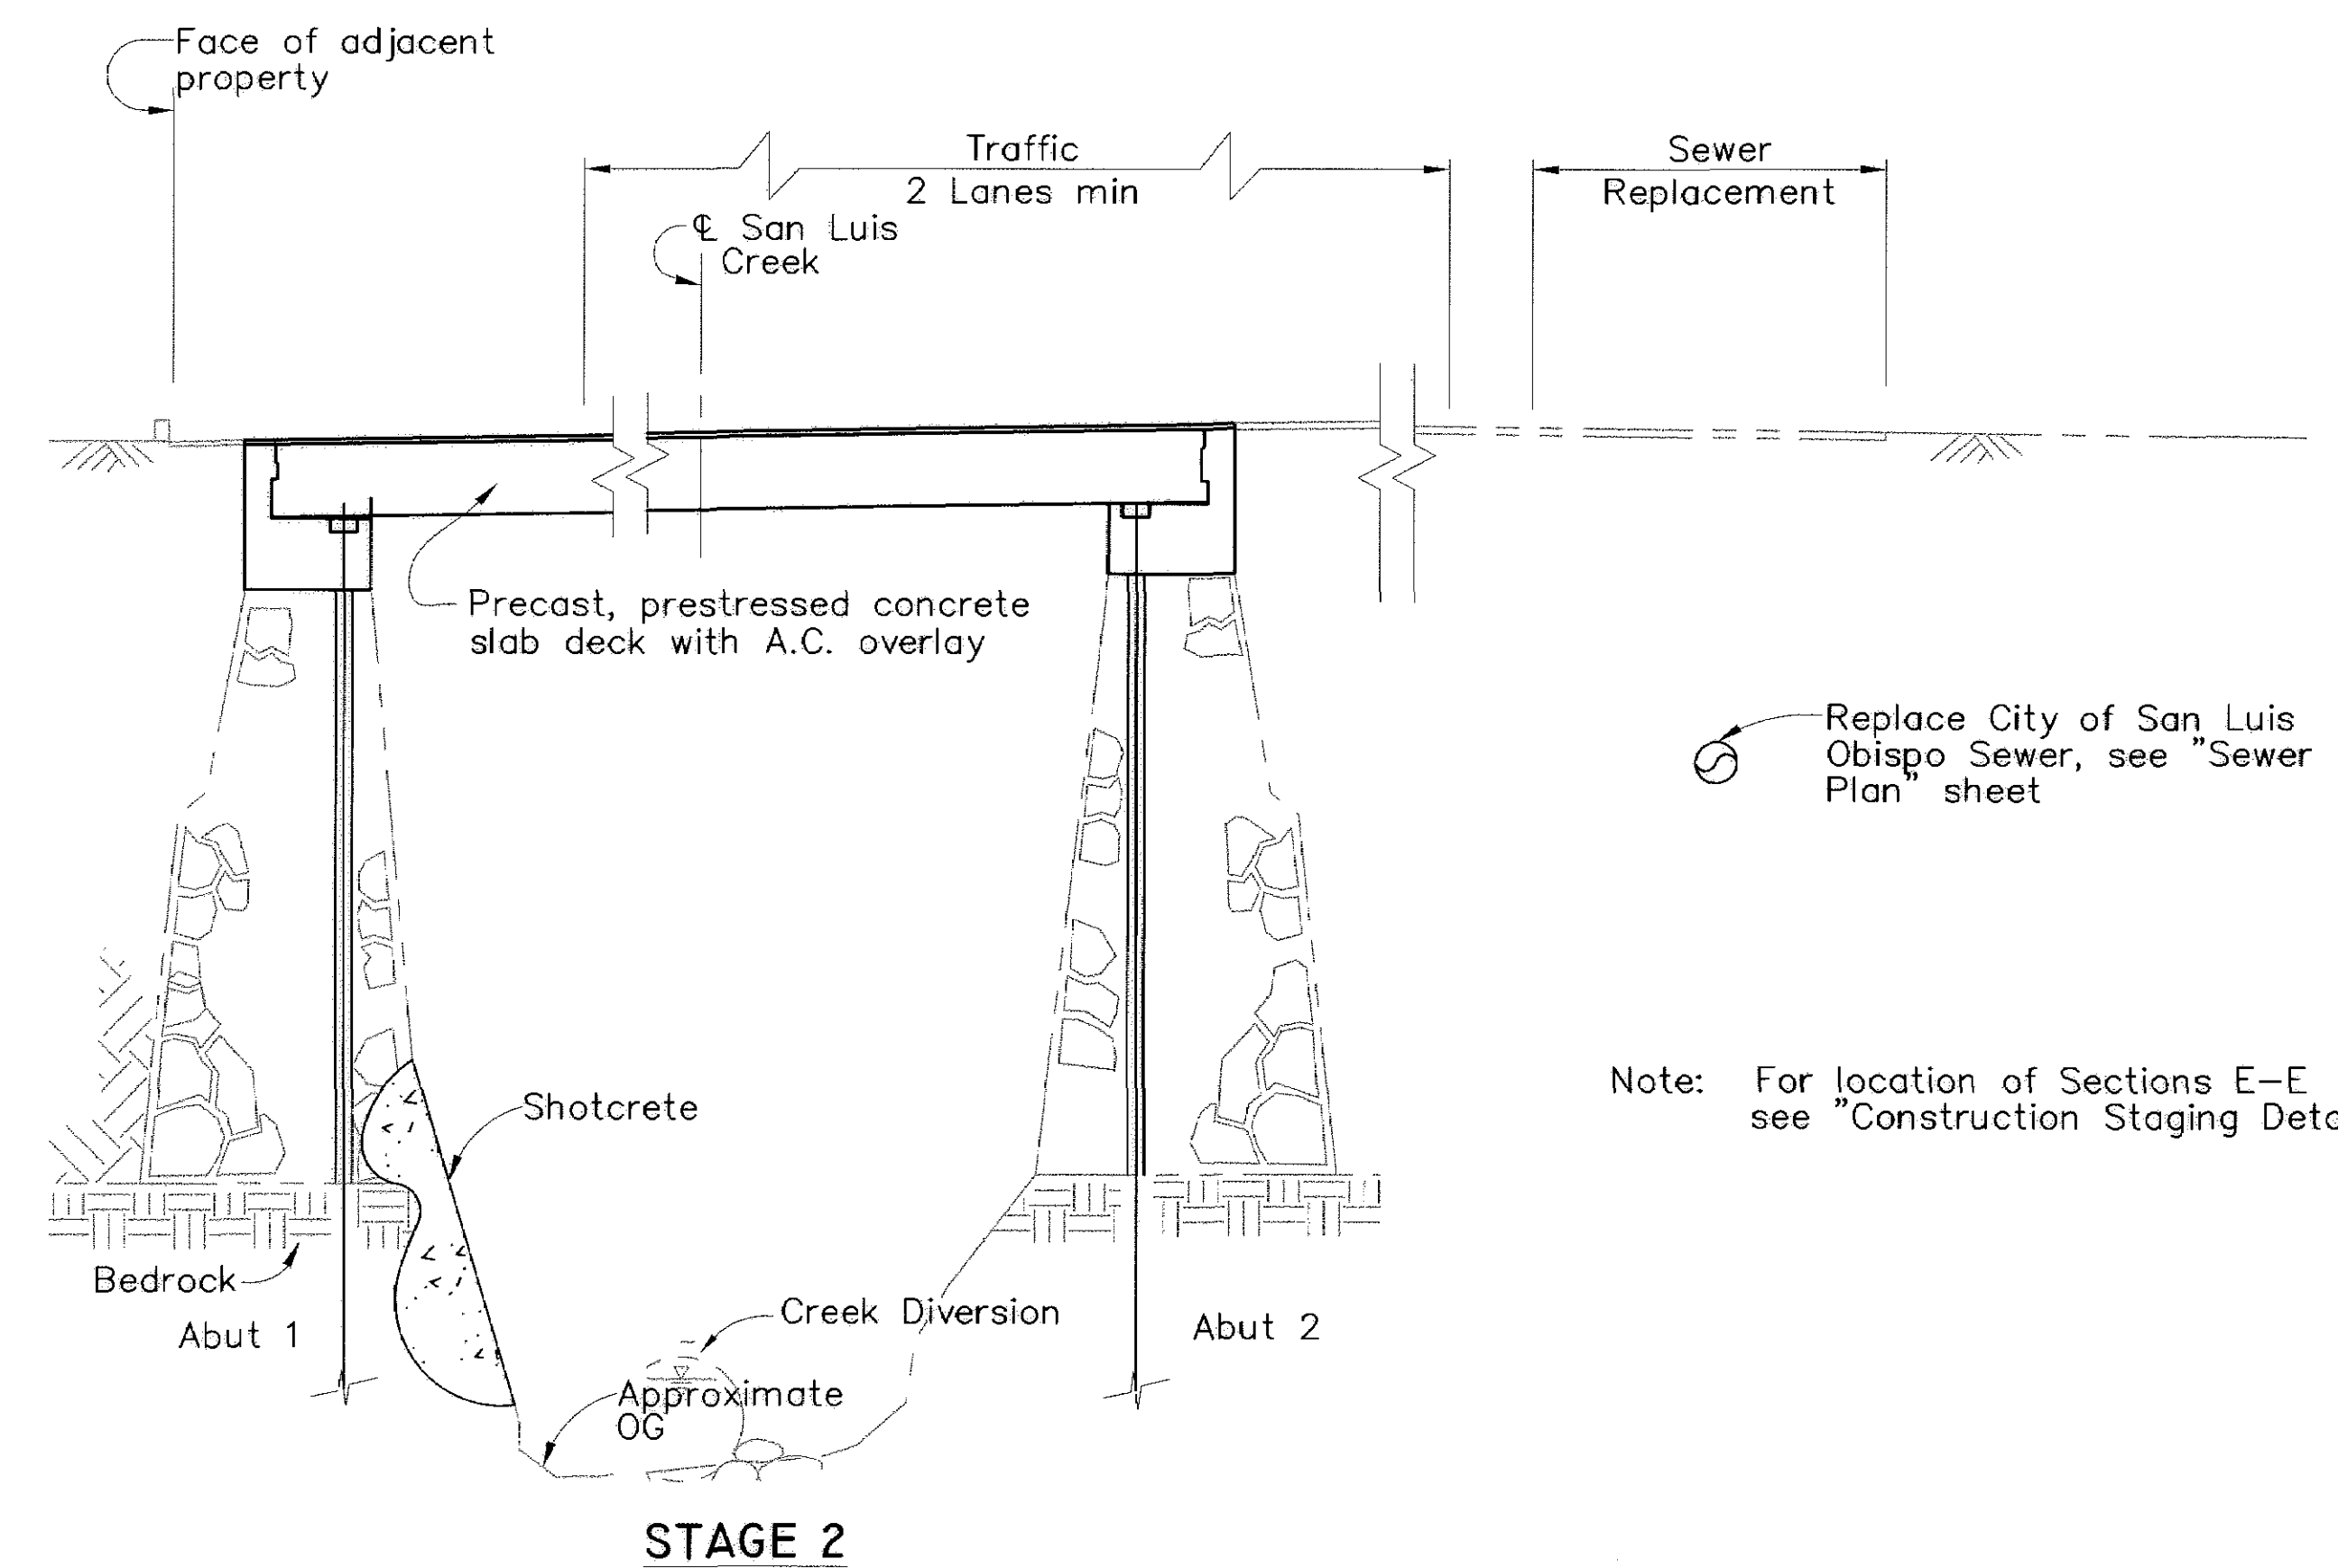

Note: For location of Sections E-E
see "Construction Staging Details No. 1" sheet.

The contractor shall verify all
controlling field dimensions before
ordering or fabricating any
materials.

All dimensions are in meters unless otherwise noted.

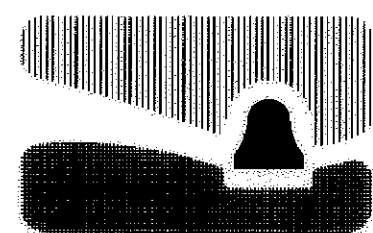

city of san luis obispo

HIGUERA STREET BRIDGE REPLACEMENT

FOR REDUCED PLANS
ORIGINAL SCALE IS IN MILLIMETERS

0 20 40 60 80 100

APPROVED BY

CITY ENGINEER

DATE 3/2000
SCALE As Noted
DESIGNED BY R.F.
DRAWN BY R.D., K.W.
CHECKED BY R.R.
APPROVED BY
UTILITIES DEPARTMENT

**CONSTRUCTION STAGING
DETAILS NO. 2**

SPECIFICATION NO.
9367
FILE NO./LOCATION
0060 B
SHEET
25 of 41

N:\MKSRV1\MK PROJECTS\1997\97017.00 HIGUERA STREET BRIDGE REHAB DRAWINGS (NOVEMBER 1999)\BRIDGE DRAWINGS (11-23-99)\97017-SC.dwg 1/18/00

General Notes Load Factor Design

Design: Bridge Design Specifications
(1983 AASHTO with Interims and Revisions by CALTRANS)

Dead Load: Includes 1.68 KPa for future wearing surface.

Live Loading: HS20-44 and alternative and permit design load.



Seismic Loading: Peak Rock Acceleration = 0.5g
Depth of Alluvium = 0-3m

Reinforced Concrete:
 $f_y = 414 \text{ MPa}$
 $f'_c = 22.4 \text{ MPa}$
 $n = g$

Prestressed Concrete:
See "Prestressing General Notes" on "Precast Concrete Slab
Details" sheet.



DIST	COUNTY	ROUTE	POST MILES TOTAL PROJECT	SHEET NO.	TOTAL SHEETS
5	SLO		—	25	41
REGISTERED CIVIL ENGINEER					
PLANS APPROVAL DATE					
MARTIN & KANE, Inc. 2200-B DOUGLAS BLVD, #150 ROSEVILLE • CA 95661					

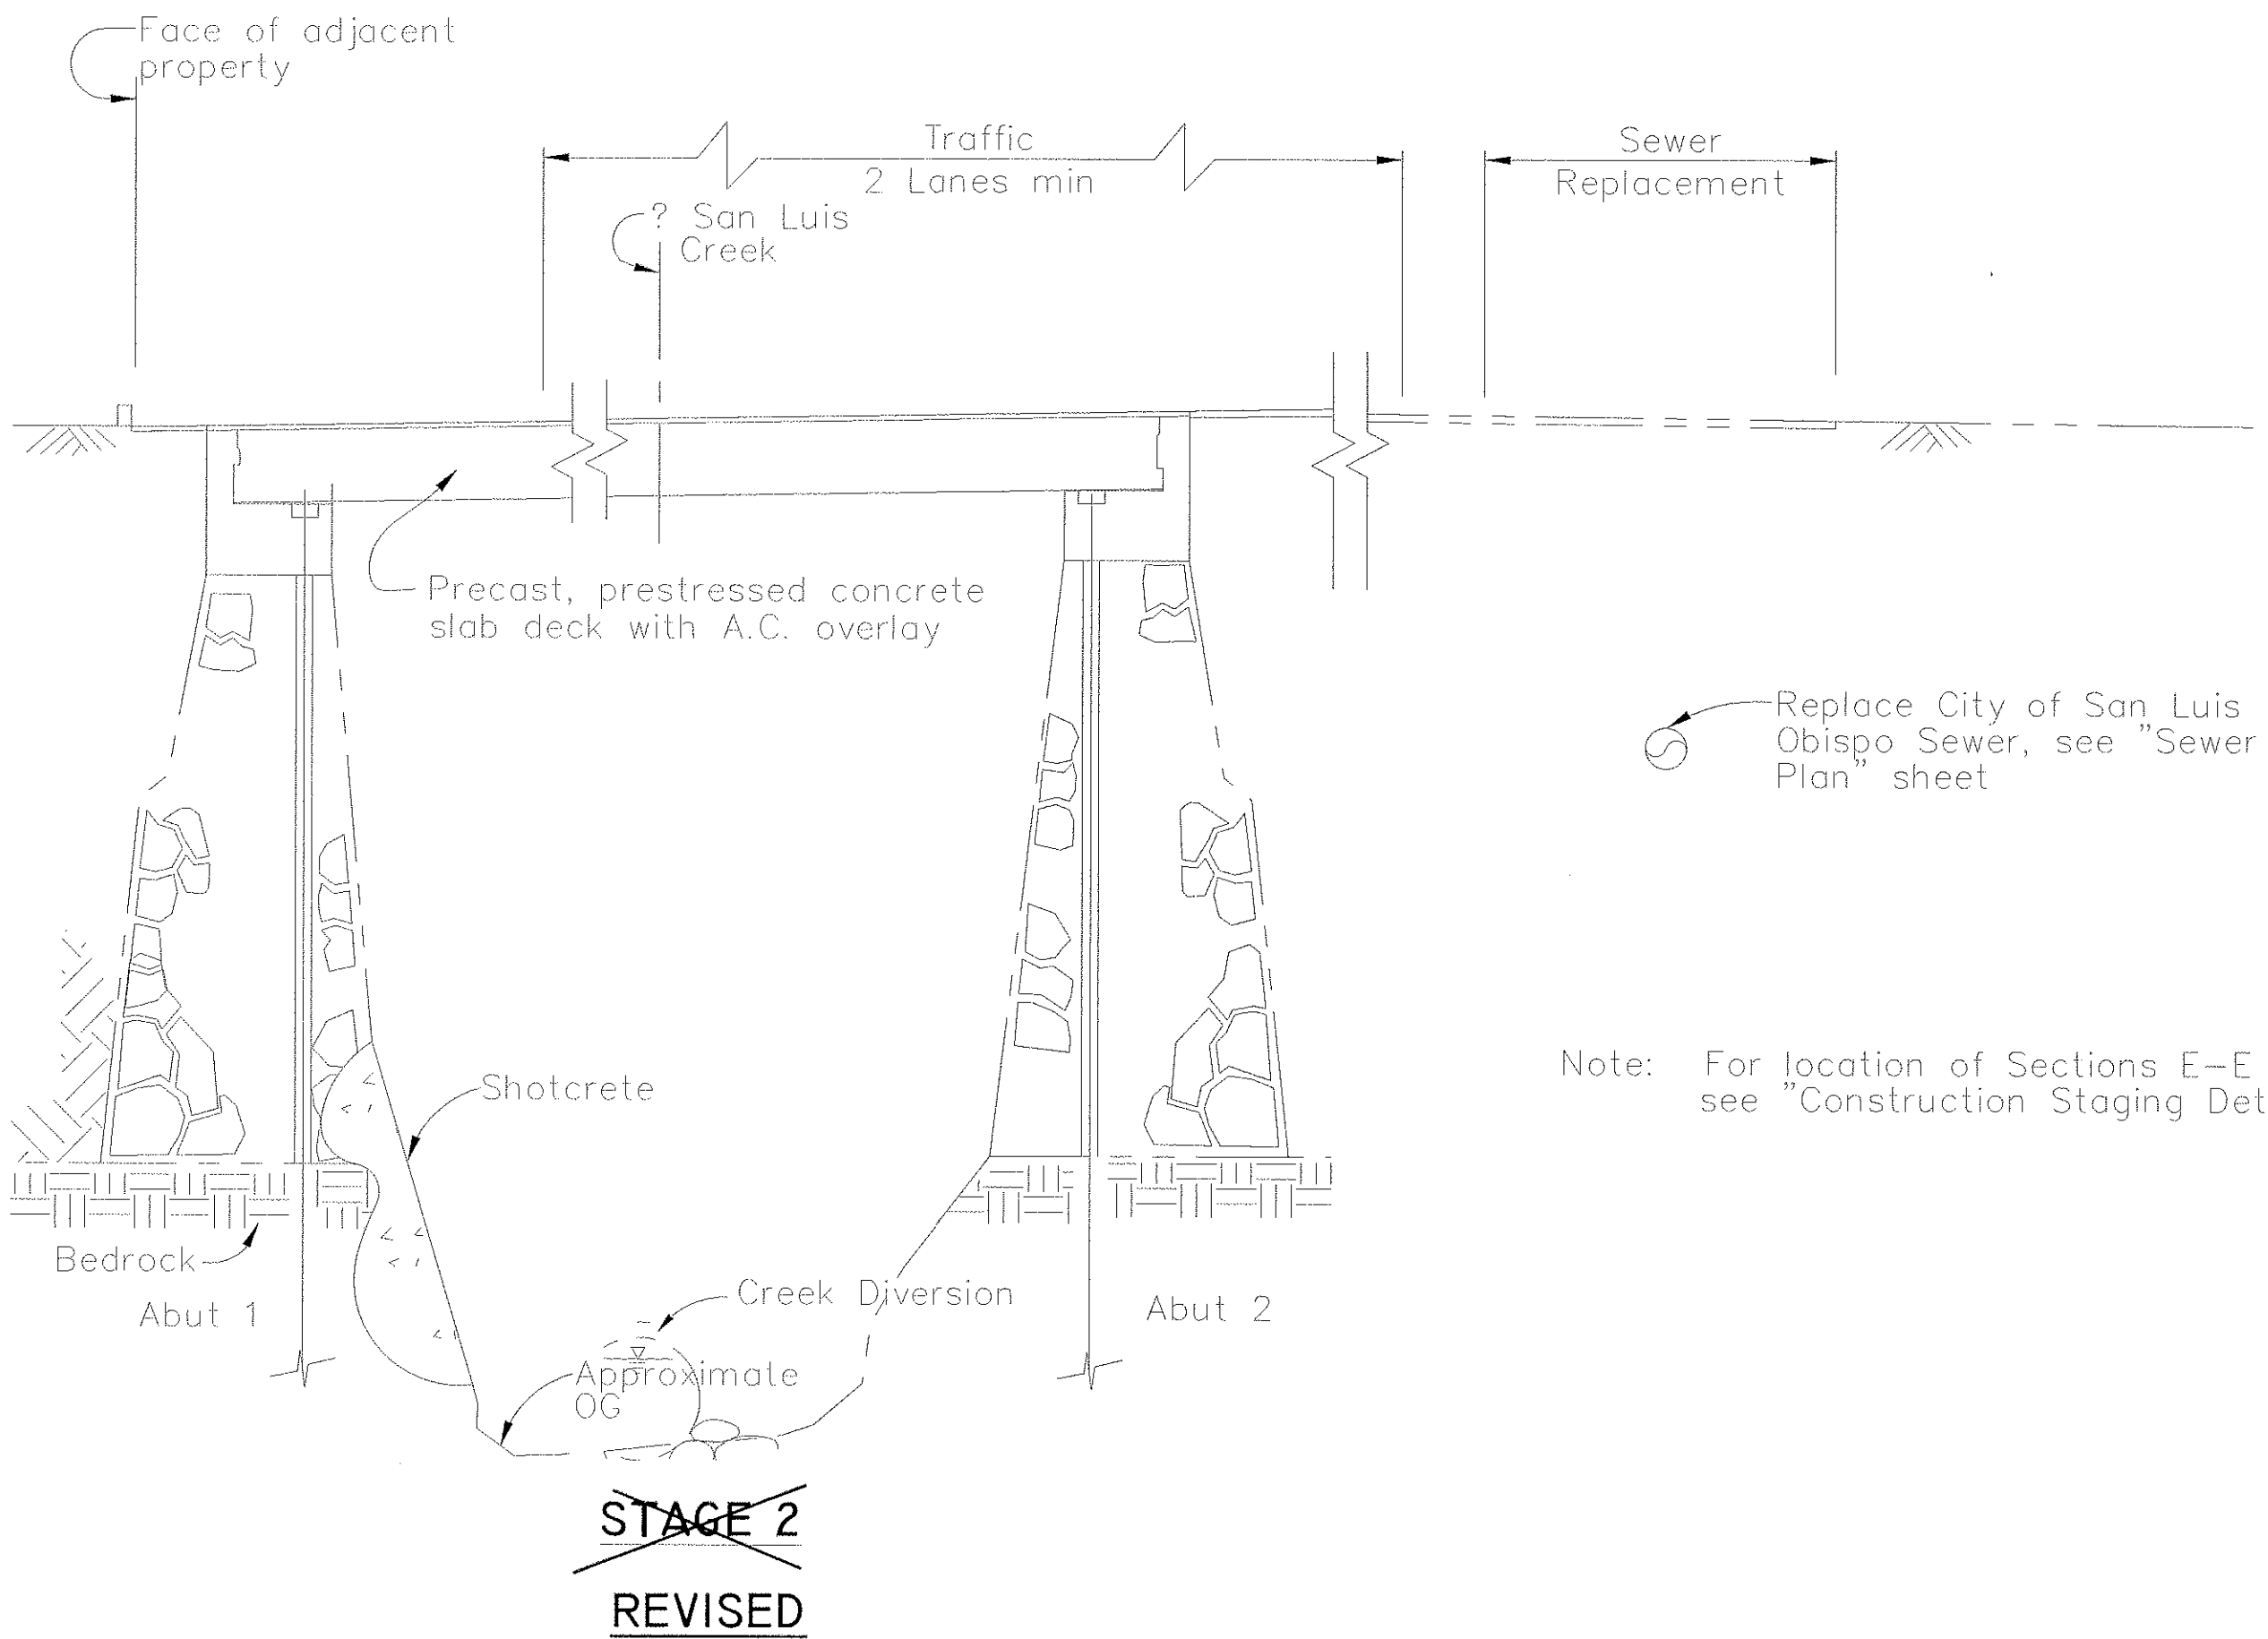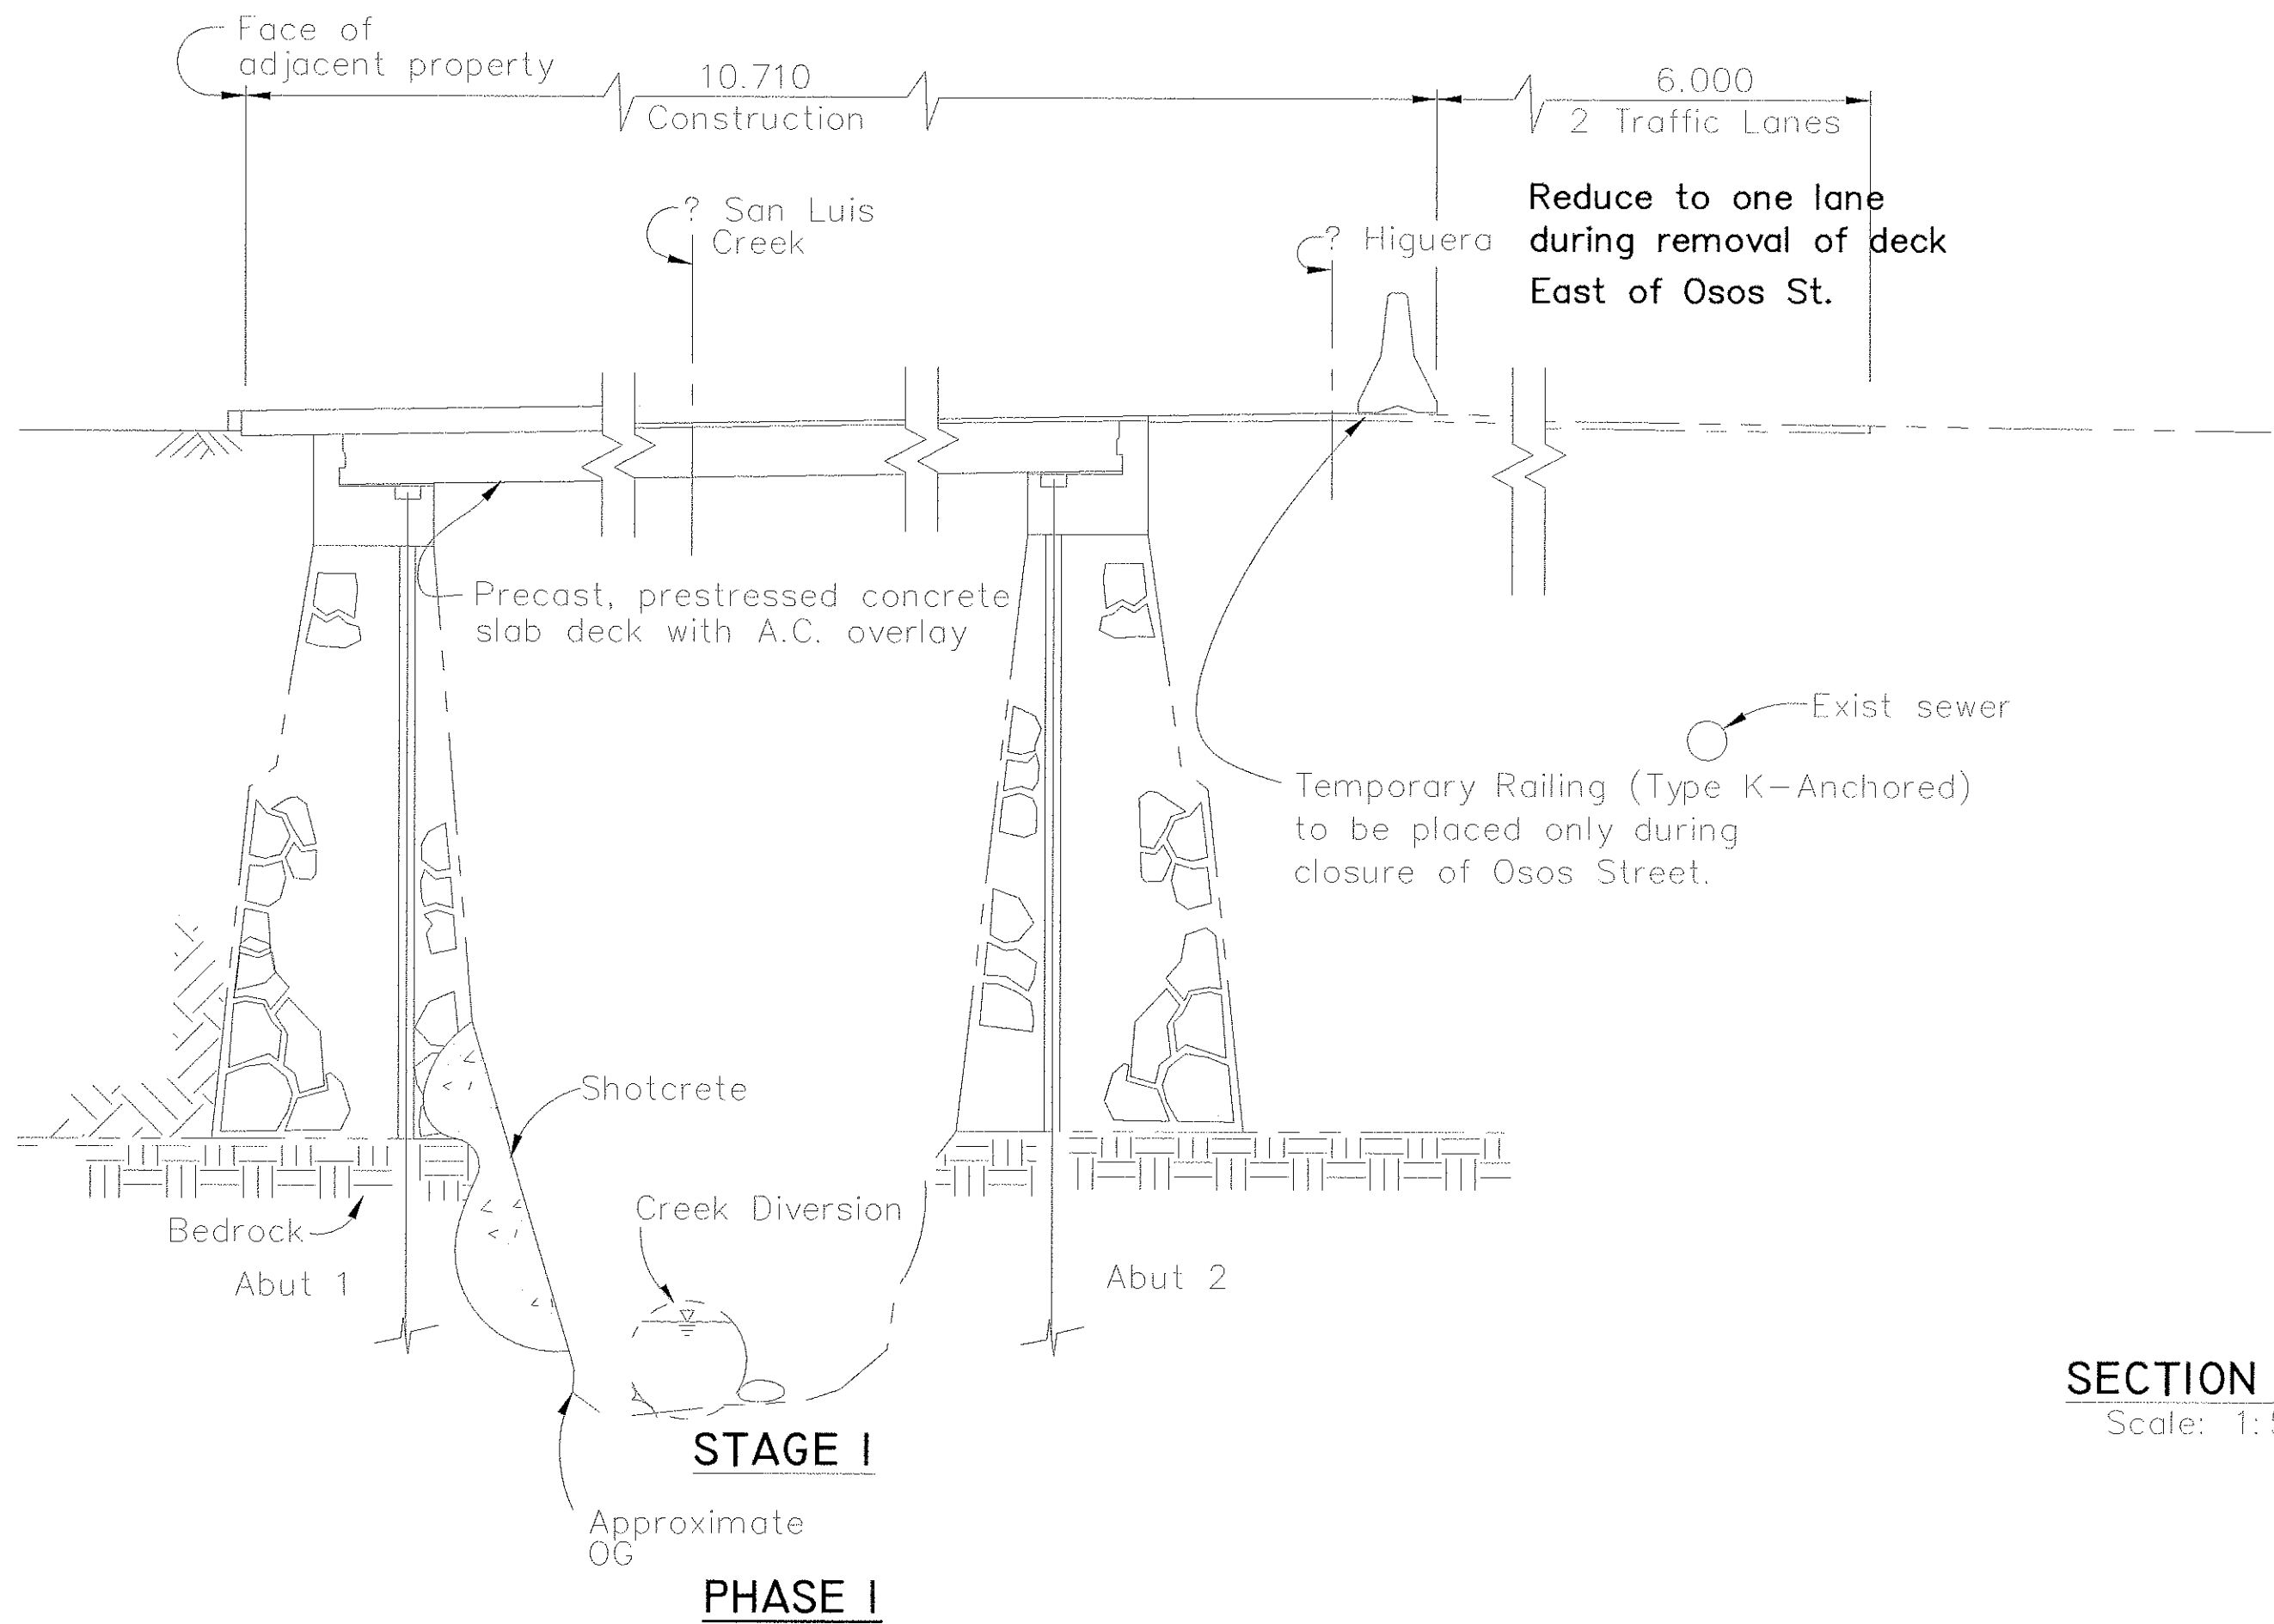


Note: For location of Sections E-E
see "Construction Staging Details No. 1" sheet.

The contractor shall verify all
controlling field dimensions before
ordering or fabricating any
materials.

All dimensions are in meters unless otherwise noted.

RECORD DRAWING
DATE: 2/28/02 BY: SR

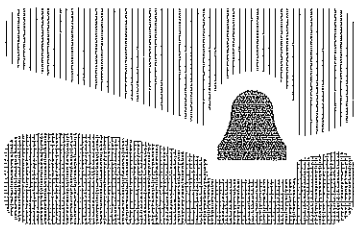

city of san luis obispo

HIGUERA STREET BRIDGE REPLACEMENT

FOR REDUCED PLANS
ORIGINAL SCALE IS IN MILLIMETERS

0 20 40 60 80 100

APPROVED BY

CITY ENGINEER

DATE 3/2000
SCALE As Noted
DESIGNED BY R.F.
DRAWN BY R.D., K.W.
CHECKED BY R.R.
APPROVED BY
UTILITIES DEPARTMENT

CONSTRUCTION STAGING
DETAILS NO. 2

SPECIFICATION NO.

9367

FILE NO./LOCATION

0060 B

SHEET

25 of 41

N:\MSRVA1\MK PROJECTS\1997\97017.00 HIGUERA STREET BRIDGE REHAB\DRAWINGS (11-23-99)\97017-SC.dwg 1/18/00



DIST	COUNTY	ROUTE	POST MILES TOTAL PROJECT	SHEET NO.	TOTAL SHEETS
5	SLO		-	26	41



Ronald L. Rivett
REGISTERED CIVIL ENGINEER

4/5/00
PLANS APPROVAL DATE

MARTIN & KANE, Inc.
2200-B DOUGLAS BLVD, #150
ROSEVILLE • CA 95661

REGISTERED PROFESSIONAL ENGINEER
Ronald L. Rivett
No. 31,269
EXP. 12/31/00
CIVIL
STATE OF CALIFORNIA


Note: All emergency exits must remain accessible during business hours.

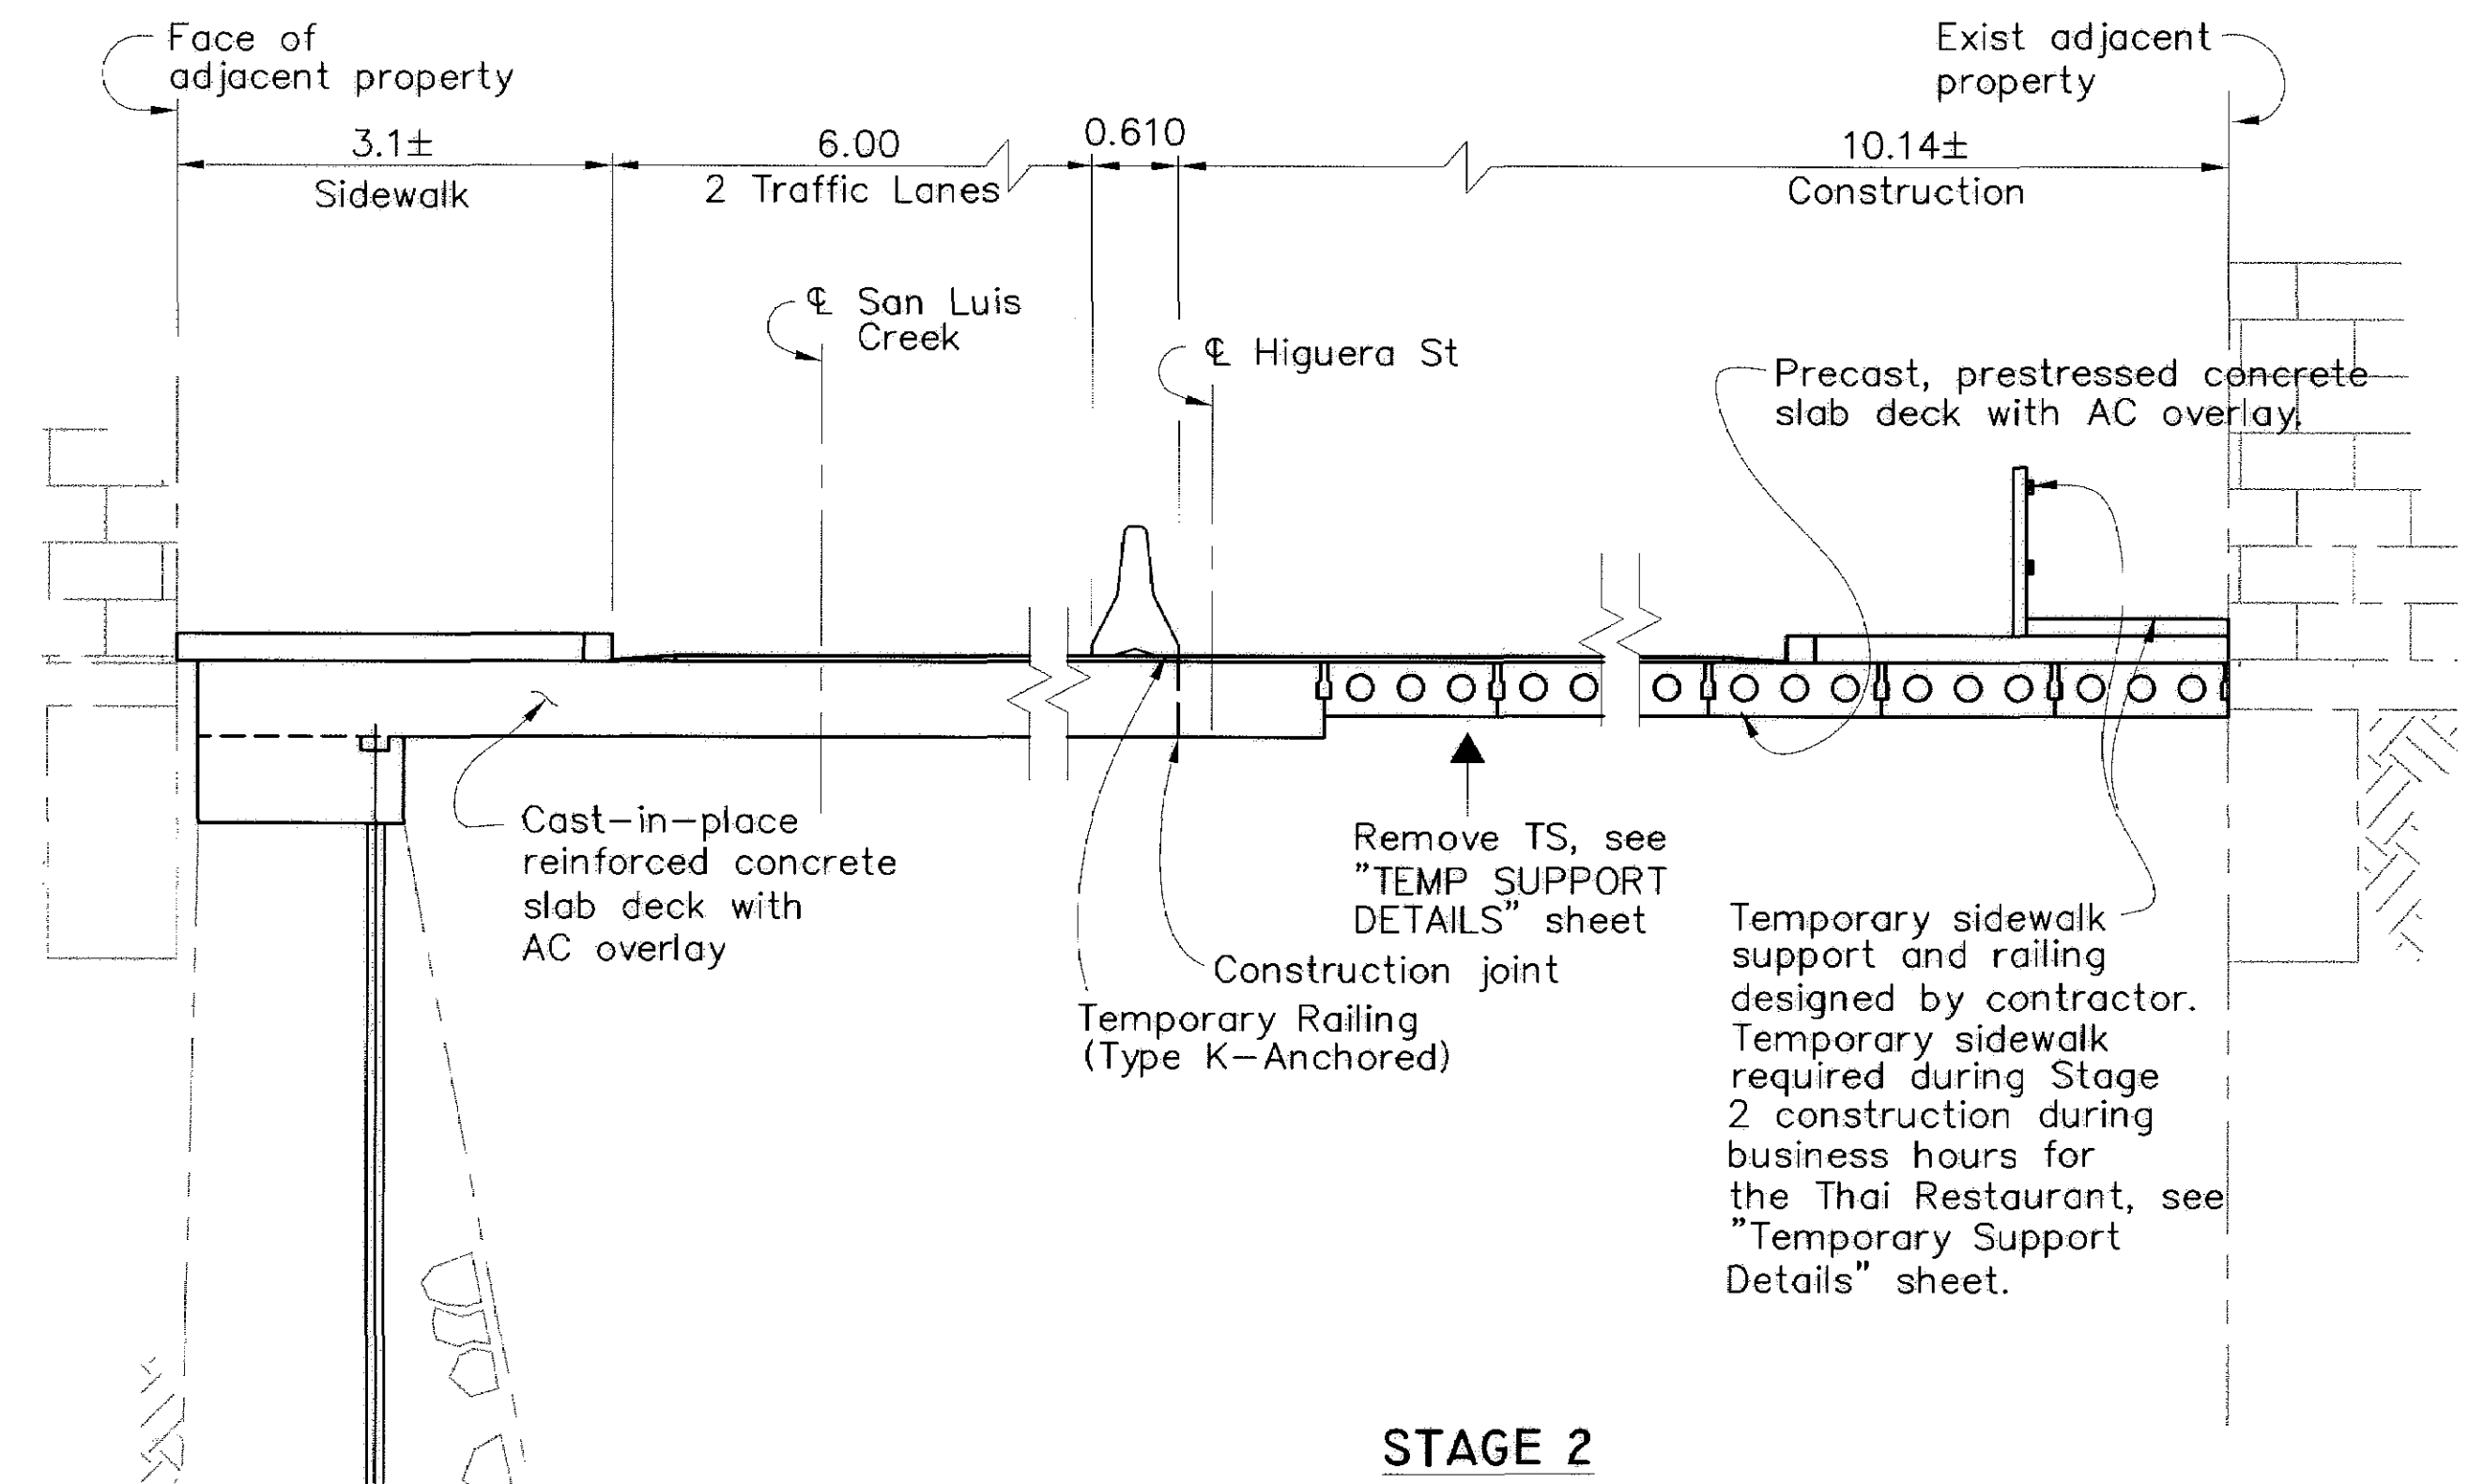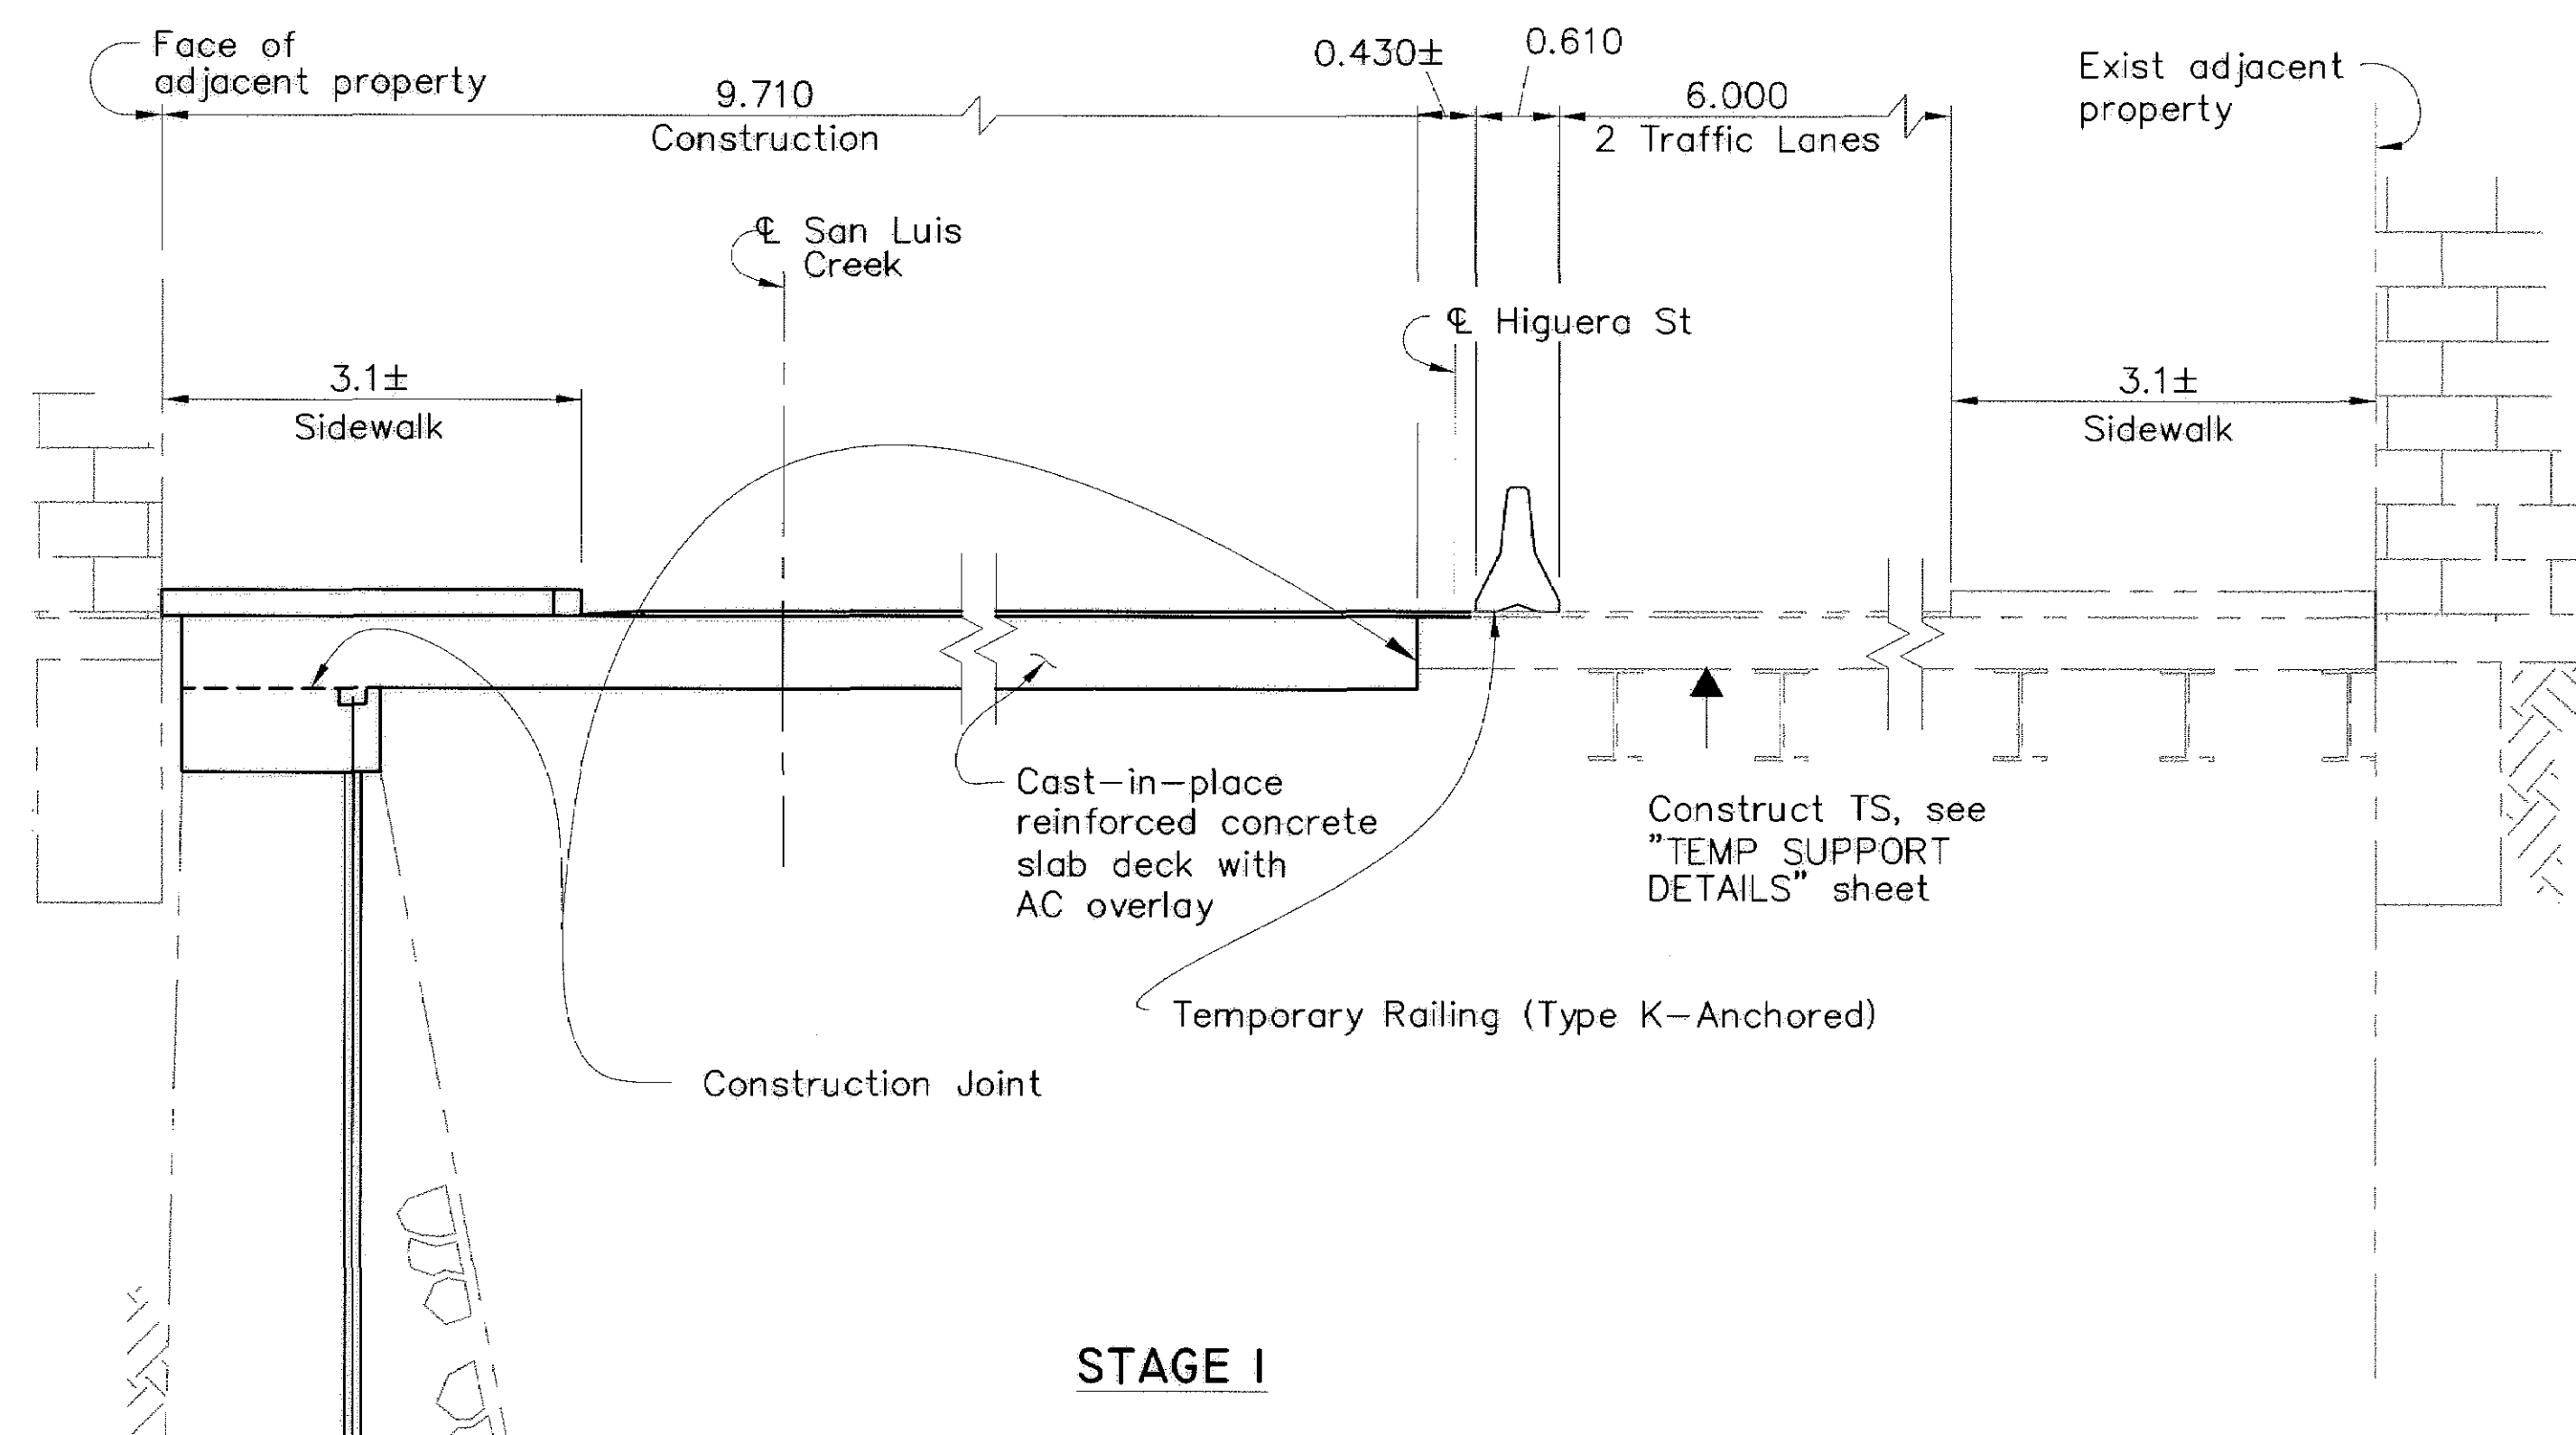

SECTION F-F
Scale: 1:50

The contractor shall verify all controlling field dimensions before ordering or fabricating any materials.

All dimensions are in meters unless otherwise noted.

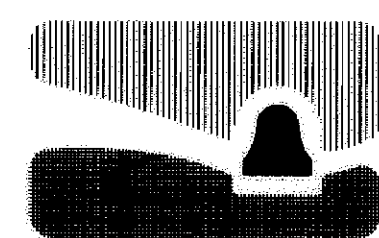

city of san luis obispo

HIGUERA STREET BRIDGE REPLACEMENT

FOR REDUCED PLANS
ORIGINAL SCALE IS IN MILLIMETERS

0 20 40 60 80 100

APPROVED BY

CITY ENGINEER

DATE 3/2000
SCALE As Noted
DESIGNED BY R.F.
DRAWN BY R.D., K.W.
CHECKED BY R.R.
APPROVED BY
UTILITIES DEPARTMENT

CONSTRUCTION STAGING DETAILS NO. 3

SPECIFICATION NO.
9367
FILE NO./LOCATION
0060 B
SHEET
26 OF 41

N:\MKSRV1\WK PROJECTS\1997\97017.00 HIGUERA STREET BRIDGE REHAB\DRAWINGS (11-23-99)\97017-SC.dwg 1/18/00



DIST	COUNTY	ROUTE	POST MILES TOTAL PROJECT	SHEET NO.	TOTAL SHEETS
5	SLO		-	26	41


REGISTERED CIVIL ENGINEER

PLANS APPROVAL DATE

MARTIN & KANE, Inc.
2200-B DOUGLAS BLVD, #150
ROSEVILLE • CA 95661


REGISTERED PROFESSIONAL ENGINEER
Ronald L. Rivett
No. 31,269
EXP. 12/31/00
CIVIL
STATE OF CALIFORNIA

Note: All emergency exits must remain accessible during business hours.

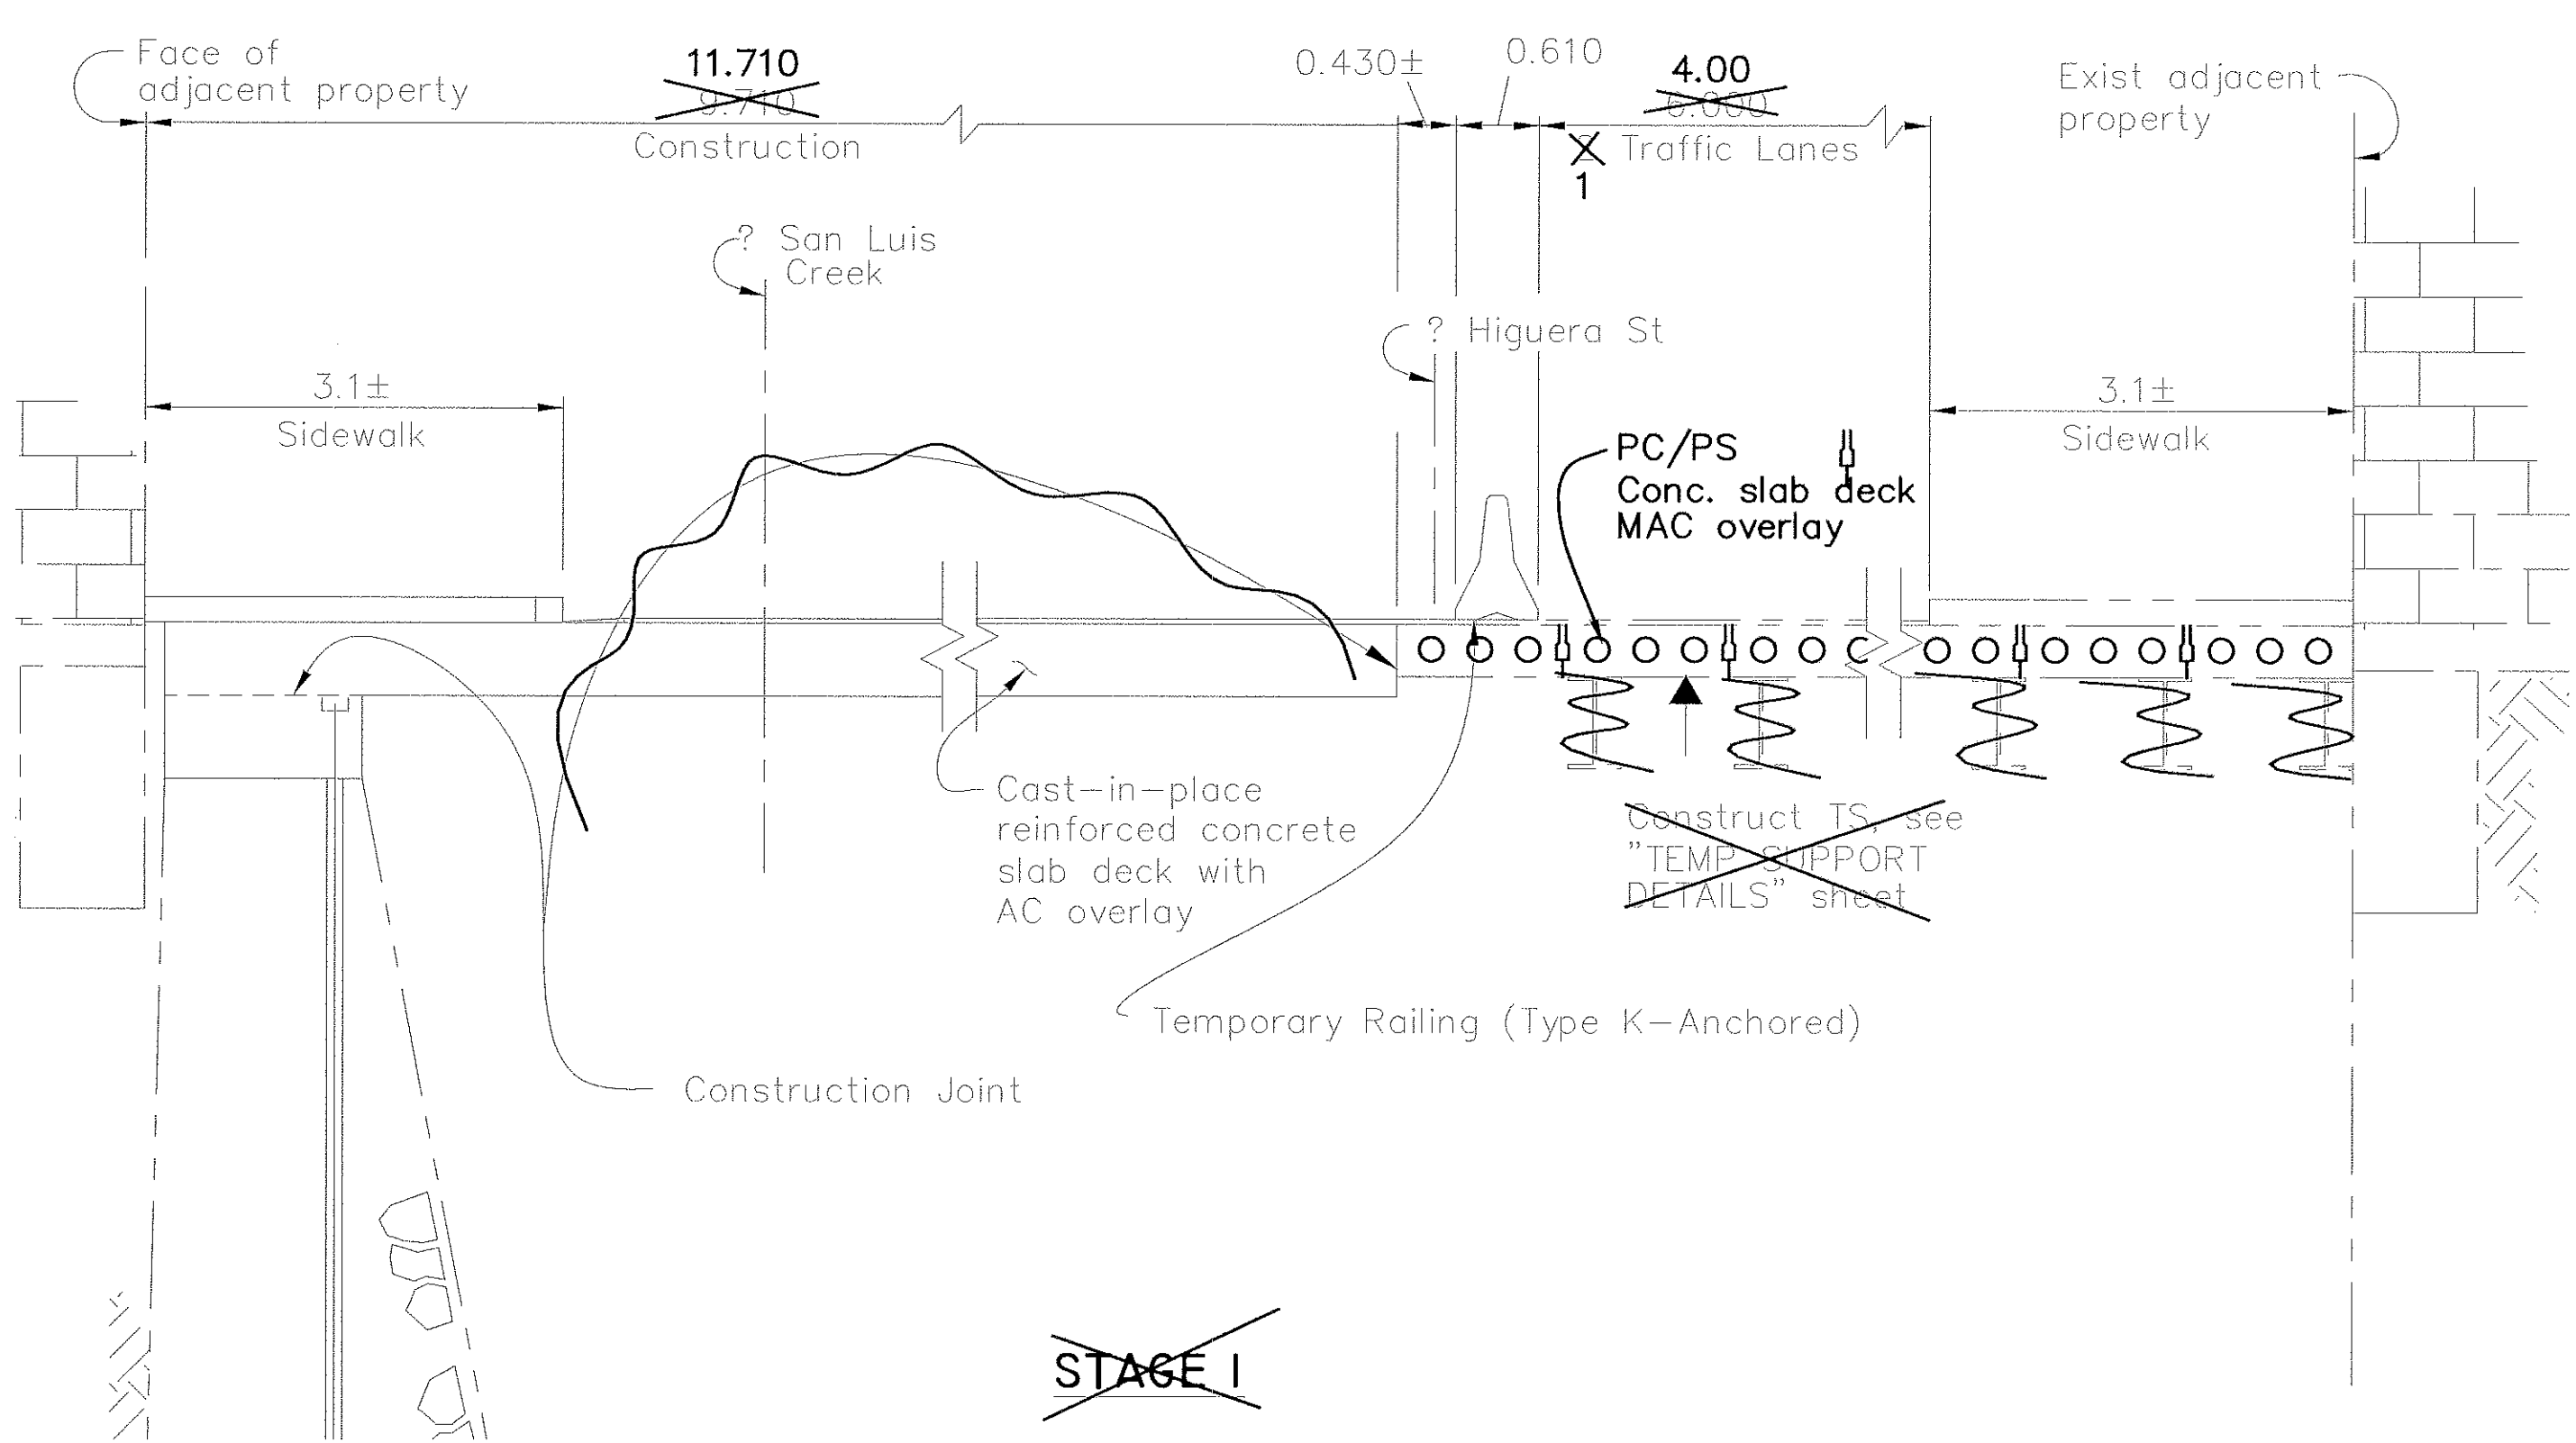


~~STAGE 1~~
PHASE 2
STAGE 2

SECTION F-F
Scale: 1:50

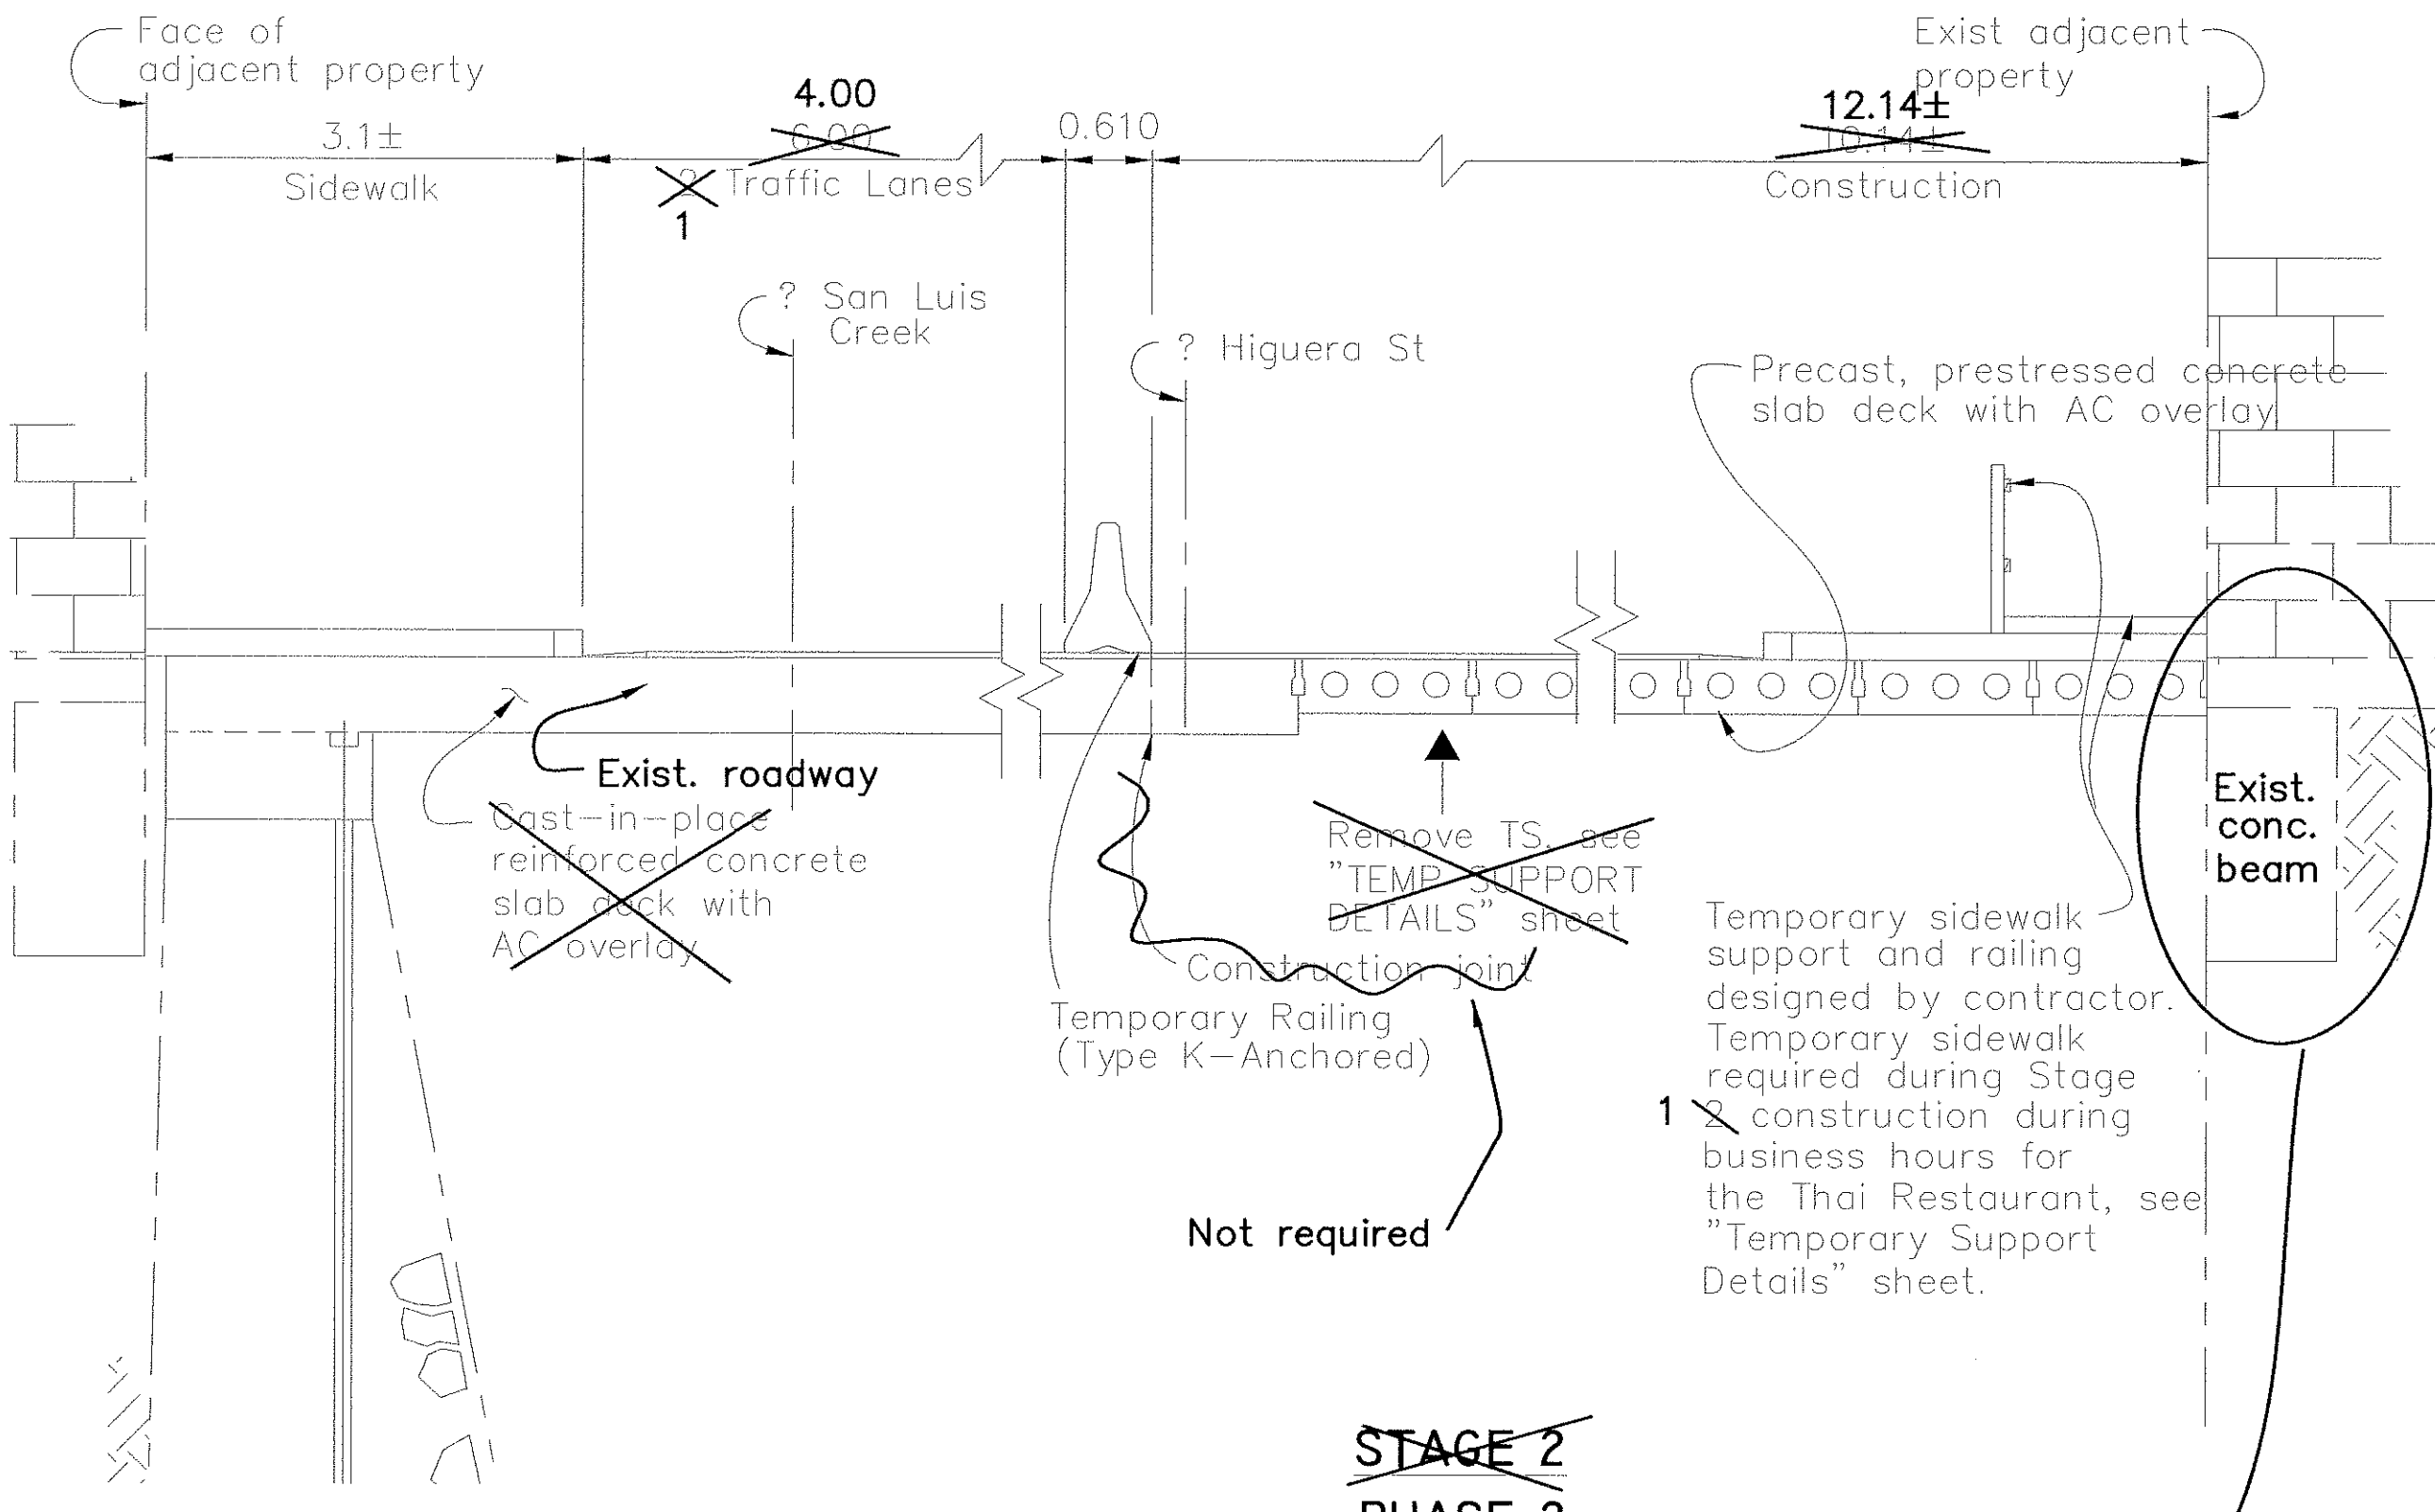

~~STAGE 2~~
PHASE 2
STAGE 1

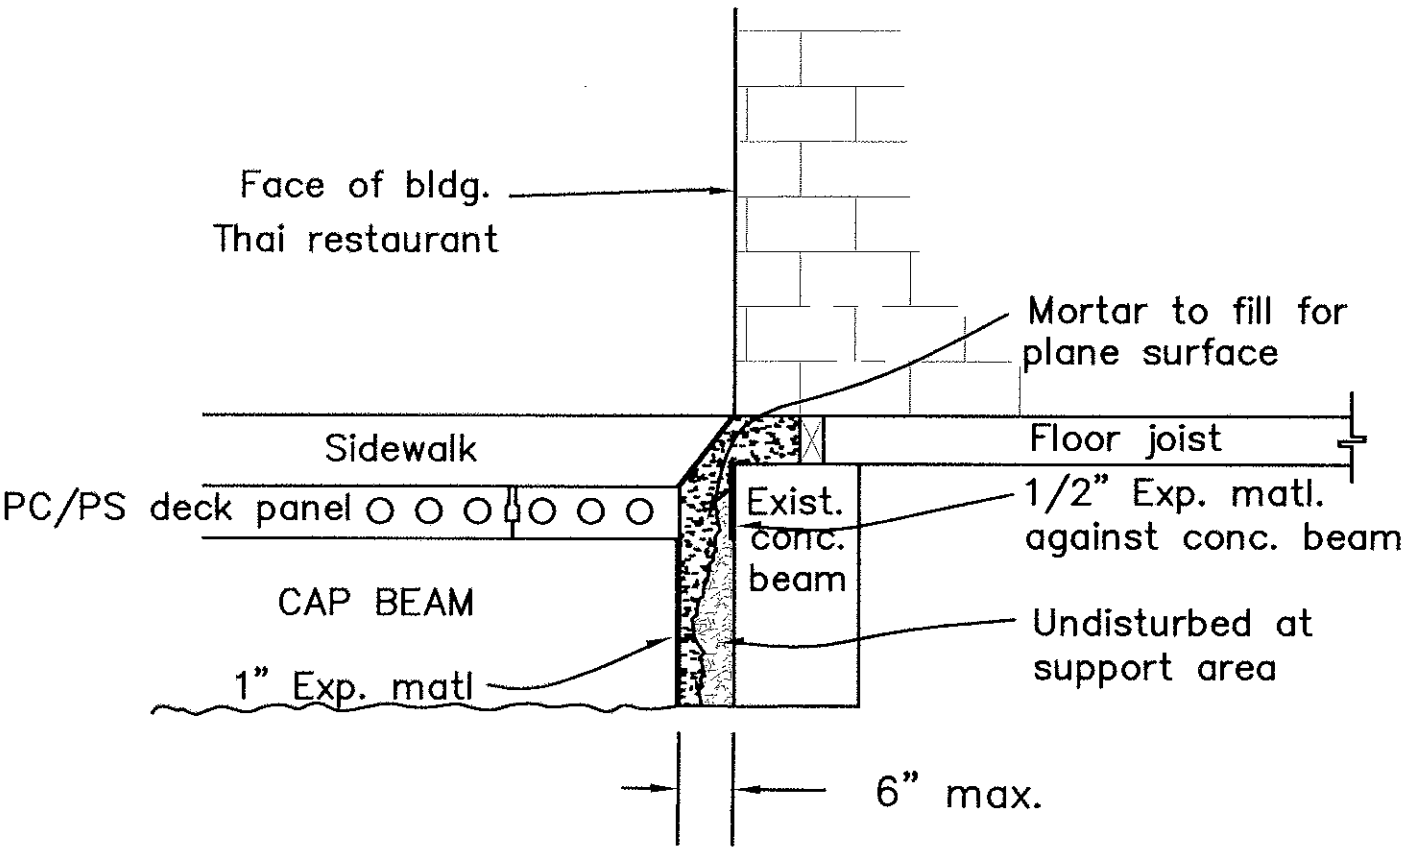


TYP. BOTH SIDES

The contractor shall verify all controlling field dimensions before ordering or fabricating any materials.

All dimensions are in meters unless otherwise noted.

RECORD DRAWING
DATE: 3/01/02 BY: SR

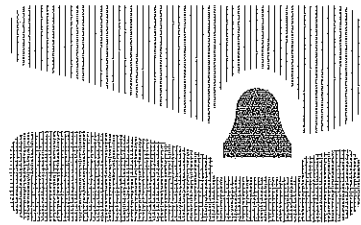

city of san luis obispo

HIGUERA STREET BRIDGE REPLACEMENT

FOR REDUCED PLANS
ORIGINAL SCALE IS IN MILLIMETERS

0 20 40 60 80 100

APPROVED BY

CITY ENGINEER

DATE: 3/2000
SCALE: As Noted
DESIGNED BY: R.F.
DRAWN BY: R.D., K.W.
CHECKED BY: R.R.
APPROVED BY:
UTILITIES DEPARTMENT

CONSTRUCTION STAGING
DETAILS NO. 3

SPECIFICATION NO.
9367
FILE NO./LOCATION
0060 B
SHEET
26R of 41



Legend:

 denotes masonry rock wall

Vx denotes void number



The contractor shall verify all controlling field dimensions before ordering or fabricating any materials.

All dimensions are in meters unless otherwise noted.



FOR REDUCED PLANS 0 20 40 60 80 100
ORIGINAL SCALE IS IN MILLIMETERS

CITY ENGINEER

VOID LOCATION PLAN

SPECIFICATION NO.
9367

FILE NO./LOCATION
0060 B

SHEET
27 OF 41

N:\MKSRV\1\MK PROJECTS\1997\97017.00 HIGUERA STREET BRIDGE REHAB\100% Submittal\97017-EG.dwg 3-17-00

Notes:

- Existing girders are shown in approximate location.
- Contractor shall field verify existing girder locations before installation of tiedowns.
- Tiedowns shall be evenly spaced between $\pm$ of existing girders.
- Tiedowns shall be spaced between 2.5 min and 3.0 max along existing abutment.
- Sectional dimensions are taken along $\pm$ of San Luis Creek.
- Insure that the new tiedowns do not conflict with the three existing tiedowns from test programs. Test program tiedowns are not to be used for final construction.
- Location of existing tiedowns in the north abutment are approximately at bridge stations 12+71.12, 12+76.29 and offset 2.00 North from $\pm$ San Luis Creek
- "Installation Procedure for Tiedown Anchors" are on the "Temporary Support Details" sheet.

No of tiedowns = 32 (see note 4)
16 "A" Shafts and 16 "B" Shafts

The contractor shall verify all controlling field dimensions before ordering or fabricating any materials.



DIST	COUNTY	ROUTE	POST MILES TOTAL PROJECT	SHEET NO.	TOTAL SHEETS
5	SLO		-	28	41

Ronald L. Rivett
REGISTERED CIVIL ENGINEER

4/5/00
PLANS APPROVAL DATE


MARTIN & KANE, Inc.
2200-B DOUGLAS BLVD, #150
ROSEVILLE • CA 95661



Legend:

▨ Limits of bridge removal

- Tiedown location (approximate) - "A" Shaft
- × Tiedown location (approximate) - "B" Shaft

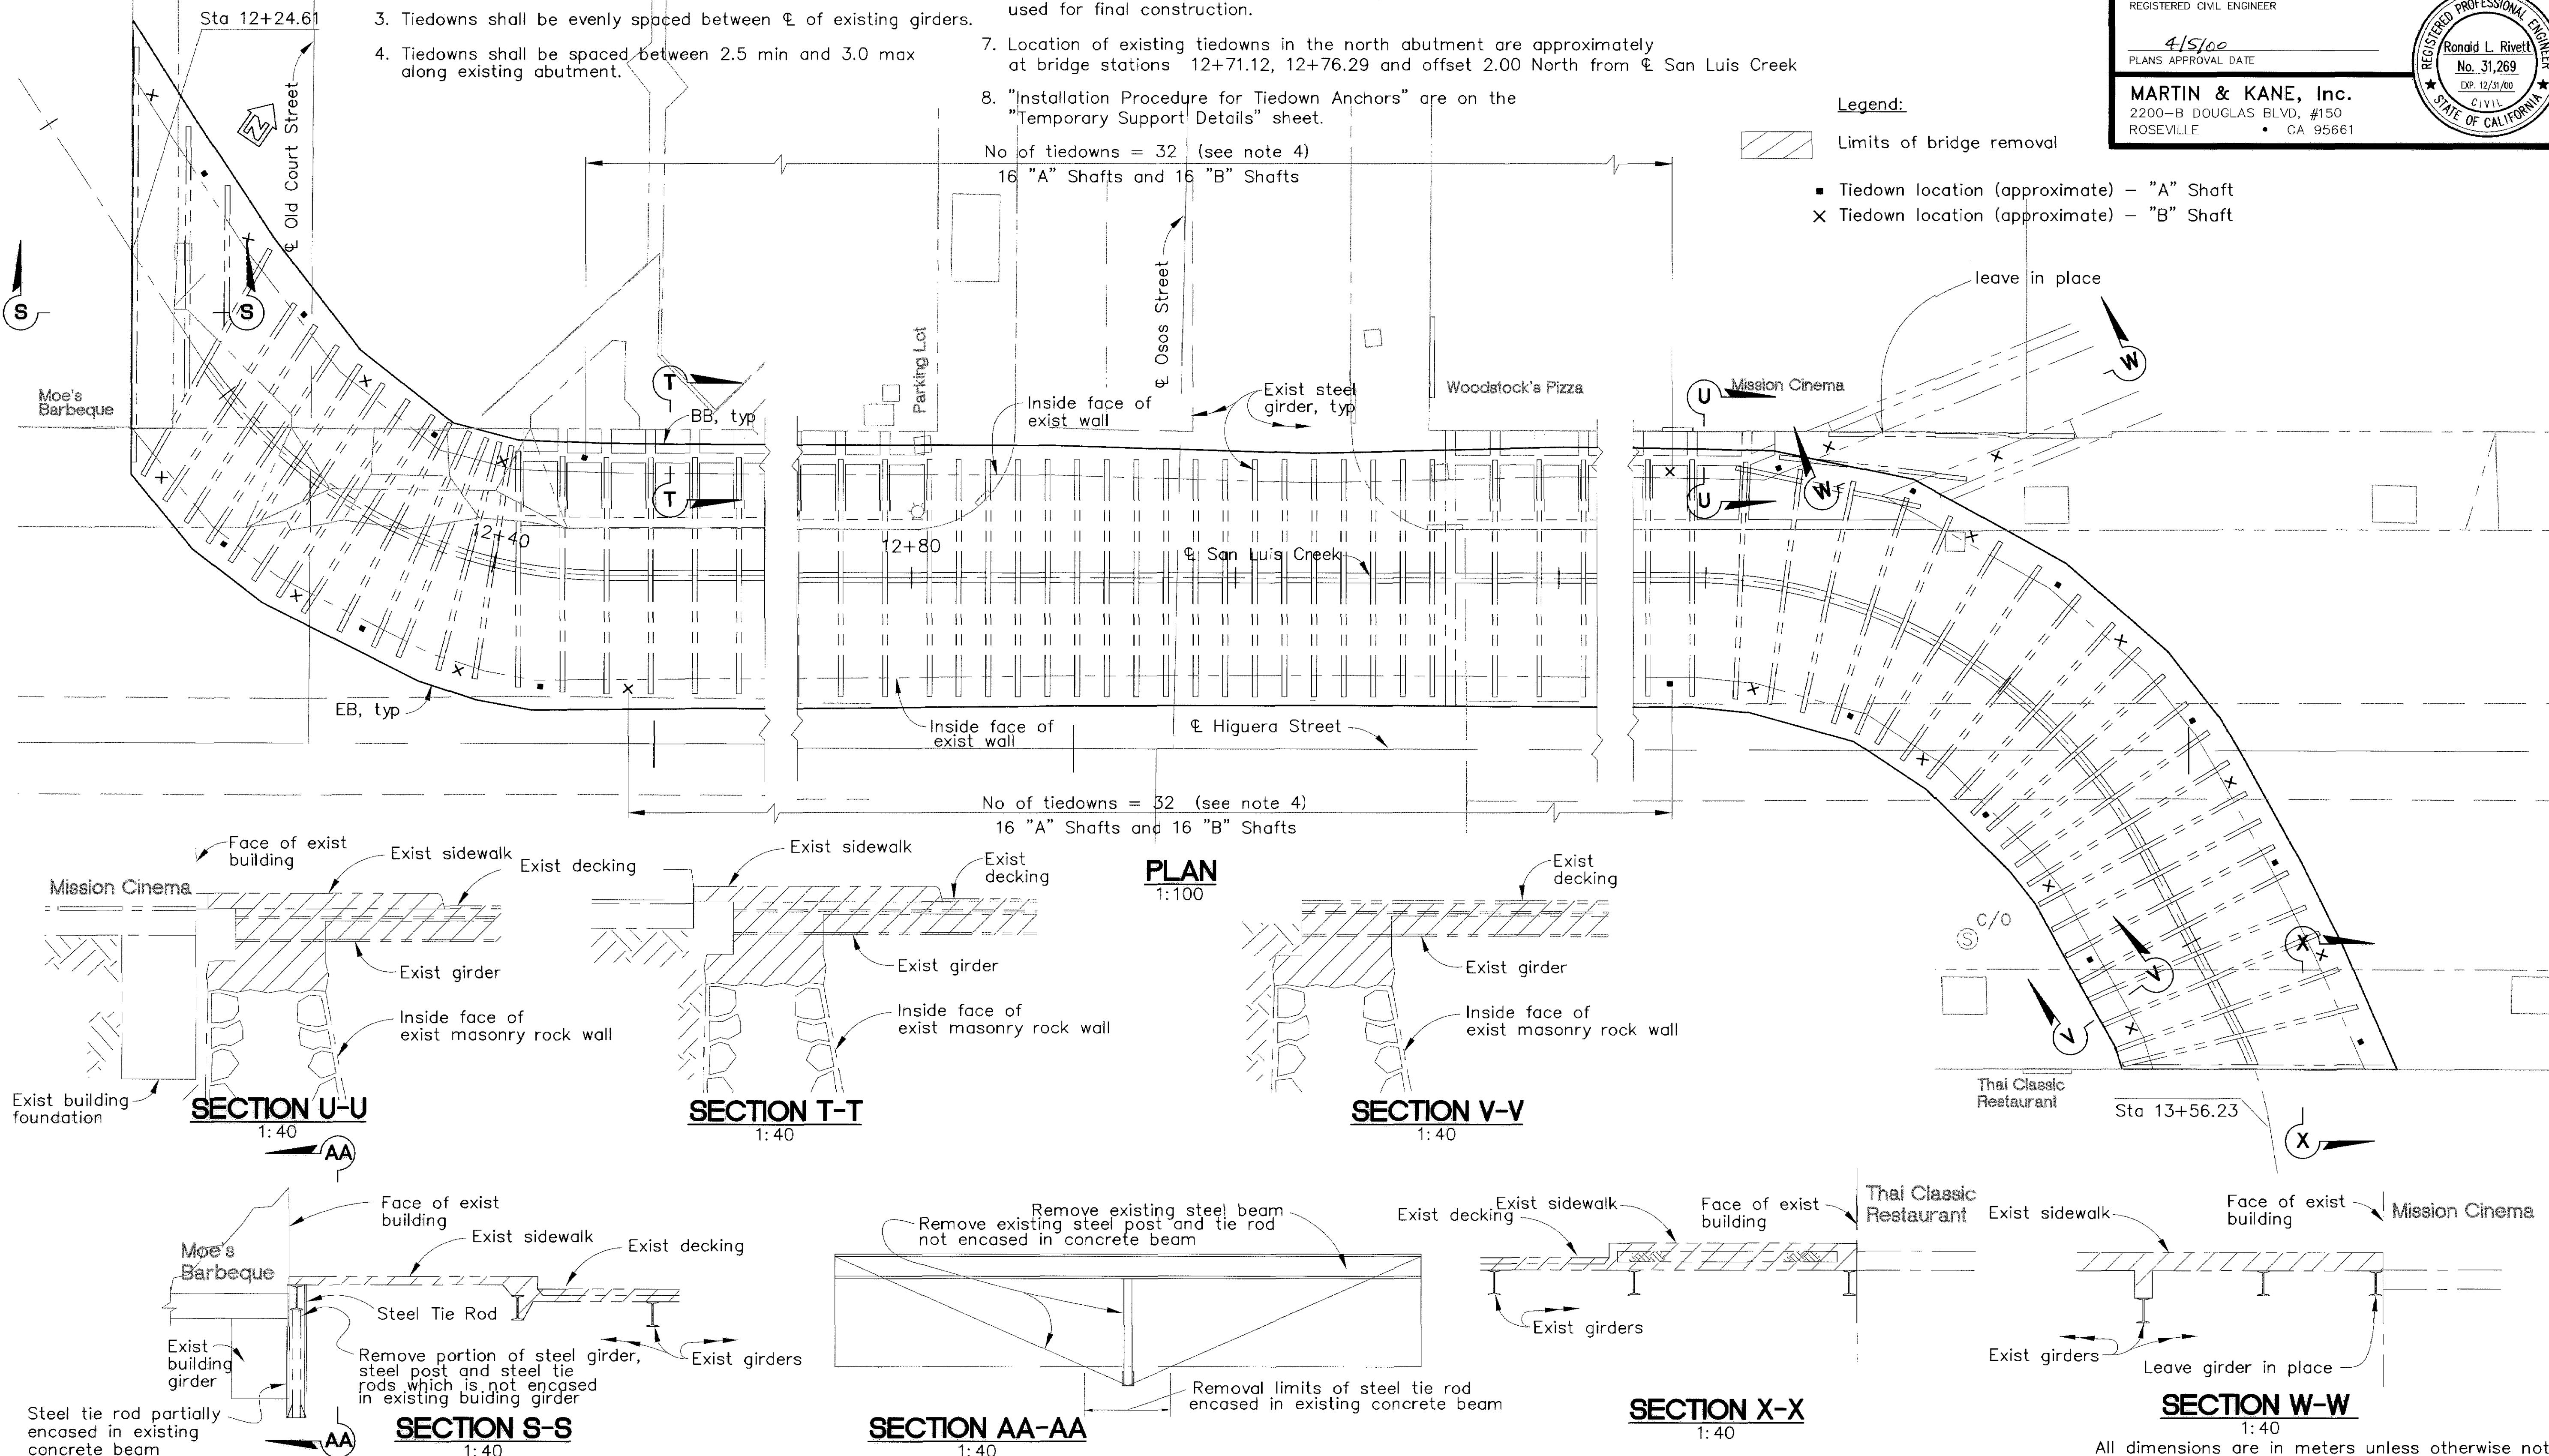

PLAN
1:100

SECTION U-U
1:40

SECTION T-T
1:40

SECTION V-V
1:40


SECTION S-S
1:40

SECTION AA-AA
1:40

SECTION X-X
1:40

SECTION W-W
1:40

All dimensions are in meters unless otherwise noted.

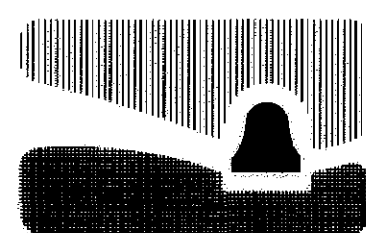

city of san luis obispo

HIGUERA STREET BRIDGE REPLACEMENT

FOR REDUCED PLANS
ORIGINAL SCALE IS IN MILLIMETERS

0 20 40 60 80 100

APPROVED BY

CITY ENGINEER

DATE 3/2000

SCALE As Noted

DESIGNED BY R.F.

DRAWN BY R.D., K.W.

CHECKED BY R.R.

APPROVED BY
UTILITIES DEPARTMENT

**EXISTING GIRDER LAYOUT
AND TIEDOWN ANCHOR LOCATIONS**

SPECIFICATION NO.


9367

FILE NO./LOCATION

0600 B

SHEET

28 of 41

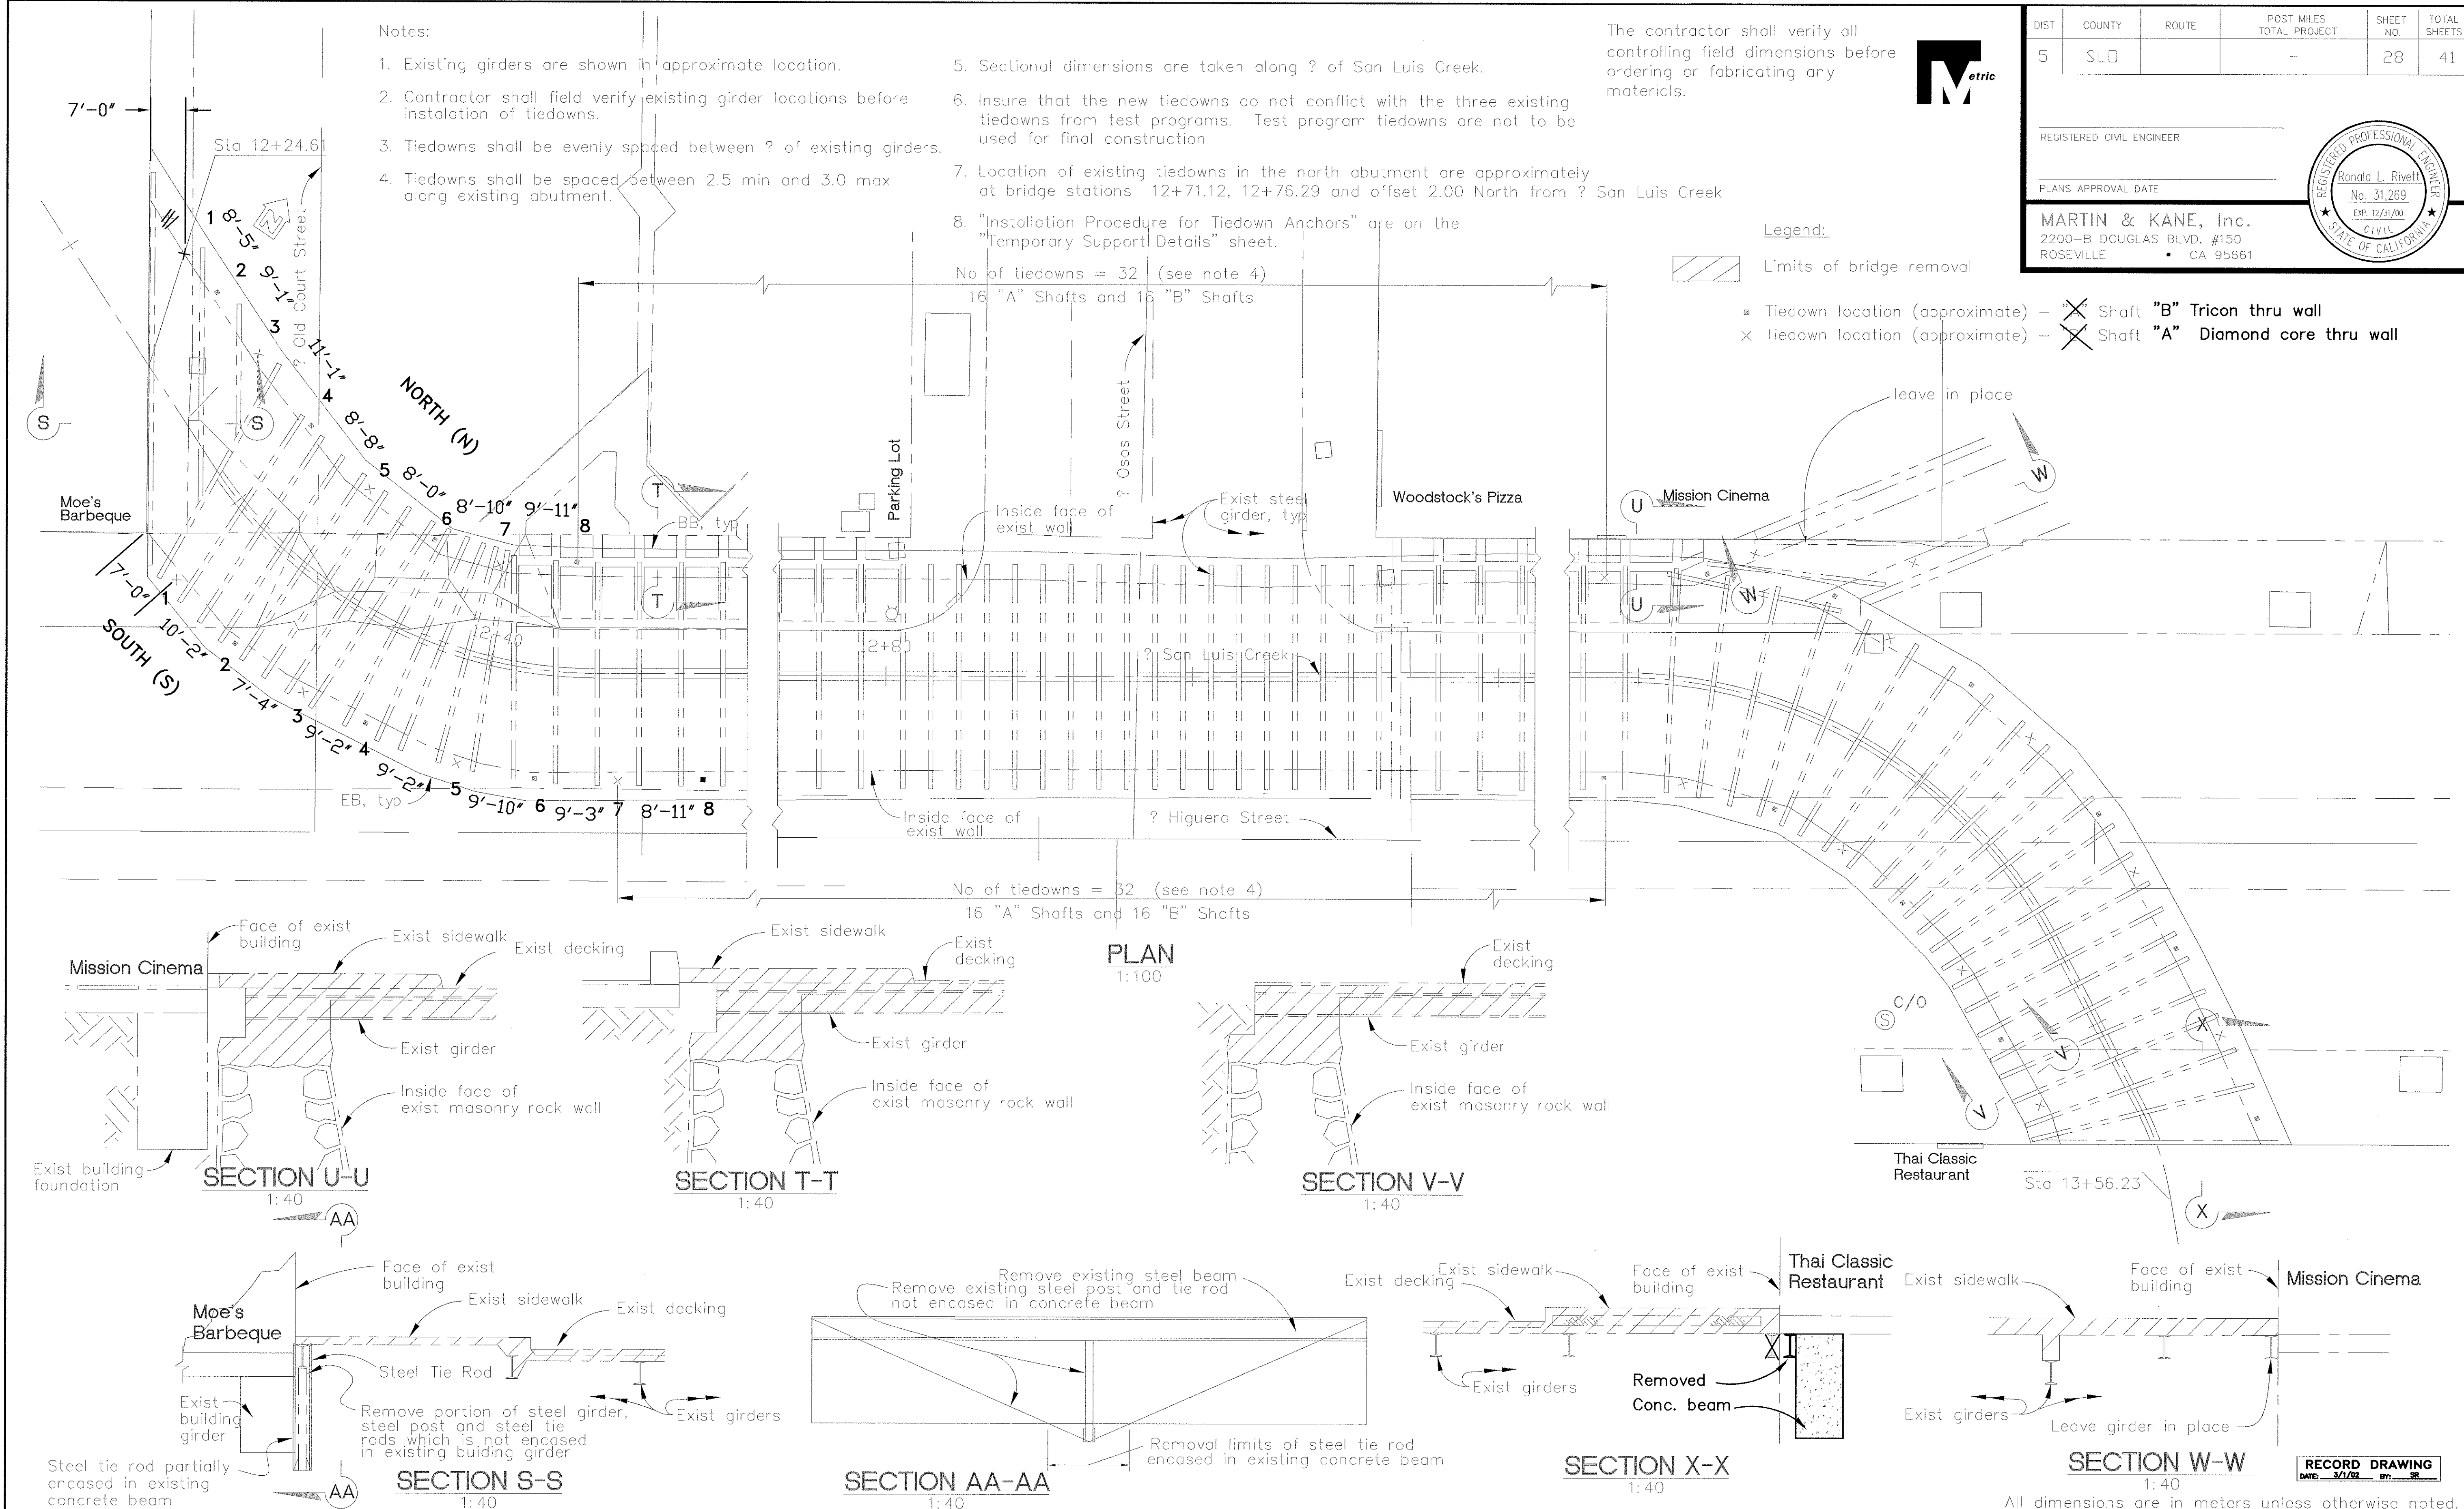

Notes:

- Existing girders are shown in approximate location.
- Contractor shall field verify existing girder locations before installation of tie-downs.
- Tie-downs shall be evenly spaced between ? of existing girders.
- Tie-downs shall be spaced between 2.5 min and 3.0 max along existing abutment.
- Sectional dimensions are taken along ? of San Luis Creek.
- Insure that the new tie-downs do not conflict with the three existing tie-downs from test programs. Test program tie-downs are not to be used for final construction.
- Location of existing tie-downs in the north abutment are approximately at bridge stations 12+71.12, 12+76.29 and offset 2.00 North from ? San Luis Creek
- "Installation Procedure for Tie-down Anchors" are on the "Temporary Support Details" sheet.

The contractor shall verify all controlling field dimensions before ordering or fabricating any materials.



DIST	COUNTY	ROUTE	POST MILES TOTAL PROJECT	SHEET NO.	TOTAL SHEETS
5	SLD		-	28	41

REGISTERED CIVIL ENGINEER


PLANS APPROVAL DATE

MARTIN & KANE, Inc.
2200-B DOUGLAS BLVD, #150
ROSEVILLE • CA 95661

REGISTERED PROFESSIONAL ENGINEER
Ronald L. Rivett
No. 31,269
EXP. 12/31/00
CIVIL
STATE OF CALIFORNIA

Legend:

- Limits of bridge removal
- Tie-down location (approximate) - X Shaft "B" Tricon thru wall
- Tie-down location (approximate) - X Shaft "A" Diamond core thru wall

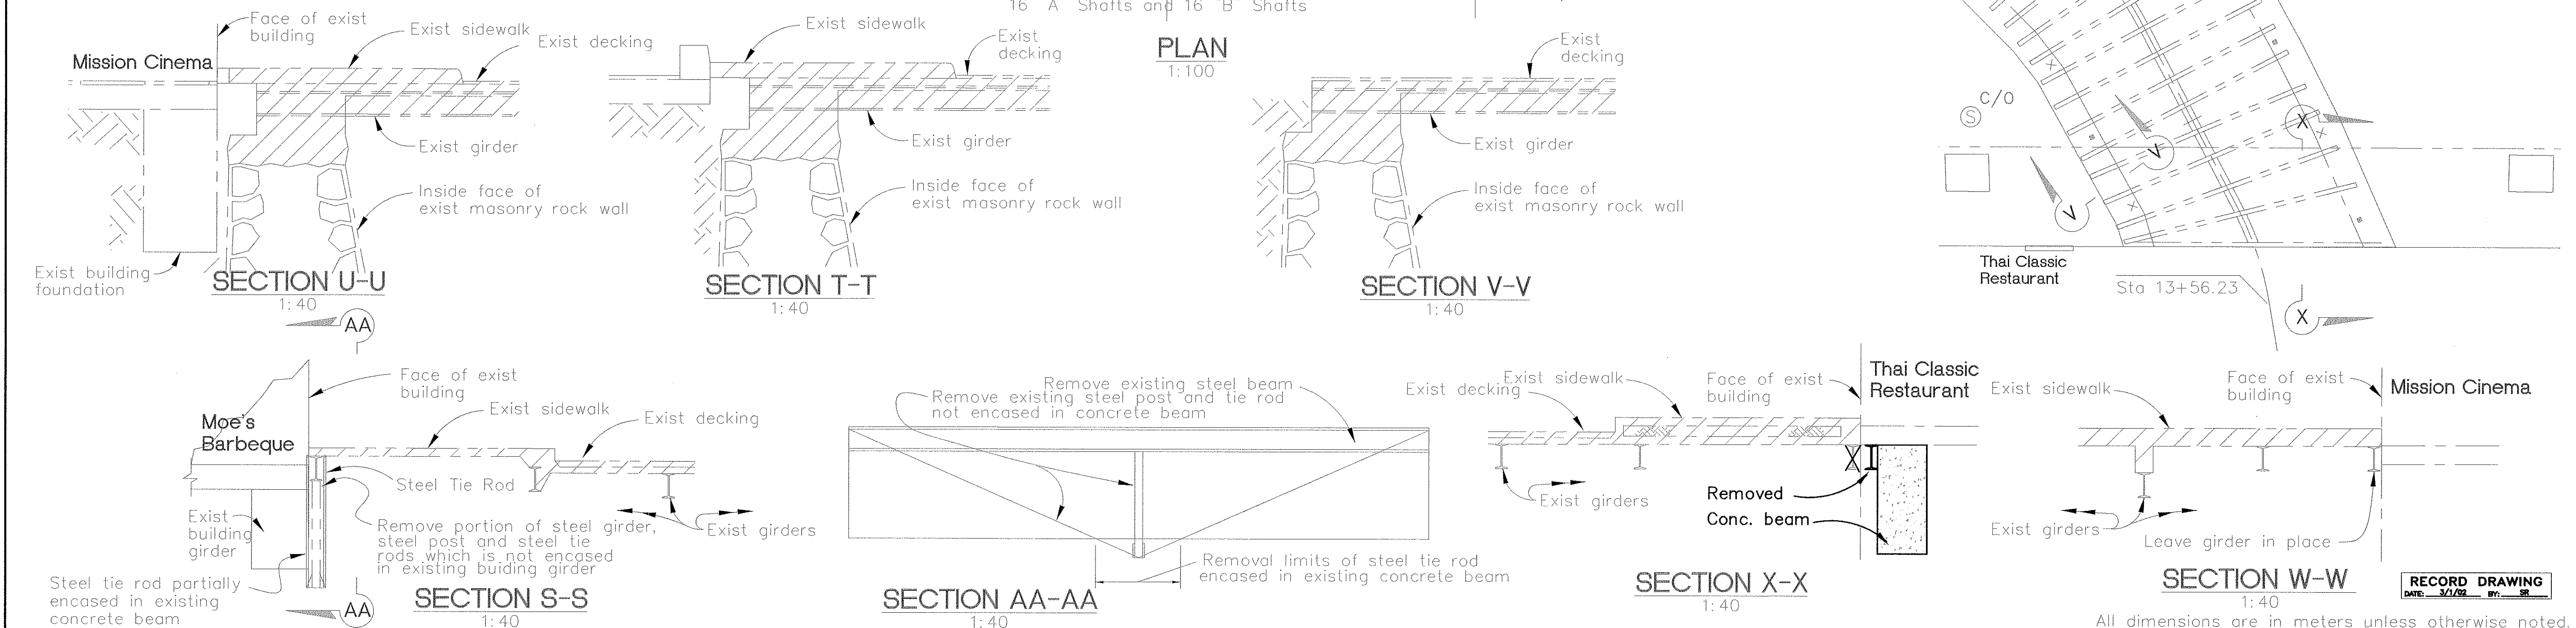




DIST	COUNTY	ROUTE	POST MILES TOTAL PROJECT	SHEET NO.	TOTAL SHEETS
5	SLO		—	29	41

Ronald L. Rivett
REGISTERED CIVIL ENGINEER

4/5/00
PLANS APPROVAL DATE

MARTIN & KANE, Inc.
2200-B DOUGLAS BLVD, #150
ROSEVILLE • CA 95661

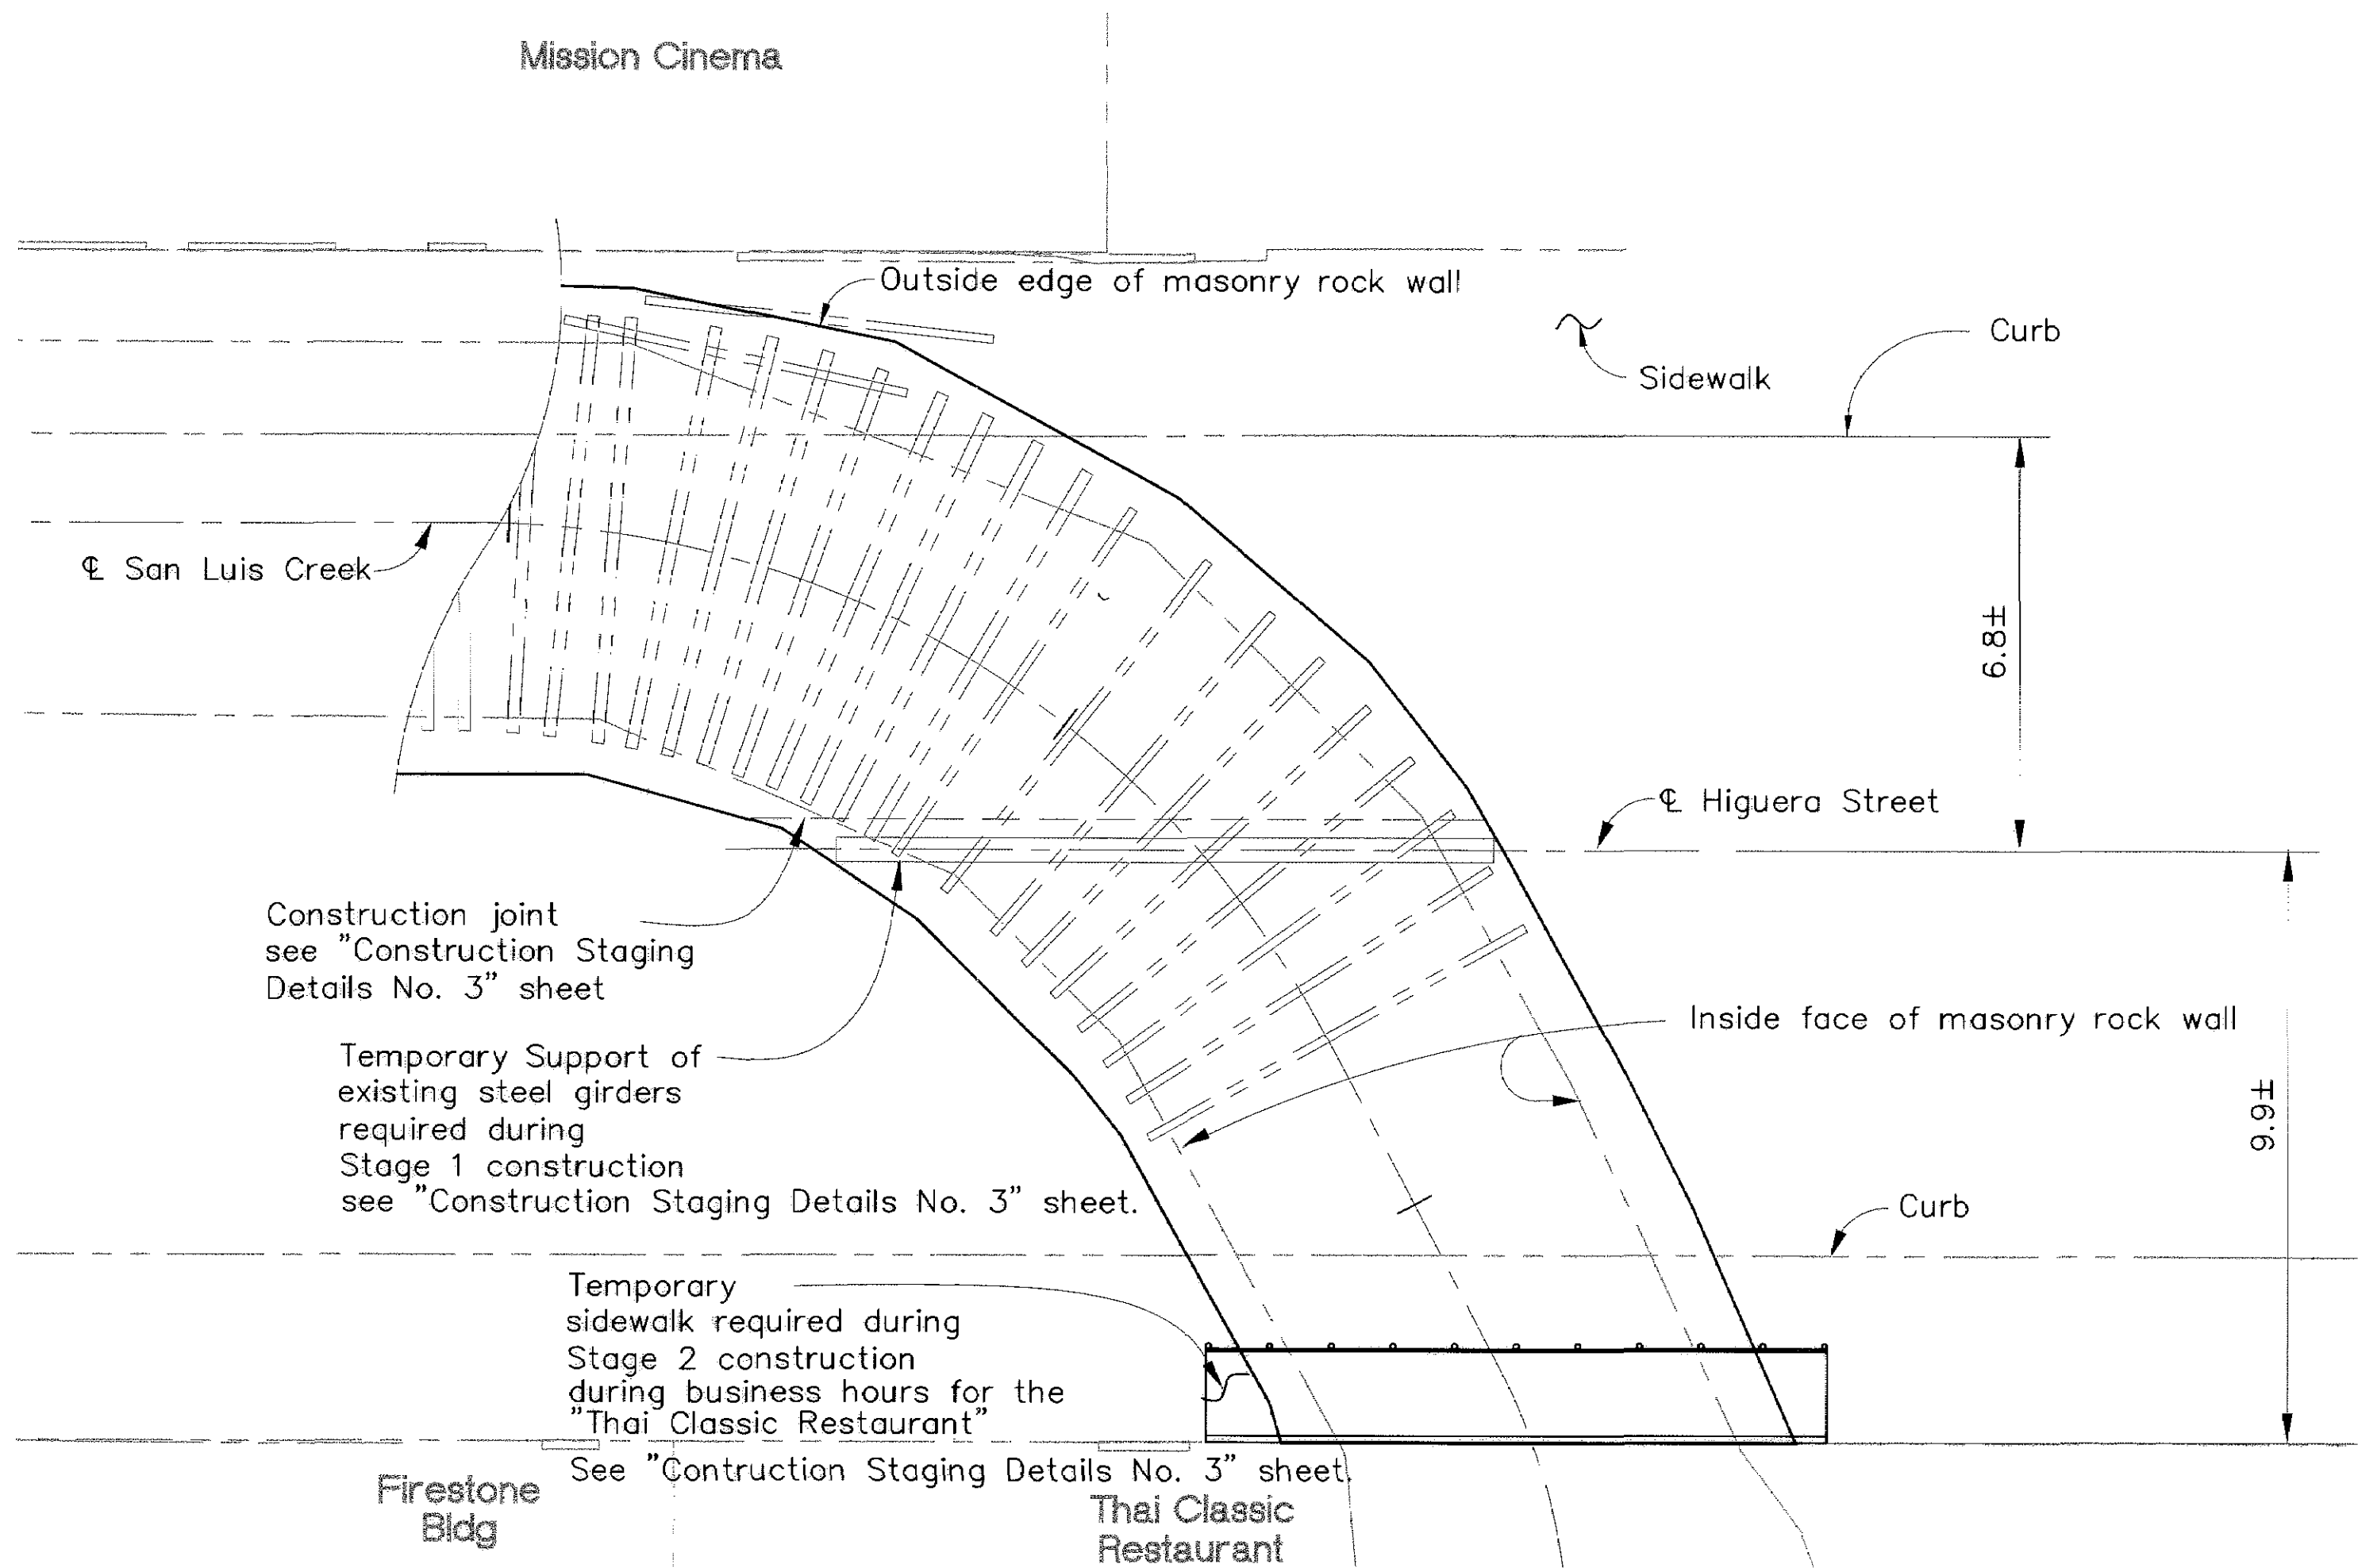

PART PLAN
Scale: 1:100

Note: For clarity not all
existing steel girders
are shown.


INSTALLATION PROCEDURE FOR TIEDOWN ANCHORS

1. Install pipe sleeve collar from top of masonry rock wall to above sidewalk/street grade to control and direct water up to the surface during the drilling operation.
2. Drill 100 mm diameter shafts at 2.5 meters minimum to 3.0 meters maximum on center (in between existing beams), or as directed by Engineer.
3. Shafts to be drilled alternately in "A" and "B" sequence. "A" shafts must be drilled and filled prior to start of drilling "B" shafts located immediately adjacent to "A" shaft.
4. Drilling of "A" shafts shall be performed with the diamond-core drill bit into the masonry wall to maximize spread of grout. Use only the tri-cone drill bit into bedrock soil beneath the wall in order to vacate cuttings in shafts by flushing with water. Drilling of "B" shafts may be with the use of tri-cone drill bit the full depth of the shaft. (Note: masonry wall may be drilled with diamond core for every shaft.)
5. Embedment depth into bedrock to be 3.0 meters minimum.
6. Place rod into shaft as soon as shaft is drilled and cleaned out. Provide centralizers at 3.0 meters o.c. maximum and one within 0.6 meters of bottom of shaft.
7. Provide PVC bond breaker sheathing to the portion of the rod in masonry rock wall. Ends of pvc sheathing to be sealed prior to grouting to prevent contamination.

8. Encase full length of shaft with 20.6 MPa neat cement/grout, with an approved fluidifier as required.
9. Test for compression strength when cement/grout has cured a minimum of 3 days.
10. After 20.6 MPa strength is obtained, tension test anchor rods per Specifications and Geotechnical Engineer's recommendations. The test set-up apparatus may bear on top of existing masonry wall. Proof test load shall be 150% of design load in increasing increments of 25% (cycling not required) up to test load. After successful testing release load on rod.
11. Repeat until all anchors are tested and certified.
12. Form, place rebar and provide stressing pocket in new concrete cap beam at top of existing wall.
13. After concrete cap beam has attained its design strength, stress anchor rods to design load and lock-off.
14. Grout annular space between rod and sheathing fully.
15. Fill anchor pocket in concrete cap beam with concrete/non-shrink grout.

The contractor shall verify all
controlling field dimensions before
ordering or fabricating any
materials.

All dimensions are in meters unless otherwise noted.

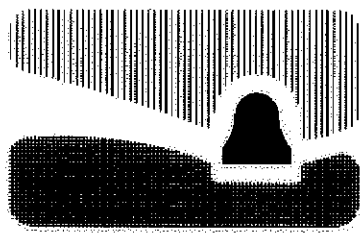

city of san luis obispo

HIGUERA STREET BRIDGE REPLACEMENT

FOR REDUCED PLANS
ORIGINAL SCALE IS IN MILLIMETERS



APPROVED BY

CITY ENGINEER

DATE 3/2000
SCALE As Noted
DESIGNED BY R.F.
DRAWN BY R.D., K.W.
CHECKED BY R.R.
APPROVED BY
UTILITIES DEPARTMENT

TEMPORARY SUPPORT DETAILS

SPECIFICATION NO.
9367
FILE NO./LOCATION
0060
SHEET
29 of 41

N:\MKSRV\1\K PROJECTS\1997\97017\00 HIGUERA STREET BRIDGE REHAB\100% Submittal\97017-TS.dwg 3-17-00



DIST	COUNTY	ROUTE	POST MILES TOTAL PROJECT	SHEET NO.	TOTAL SHEETS
5	SLO		—	29	41

REGISTERED CIVIL ENGINEER

PLANS APPROVAL DATE

MARTIN & KANE, Inc.

2200-B DOUGLAS BLVD. #150

ROSEVILLE • CA 95661

REGISTERED PROFESSIONAL ENGINEER


Ronald L. Rivett

No. 31,269

EXP. 12/31/00

CIVIL

STATE OF CALIFORNIA

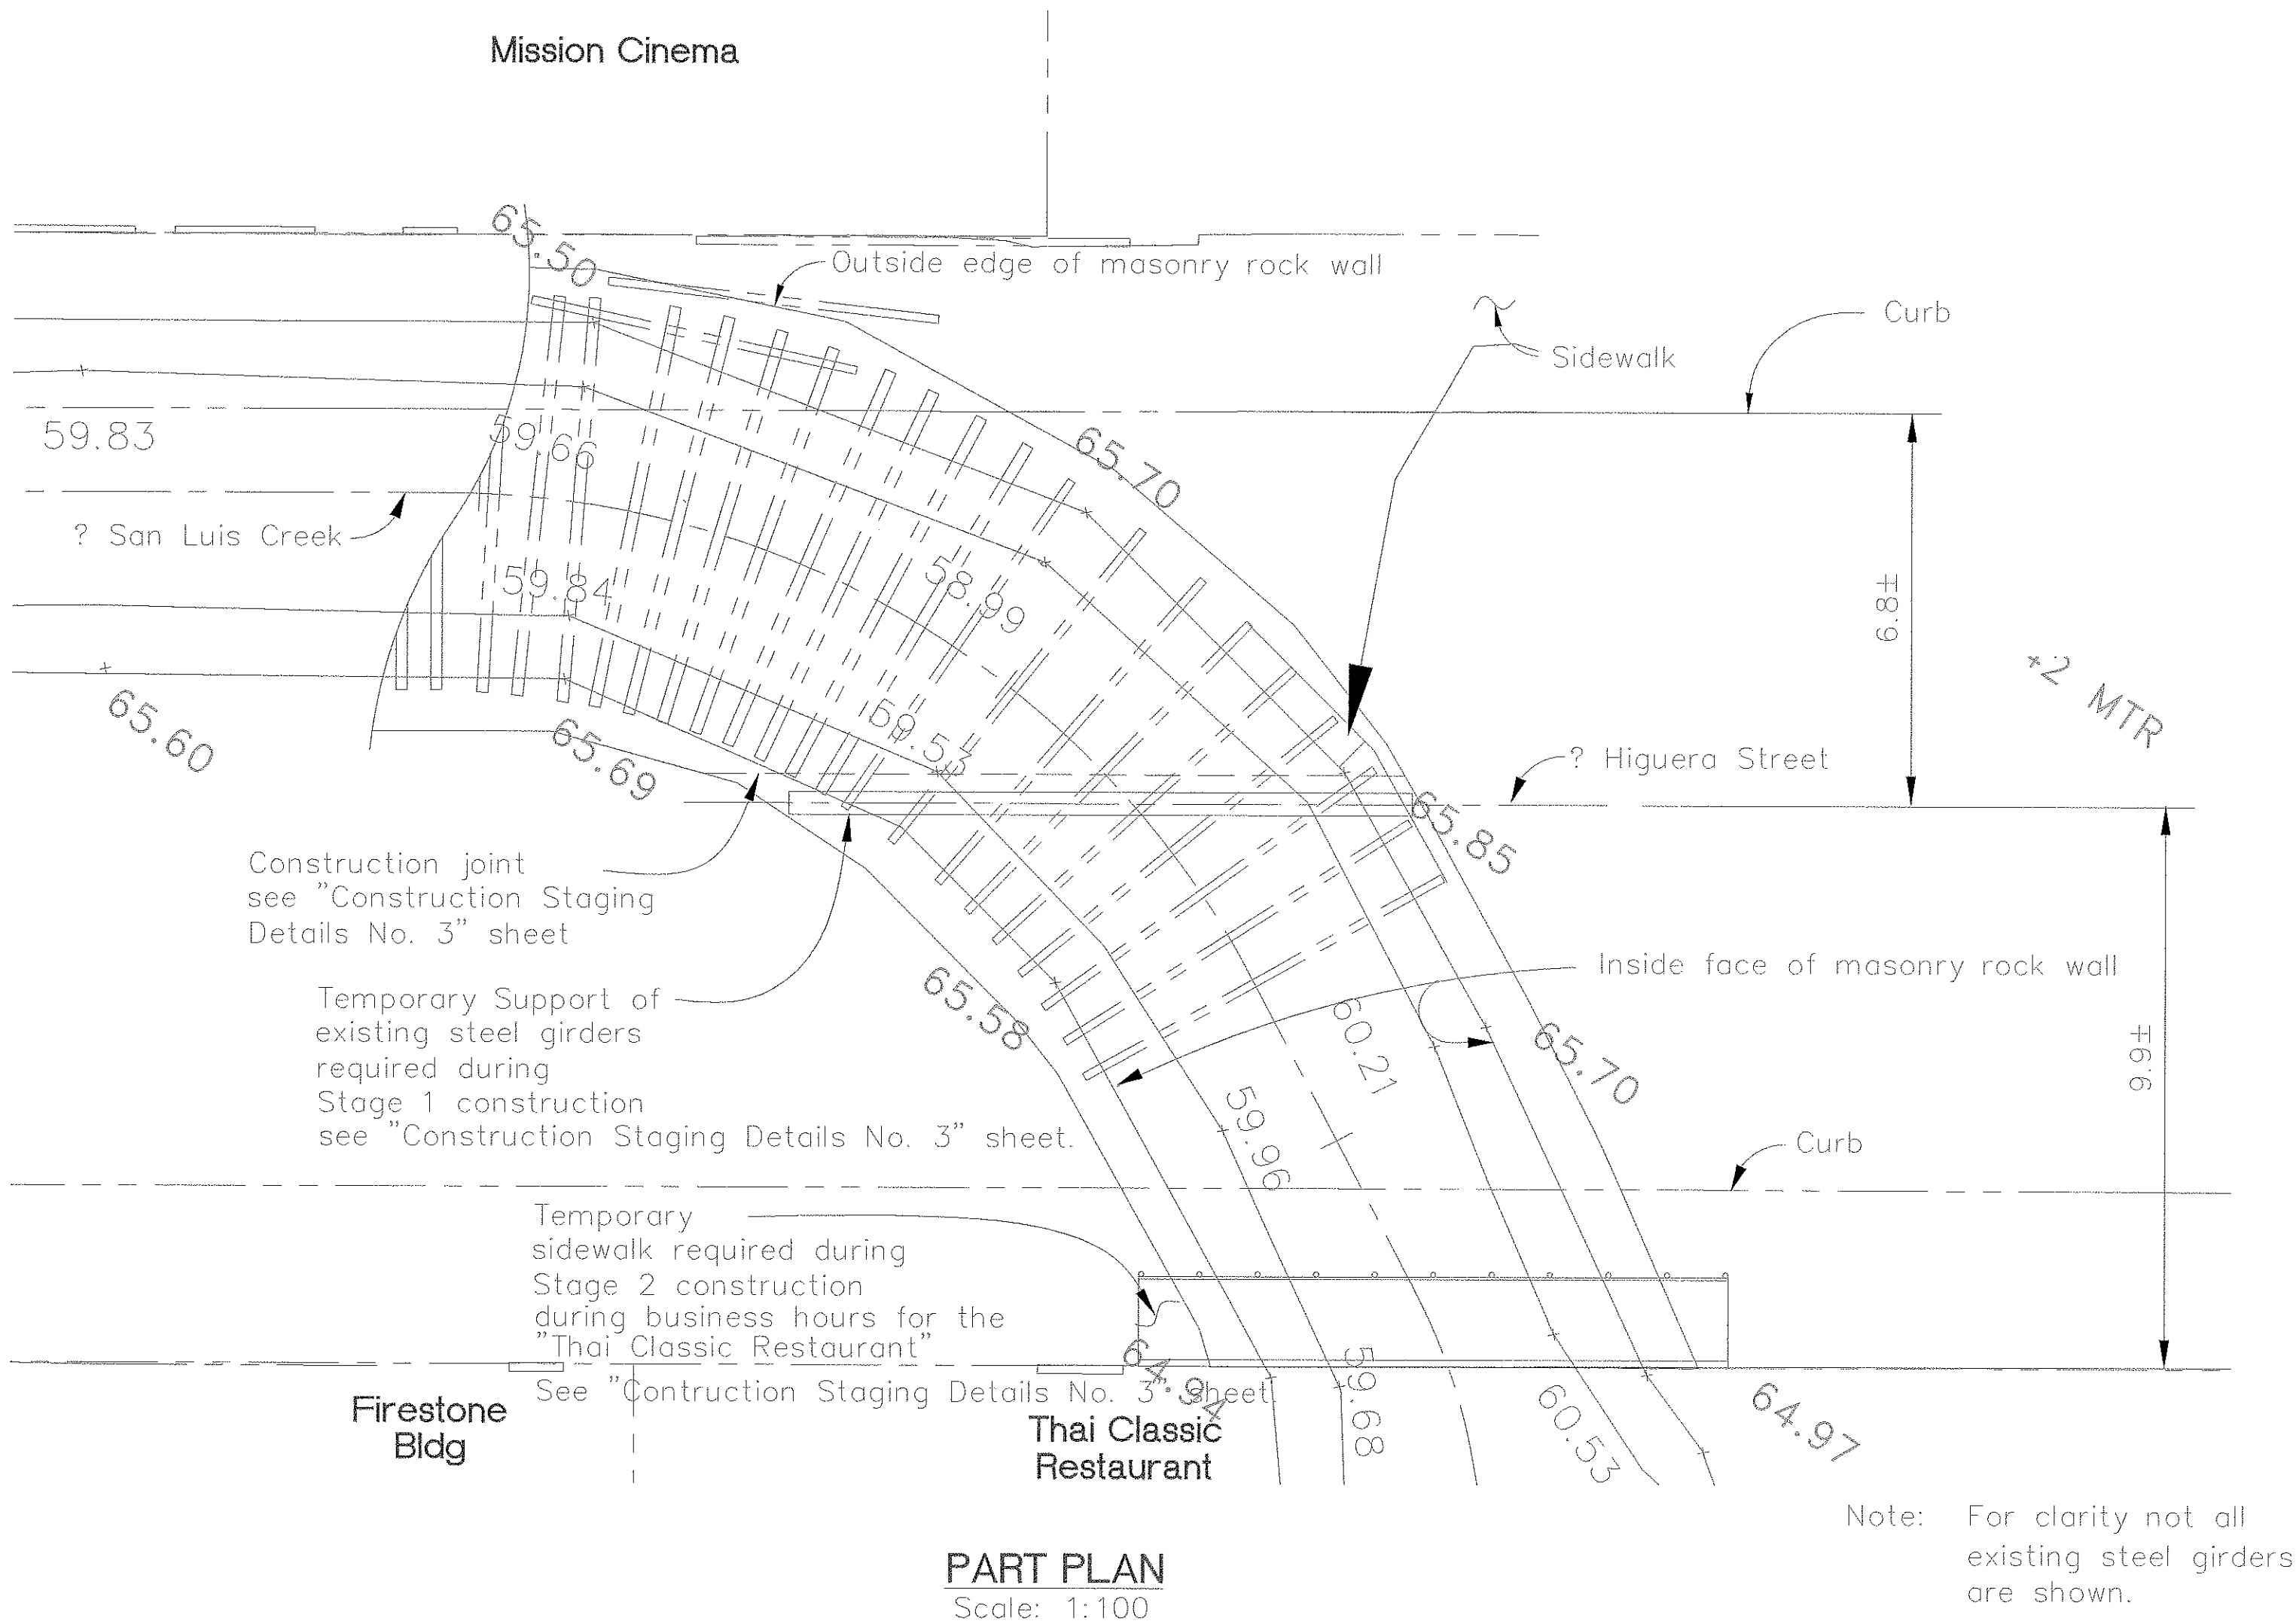

CCO #5 REVISED NOTE 5


INSTALLATION PROCEDURE FOR TIEDOWN ANCHORS

1. Install pipe sleeve collar from top of masonry rock wall to above sidewalk/street grade to control and direct water up to the surface during the drilling operation.
2. Drill 100 mm diameter shafts at 2.5 meters minimum to 3.0 meters maximum on center (in between existing beams), or as directed by Engineer.
3. Shafts to be drilled alternately in "A" and "B" sequence. "A" shafts must be drilled and filled prior to start of drilling "B" shafts located immediately adjacent to "A" shaft.
4. Drilling of "A" shafts shall be performed with the diamond-core drill bit into the masonry wall to maximize spread of grout. Use only the tri-cone drill bit into bedrock soil beneath the wall in order to vacate cuttings in shafts by flushing with water. Drilling of "B" shafts may be with the use of tri-cone drill bit the full depth of the shaft. (Note: masonry wall may be drilled with diamond core for every shaft.)
5. Embedment depth into bedrock to be ~~5.0~~ **5.0 meters minimum. or directed by the Engineer**
6. Place rod into shaft as soon as shaft is drilled and cleaned out. Provide centralizers at 3.0 meters o.c. maximum and one within 0.6 meters of bottom of shaft.
7. Provide PVC bond breaker sheathing to the portion of the rod in masonry rock wall. Ends of pvc sheathing to be sealed prior to grouting to prevent contamination.
8. Encase full length of shaft with 20.6 MPa neat cement/grout, with an approved fluidifier as required.
9. Test for compression strength when cement/grout has cured a minimum of 3 days.
10. After 20.6 MPa strength is obtained, tension test anchor rods per Specifications and Geotechnical Engineer's recommendations. The test set-up apparatus may bear on top of existing masonry wall. Proof test load shall be 150% of design load in increasing increments of 25% (cycling not required) up to test load. After successful testing release load on rod.
11. Repeat until all anchors are tested and certified.
12. Form, place rebar and provide stressing pocket in new concrete cap beam at top of existing wall.
13. After concrete cap beam has attained its design strength, stress anchor rods to design load and lock-off.
14. Grout annular space between rod and sheathing fully.
15. Fill anchor pocket in concrete cap beam with concrete/non-shrink grout.

The contractor shall verify all controlling field dimensions before ordering or fabricating any materials.

RECORD DRAWING
DATE: 3/1/99 BY: JR

All dimensions are in meters unless otherwise noted.

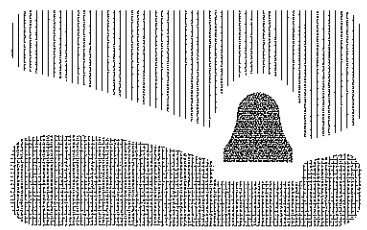

city of san luis obispo

HIGUERA STREET BRIDGE REPLACEMENT

FOR REDUCED PLANS
ORIGINAL SCALE IS IN MILLIMETERS
0 20 40 60 80 100

APPROVED BY

CITY ENGINEER

DATE 3/2000
SCALE As Noted
DESIGNED BY R.F.
DRAWN BY R.D., K.W.
CHECKED BY R.R.
APPROVED BY
UTILITIES DEPARTMENT

TEMPORARY SUPPORT DETAILS


SPECIFICATION NO.
9367
FILE NO./LOCATION
0060 B
SHEET
29 of 41

MKSERVER\PROJECTS\1997\97017.00 HIGUERA STREET BRIDGE REHAB\100% Submittal\97017-SLAB.dwg 3-17-00



DIST	COUNTY	ROUTE	POST MILES TOTAL PROJECT	SHEET NO.	TOTAL SHEETS
5	SLO		-	30	41
REGISTERED CIVIL ENGINEER					
PLANS APPROVAL DATE					
MARTIN & KANE, Inc. 2200-B DOUGLAS BLVD., #150 ROSEVILLE • CA 95661					

REGISTERED PROFESSIONAL ENGINEER
Ronald L. Rivett
No. 31,269
Exp. 12/31/00
CIVIL
STATE OF CALIFORNIA

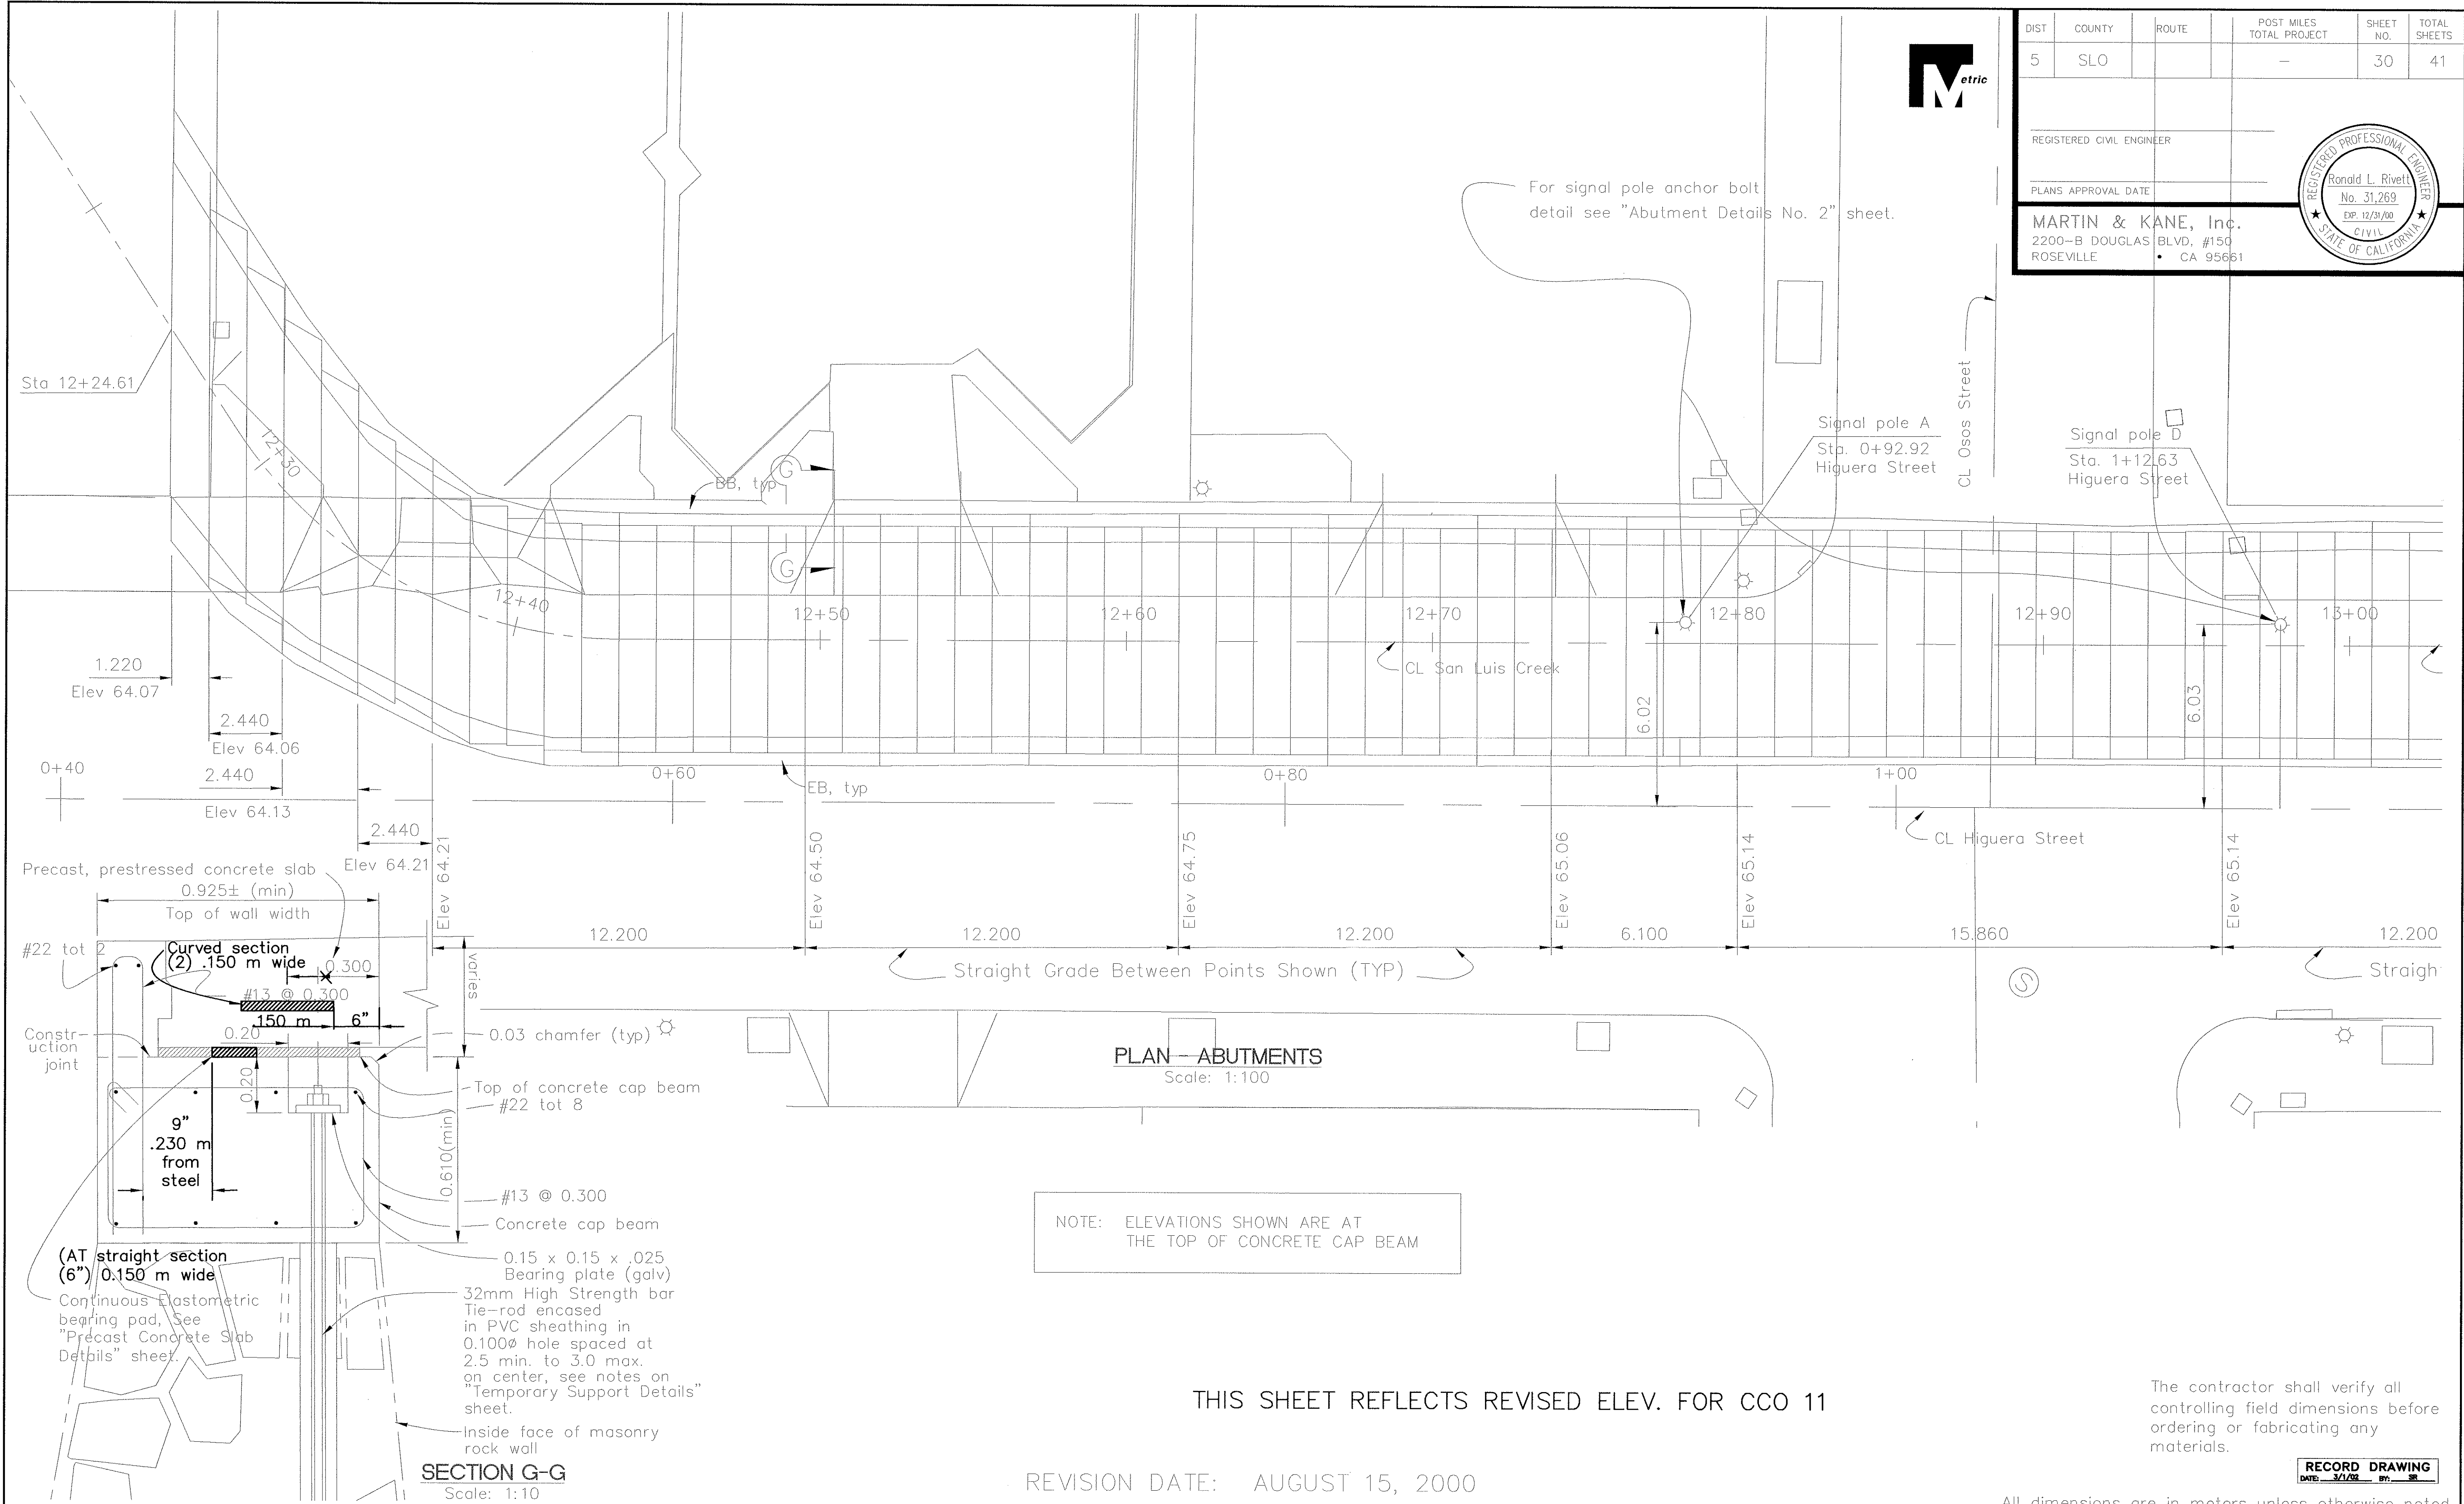

The contractor shall verify all controlling field dimensions before ordering or fabricating any materials.

RECORD DRAWING
DATE: 3/1/02 BY: SR

All dimensions are in meters unless otherwise noted

city of san luis obispo

HIGUERA STREET BRIDGE REPLACEMENT

APPROVED BY
CITY ENGINEER

DATE: 3/2000
SCALE: As Noted
DESIGNED BY: R.F.
DRAWN BY: R.D., K.W.
CHECKED BY: R.R.
APPROVED BY: R.R.
UTILITIES DEPARTMENT


ABUTMENT DETAILS NO. 1

SPECIFICATION NO.
9367

FILE NO./LOCATION
0066 B

SHEET
30 OF 41

\\MSERVER\PROJECTS\1997\97017.00 HIGUERA STREET BRIDGE REHA\100% Submittal\97017-SLAB.dwg 3-17-00




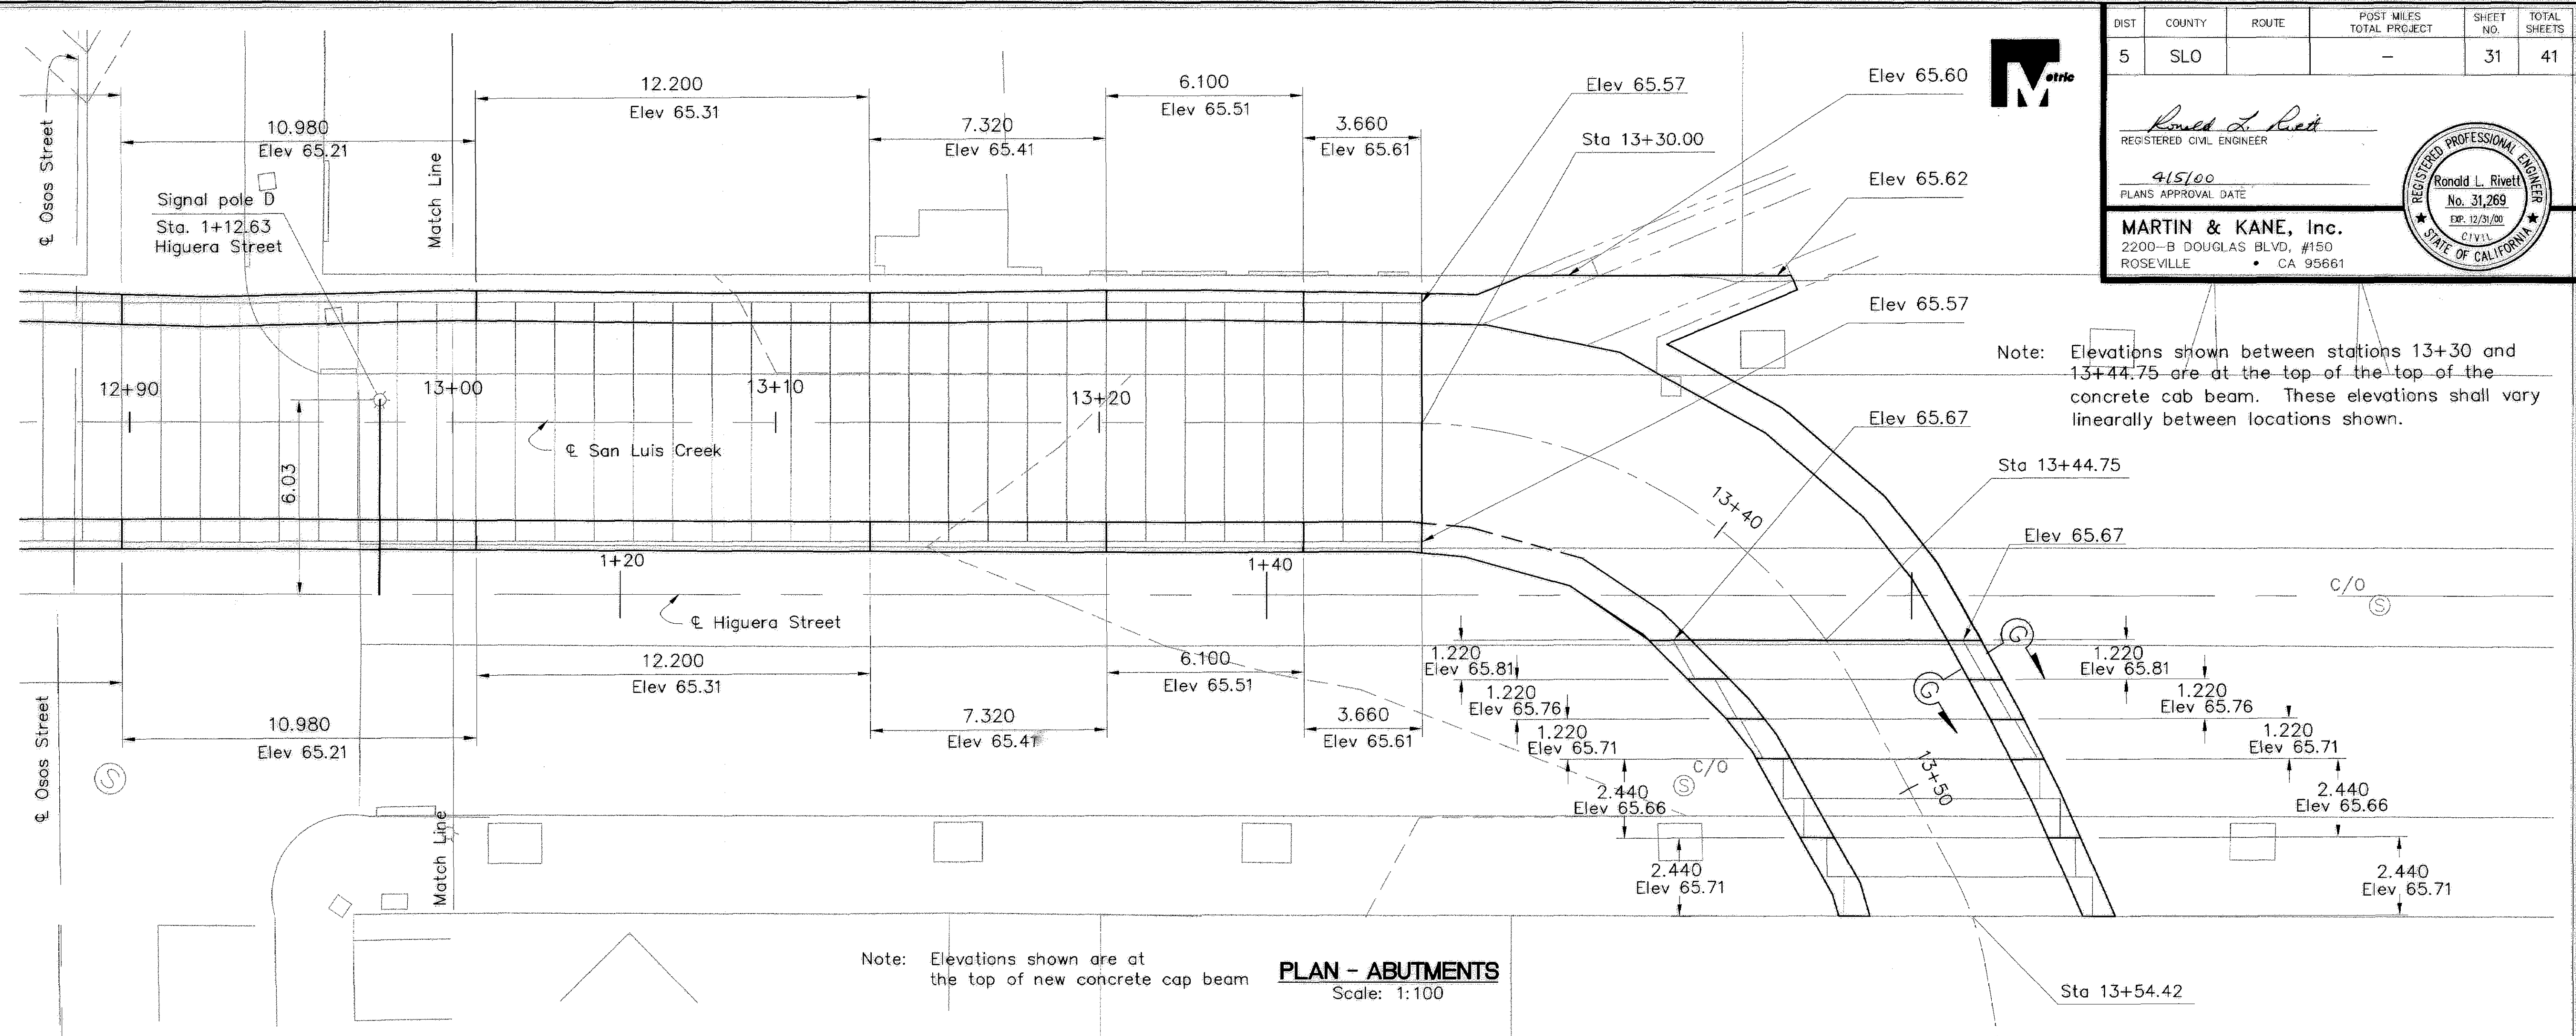


DIST	COUNTY	ROUTE	POST MILES TOTAL PROJECT	SHEET NO.	TOTAL SHEETS
5	SLO		-	31	41

REGISTERED CIVIL ENGINEER
Ronald L. Rivett
No. 31,269
EXP. 12/31/00
CIVIL
STATE OF CALIFORNIA

MARTIN & KANE, Inc.
2200-B DOUGLAS BLVD, #150
ROSEVILLE, CA 95661

PLANS APPROVAL DATE: 4/5/00

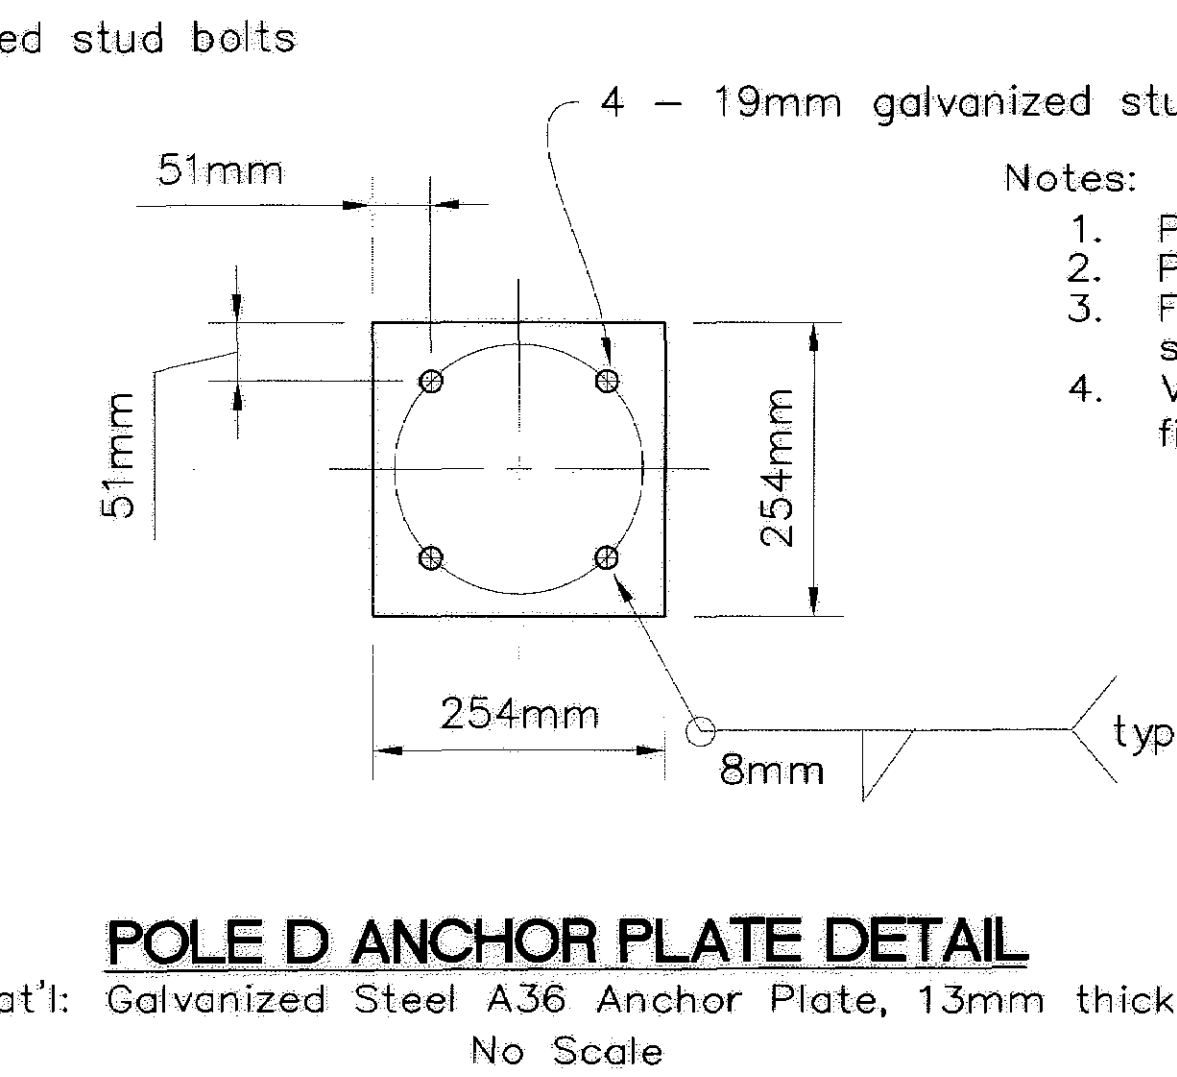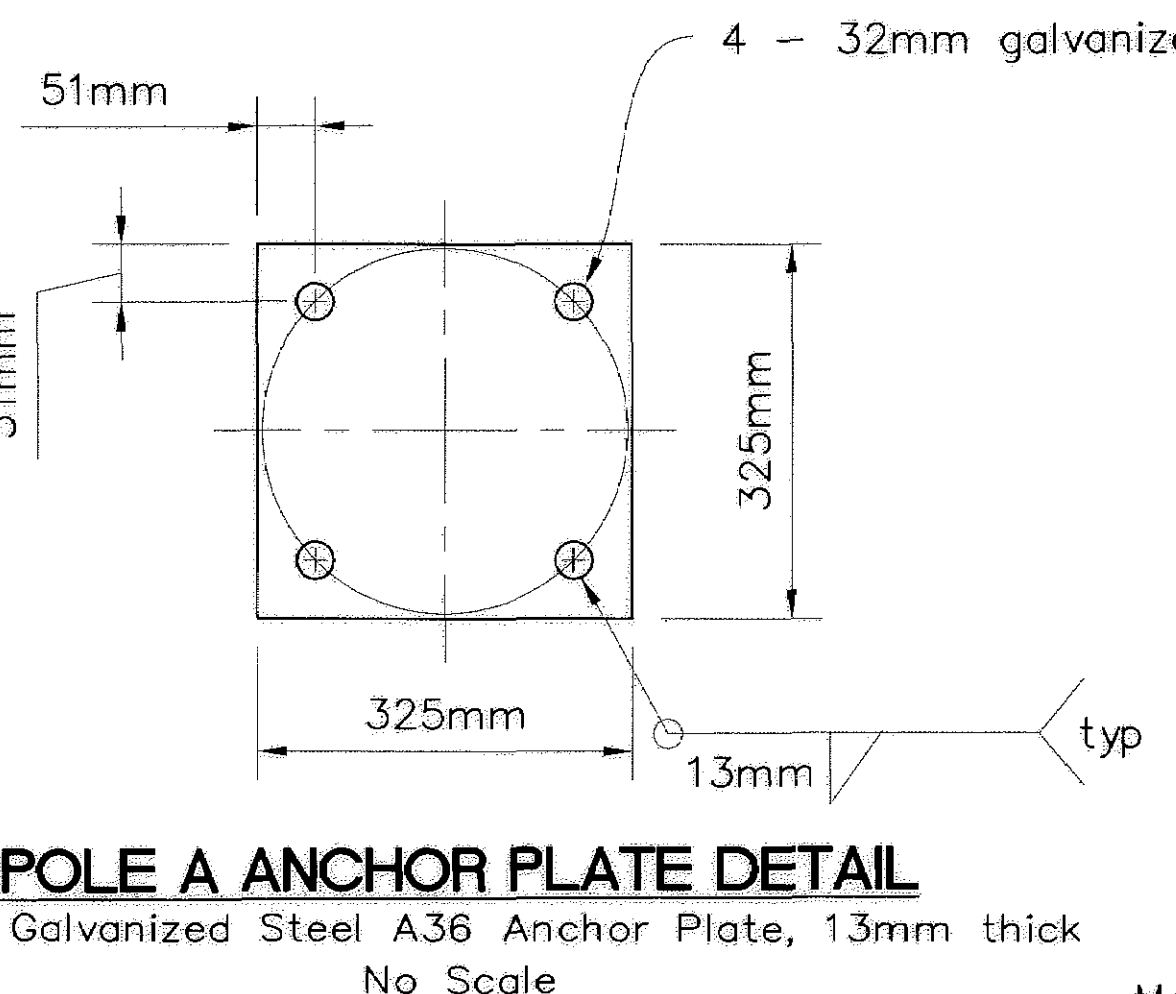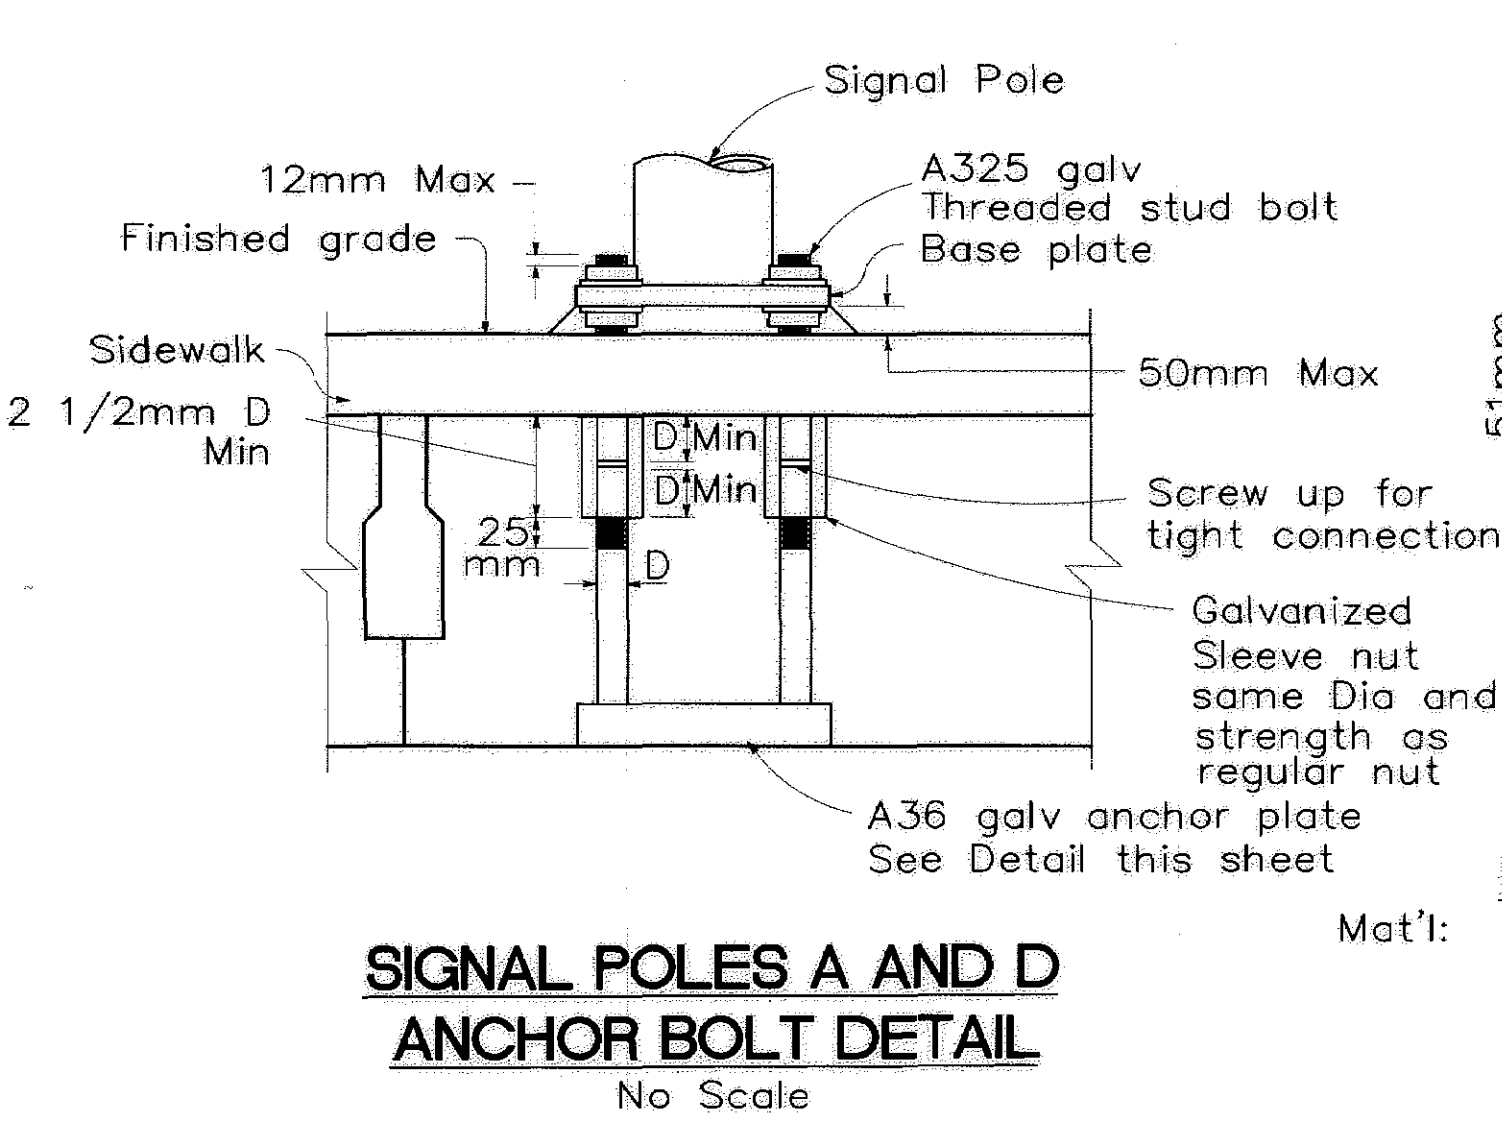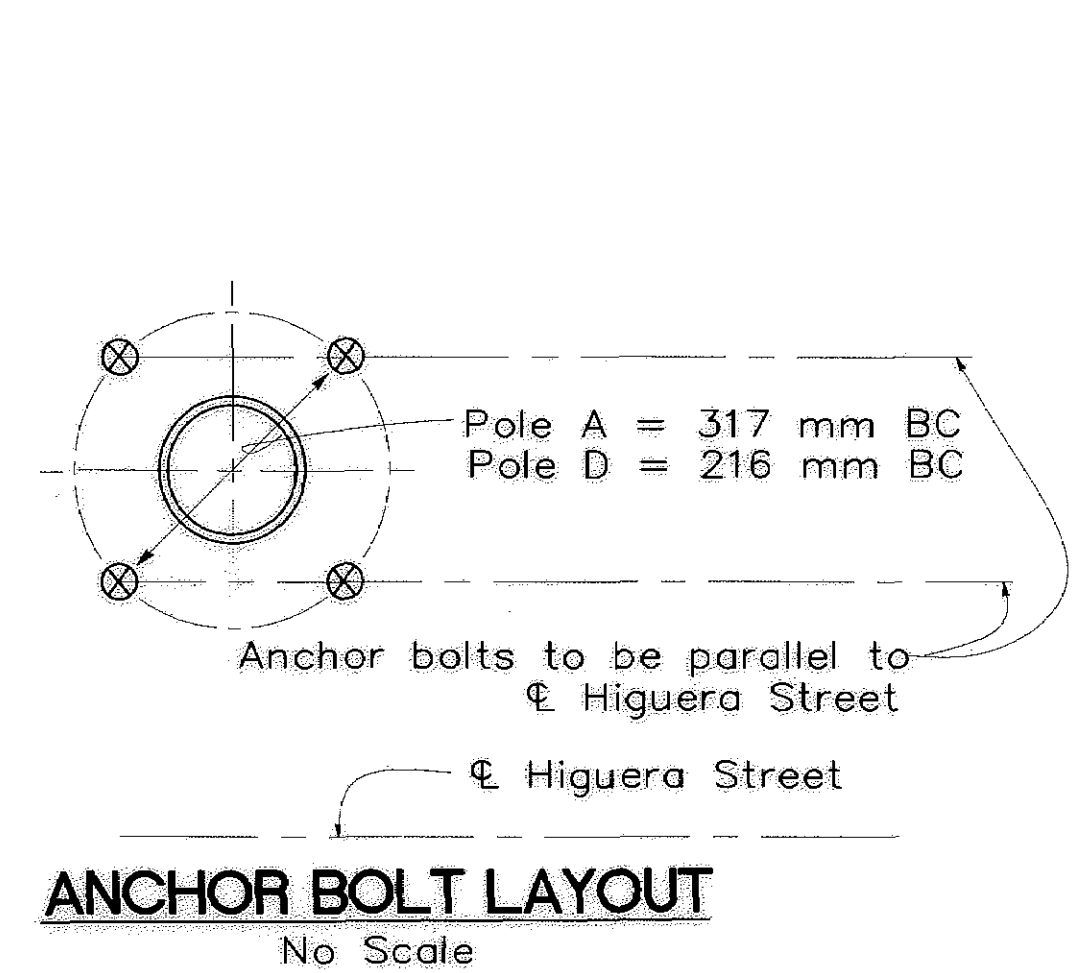


- Notes:
1. Pole A has 4 - 32mm A325 anchor bolts.
 2. Pole D has 4 - 19mm A325 anchor bolts.
 3. For location and details of signal poles A and D see "Traffic Signal and Lighting Plan" sheet.
 4. Voids in "Precast Prestressed Slab" unit to be filled within 0.6m of "Anchor Plate".


The contractor shall verify all controlling field dimensions before ordering or fabricating any materials.

All dimensions are in meters unless otherwise noted

\\MKSERVER\PROJECTS\1997\970117.00 HIGUERA STREET BRIDGE REHAUF 100% Submittal\970117-SLAB.dwg 3-17-00



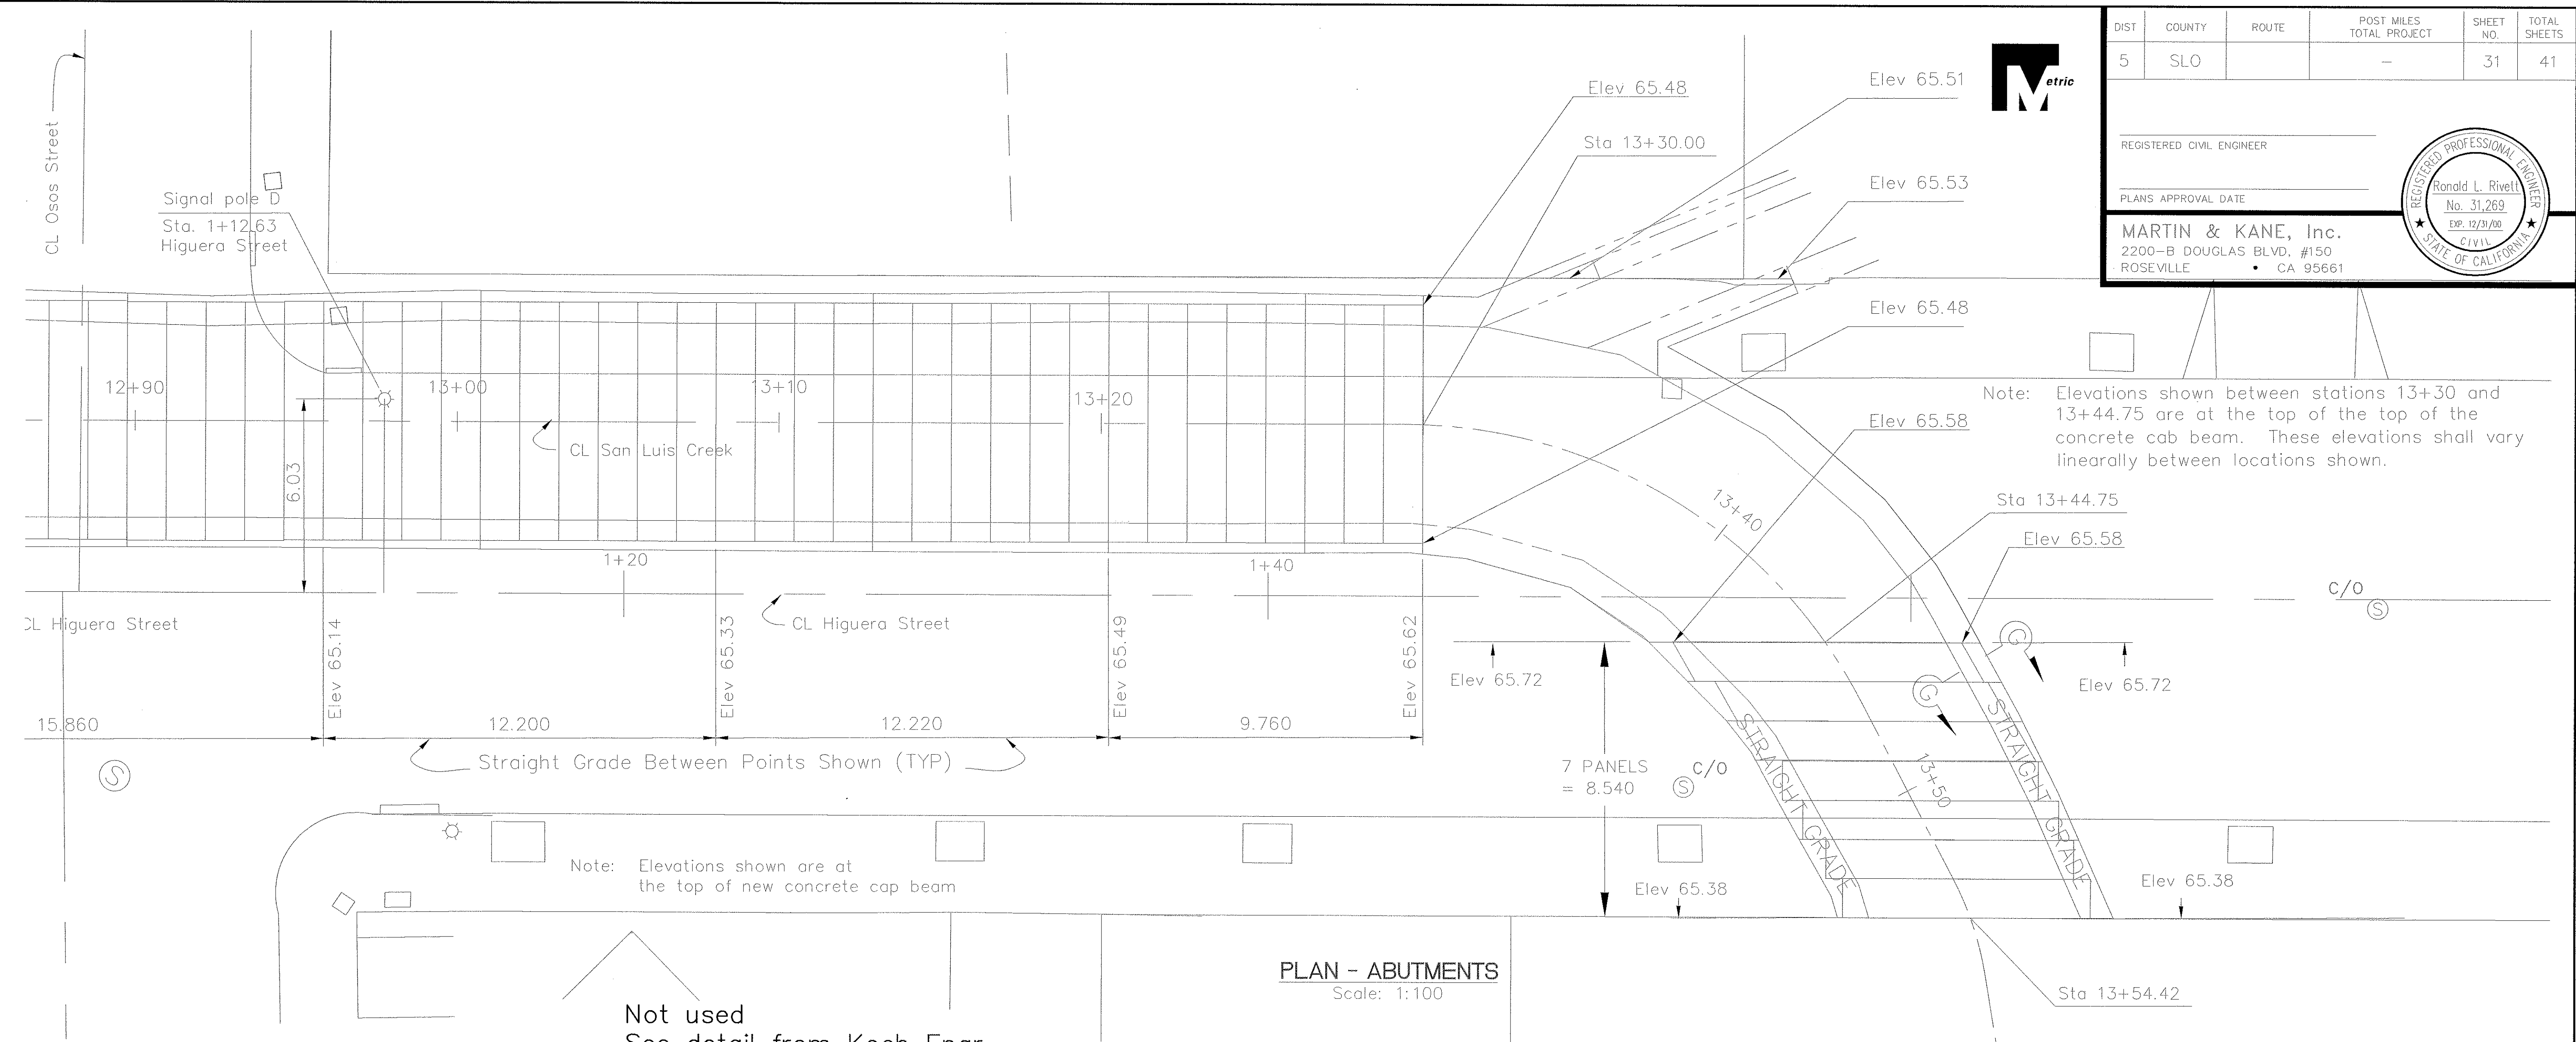


Not used
See detail from Koch Engr.

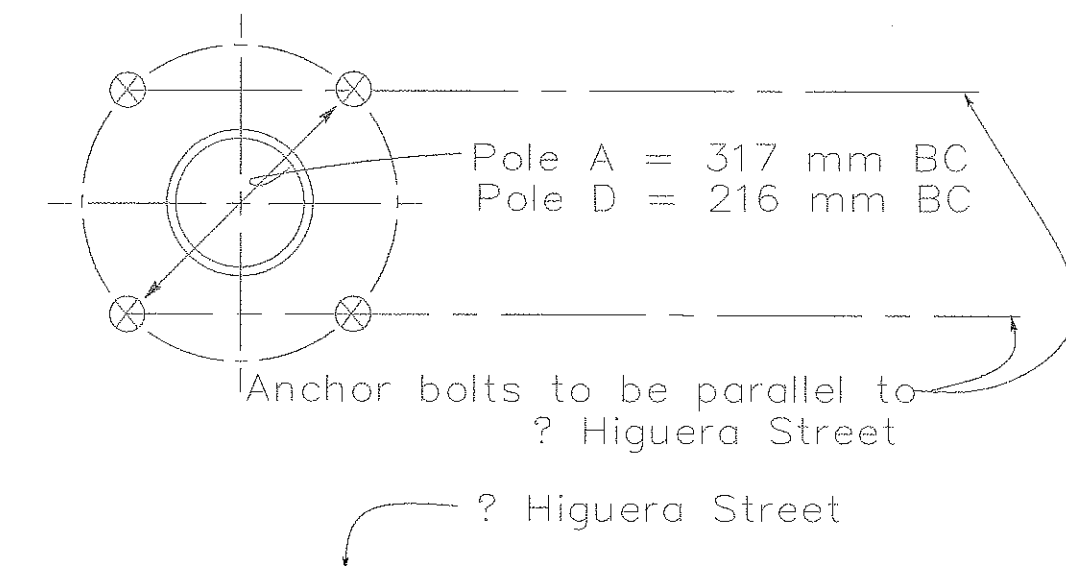

ANCHOR BOLT LAYOUT
No Scale


RECORD DRAWING
DATE: 3/1/02 BY: SR

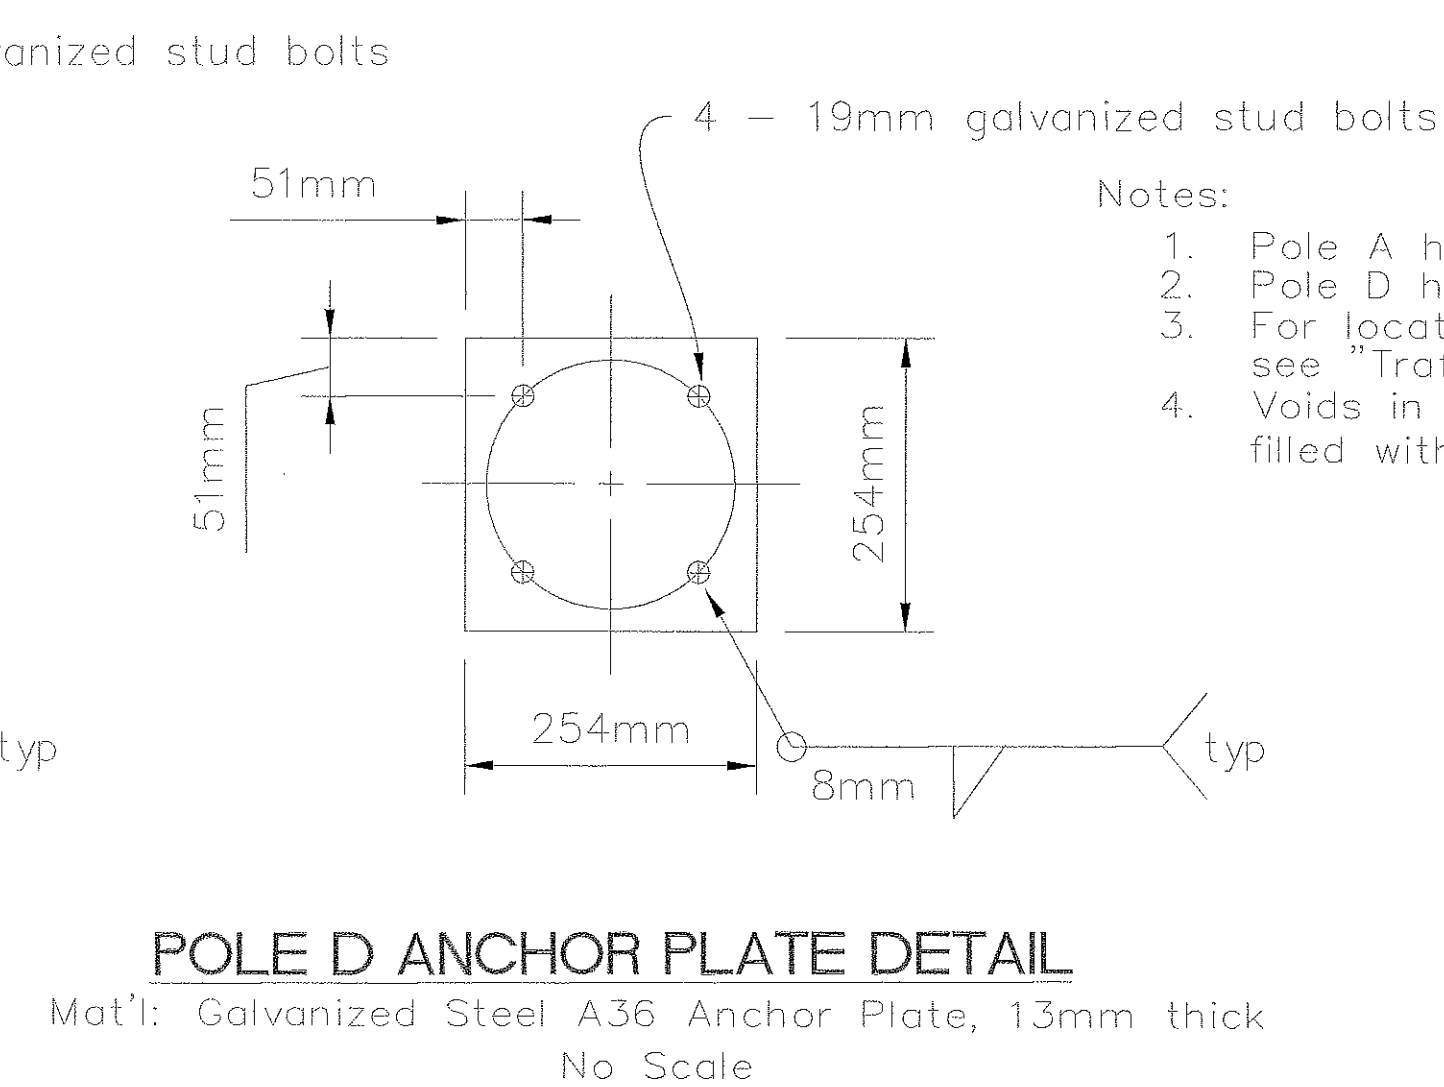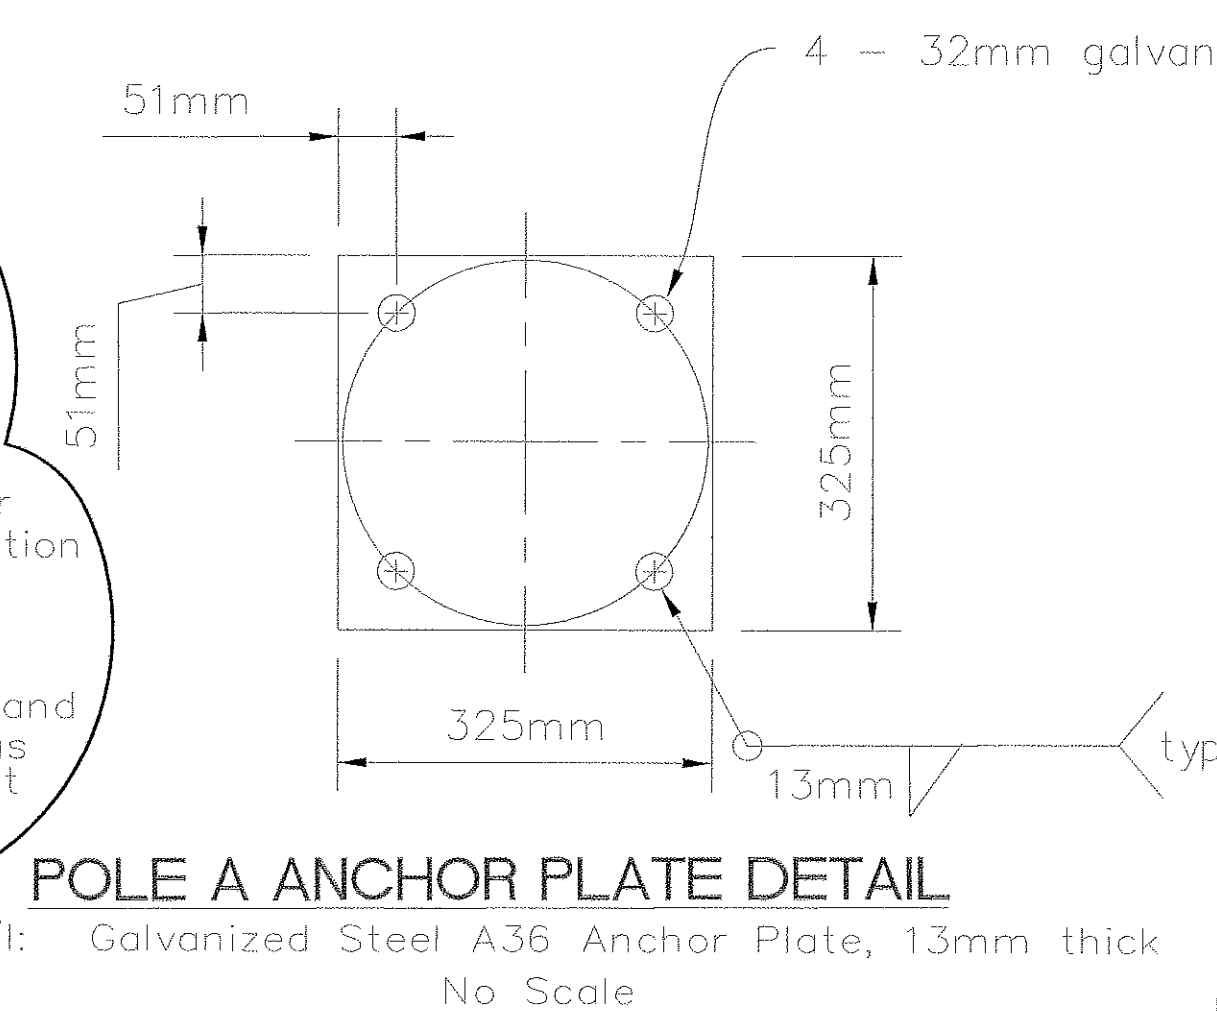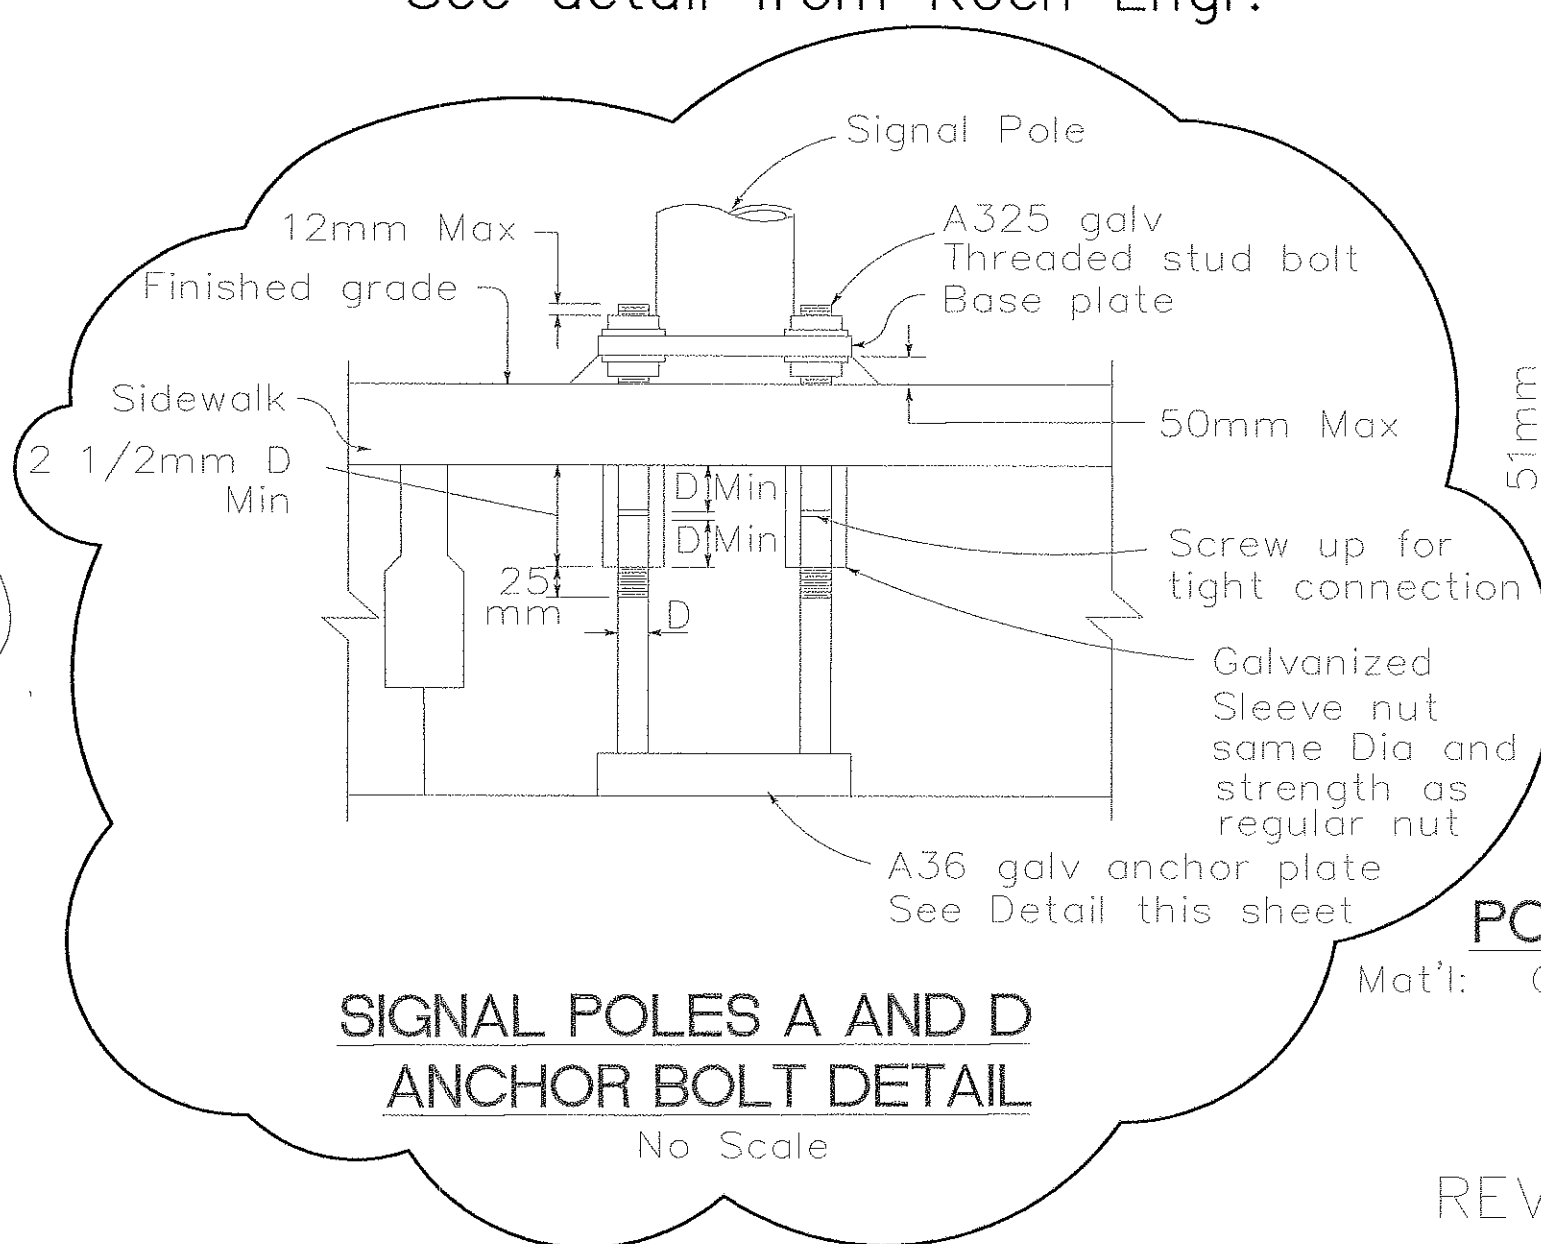

- Notes:
1. Pole A has 4 - 32mm A325 anchor bolts.
 2. Pole D has 4 - 19mm A325 anchor bolts.
 3. For location and details of signal poles A and D see "Traffic Signal and Lighting Plan" sheet.
 4. Voids in "Precast Prestressed Slab" unit to be filled within 0.6m of "Anchor Plate".

The contractor shall verify all
controlling field dimensions before
ordering or fabricating any
materials.

All dimensions are in meters unless otherwise noted

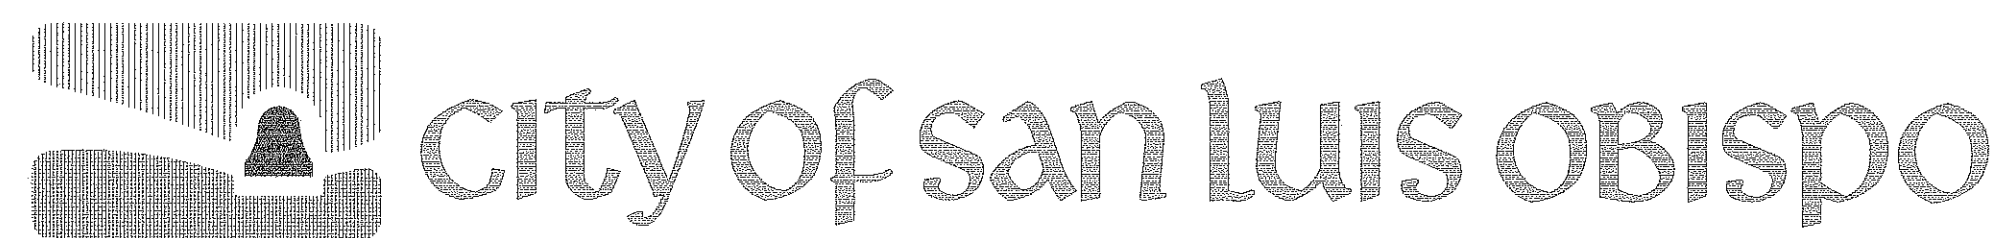

HIGUERA STREET BRIDGE REPLACEMENT

APPROVED BY
CITY ENGINEER

DATE 3/2000
SCALE As Noted
DESIGNED BY R.F.
DRAWN BY R.D., K.W.
CHECKED BY R.R.
APPROVED BY
UTILITIES DEPARTMENT

ABUTMENT DETAILS NO. 2

SPECIFICATION NO.
9367
FILE NO./LOCATION
0060 B
SHEET
31R OF 41

DIST	COUNTY	ROUTE	POST MILES TOTAL PROJECT	SHEET NO.	TOTAL SHEETS
5	SLO		-	32	41



Ronald L. Rivett
REGISTERED CIVIL ENGINEER

4/5/00
PLANS APPROVAL DATE


MARTIN & KANE, Inc.
2200-B DOUGLAS BLVD, #150
ROSEVILLE, CA 95661

REGISTERED PROFESSIONAL ENGINEER

Ronald L. Rivett
No. 31,269
EXP. 12/31/00
CIVIL
STATE OF CALIFORNIA

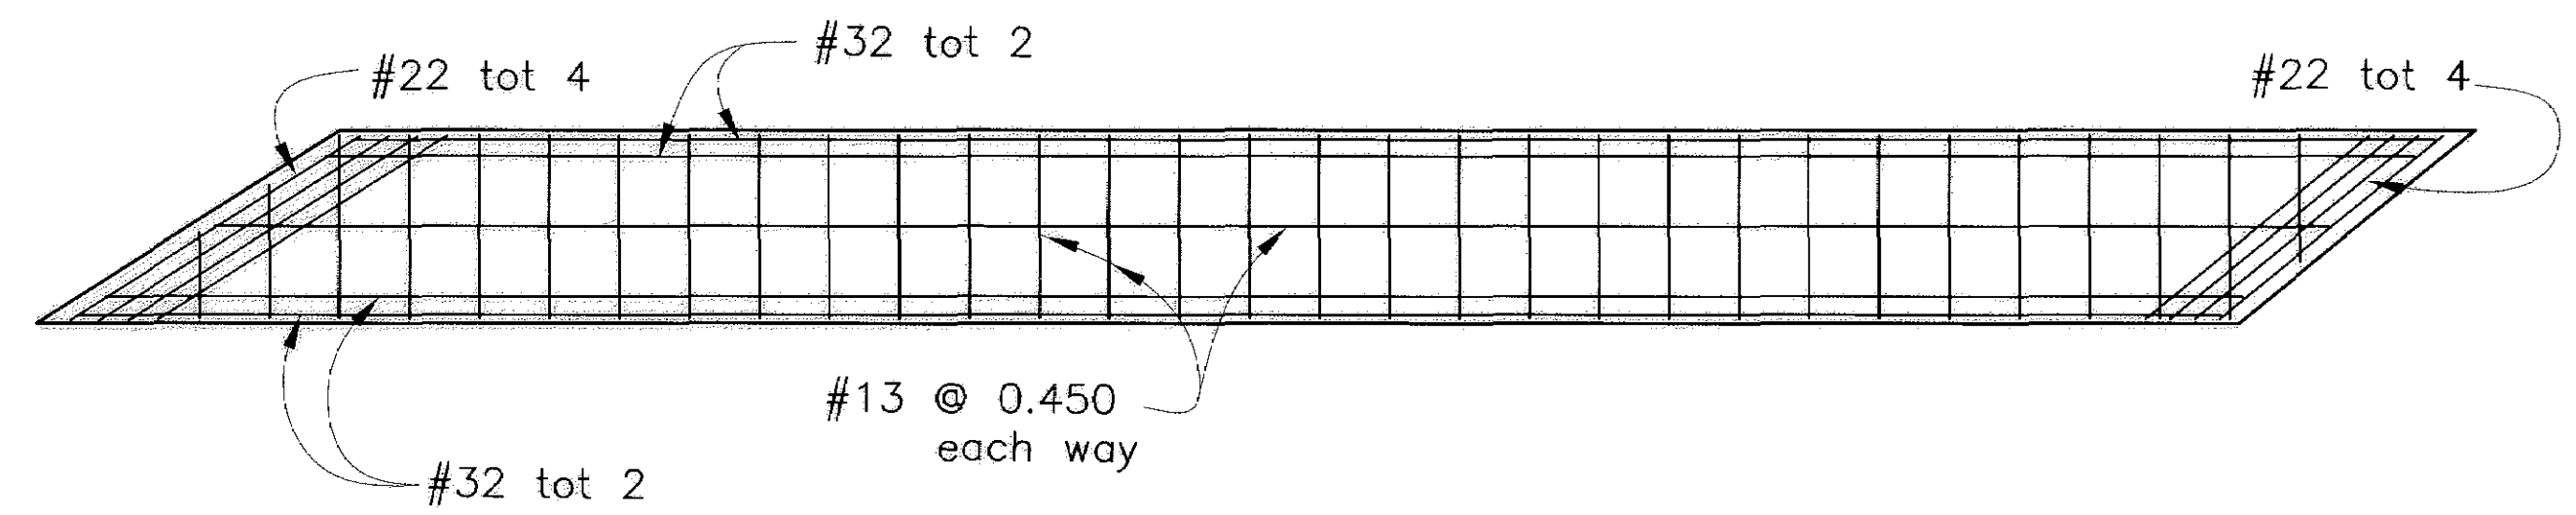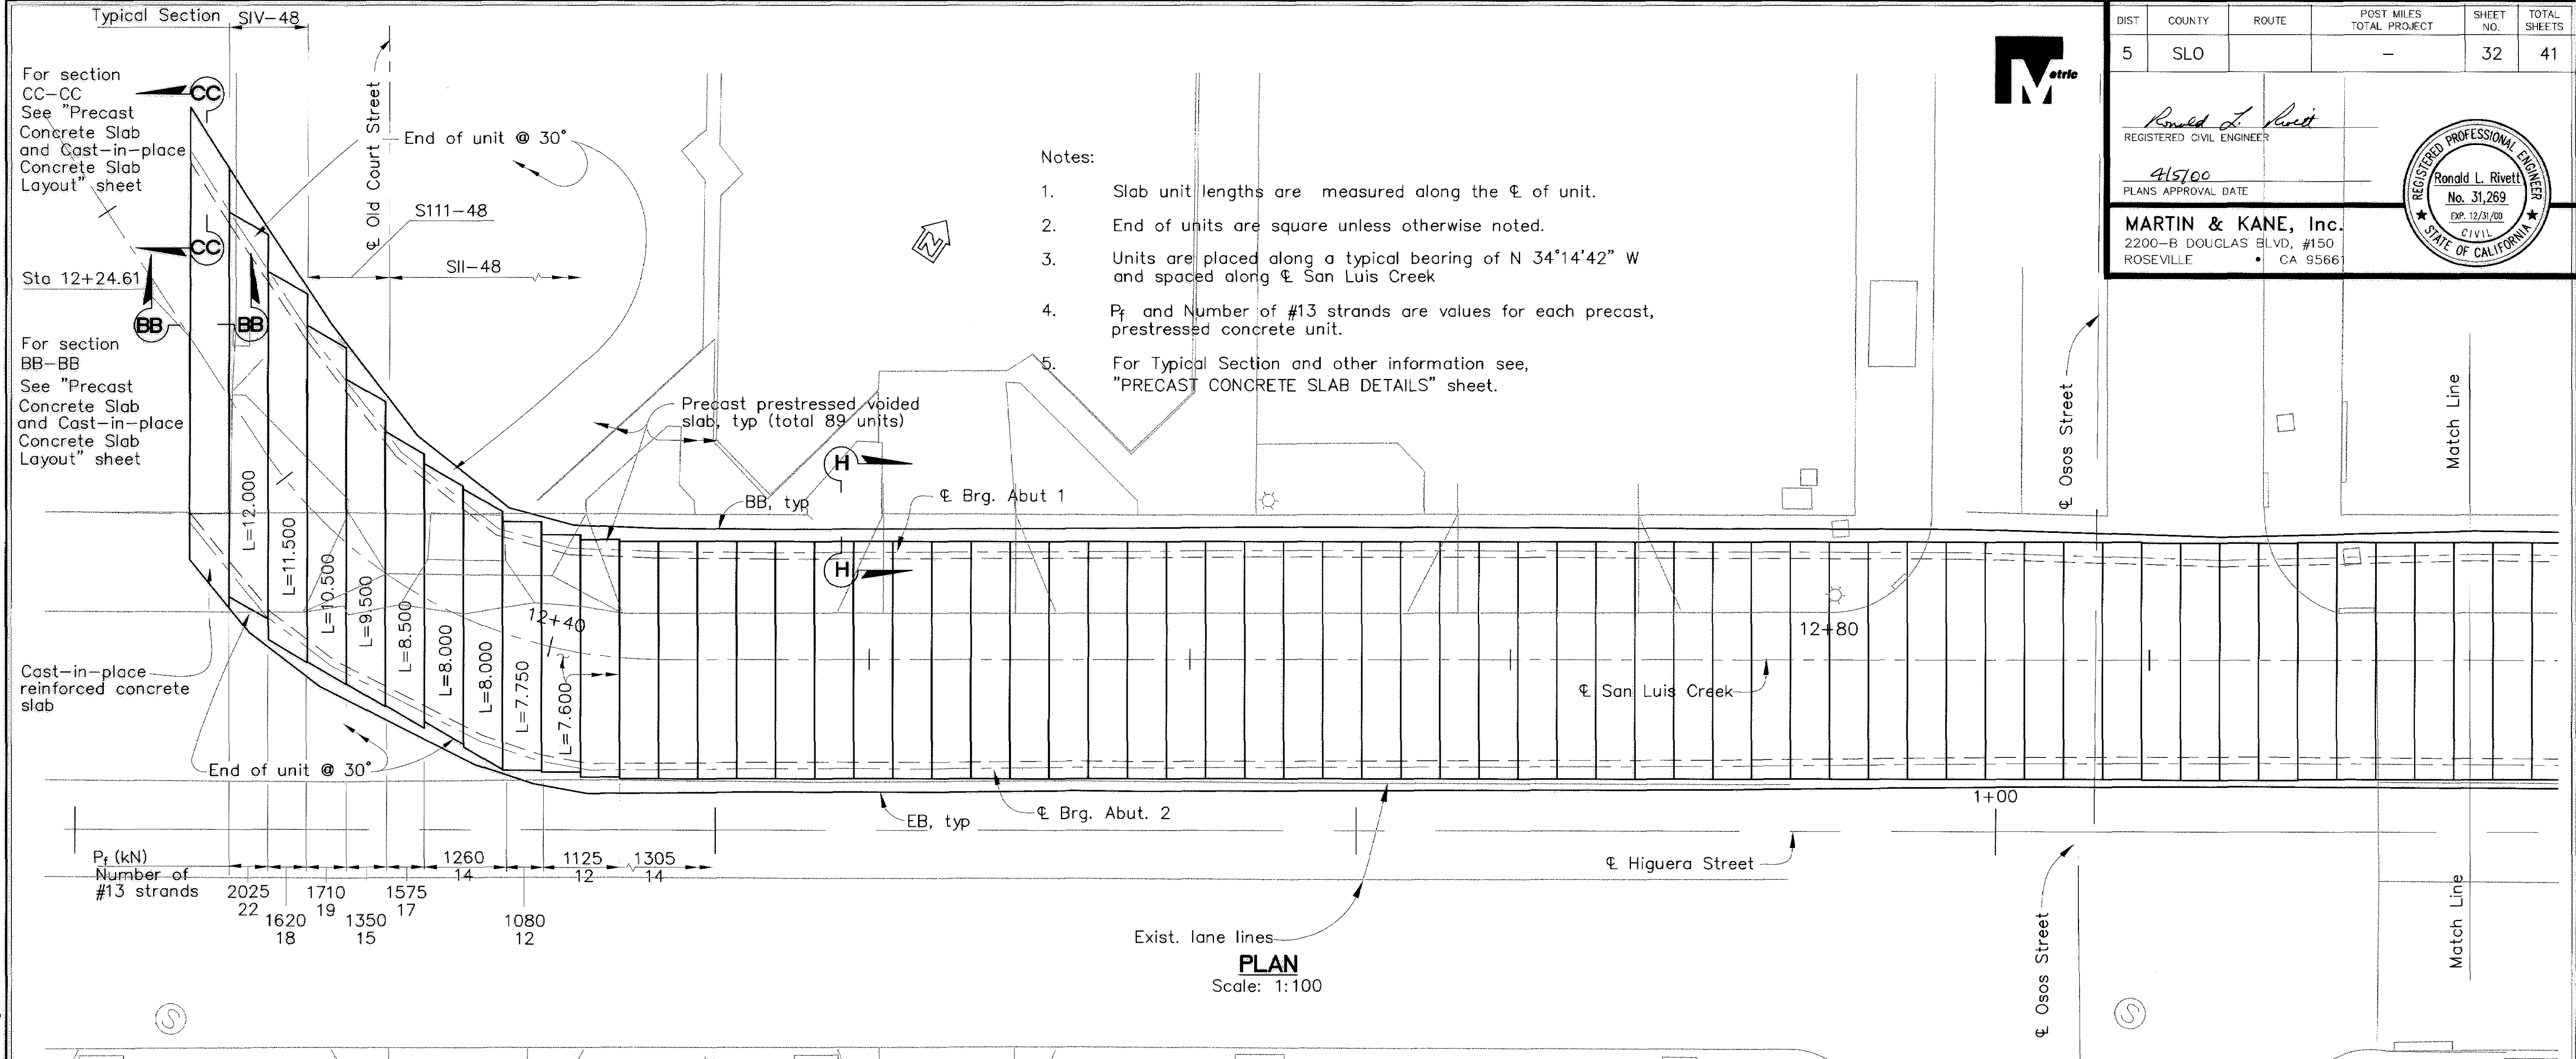

TOP SLAB REINFORCEMENT
Rotated 90° CCW

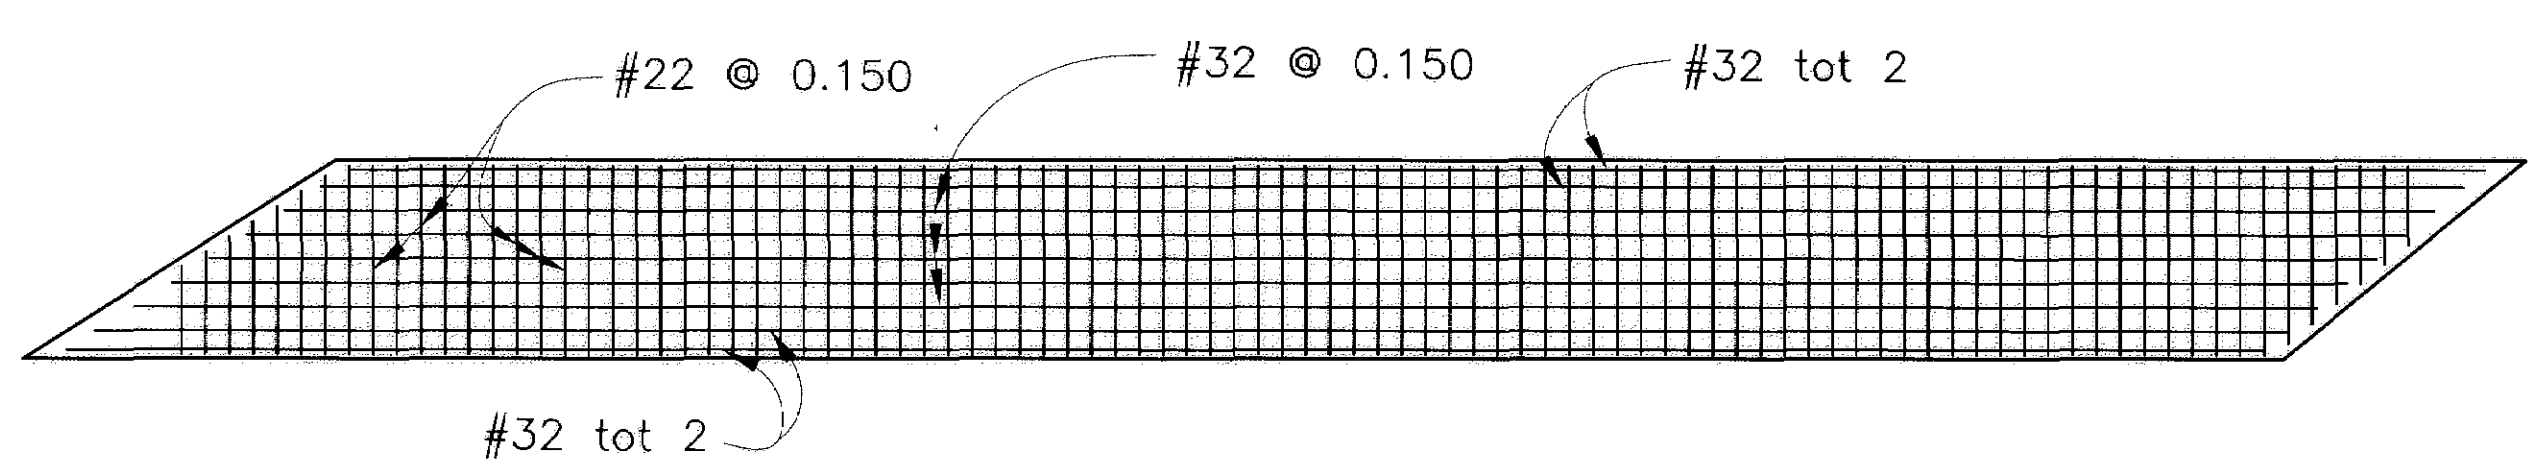

BOTTOM SLAB REINFORCEMENT
Rotated 90° CCW

REINFORCED CONCRETE SLAB AT MOE'S RESTAURANT
Scale: 1:50

 
The contractor shall verify all controlling field dimensions before ordering or fabricating any materials.

All dimensions are in meters unless otherwise noted



HIGUERA STREET BRIDGE REPLACEMENT

FOR REDUCED PLANS
ORIGINAL SCALE IS IN MILLIMETERS



APPROVED BY

CITY ENGINEER

DATE: 3/2000
SCALE: As Noted
DESIGNED BY: R.F.
DRAWN BY: R.D., K.W.
CHECKED BY: R.R.
APPROVED BY:
UTILITIES DEPARTMENT

PRECAST CONCRETE SLAB LAYOUT

SPECIFICATION NO.
9367
FILE NO./LOCATION
0060 B
SHEET
32 OF 41

N:\MSR\PROJECTS\1997\97017.00 HIGUERA STREET BRIDGE REHAB\100% Submittal\97017-7-SLAB.dwg 3-17-00

N:\MSR\PROJECTS\1997\97017.00 HIGUERA STREET BRIDGE REHAB\100% Submittal\97017-7-SLAB.dwg 3-17-00



DIST	COUNTY	ROUTE	POST MILES TOTAL PROJECT	SHEET NO.	TOTAL SHEETS
5	SLO		-	33	41

Ronald L. Rivett
REGISTERED CIVIL ENGINEER


4/5/00
PLANS APPROVAL DATE

MARTIN & KANE, Inc.
2200-B DOUGLAS BLVD., #150
ROSEVILLE CA 95661




Notes:

- Slab unit lengths are measured along the ϕ of unit.
- End of units are square unless otherwise noted.
- Units are placed along a typical bearing of N 34°14'42" W and spaced along ϕ San Luis Creek
- Units are placed parallel to ϕ Higuera Street.
- P_f and Number of #13 strands are values for each precast, prestressed concrete unit.
- For Typical Section and other information see, "PRECAST CONCRETE SLAB DETAILS" sheet.

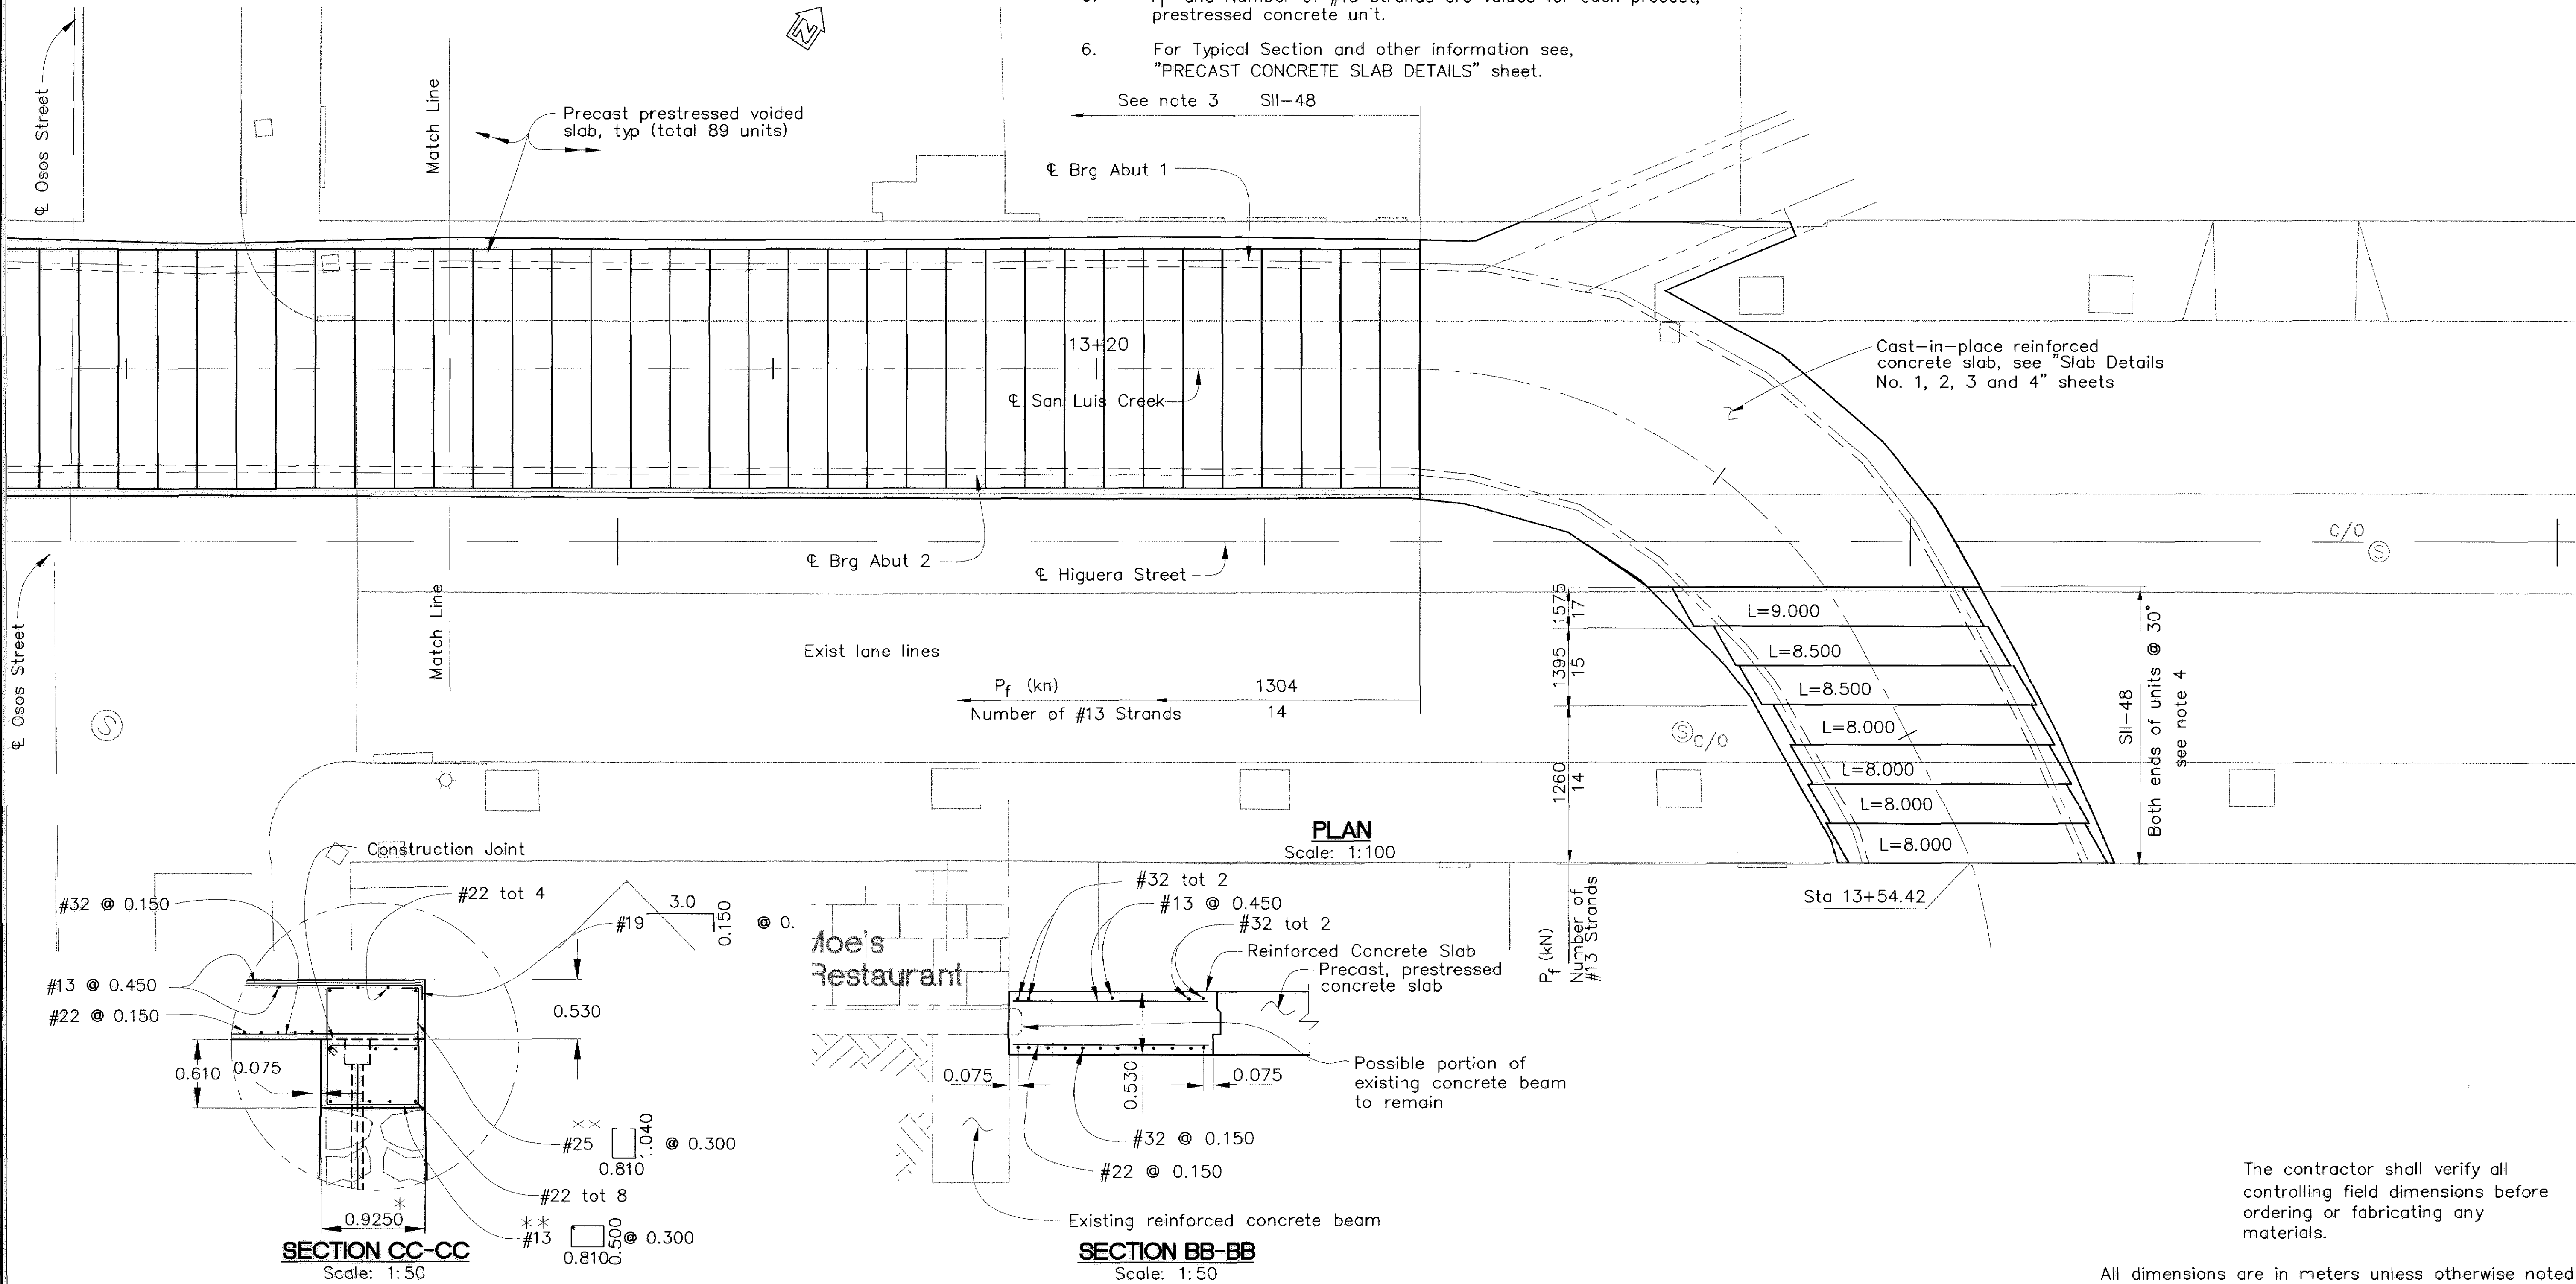

The contractor shall verify all controlling field dimensions before ordering or fabricating any materials.

All dimensions are in meters unless otherwise noted

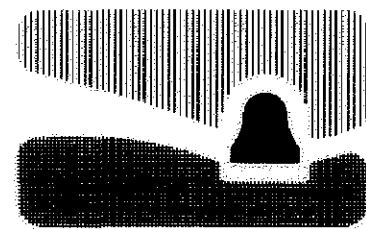

city of san luis obispo

HIGUERA STREET BRIDGE REPLACEMENT

FOR REDUCED PLANS
ORIGINAL SCALE IS IN MILLIMETERS

0 20 40 60 80 100

APPROVED BY

CITY ENGINEER

DATE 3/2000
SCALE As Noted
DESIGNED BY R.F.
DRAWN BY R.D., K.W.
CHECKED BY R.R.
APPROVED BY
UTILITIES DEPARTMENT

PRECAST CONCRETE SLAB AND
CAST-IN-PLACE CONCRETE SLAB LAYOUT

SPECIFICATION NO.
9367
FILE NO./LOCATION
0060 B
SHEET
33 OF 41

N:\MSR\PROJECTS\1997\97017.00 HIGUERA STREET BRIDGE REPLACEMENT\100% Submittal\97017-7-SUB.dwg 3-17-00



DIST	COUNTY	ROUTE	POST MILES TOTAL PROJECT	SHEET NO.	TOTAL SHEETS
5	SLO		—	33	41

REGISTERED CIVIL ENGINEER


PLANS APPROVAL DATE

MARTIN & KANE, Inc.
2200-B DOUGLAS BLVD. #150
ROSELLE CA 95661

REGISTERED PROFESSIONAL ENGINEER
No. 31,269
Exp. 2/3/00
CIVIL
STATE OF CALIFORNIA

Notes:

- Slab unit lengths are measured along the ? of unit.
- End of units are square unless otherwise noted.
- Units are placed along a typical bearing of N 34°14'42" W and spaced along ? San Luis Creek
- Units are placed parallel to ? Higuera Street.
- P_f and Number of #13 strands are values for each precast, prestressed concrete unit.
- For Typical Section and other information see, "PRECAST CONCRETE SLAB DETAILS" sheet.

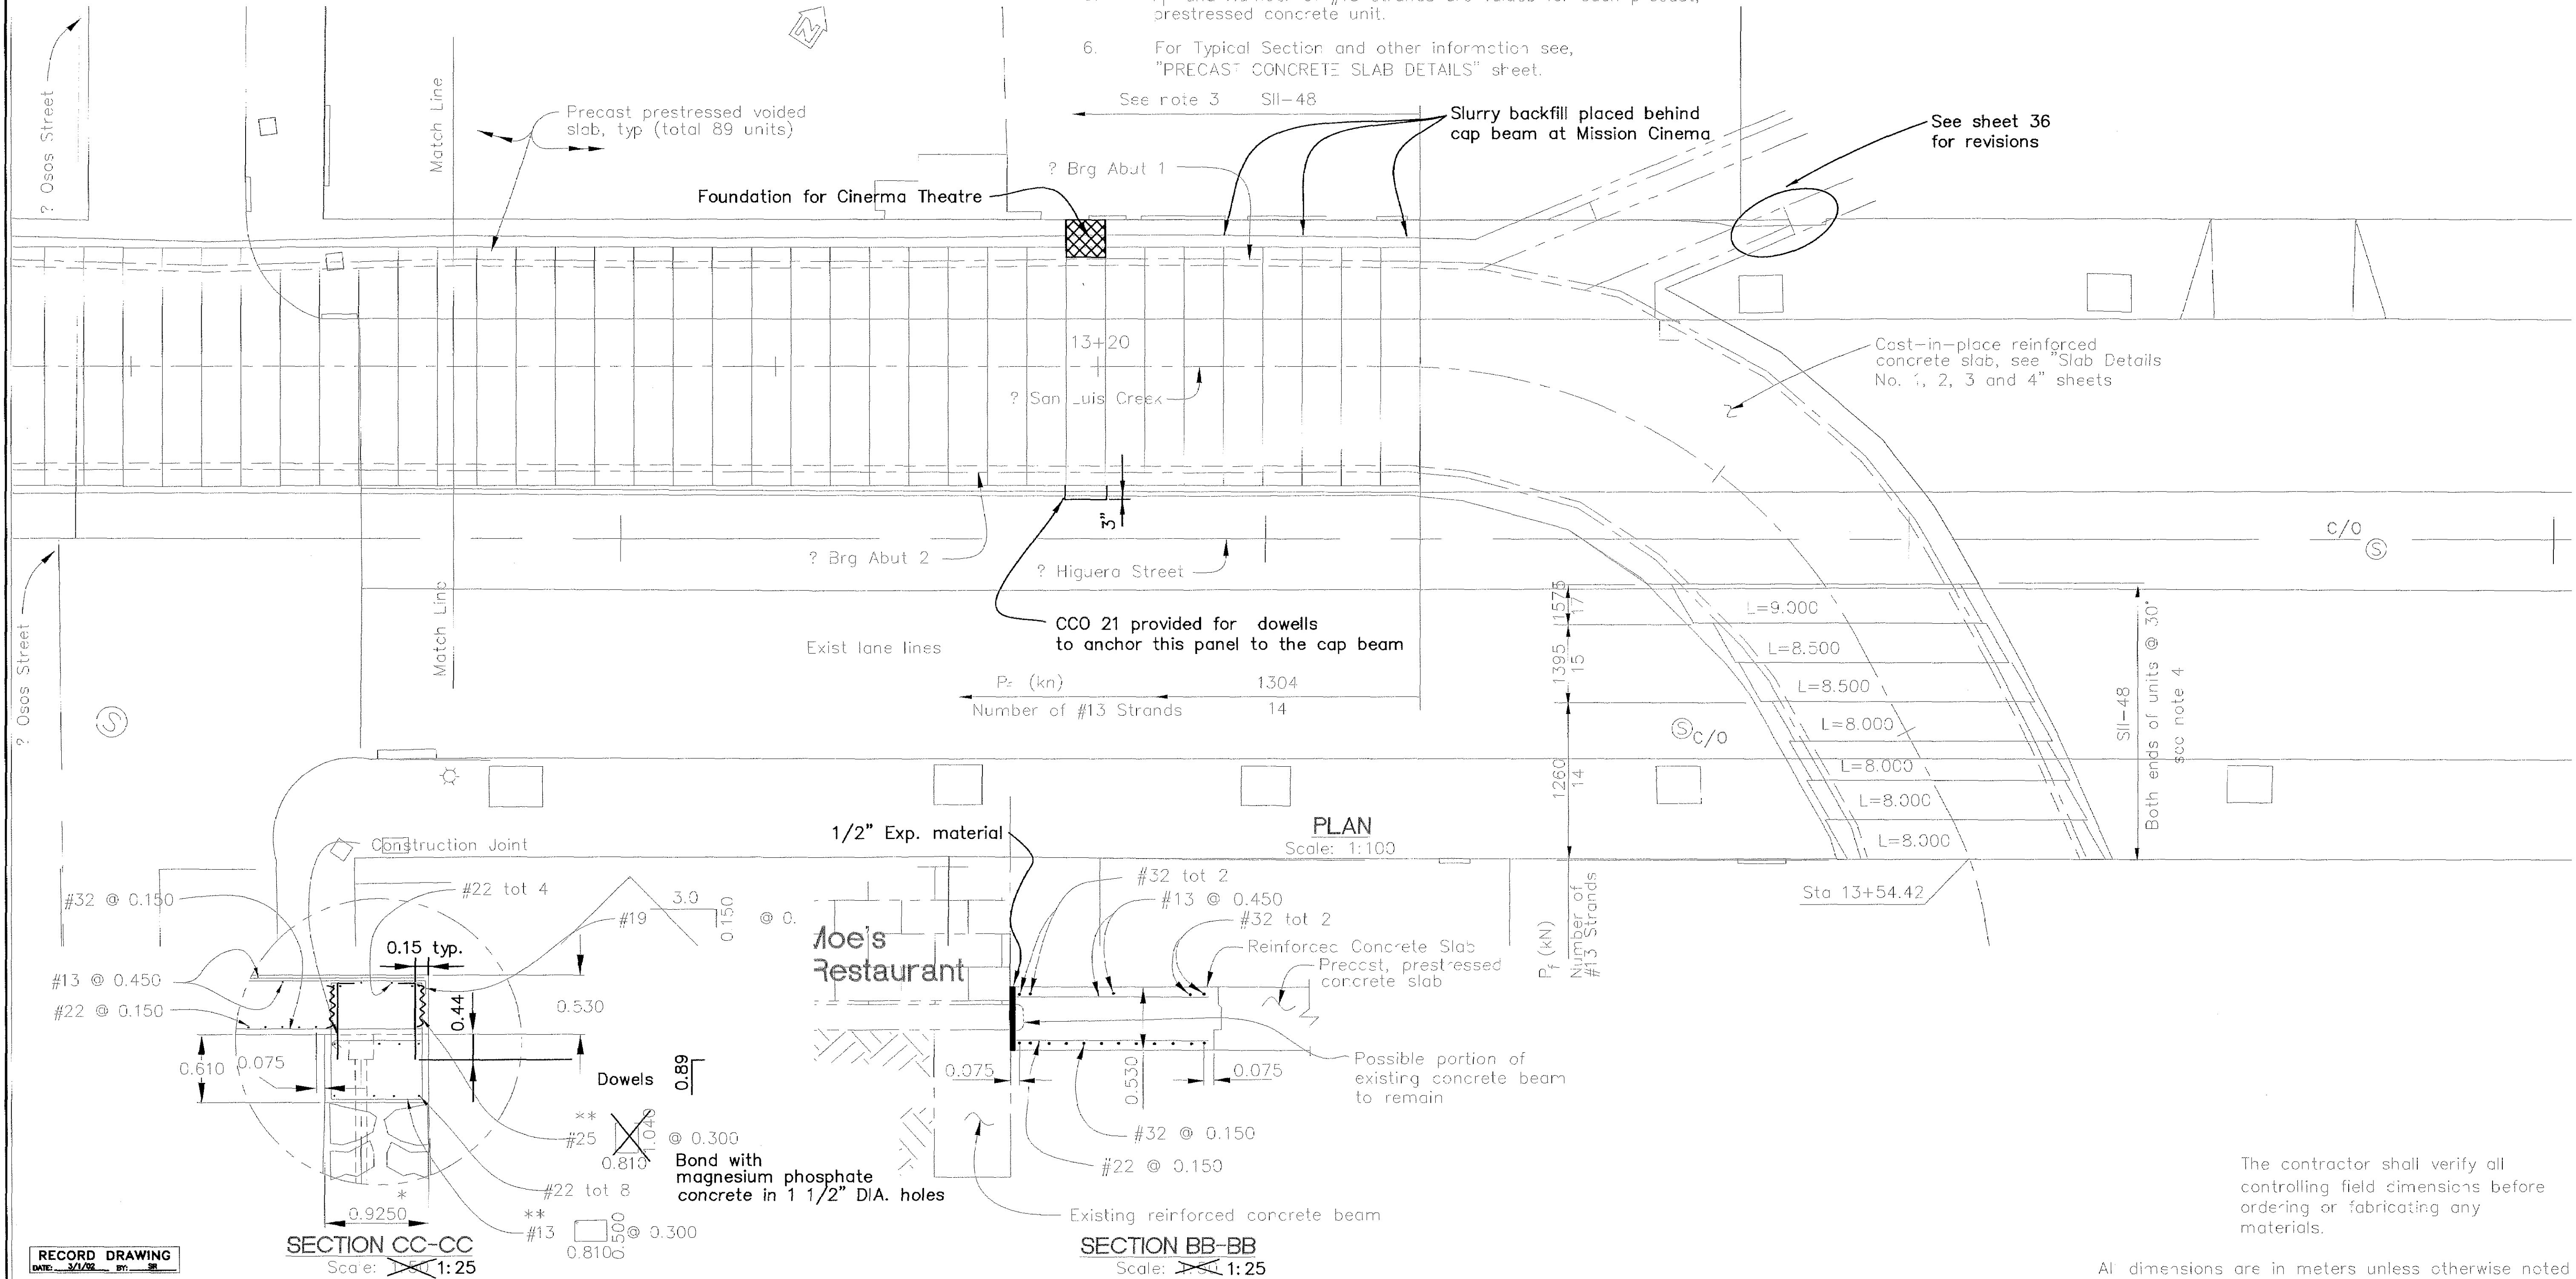

The contractor shall verify all controlling field dimensions before ordering or fabricating any materials.

All dimensions are in meters unless otherwise noted

N:\MKSRV1\MK PROJECTS\1997\97017.00 HIGUERA STREET BRIDGE REHAB\100% Submittal\97017-SD2.dwg 3-17-00




DIST	COUNTY	ROUTE	POST MILES TOTAL PROJECT	SHEET NO.	TOTAL SHEETS
5	SLO		—	34	41
REGISTERED CIVIL ENGINEER					
PLANS APPROVAL DATE					
MARTIN & KANE, Inc. 2200-B DOUGLAS BLVD. #150 ROSEVILLE CA 95661					

REGISTERED PROFESSIONAL ENGINEER

Ronald L. Rivett
No. 31,269
EXP. 12/31/00
CIVIL
STATE OF CALIFORNIA

- Note:
1. $\times$ denotes bundled bars
 2. For additional info see "Slab Details No. 3 and 4 sheets
 3. All #29 bundles not shown

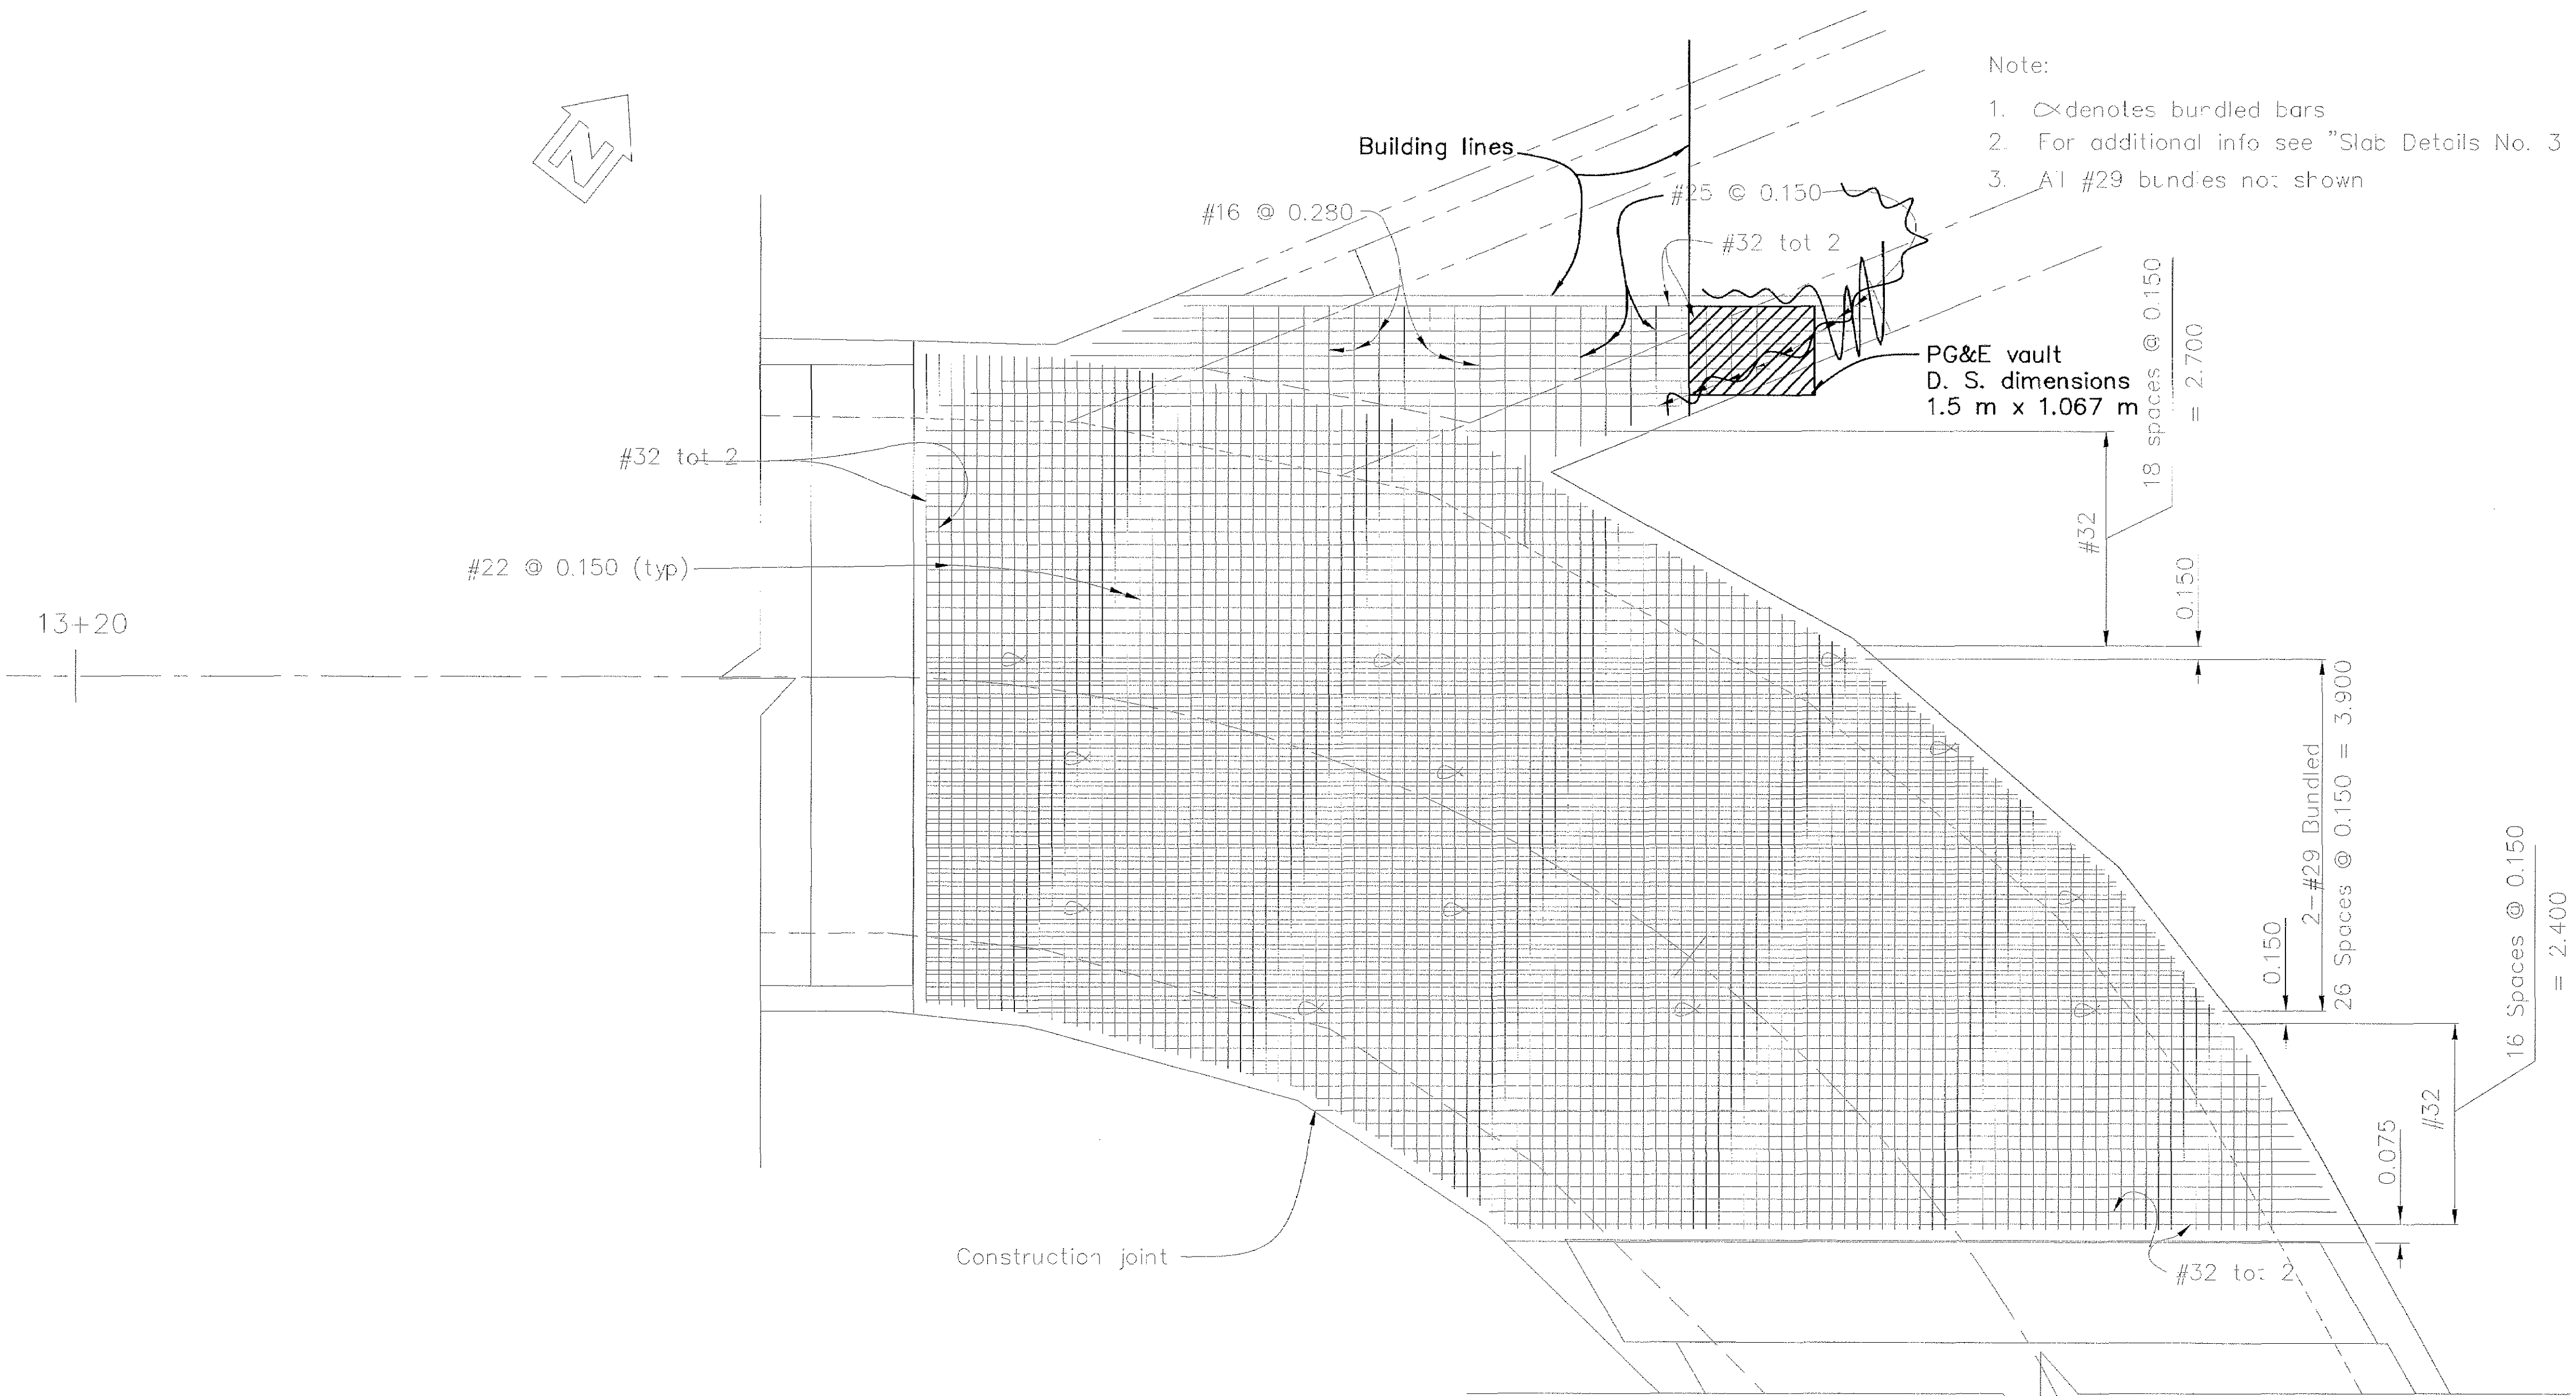

BOTTOM SLAB REINFORCEMENT


Scale: 1:50

CHANGES PER CCO 33

The contractor shall verify all
controlling field dimensions before
ordering or fabricating any
materials.

All dimensions are in meters unless otherwise noted

RECORD DRAWING
DATE: 3/1/00 BY: JR

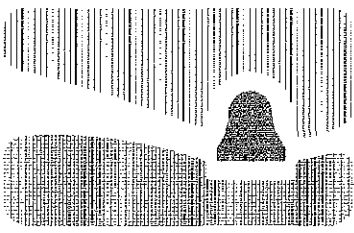

city of san luis obispo

HIGUERA STREET BRIDGE REPLACEMENT

FOR REDUCED PLANS
ORIGINAL SCALE IS IN MILLIMETERS



APPROVED BY

CITY ENGINEER

DATE 3/2000

SCALE 1:50

DESIGNED BY R.F.

DRAWN BY R.D., K.W.

CHECKED BY R.R.

APPROVED BY

UTILITIES DEPARTMENT

SLAB DETAILS NO. 1

SPECIFICATION NO.

9367

FILE NO./LOCATION

0060 B

SHEET

34 OF 41

DIST	COUNTY	ROUTE	POST MILES TOTAL PROJECT	SHEET NO.	TOTAL SHEETS
5	SLO		—	35	41




Ronald L. Rivett
REGISTERED CIVIL ENGINEER

4/5/00
PLANS APPROVAL DATE

MARTIN & KANE, Inc.
2200-B DOUGLAS BLVD, #150
ROSEVILLE • CA 95661



Note:
For additional info
see "Slab Details No.3 and 4"
sheets

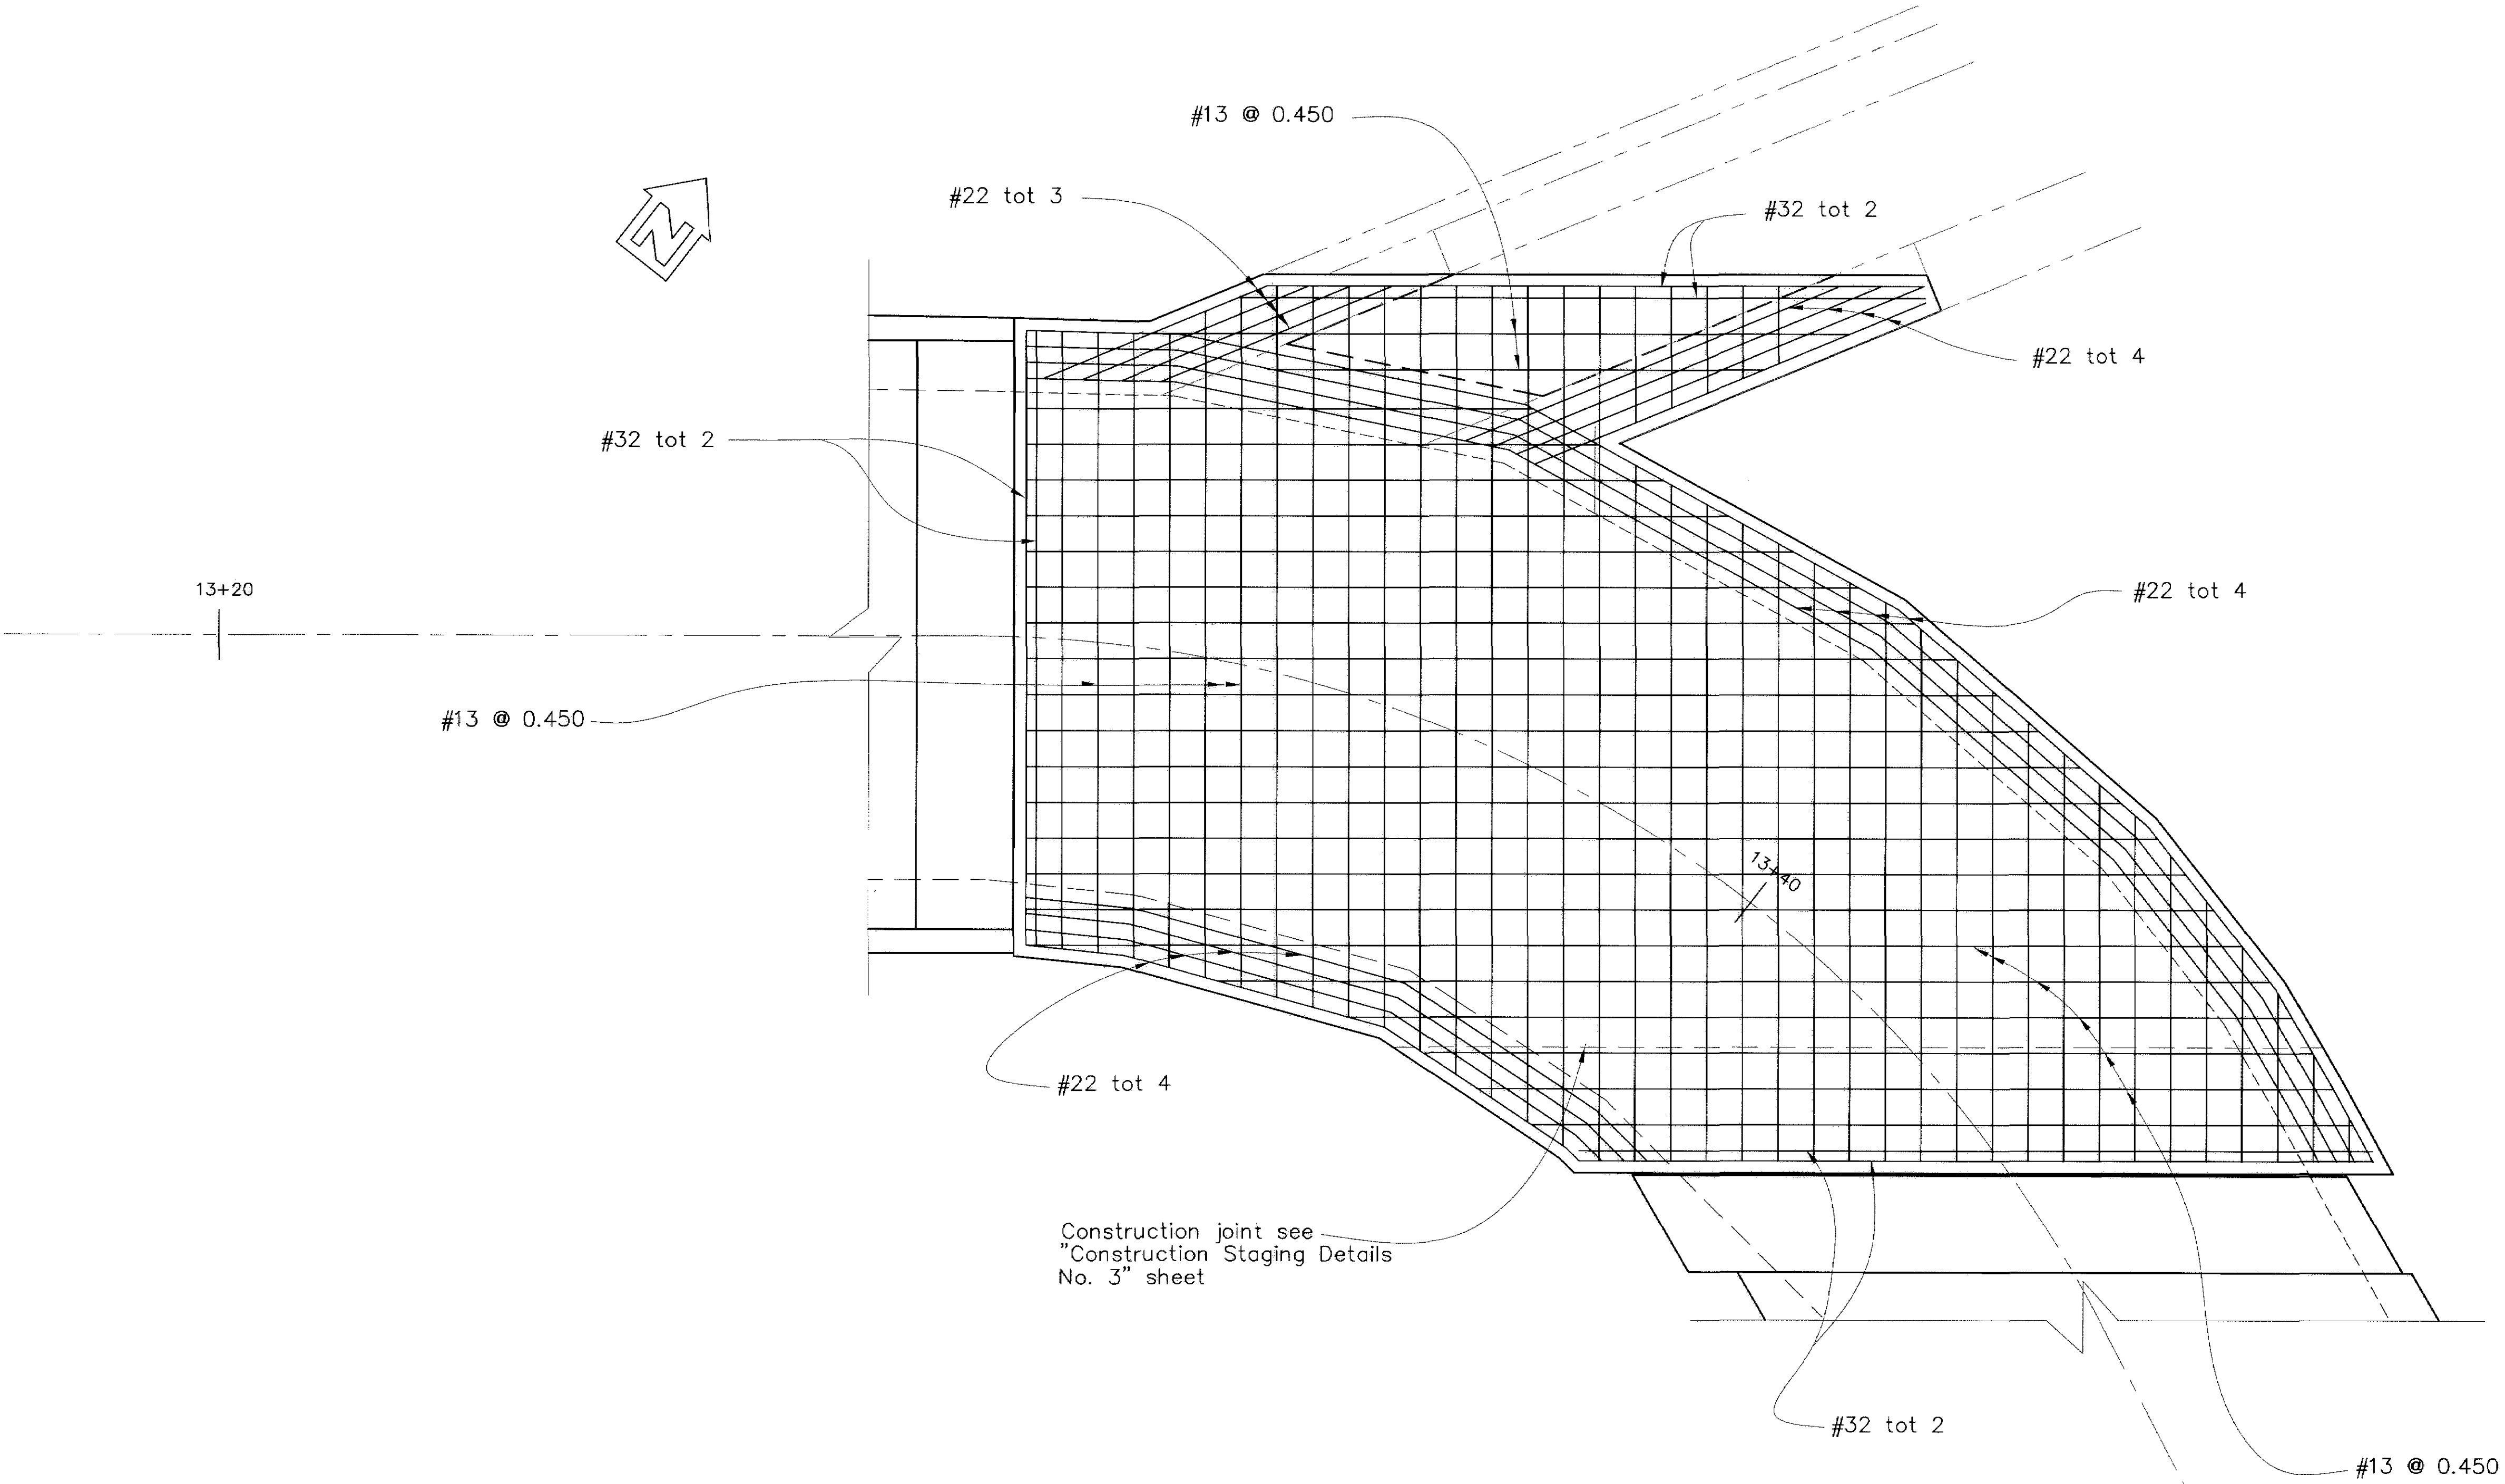


TOP SLAB REINFORCEMENT

Scale: 1:50

The contractor shall verify all
controlling field dimensions before
ordering or fabricating any
materials.


All dimensions are in meters unless otherwise noted

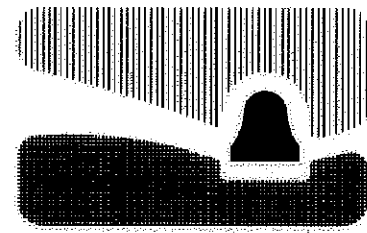

city of san luis obispo

HIGUERA STREET BRIDGE REPLACEMENT

 FOR REDUCED PLANS
ORIGINAL SCALE IS IN MILLIMETERS



APPROVED BY

CITY ENGINEER

DATE 3/2000

SCALE 1:50

DESIGNED BY R.F.

DRAWN BY R.D., K.W.

CHECKED BY R.R.

APPROVED BY

UTILITIES DEPARTMENT

SLAB DETAILS NO. 2

SPECIFICATION NO.

9367

FILE NO./LOCATION

0060 B

SHEET

35 OF 41



DIST	COUNTY	ROUTE	POST MILES TOTAL PROJECT	SHEET NO.	TOTAL SHEETS
5	SLO		—	35	4

REGISTERED CIVIL ENGINEER

PLANS APPROVAL DATE

MARTIN & KANE, Inc.
2200-B DOUGLAS BLVD, #150
ROSEVILLE • CA 95661

REGISTERED PROFESSIONAL ENGINEER


Ronald L. Rivett

No. 3,269

EXP. 12/31/00

CIVIL

STATE OF CALIFORNIA

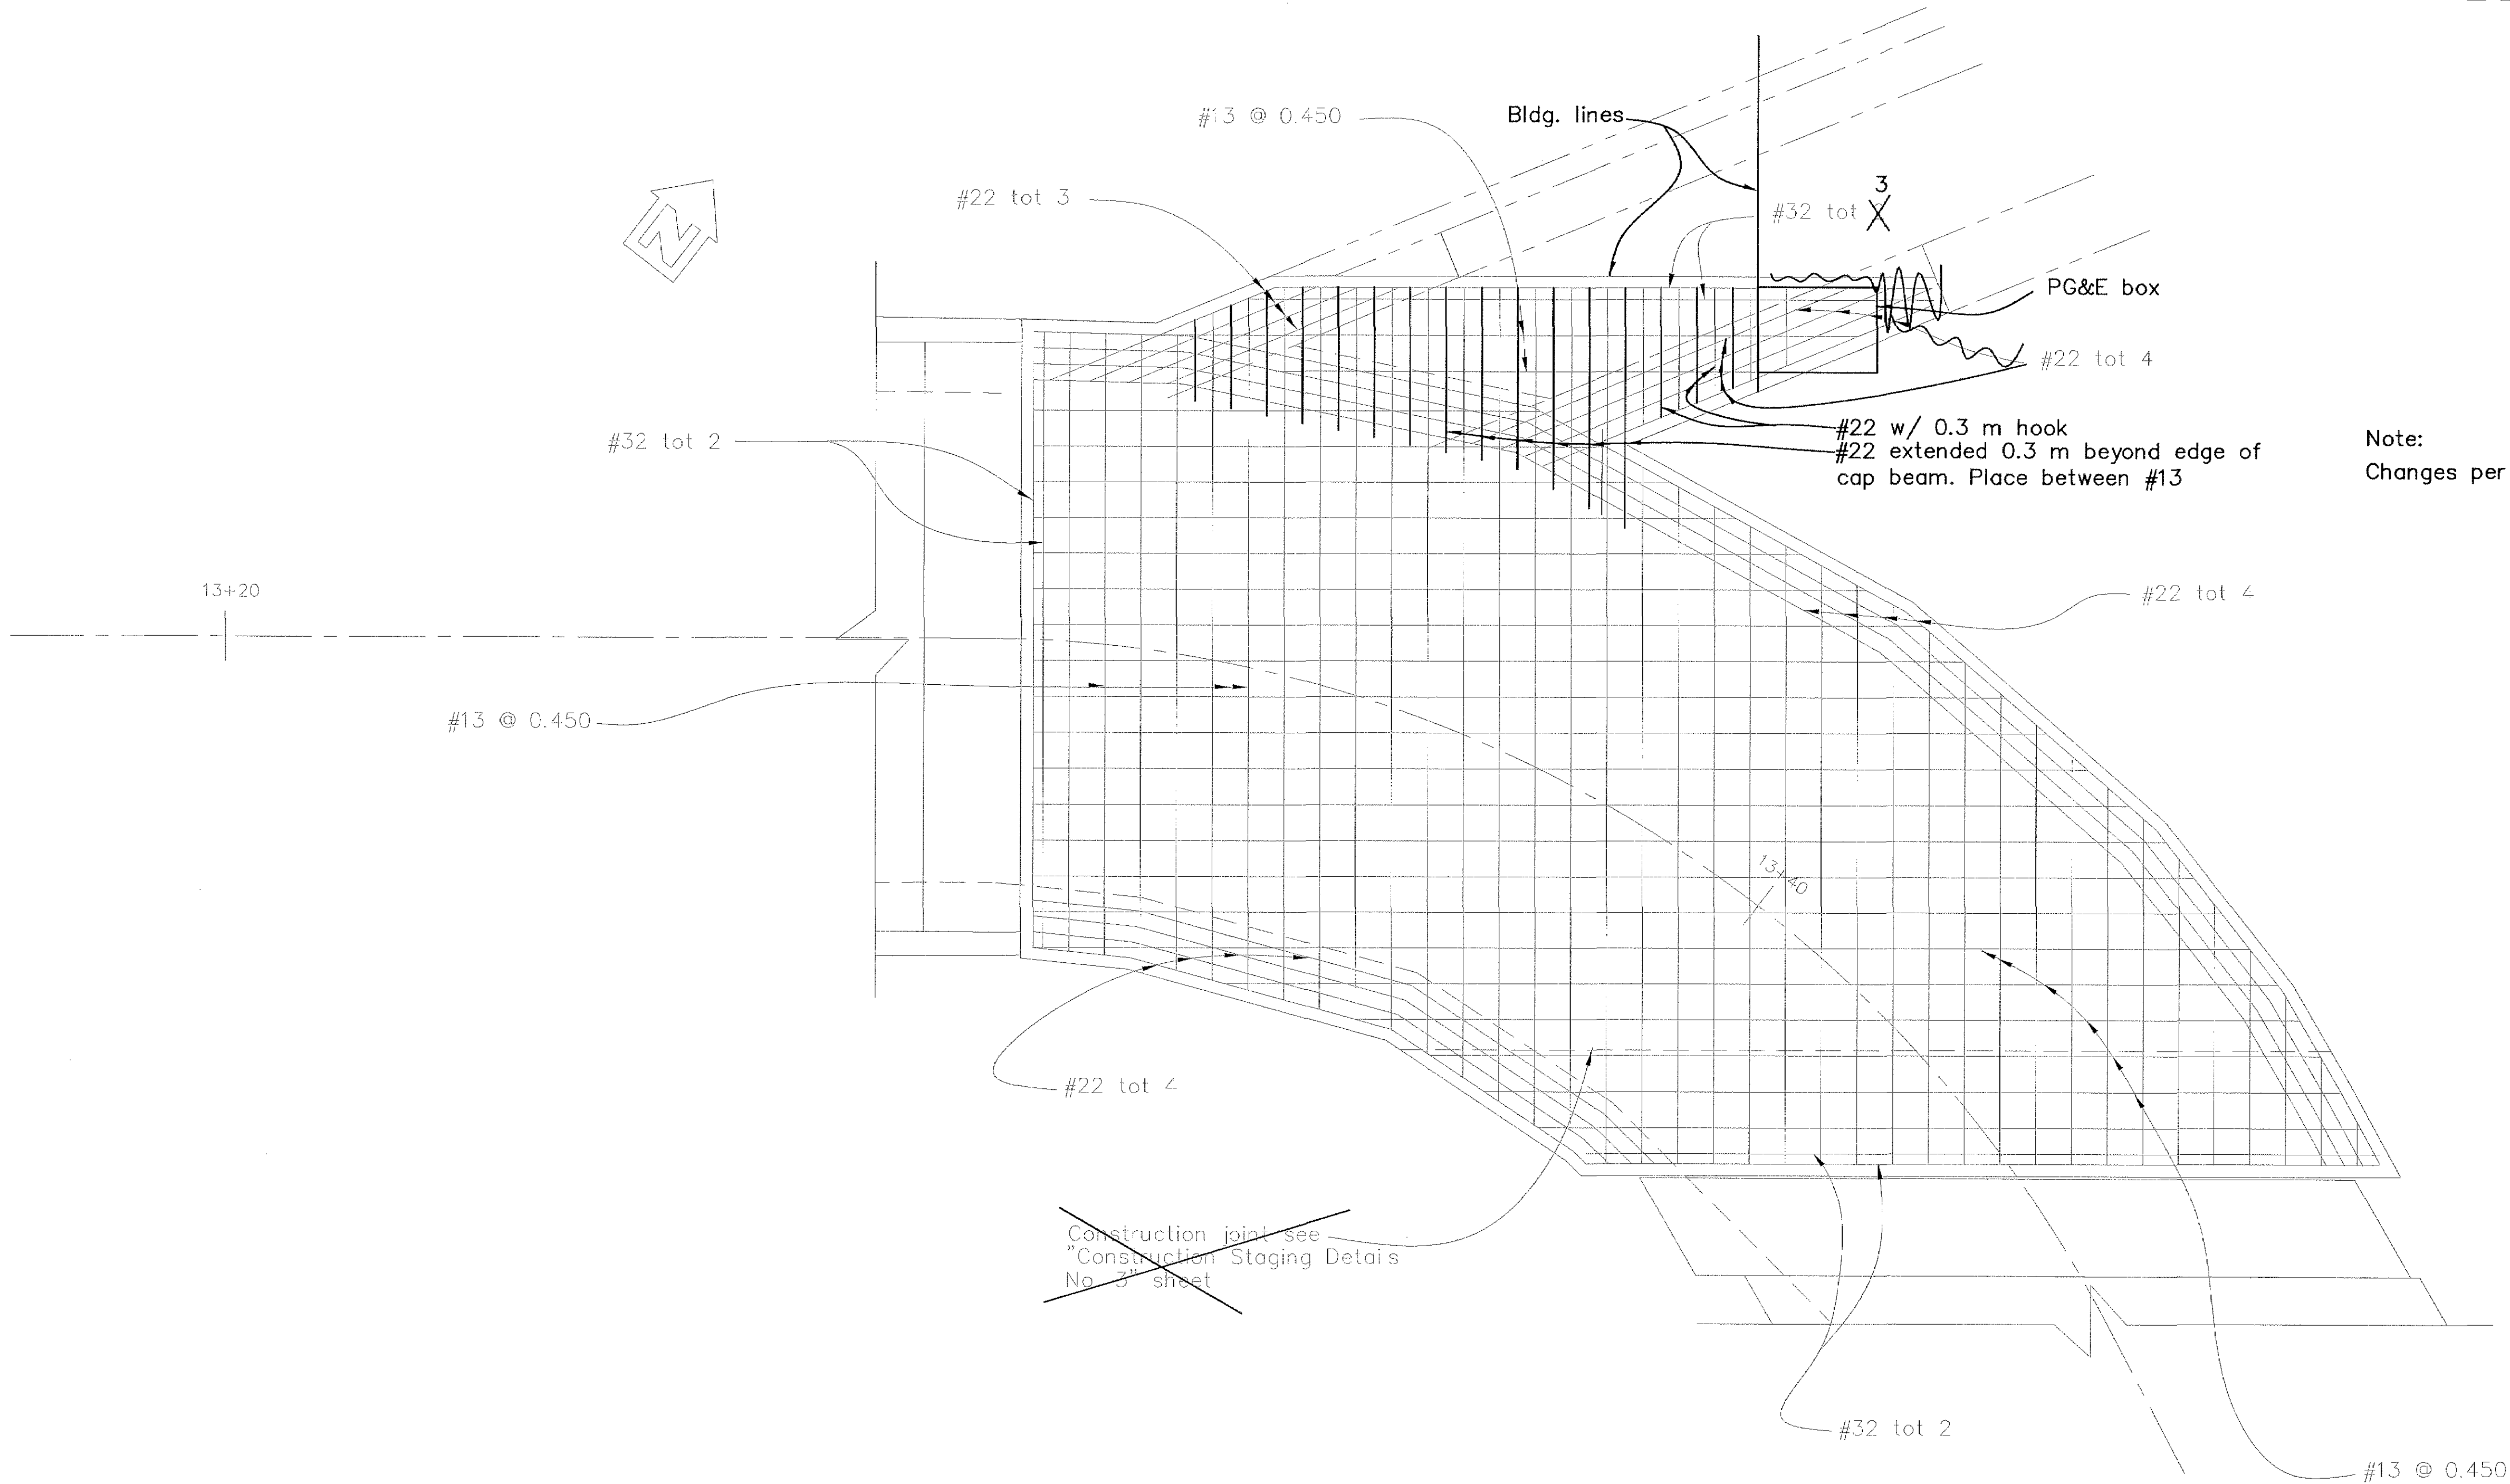

Note:
Changes per CCO 33

Note:
For additiona info
see "Slab Details No.3 and 4"
sheets


TOP SLAB REINFORCEMENT

Scale: 1:50

The contractor shall verify all
controlling field dimensions before
ordering or fabricating any
materials.

All dimensions are in meters unless otherwise noted

RECORD DRAWING
DATE: 3/24/02 BY: SR

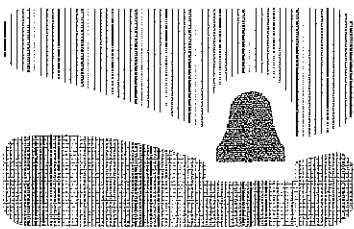

city of san luis obispo

HIGUERA STREET BRIDGE REPLACEMENT

FOR REDUCED PLANS
ORIGINAL SCALE IS IN MILLIMETERS



APPROVED BY

CITY ENGINEER

DATE 3/2000
SCALE 1:50
DESIGNED BY R.F.
DRAWN BY R.D., K.W.
CHECKED BY R.R.
APPROVED BY
UTILITIES DEPARTMENT

SLAB DETAILS NO. 2

SPECIFICATION NO.

9367


FILE NO./LOCATION

0060 B

SHEET

35R of 41

Note: For sections 0-0 and P-P
see "Slab Details No. 4" sheet

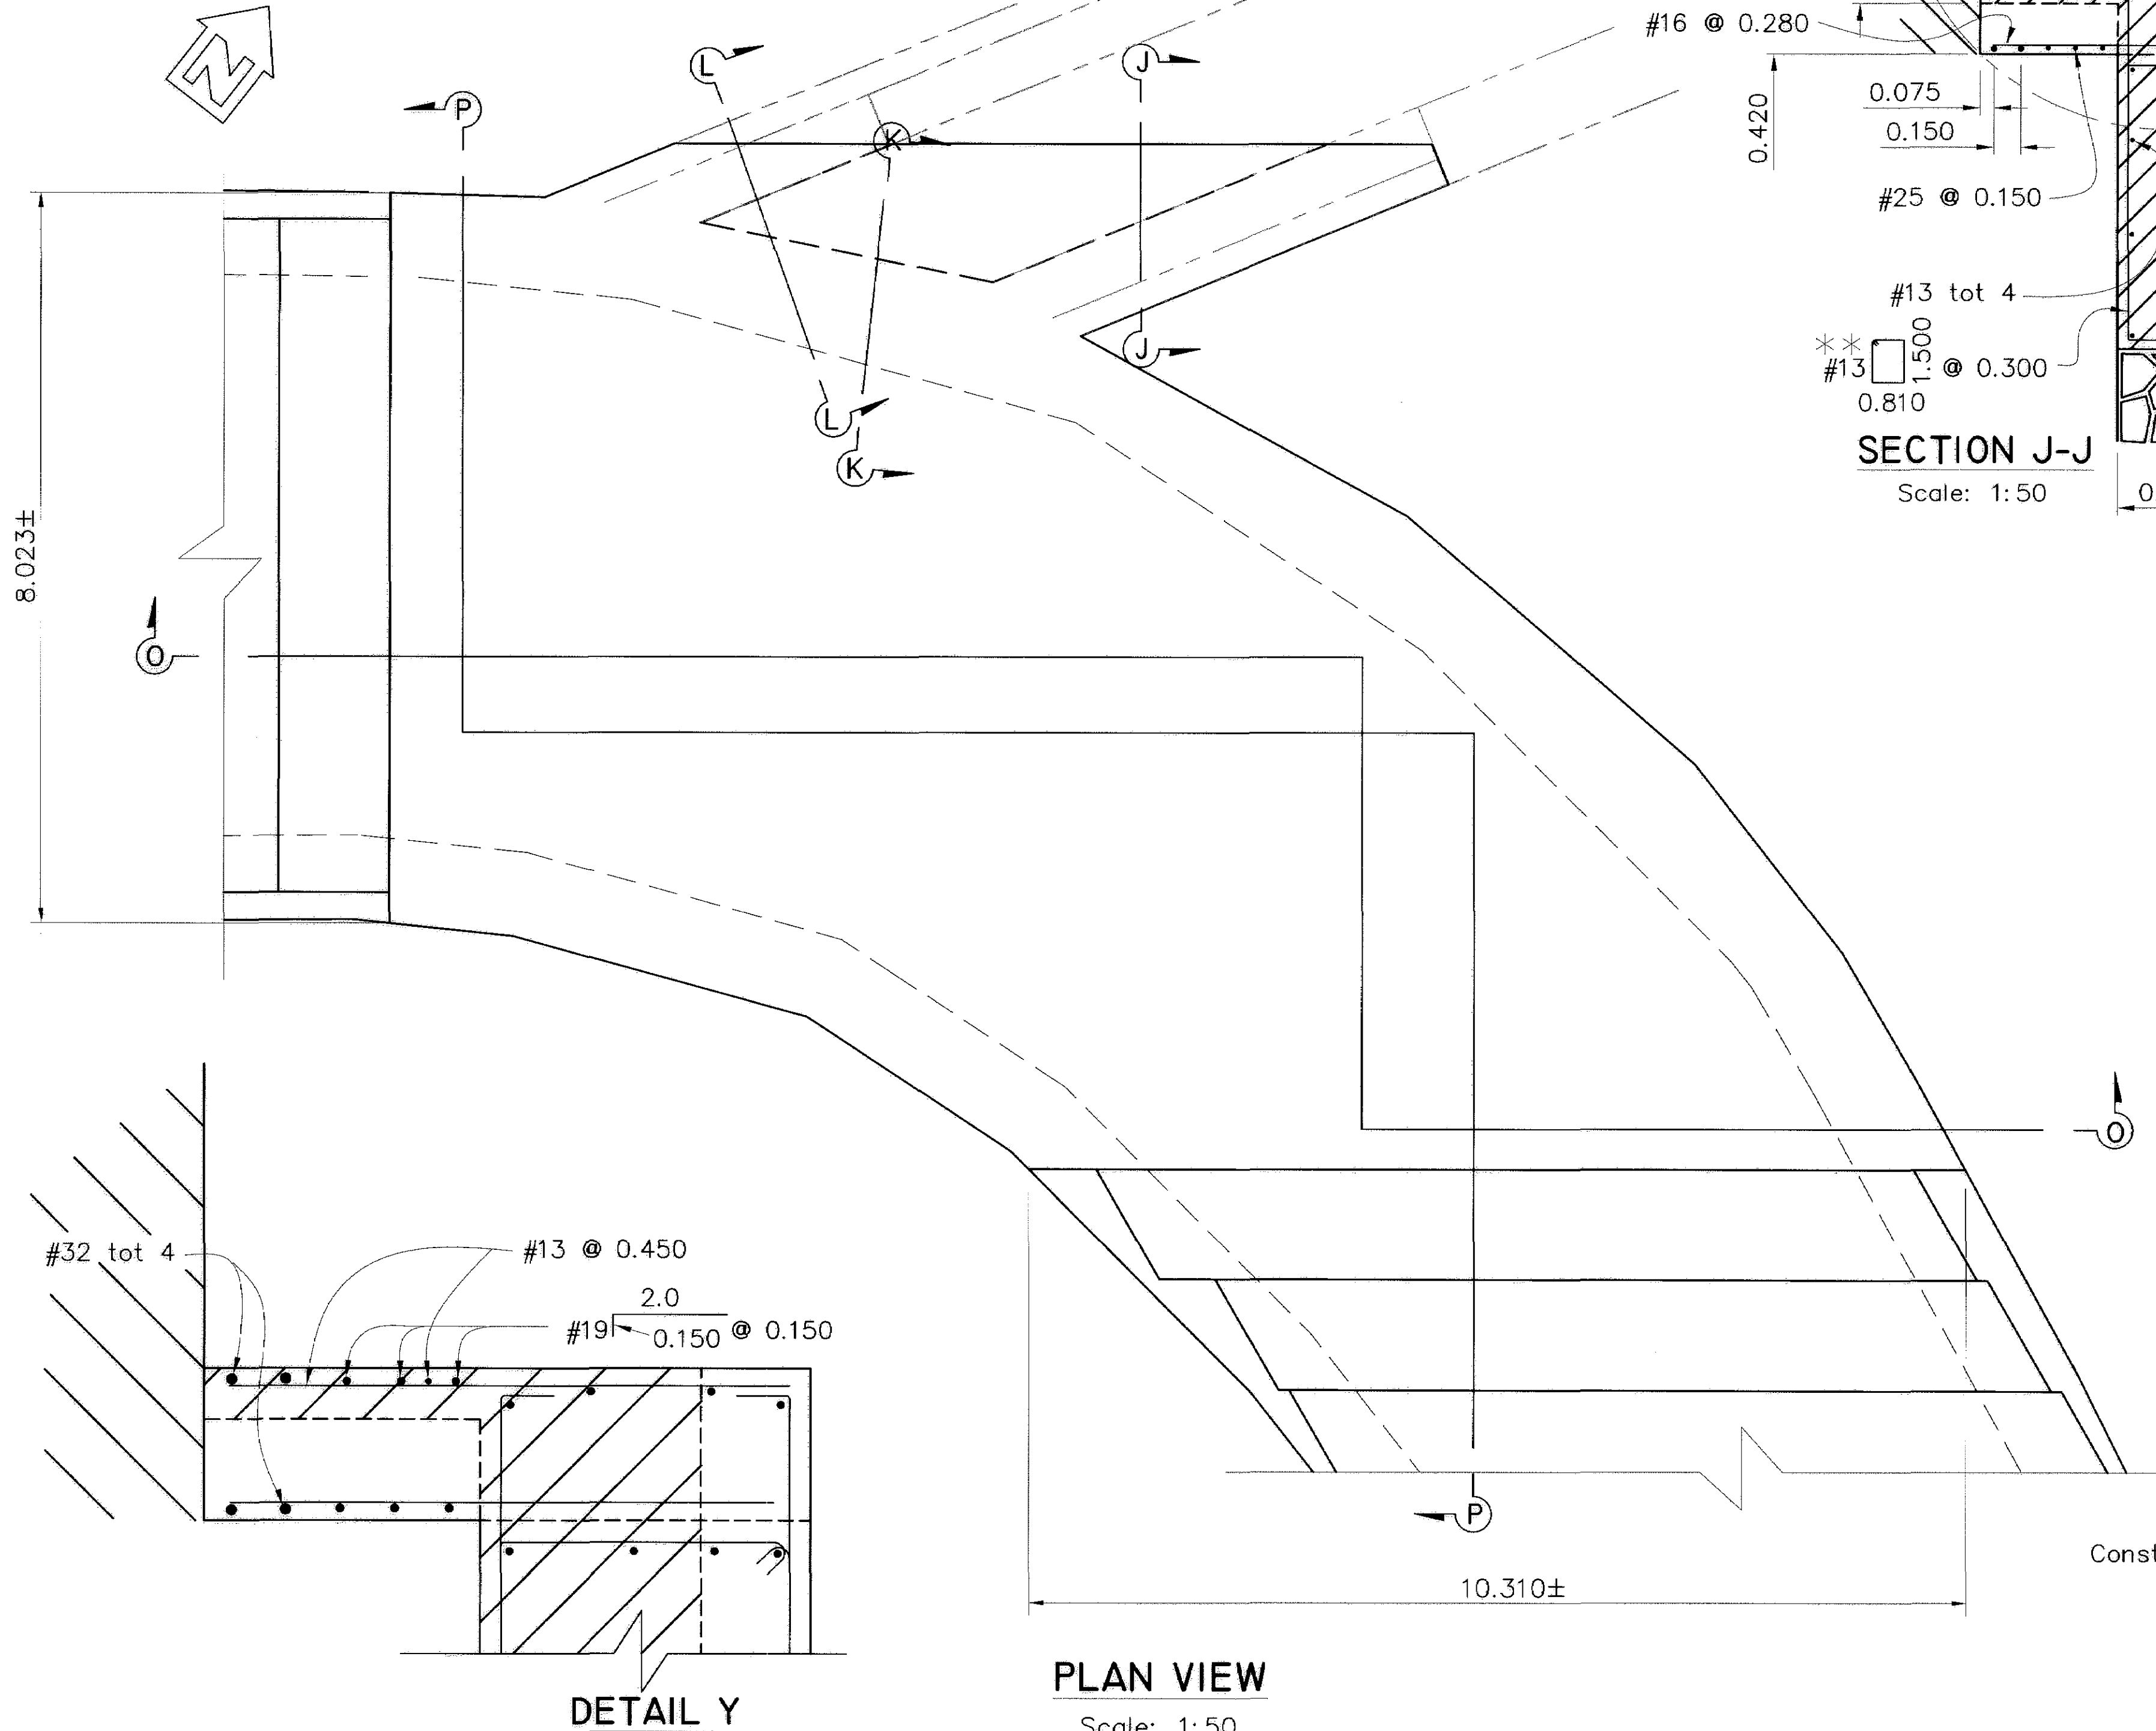


DETAIL Y
Scale: 1:50

PLAN VIEW
Scale: 1:50

The contractor shall verify all
controlling field dimensions before
ordering or fabricating any
materials.

All dimensions are in meters unless otherwise noted

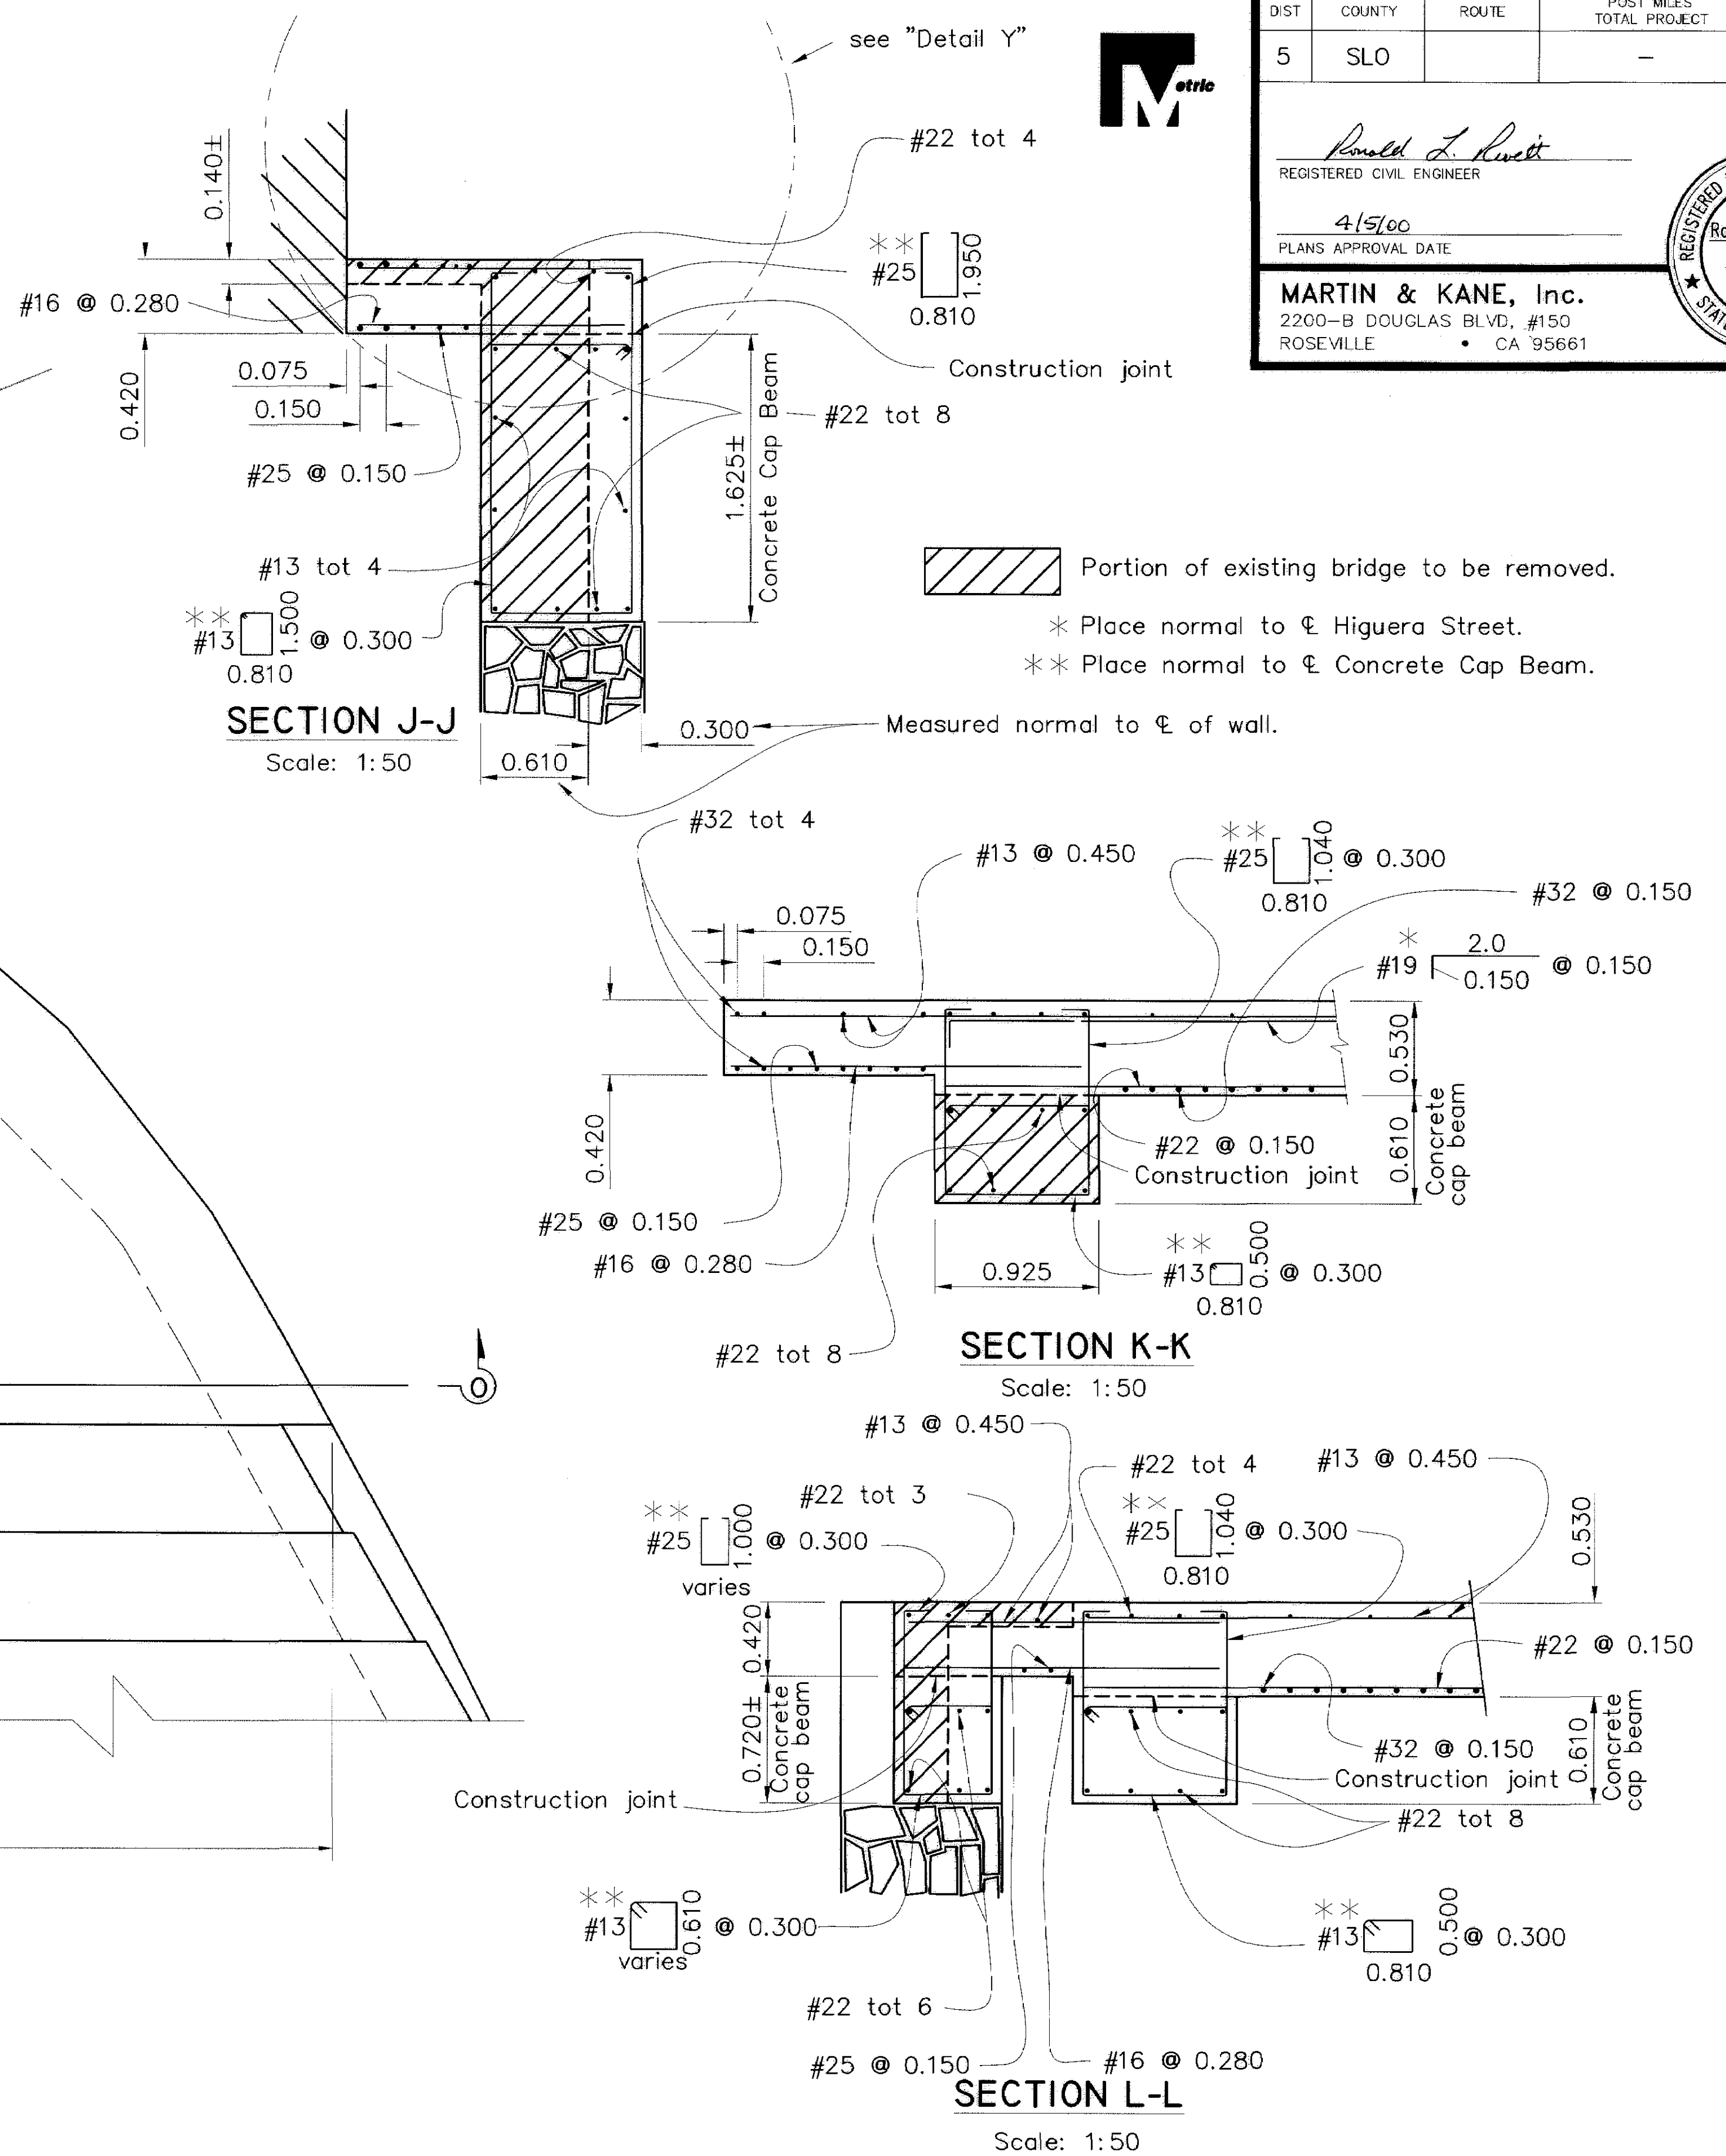

SECTION J-J
Scale: 1:50

SECTION K-K
Scale: 1:50

SECTION L-L
Scale: 1:50



DIST	COUNTY	ROUTE	POST MILES TOTAL PROJECT	SHEET NO.	TOTAL SHEETS
5	SLO		-	36	41

REGISTERED CIVIL ENGINEER
Ronald L. Rivett
4/5/00
PLANS APPROVAL DATE

MARTIN & KANE, Inc.
2200-B DOUGLAS BLVD., #150
ROSEVILLE • CA 95661

REGISTERED PROFESSIONAL ENGINEER
Ronald L. Rivett
No. 31,269
EXP. 12/31/00
CIVIL
STATE OF CALIFORNIA


Portion of existing bridge to be removed.

* Place normal to Φ Higuera Street.

** Place normal to Φ Concrete Cap Beam.

Measured normal to Φ of wall.

N:\MSR\RV\WK PROJECTS\1997\97017.00 HIGUERA STREET BRIDGE REHAB\100% Submittal\97017-SD2.dwg 3-17-00

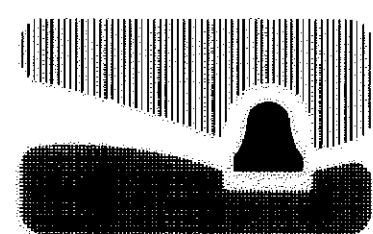

city of san luis obispo

HIGUERA STREET BRIDGE REPLACEMENT

FOR REDUCED PLANS
ORIGINAL SCALE IS IN MILLIMETERS




APPROVED BY
CITY ENGINEER

DATE 3/2000
SCALE As Noted
DESIGNED BY R.F.
DRAWN BY R.D., K.W.
CHECKED BY R.R.
APPROVED BY
UTILITIES DEPARTMENT

SLAB DETAILS NO. 3

SPECIFICATION NO.
9367
FILE NO./LOCATION
0000 B
SHEET
36 of 41

PROJECT: 1997\97017.00 HIGUERA STREET BRIDGE REPAIR 100% Submittal\9/01 / -SD2.dwg 3-17-00

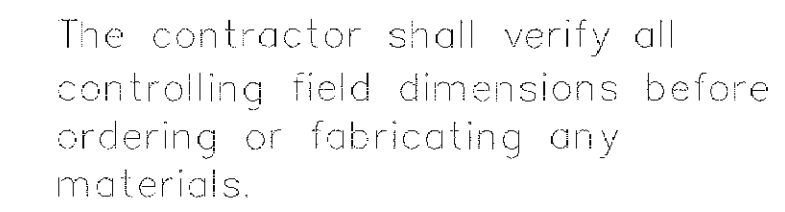[illegible]

CITY ENGINEER

36 OF 41

© 2006 The Authors
Journal compilation © 2006 Blackwell Publishing Ltd

N:\MSR\VR\WK PROJECTS\1997\97017.00 HIGUERA STREET BRIDGE REHAB\100% Submittal\97017-SD2.dwg 3-17-00




DIST	COUNTY	ROUTE	POST MILES TOTAL PROJECT	SHEET NO.	TOTAL SHEETS
5	SLO		—	37	41


Ronald L. Rivett
REGISTERED CIVIL ENGINEER
4/5/00
PLANS APPROVAL DATE

MARTIN & KANE, Inc.
2200-B DOUGLAS BLVD, #150
ROSEVILLE • CA 95661


REGISTERED PROFESSIONAL ENGINEER
No. 31,269
EXP. 12/31/00
CIVIL
STATE OF CALIFORNIA

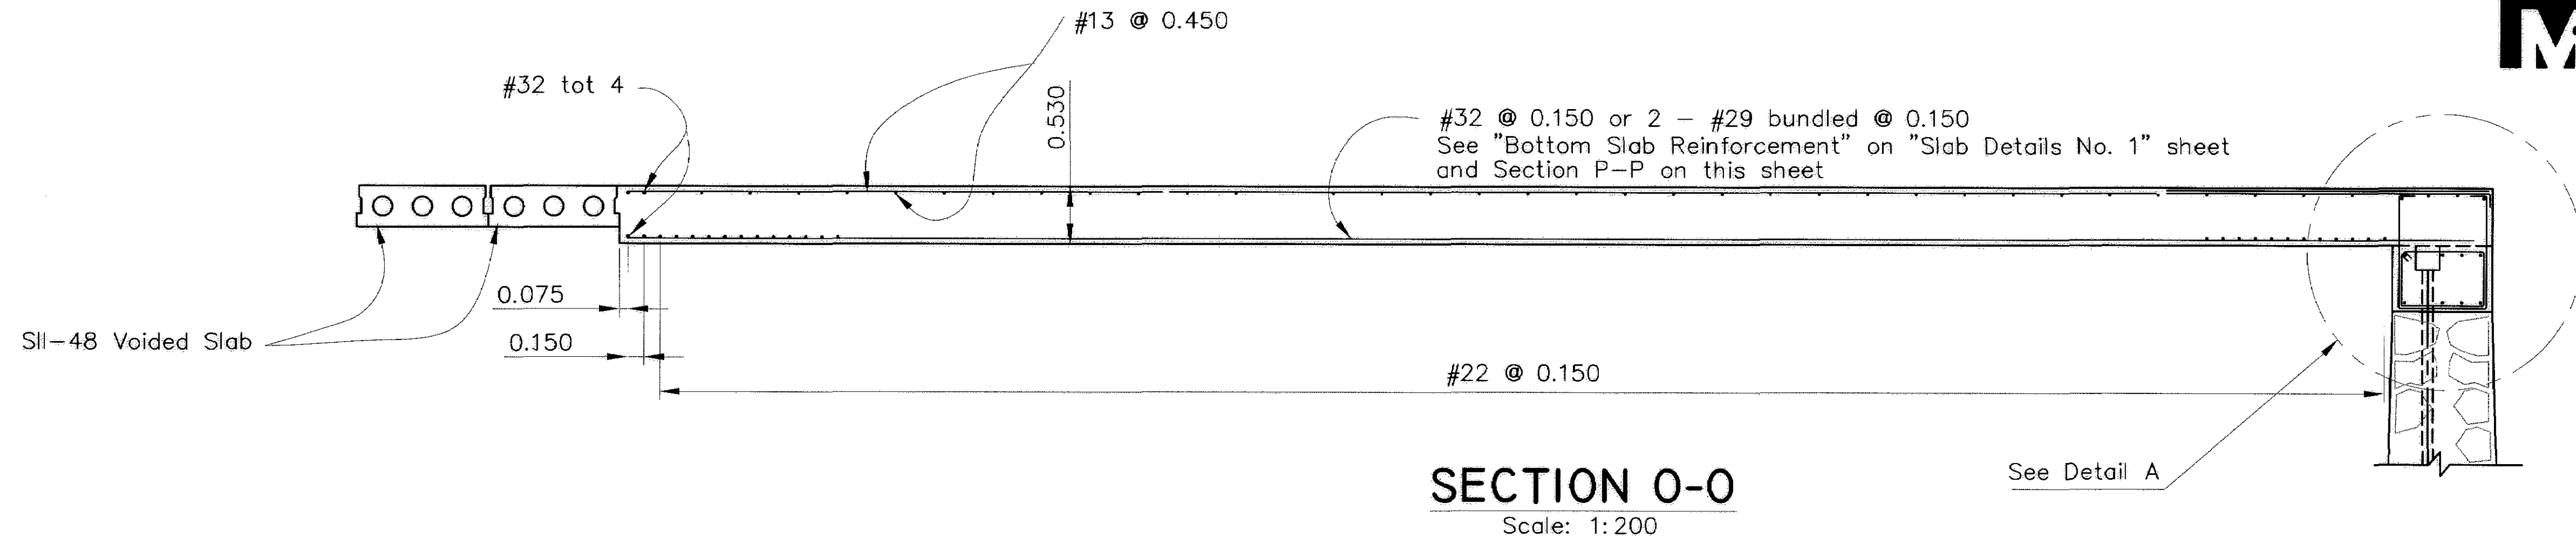


Note: For locations of sections 0-0 and P-P
see "Slab Details No. 3" sheet

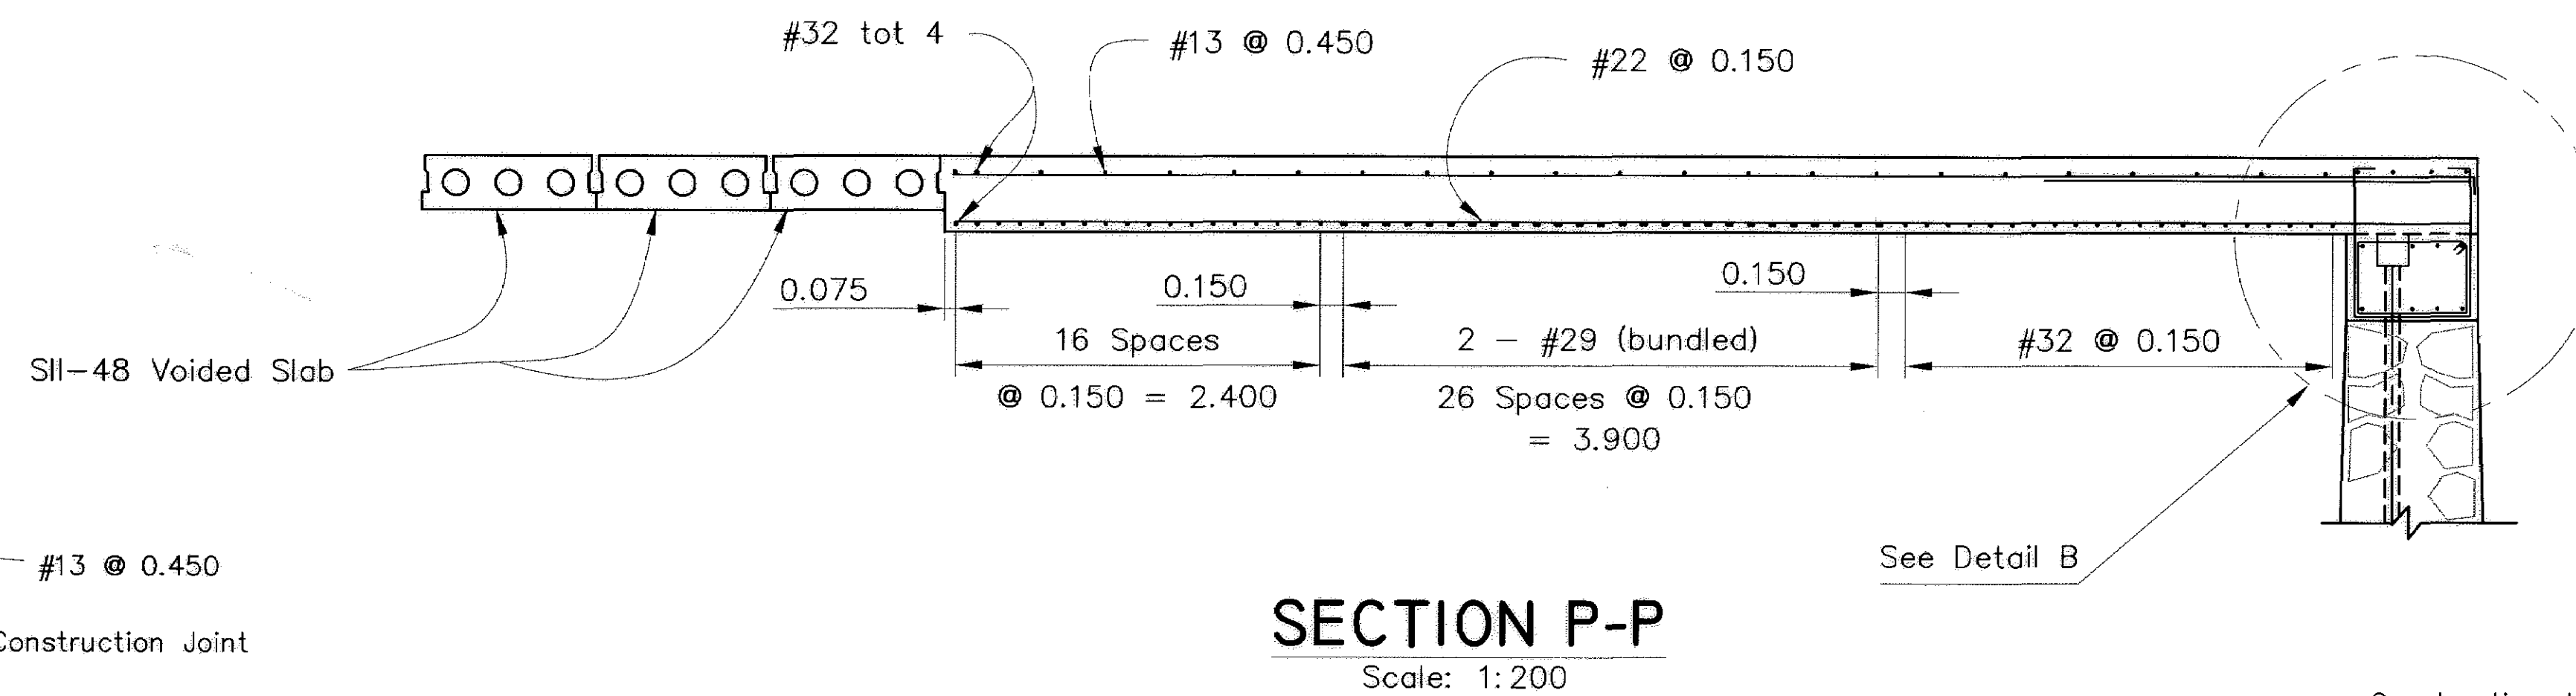


The contractor shall verify all
controlling field dimensions before
ordering or fabricating any
materials.

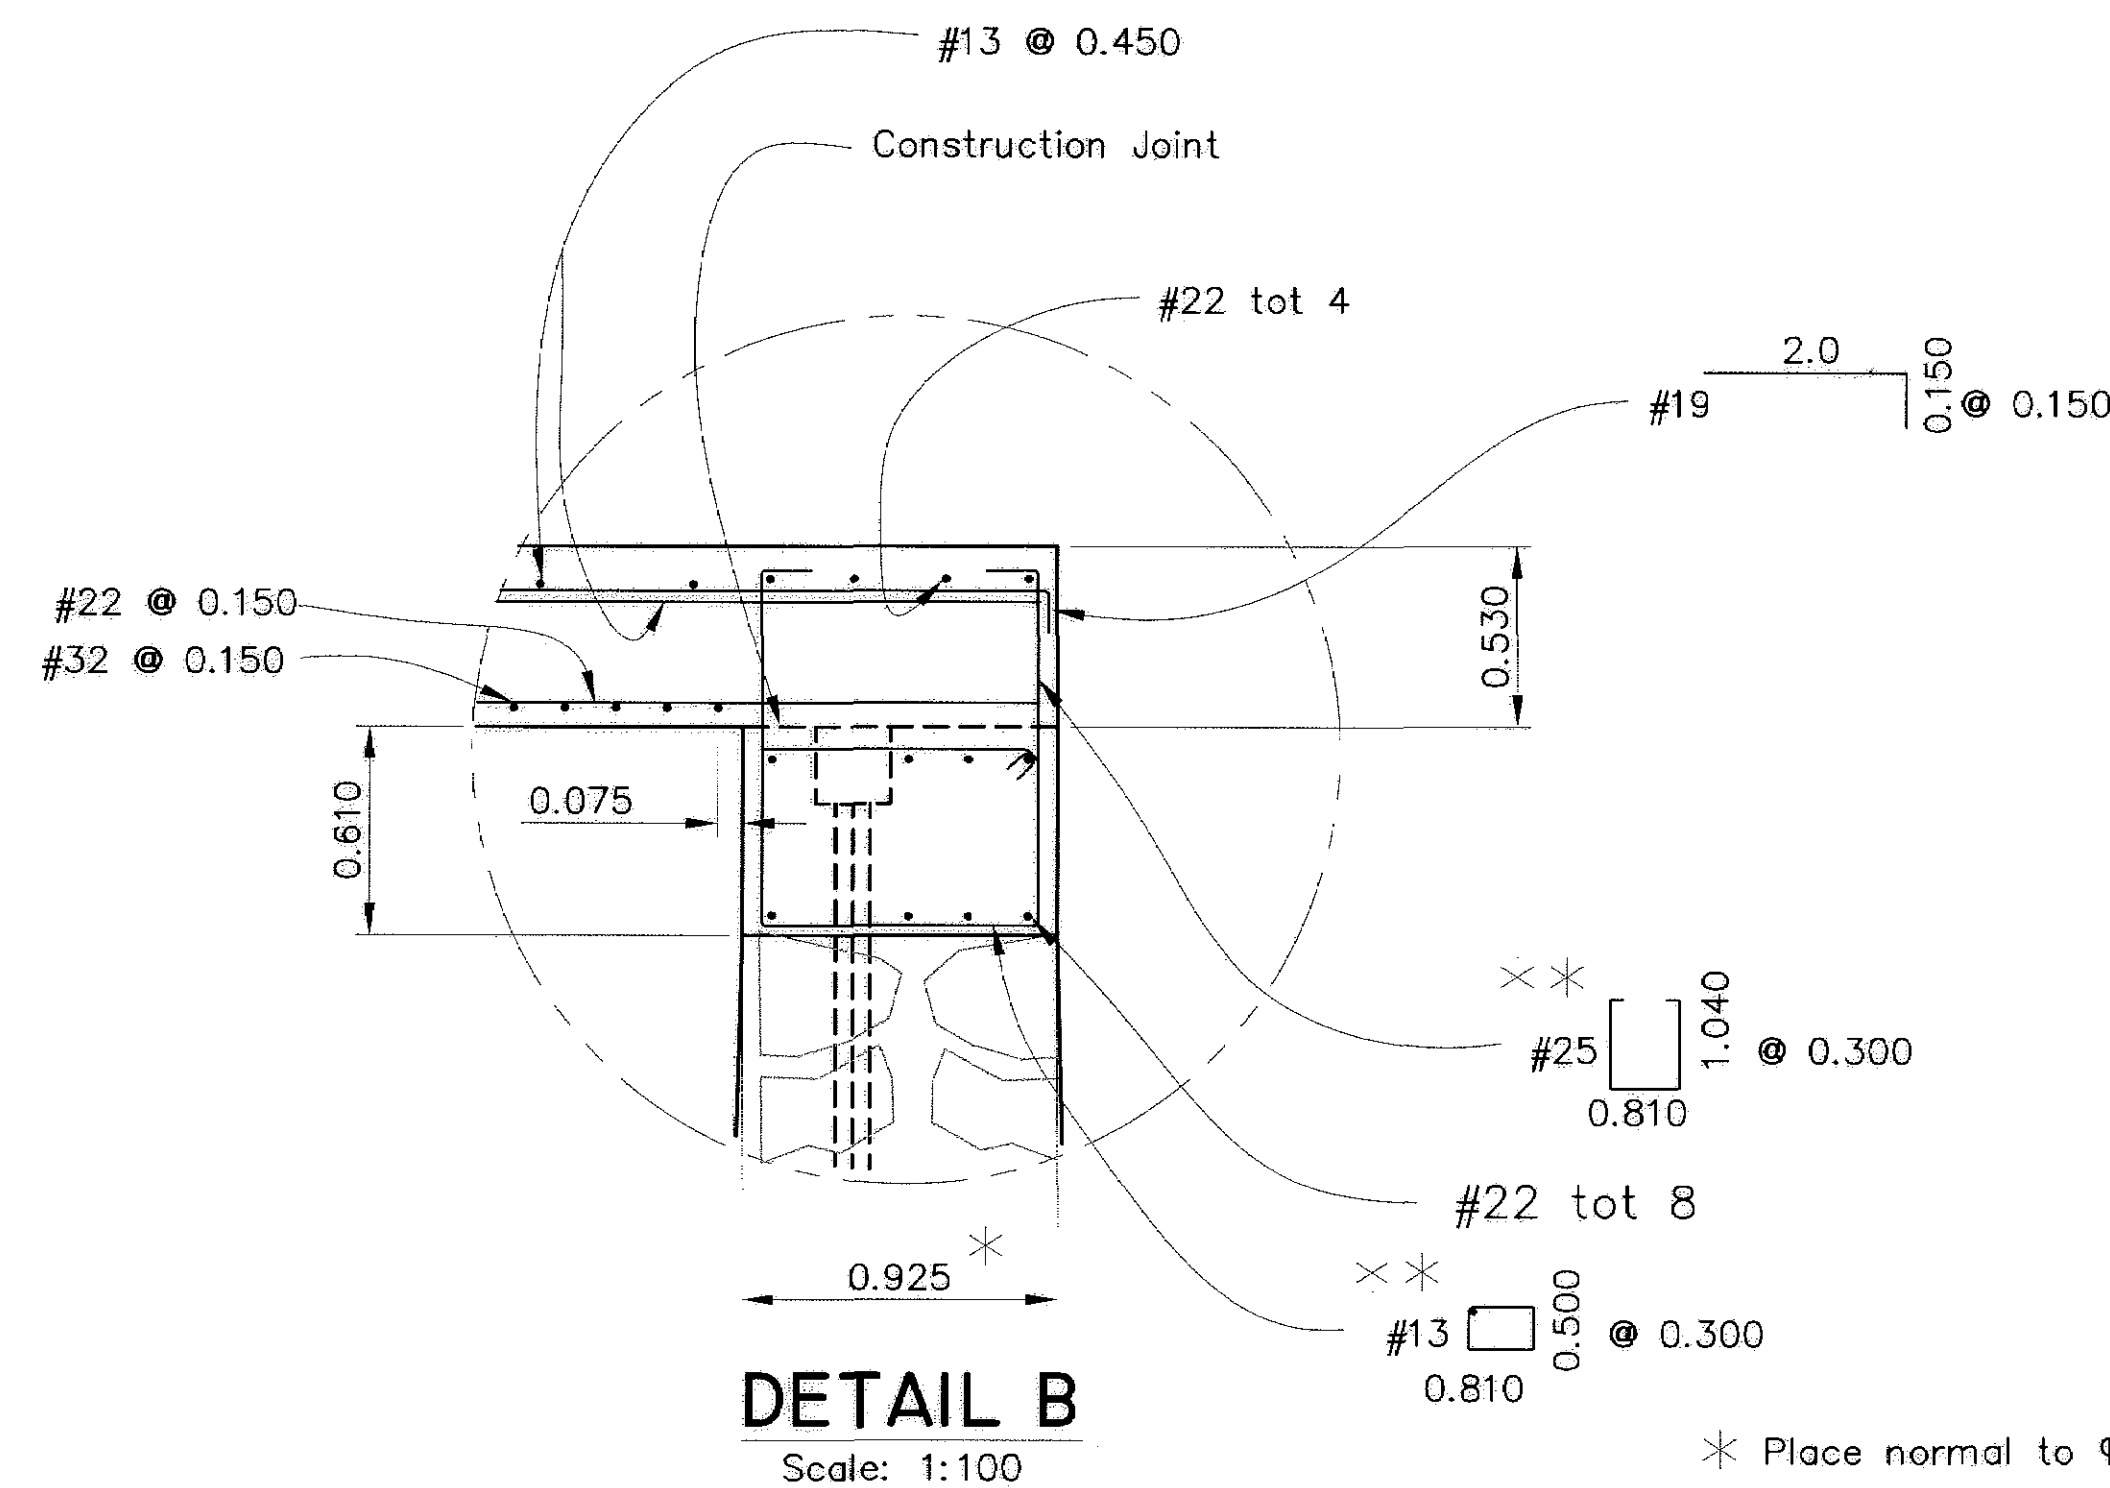

- * Place normal to Higuera Street.
- * * Place normal to Concrete Cap Beam.

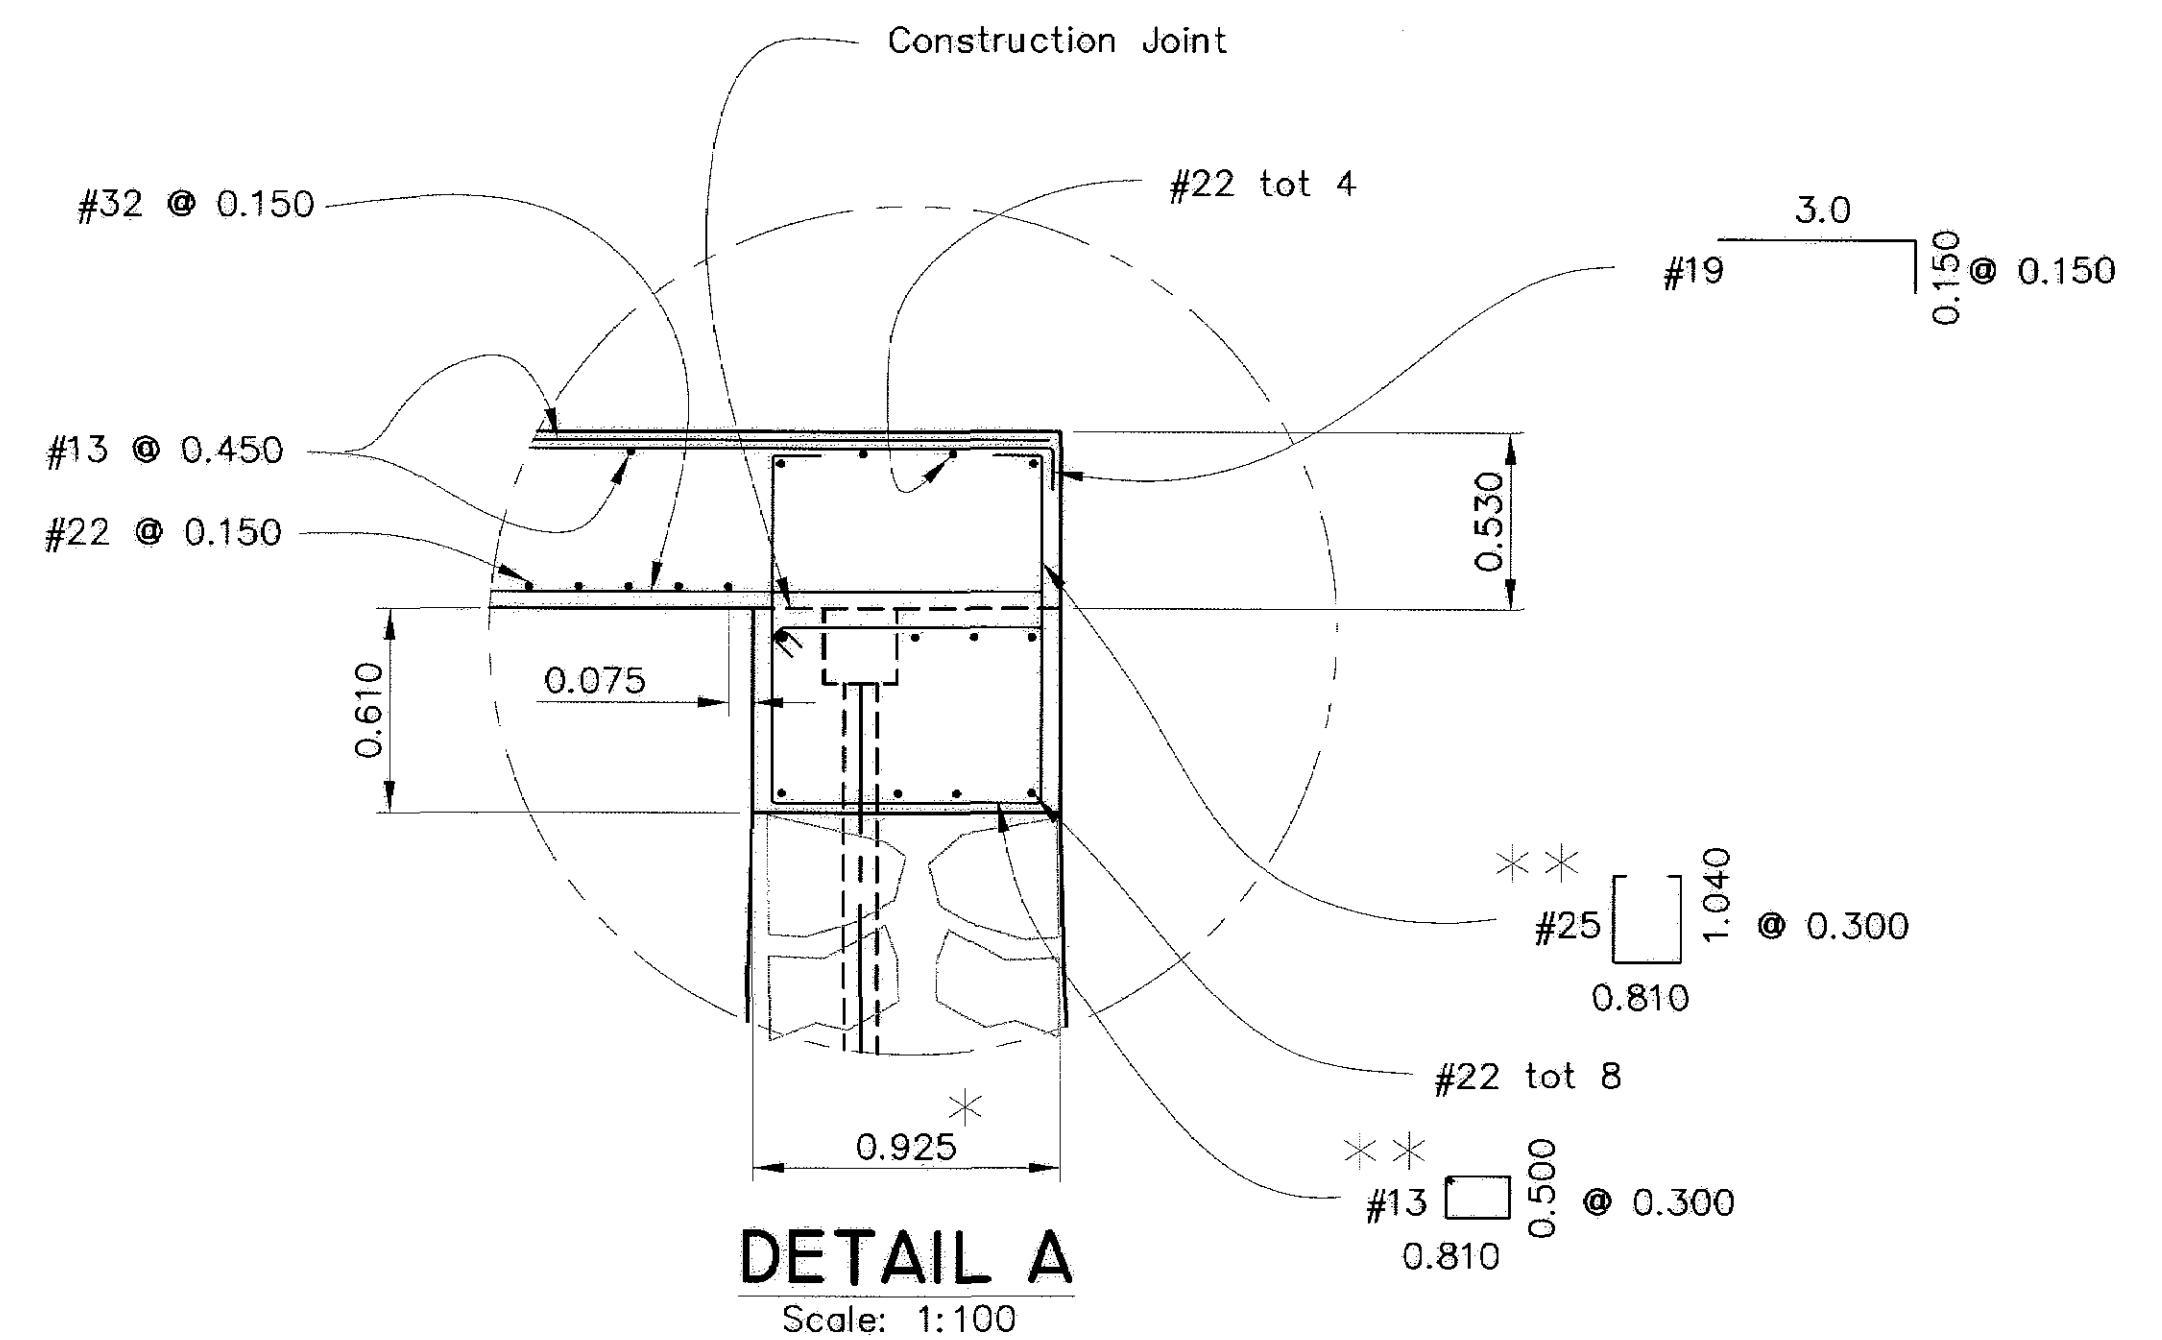

All dimensions are in meters unless otherwise noted

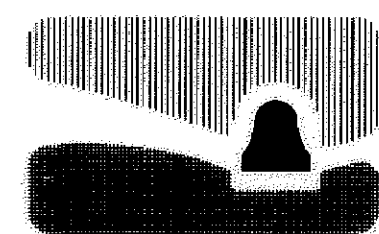

city of san luis obispo

HIGUERA STREET BRIDGE REPLACEMENT

FOR REDUCED PLANS
ORIGINAL SCALE IS IN MILLIMETERS



APPROVED BY

CITY ENGINEER

DATE	3/2000
SCALE	As Noted
DESIGNED BY	R.F.
DRAWN BY	R.D., K.W.
CHECKED BY	R.R.
APPROVED BY	
UTILITIES DEPARTMENT	

SLAB DETAILS NO. 4

SPECIFICATION NO.	9367
FILE NO./LOCATION	0060 B
SHEET	37 OF 41

DIST

COUNTY

ROUTE

POST MILES
TOTAL PROJECT

SHEET
NO.

TOTAL
SHEETS

5

S_O

—

37

41

REGISTERED CIVIL ENGINEER

PLANS APPROVAL DATE

MARTIN & KANE, Inc.
2200-B DOUGLAS BLVD., #150
ROSEVILLE • CA 95661

REGISTERED PROFESSIONAL ENGINEER


Ronald L. Rivett

No. 31,269

EXP. 12/31/00

CIVIL

STATE OF CALIFORNIA

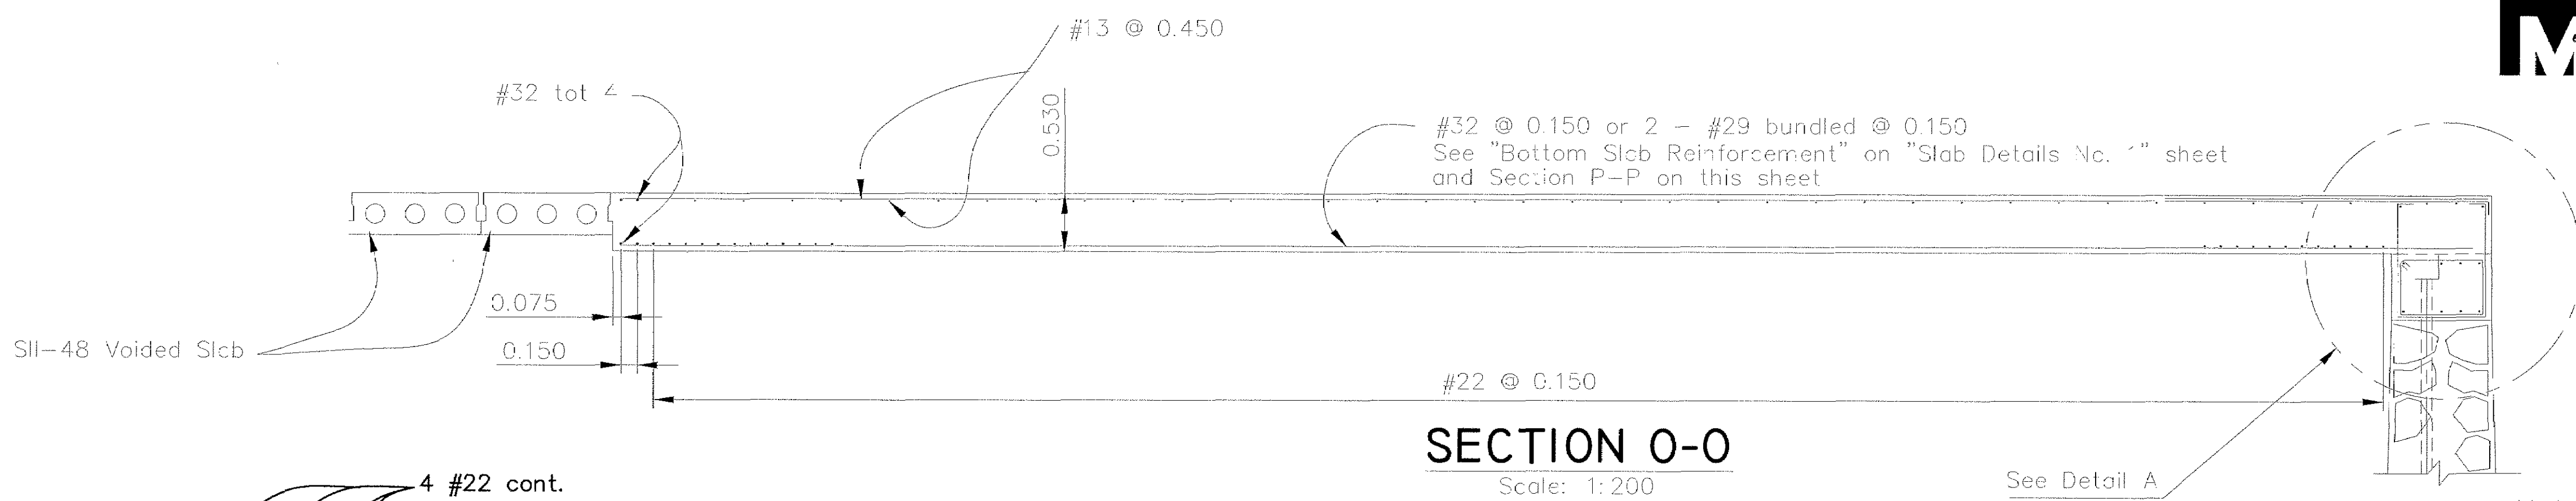


SECTION 0-0

Scale: 1:200


See Detail A

Note: For locations of sections 0-0 and P-P see "Slab Details No. 3" sheet

The contractor shall verify all controlling field dimensions before ordering or fabricating any materials.

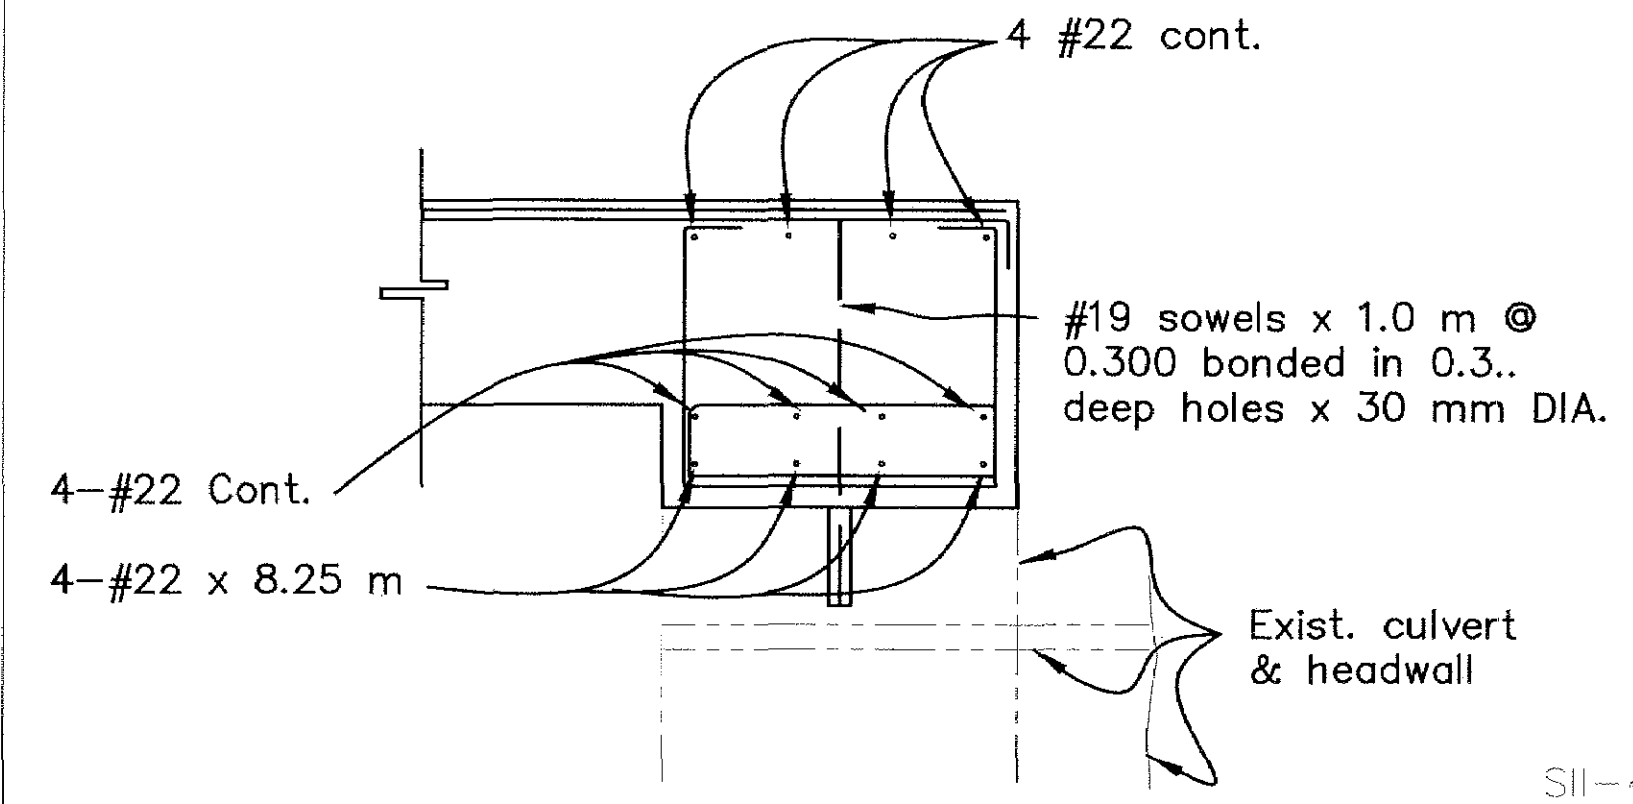


SECTION K₁ - K₁

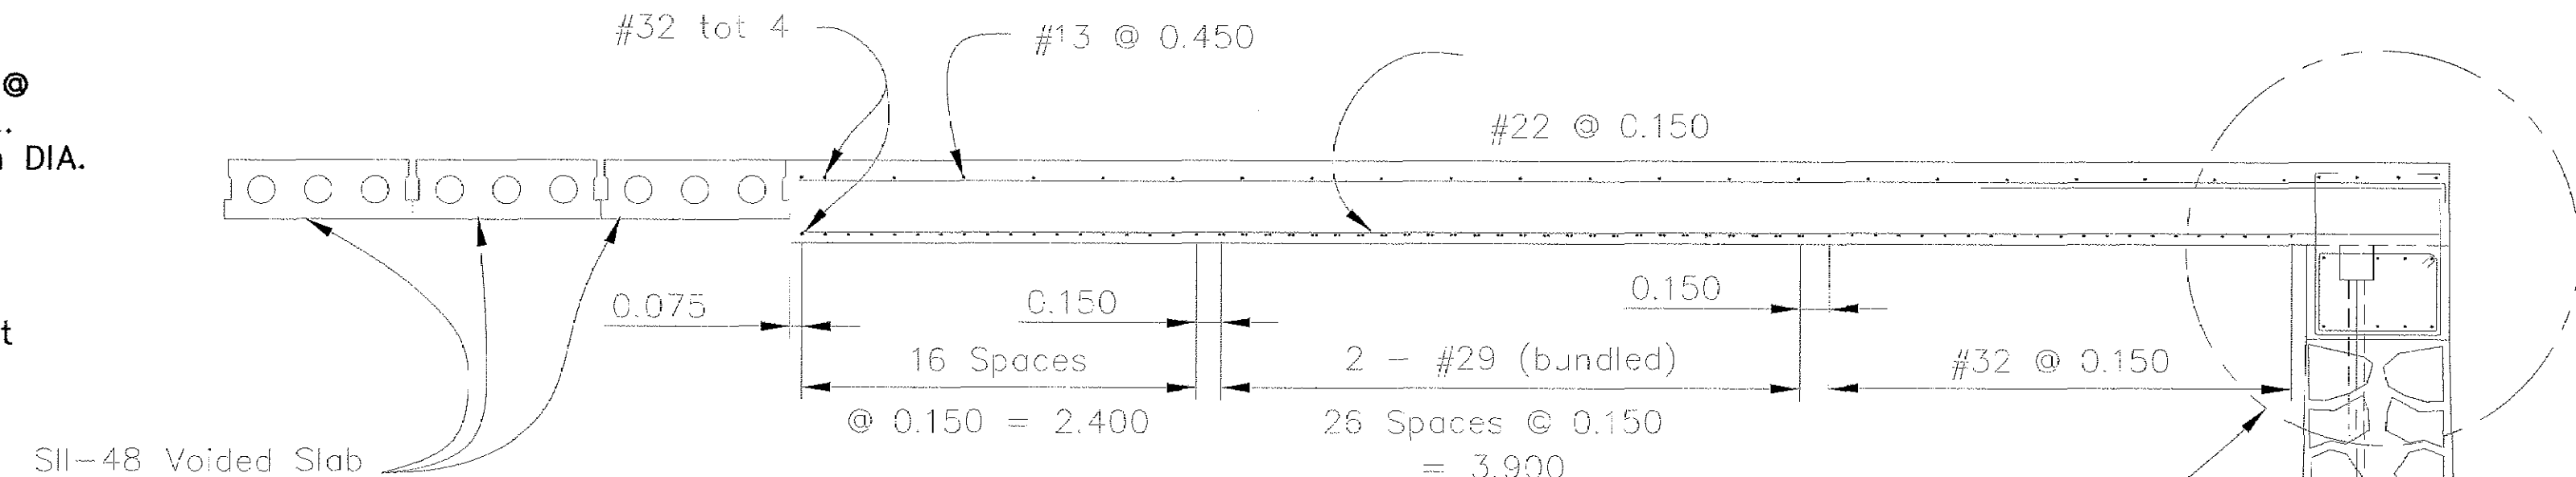

SECTION P-P


Scale: 1:200

See Detail B

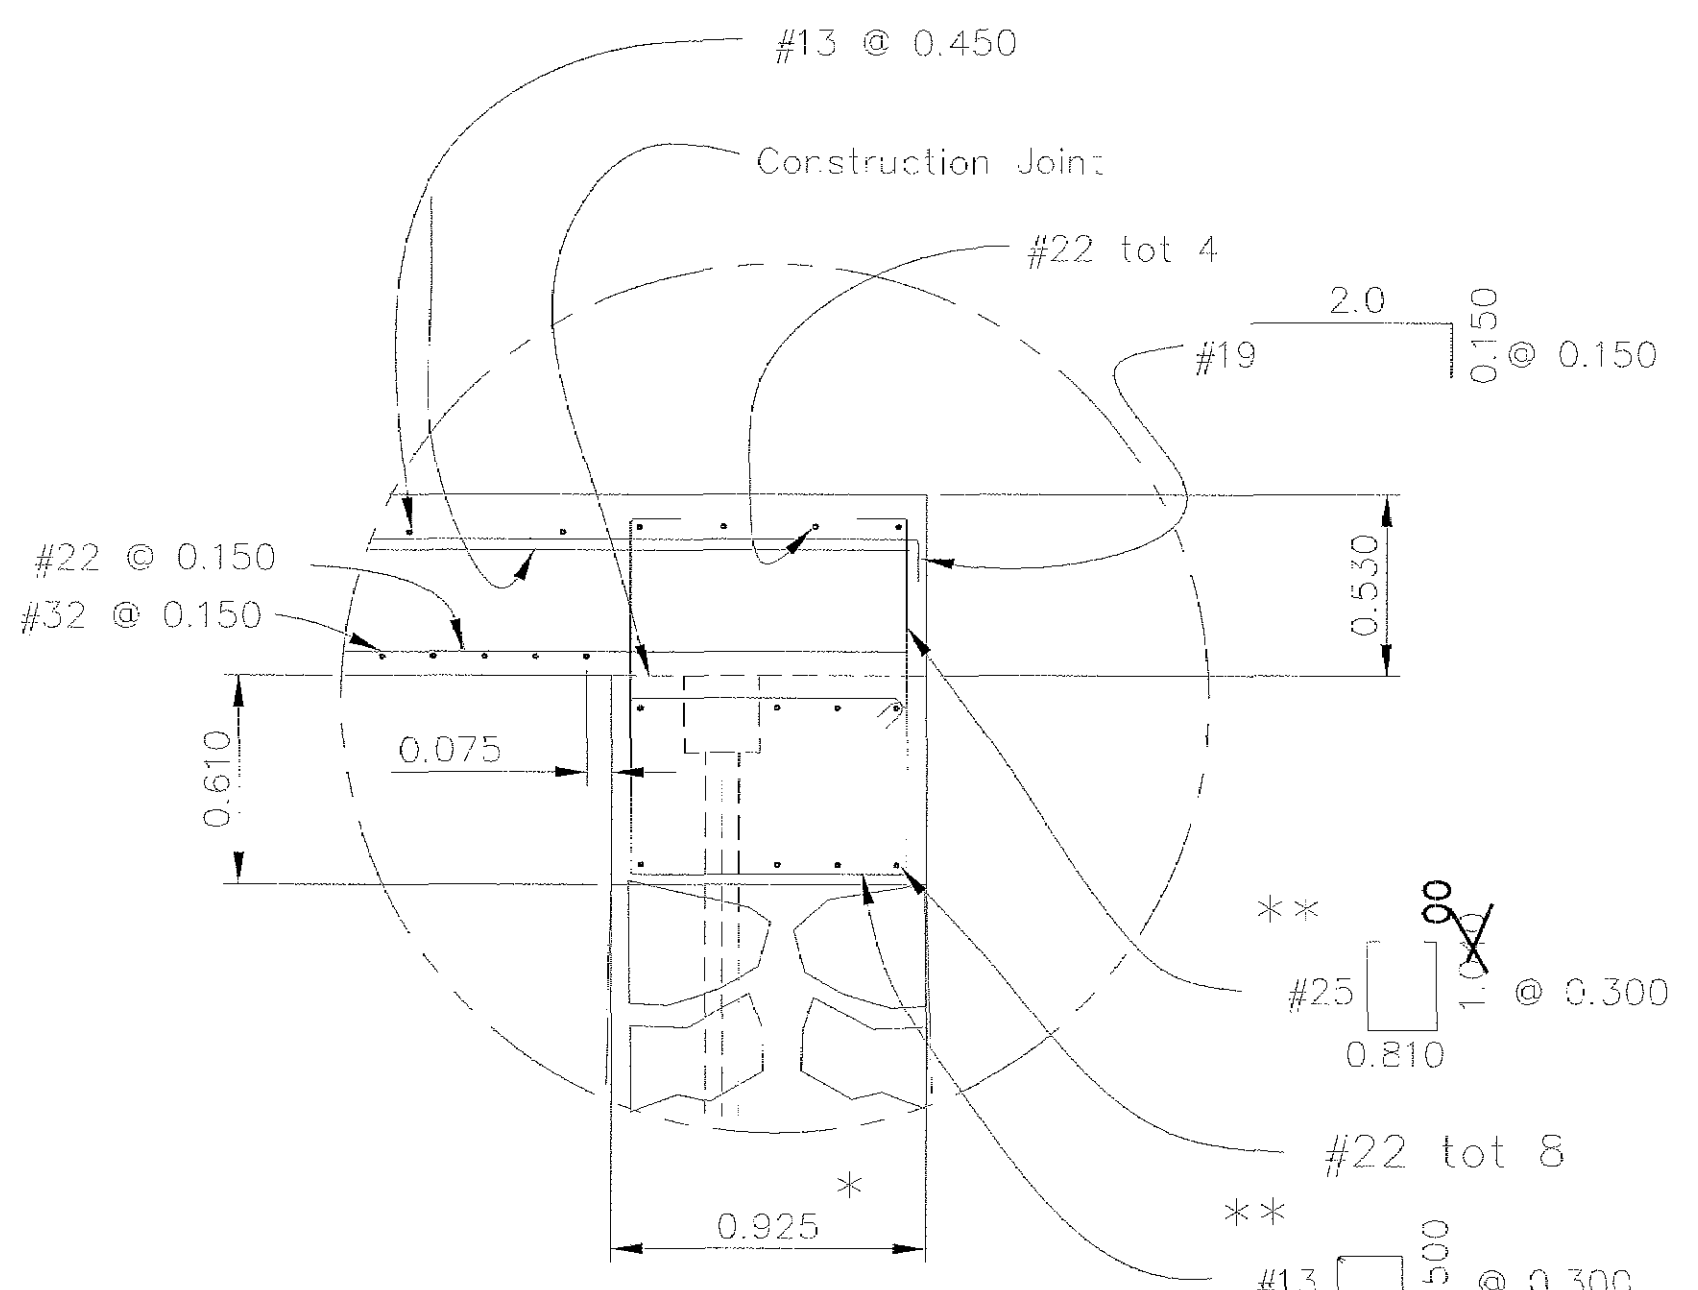


DETAIL B

Scale: 1:100

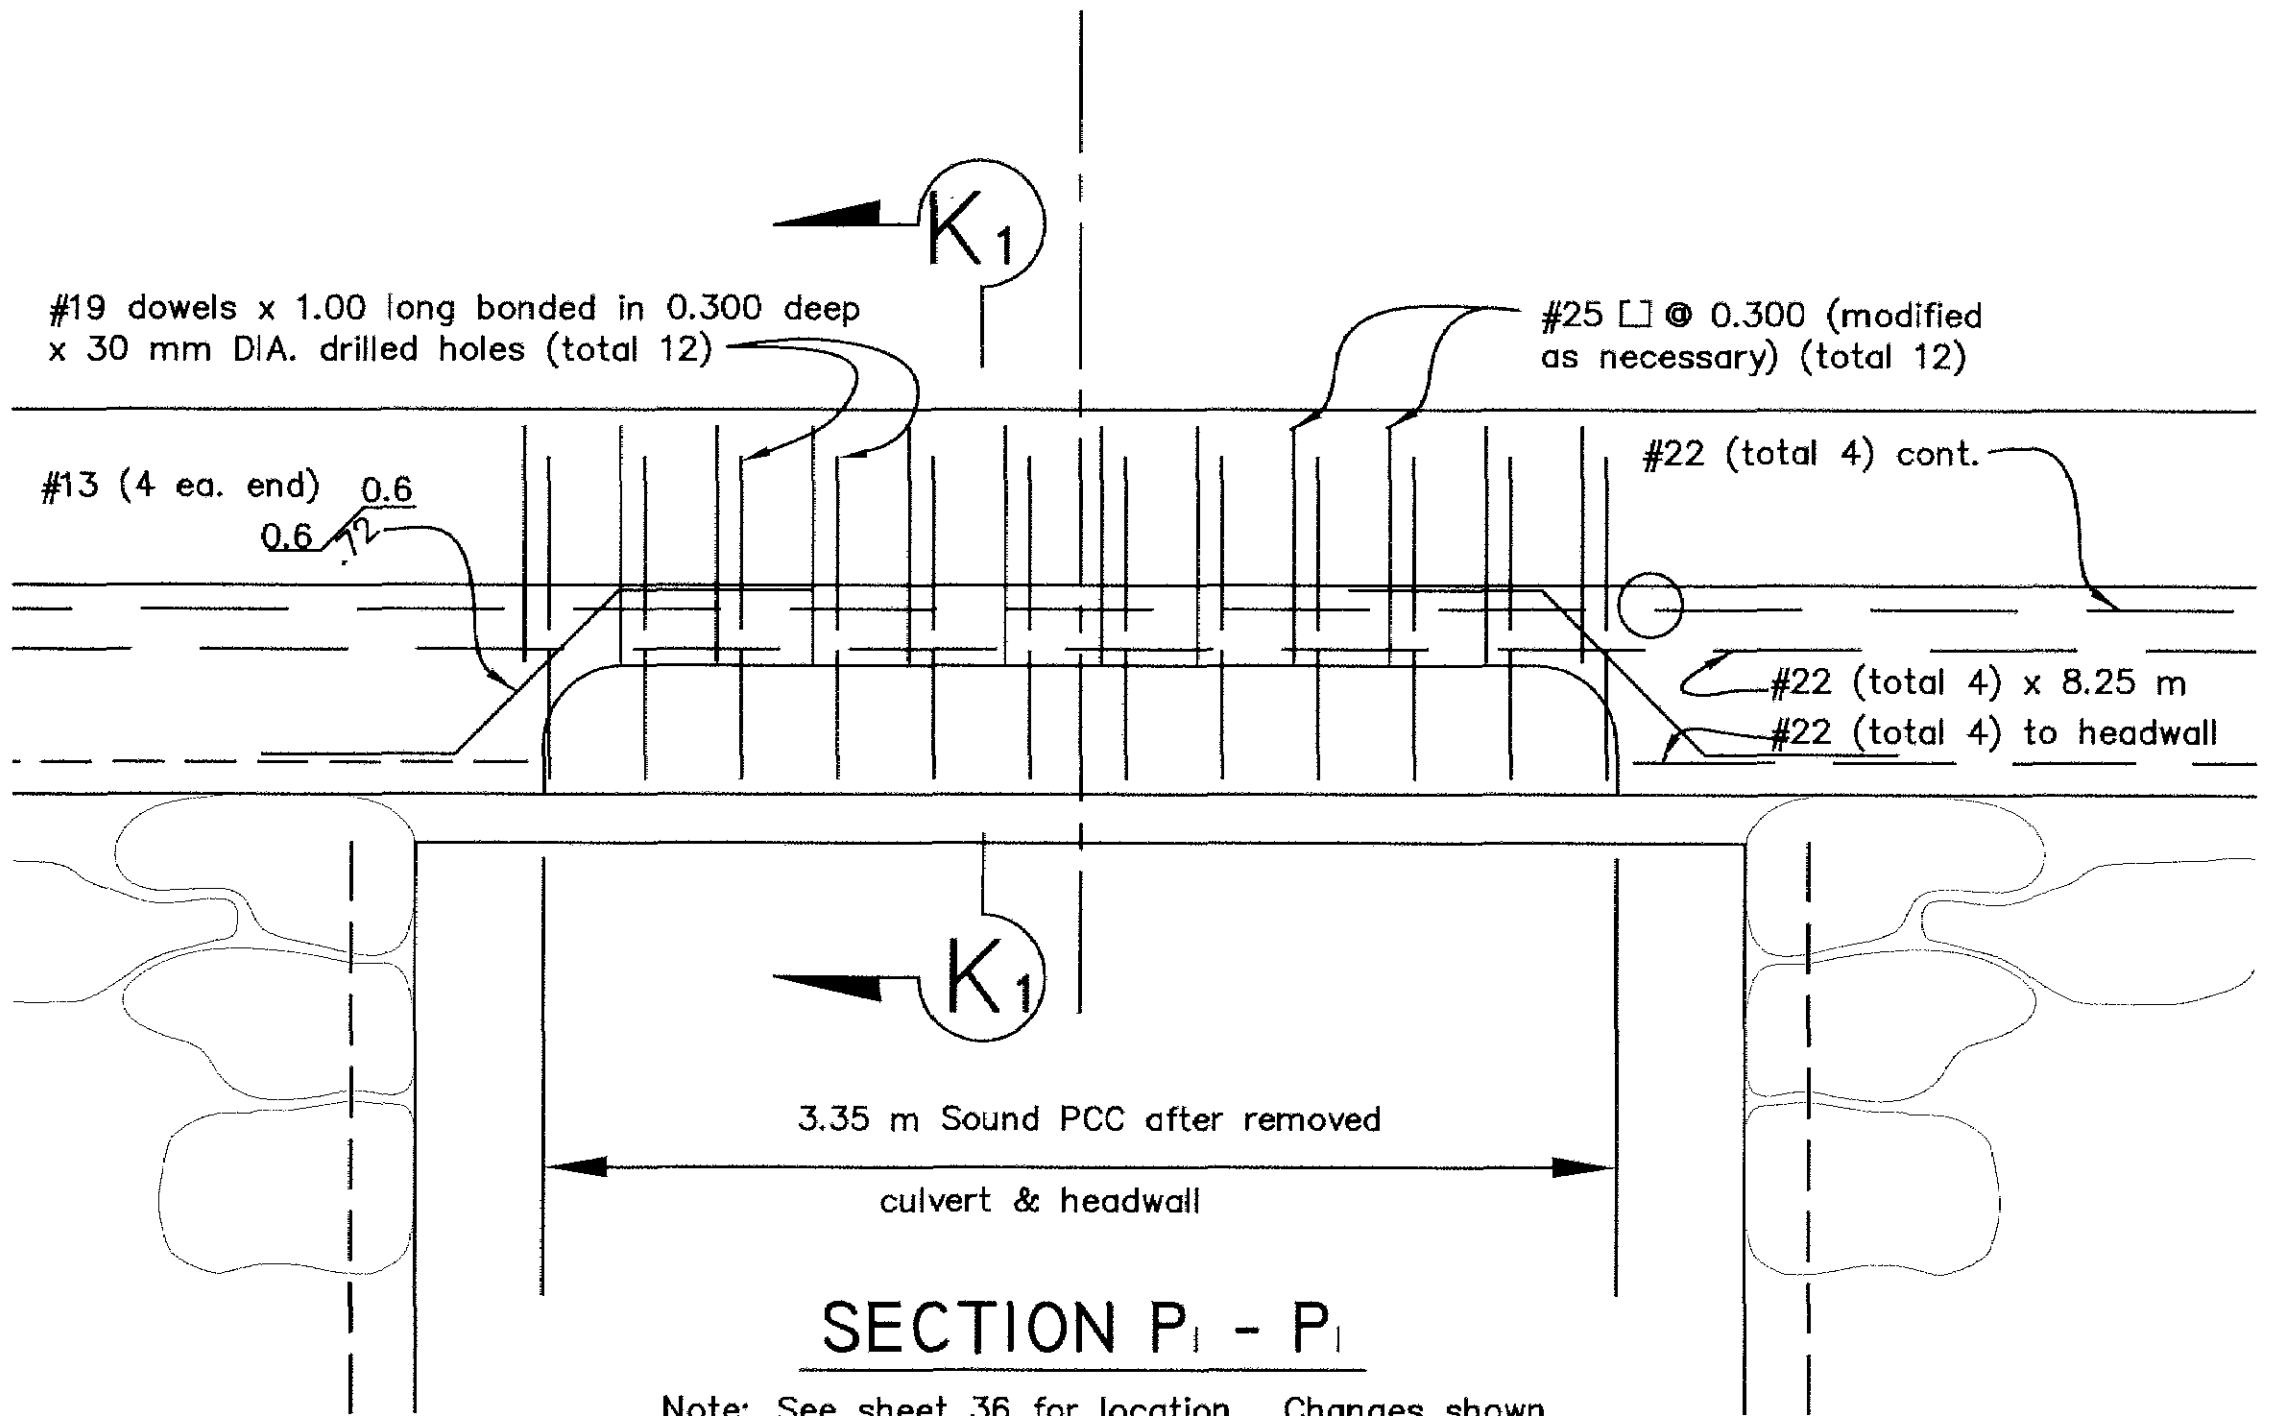

SECTION P₁ - P₁

Note: See sheet 36 for location. Changes shown in sections P₁ - P₁ & K₁ - K₁ are per CC) 33

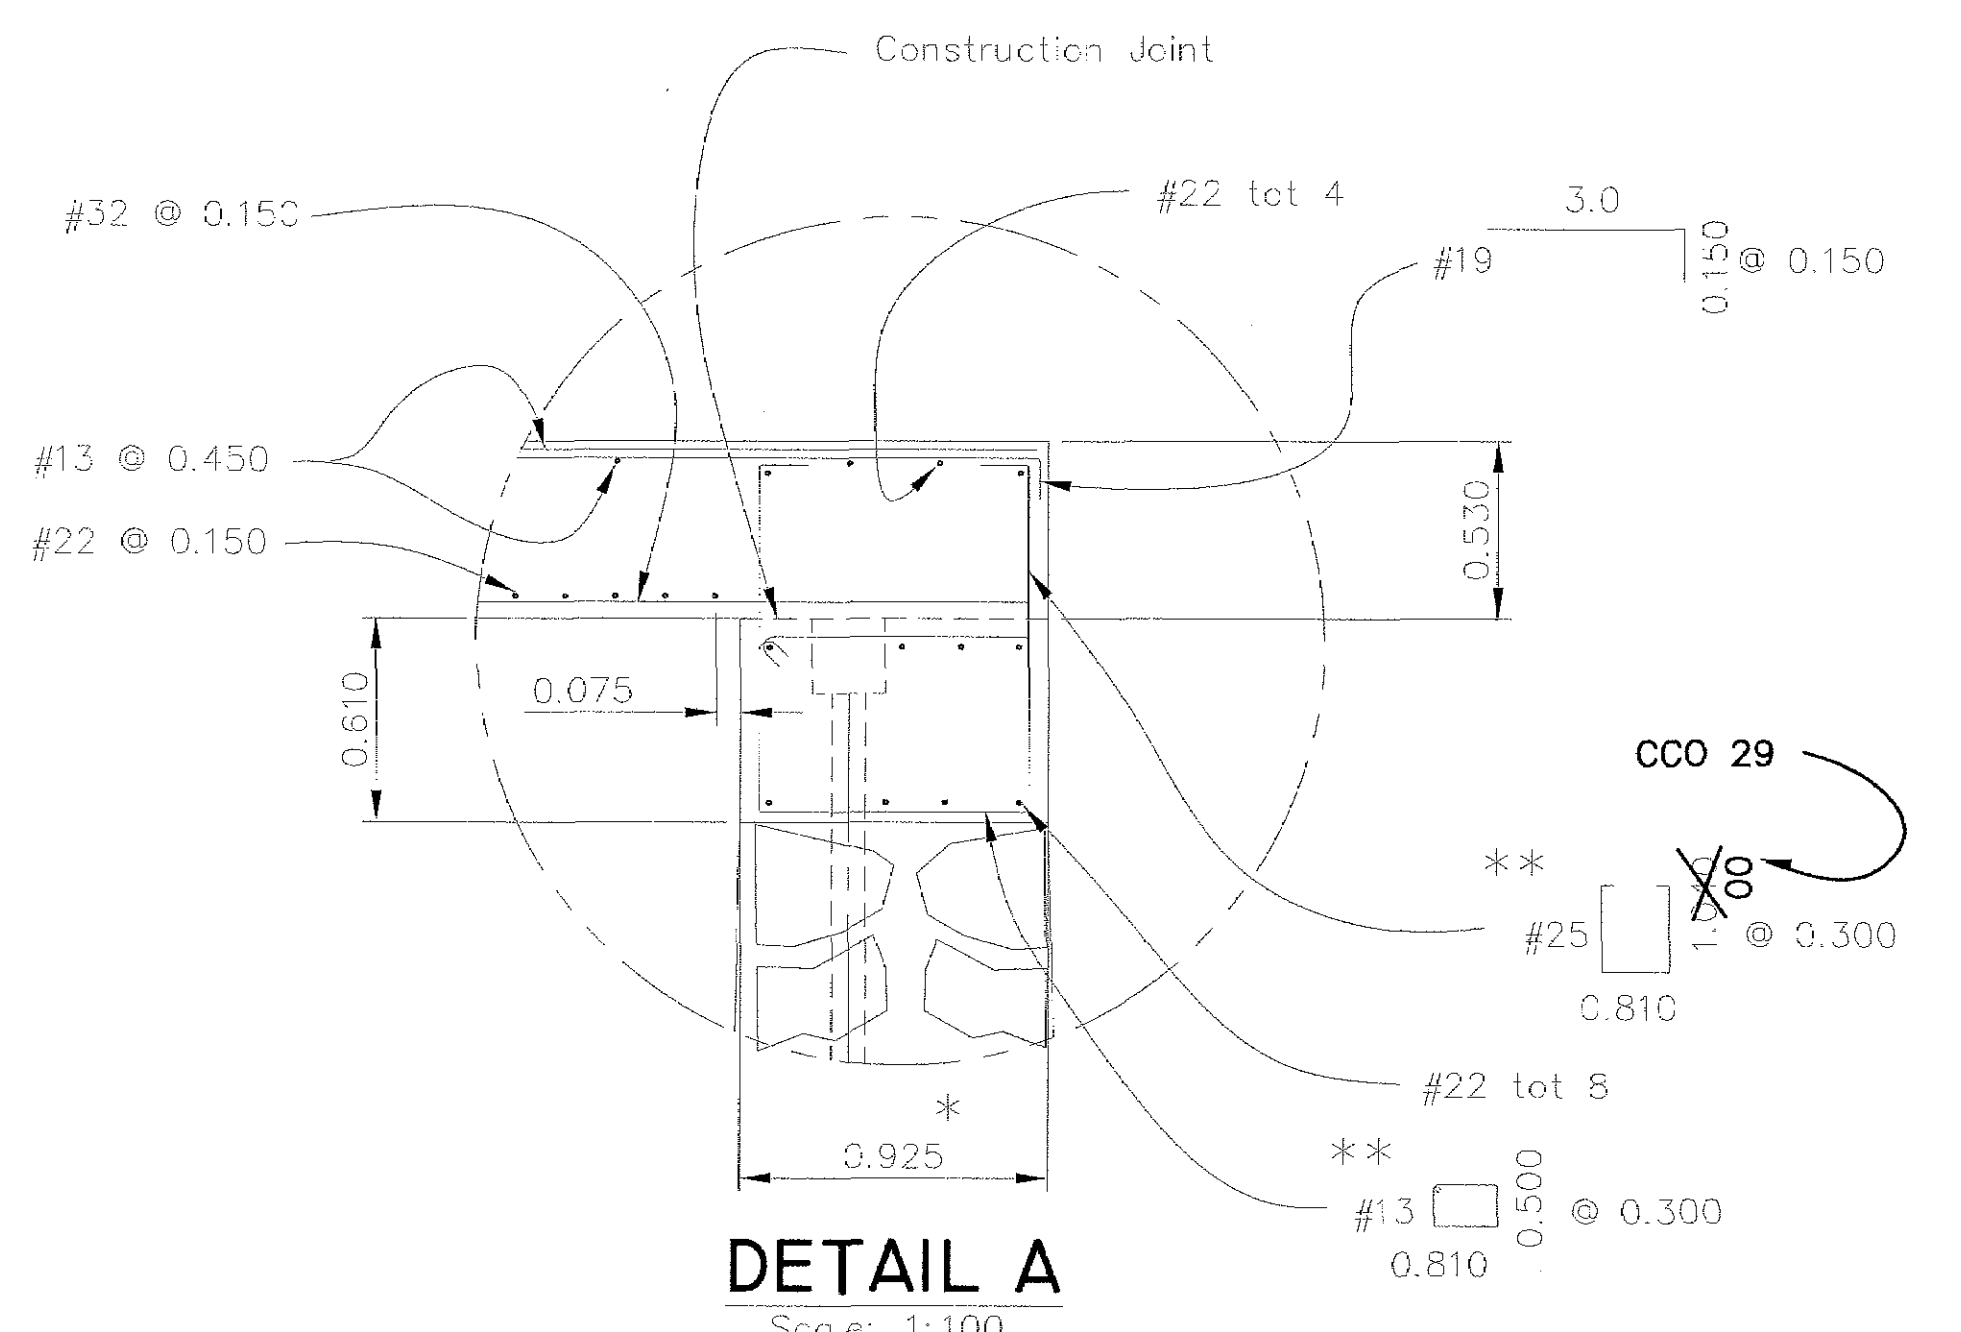

DETAIL A

Scale: 1:100

* Place normal to ? Higuera Street.
** Place normal to ? Concrete Cap Beam.

RECORD DRAWING
DATE: 3/24/02 BY: SR

All dimensions are in meters unless otherwise noted

city of san luis obispo

HIGUERA STREET BRIDGE REPLACEMENT

FOR REDUCED PLANS
ORIGINAL SCALE IS IN MILLIMETERS

0 20 40 60 80 100

APPROVED BY

CITY ENGINEER

DATE 3/2000

SCALE As Noted

DESIGNED BY R.F.

DRAWN BY R.D., K.W.

CHECKED BY R.R.

APPROVED BY

UTILITIES DEPARTMENT


SLAB DETAILS NO. 4

SPECIFICATION NO. 9367


FILE NO./LOCATION 0060 B

SHEET 37R of 41


N:\MSRVR\WK PROJECTS\1997\97017.00 HIGUERA STREET BRIDGE REHAB\100% Submittal\97017-SD.dwg 3/17/00

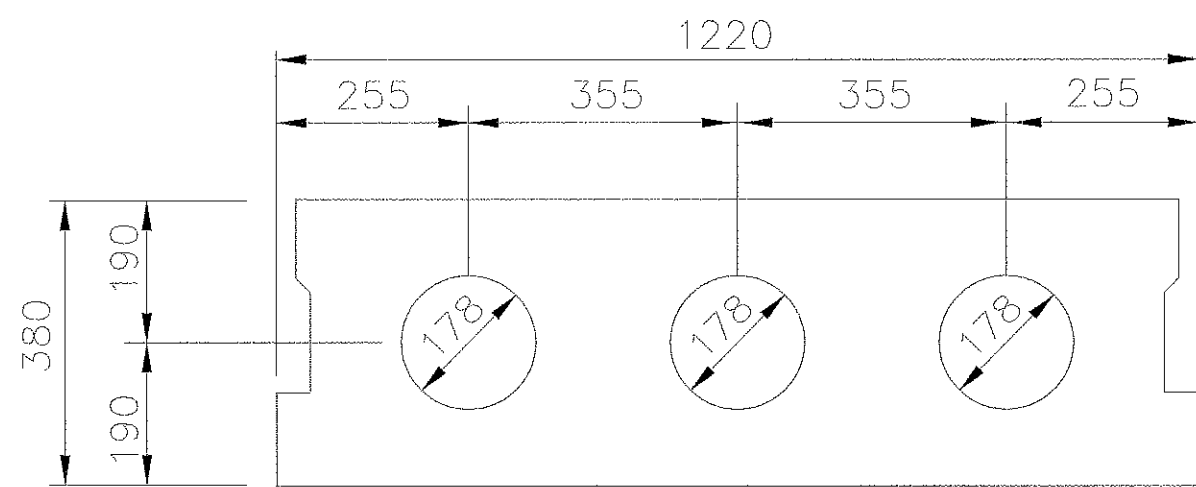

SII-48
1:10

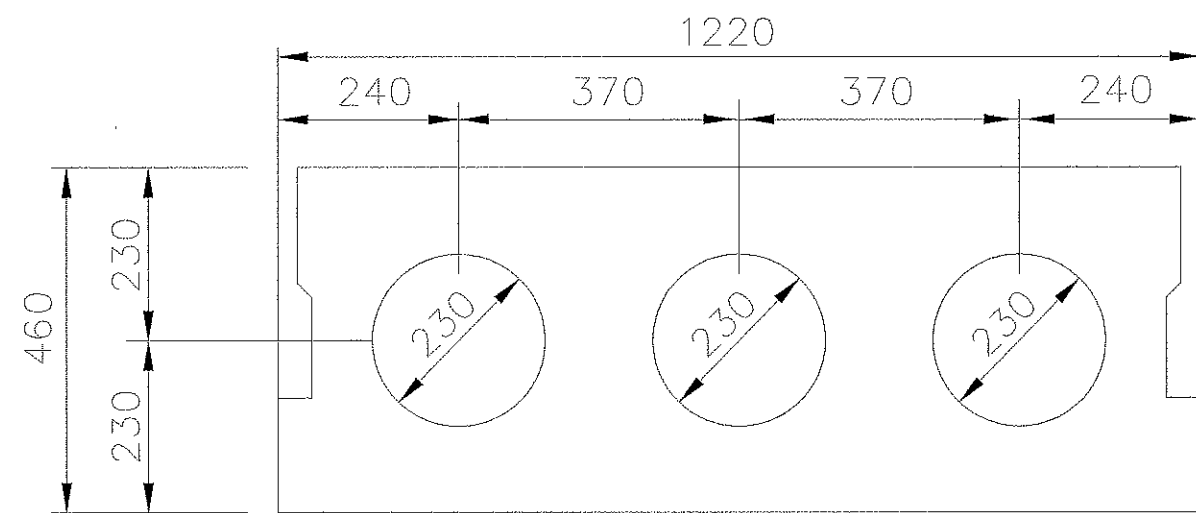


SIII-48
1:10

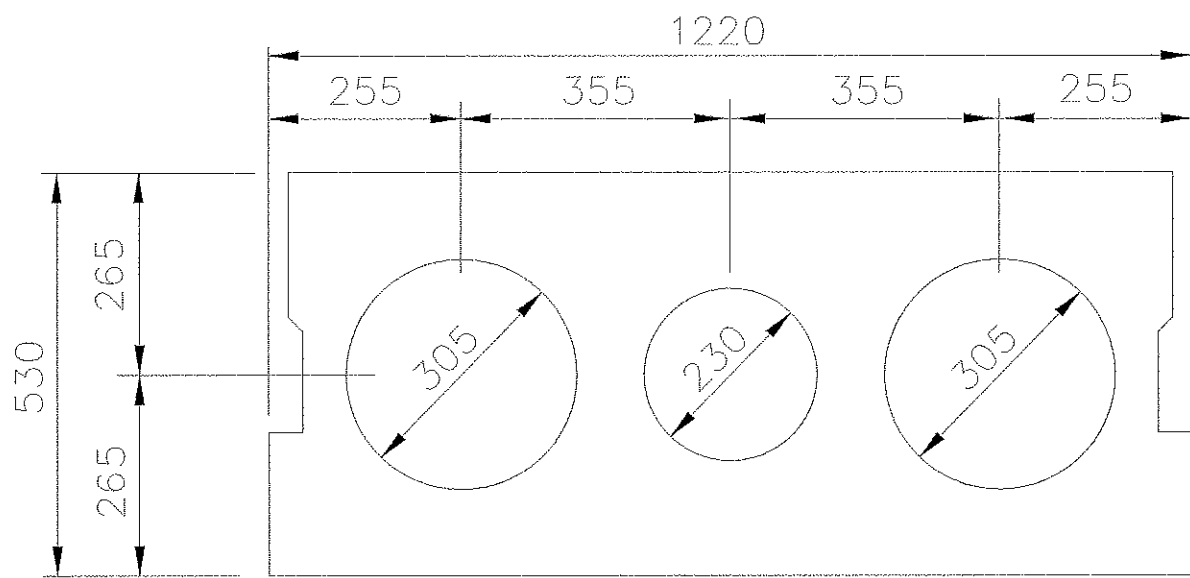

SIV-48
1:10


TYPICAL SECTION
1:10

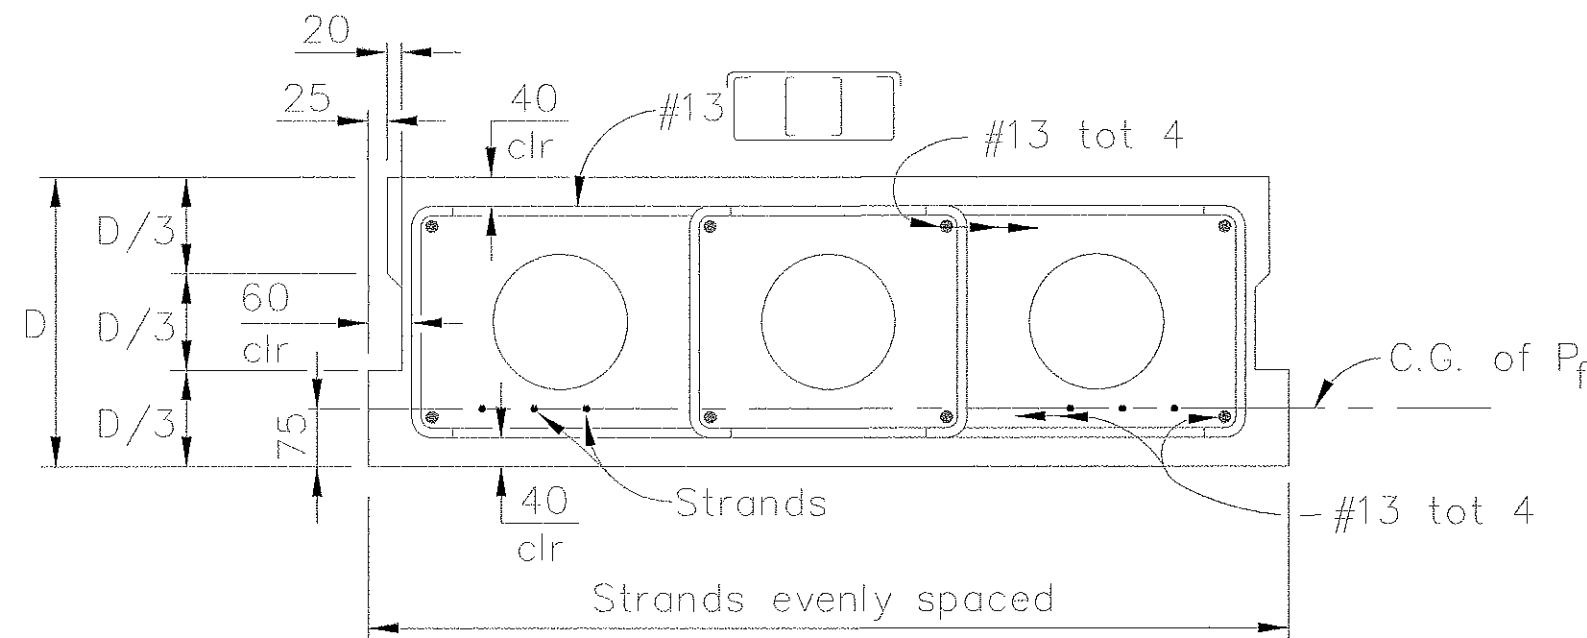

TYPICAL REINFORCEMENT
1:10


Prestressing General Notes:

1. P_f is the force required at center of span after all losses. for P_f and the number of strands per unit see "Precast Concrete Slab Layout" and "Precast Concrete Slab and Cast-in-Place Concrete Slab Layout" sheets.
2. Slabs designed for pretensioning.
3. Concrete strength at time of stressing 28 MPa, $f'_c = 28$ MPa at 28 days.
4. Live loading = HS 20-44, Alternative and permit Design load.
5. Design load varies for surfacing.
6. Keyways to be filled with mortar.

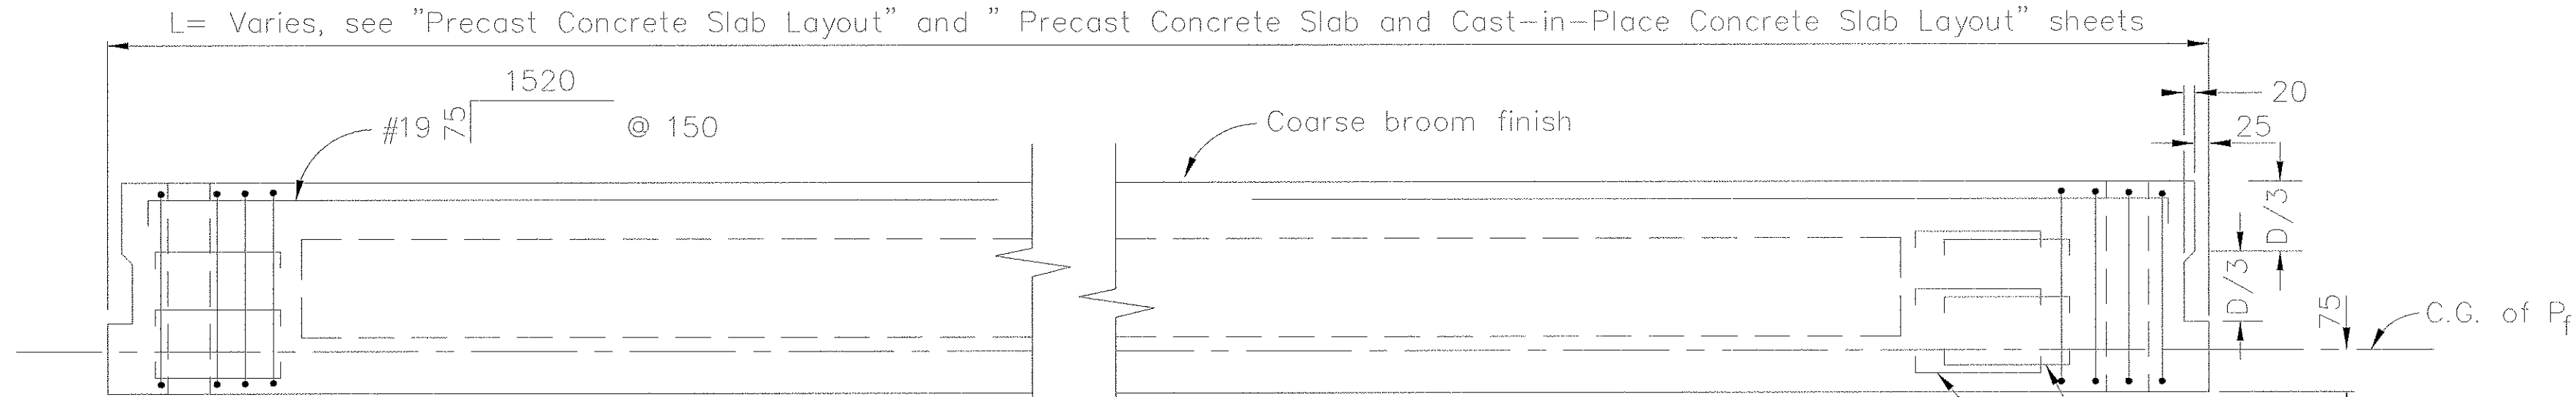


ELEVATION
1:10

Note: "L" is measured along ? of slab unit

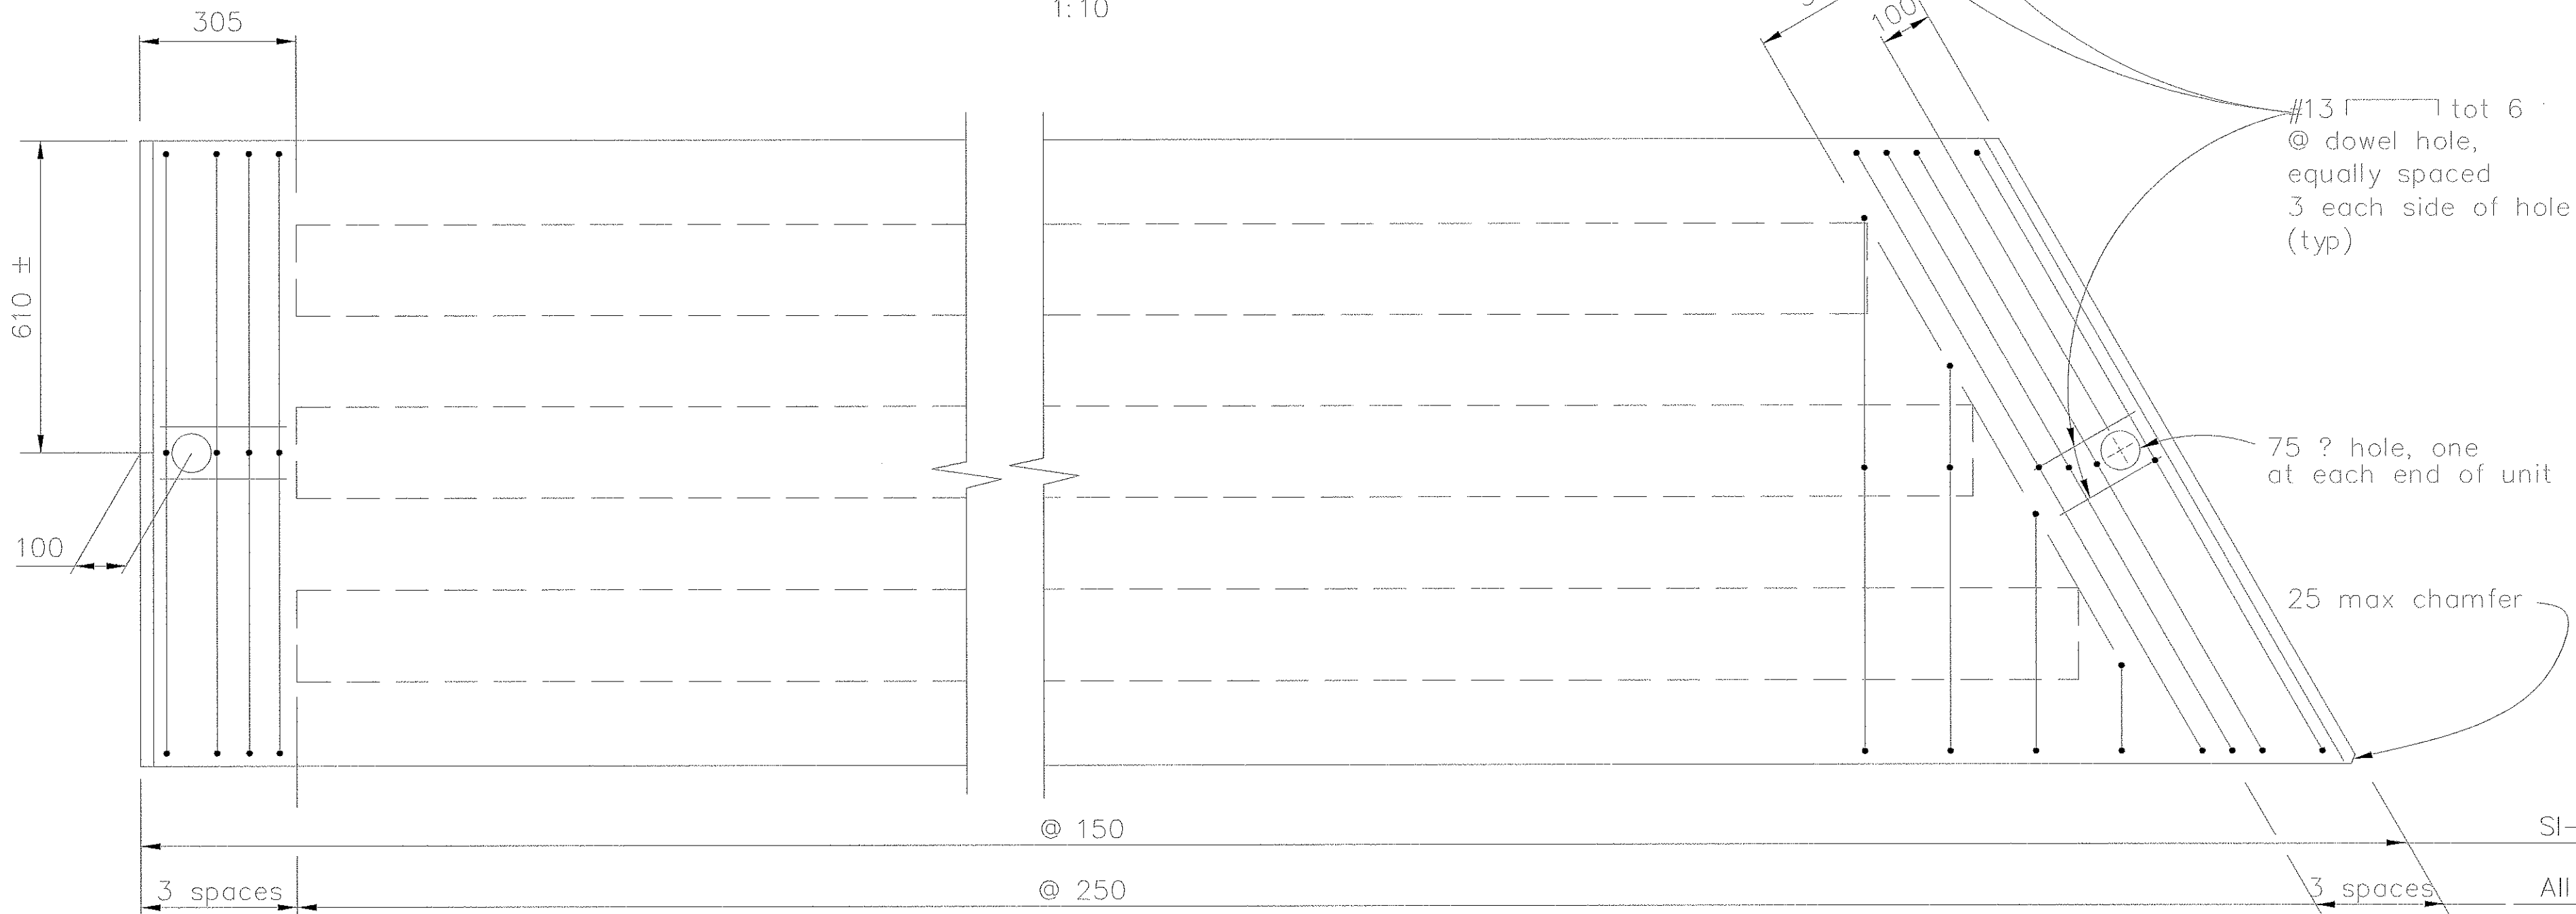

PLAN
1:10

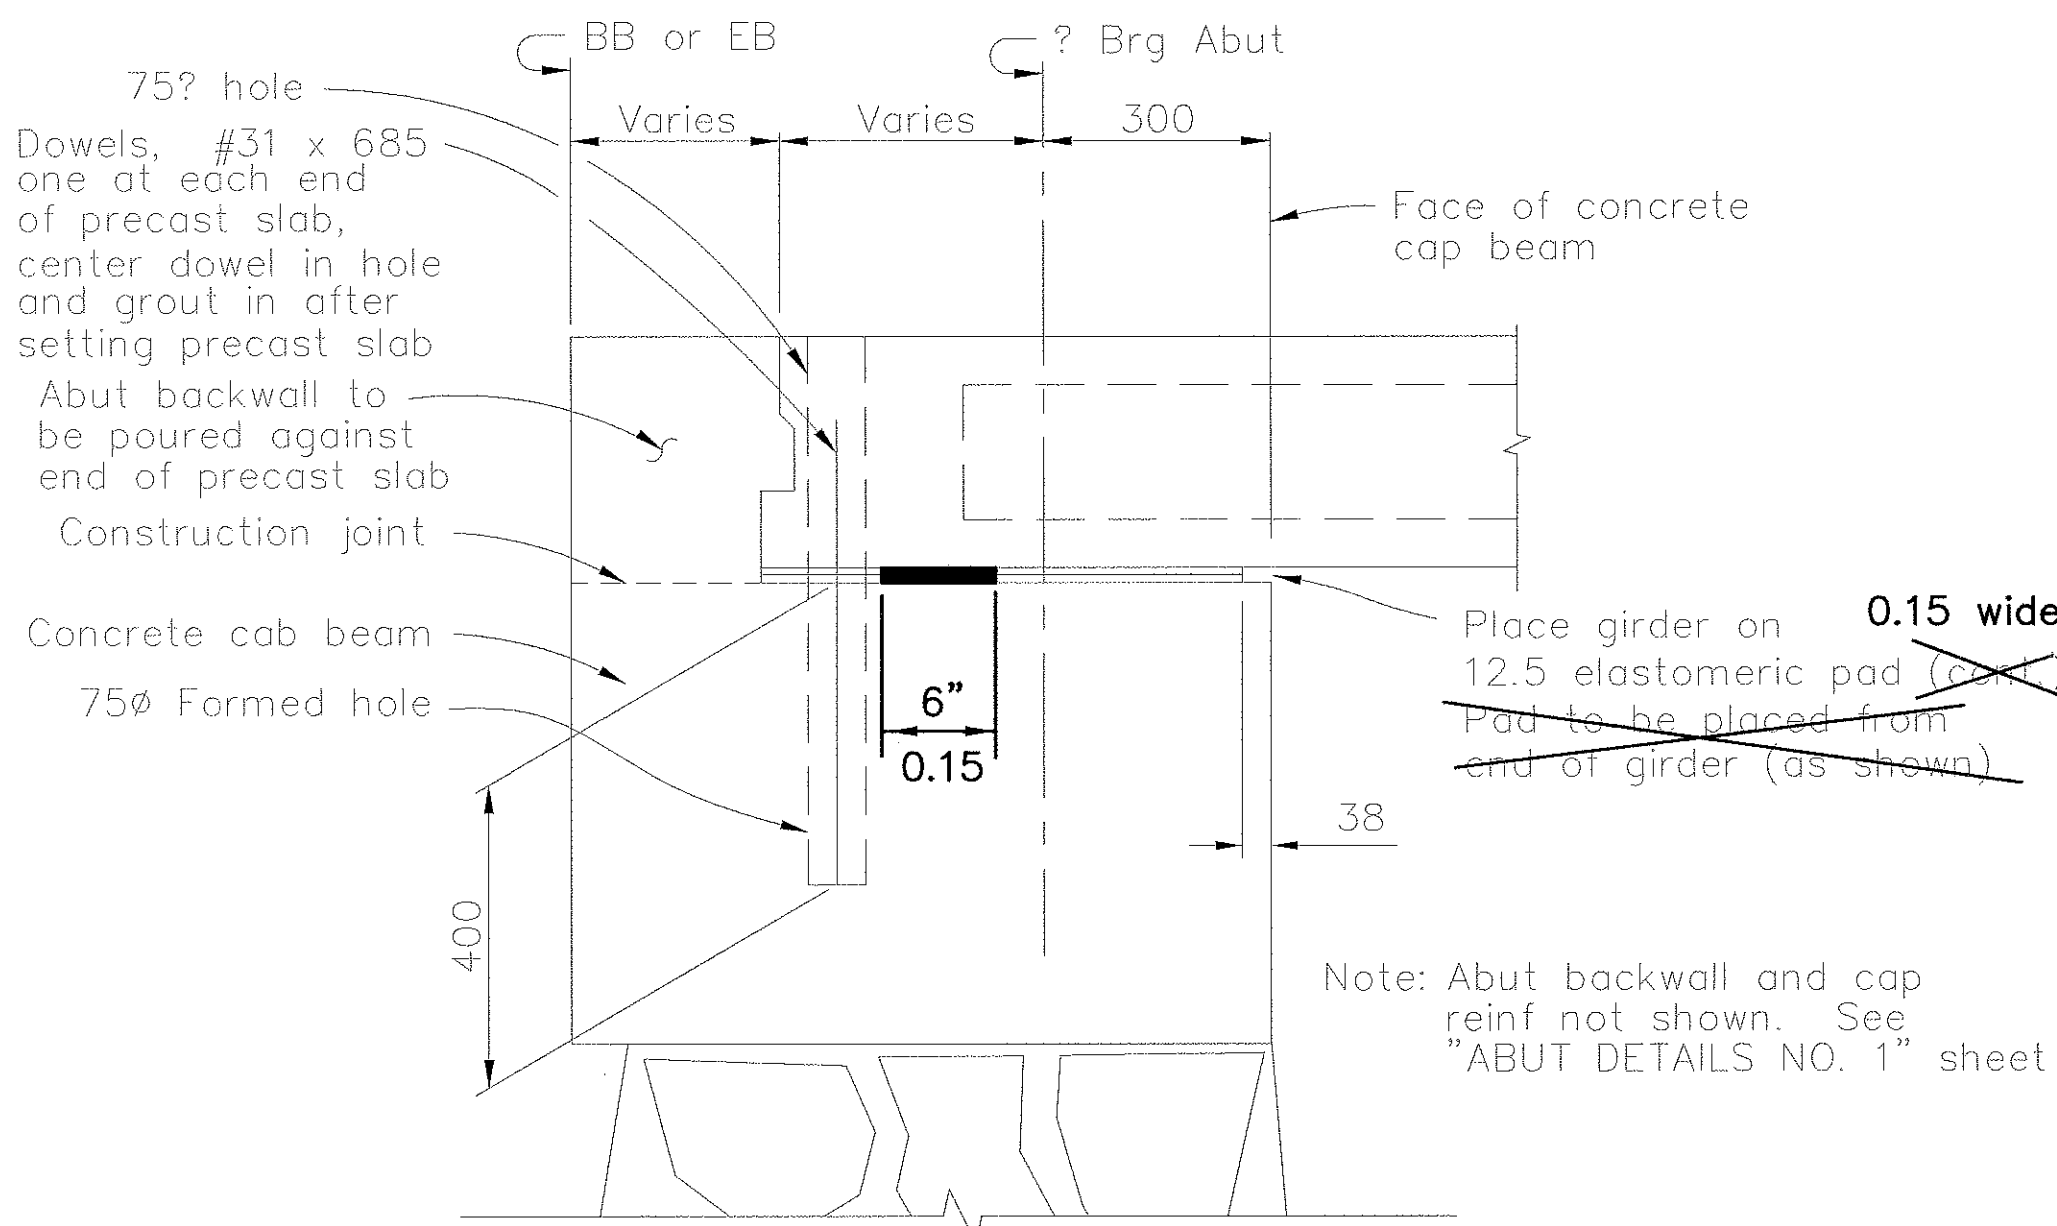


SUPPORT DETAIL AT ABUTMENT
1:10

The contractor shall verify all controlling field dimensions before ordering or fabricating any materials.

All dimensions are in millimeters unless otherwise noted.

RECORD DRAWING
DATE: 3/9/02 BY: SR

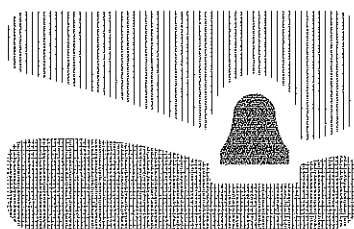

city of san luis obispo

HIGUERA STREET BRIDGE REPLACEMENT

FOR REDUCED PLANS
ORIGINAL SCALE IS IN MILLIMETERS



APPROVED BY

CITY ENGINEER

DATE: 3/2000
SCALE: As Noted
DESIGNED BY: R.F.
DRAWN BY: R.D., K.W.
CHECKED BY: R.R.
APPROVED BY:
UTILITIES DEPARTMENT

PRECAST CONCRETE SLAB DETAILS

SPECIFICATION NO.
9367
FILE NO./LOCATION
0060 B
SHEET
38 OF 41

DIST	COUNTY	ROUTE	POST MILES TOTAL PROJECT	SHEET NO.	TOTAL SHEETS
5	SLO		—	39	41

Ronald L. Rivett
REGISTERED CIVIL ENGINEER
4/5/00
PLANS APPROVAL DATE

REGISTERED PROFESSIONAL ENGINEER

Ronald L. Rivett




No. 31,269

EXP. 12/31/00

CIVIL

STATE OF CALIFORNIA

MARTIN & KANE, Inc.
2200-B DOUGLAS BLVD., #150
ROSEVILLE • CA 95661

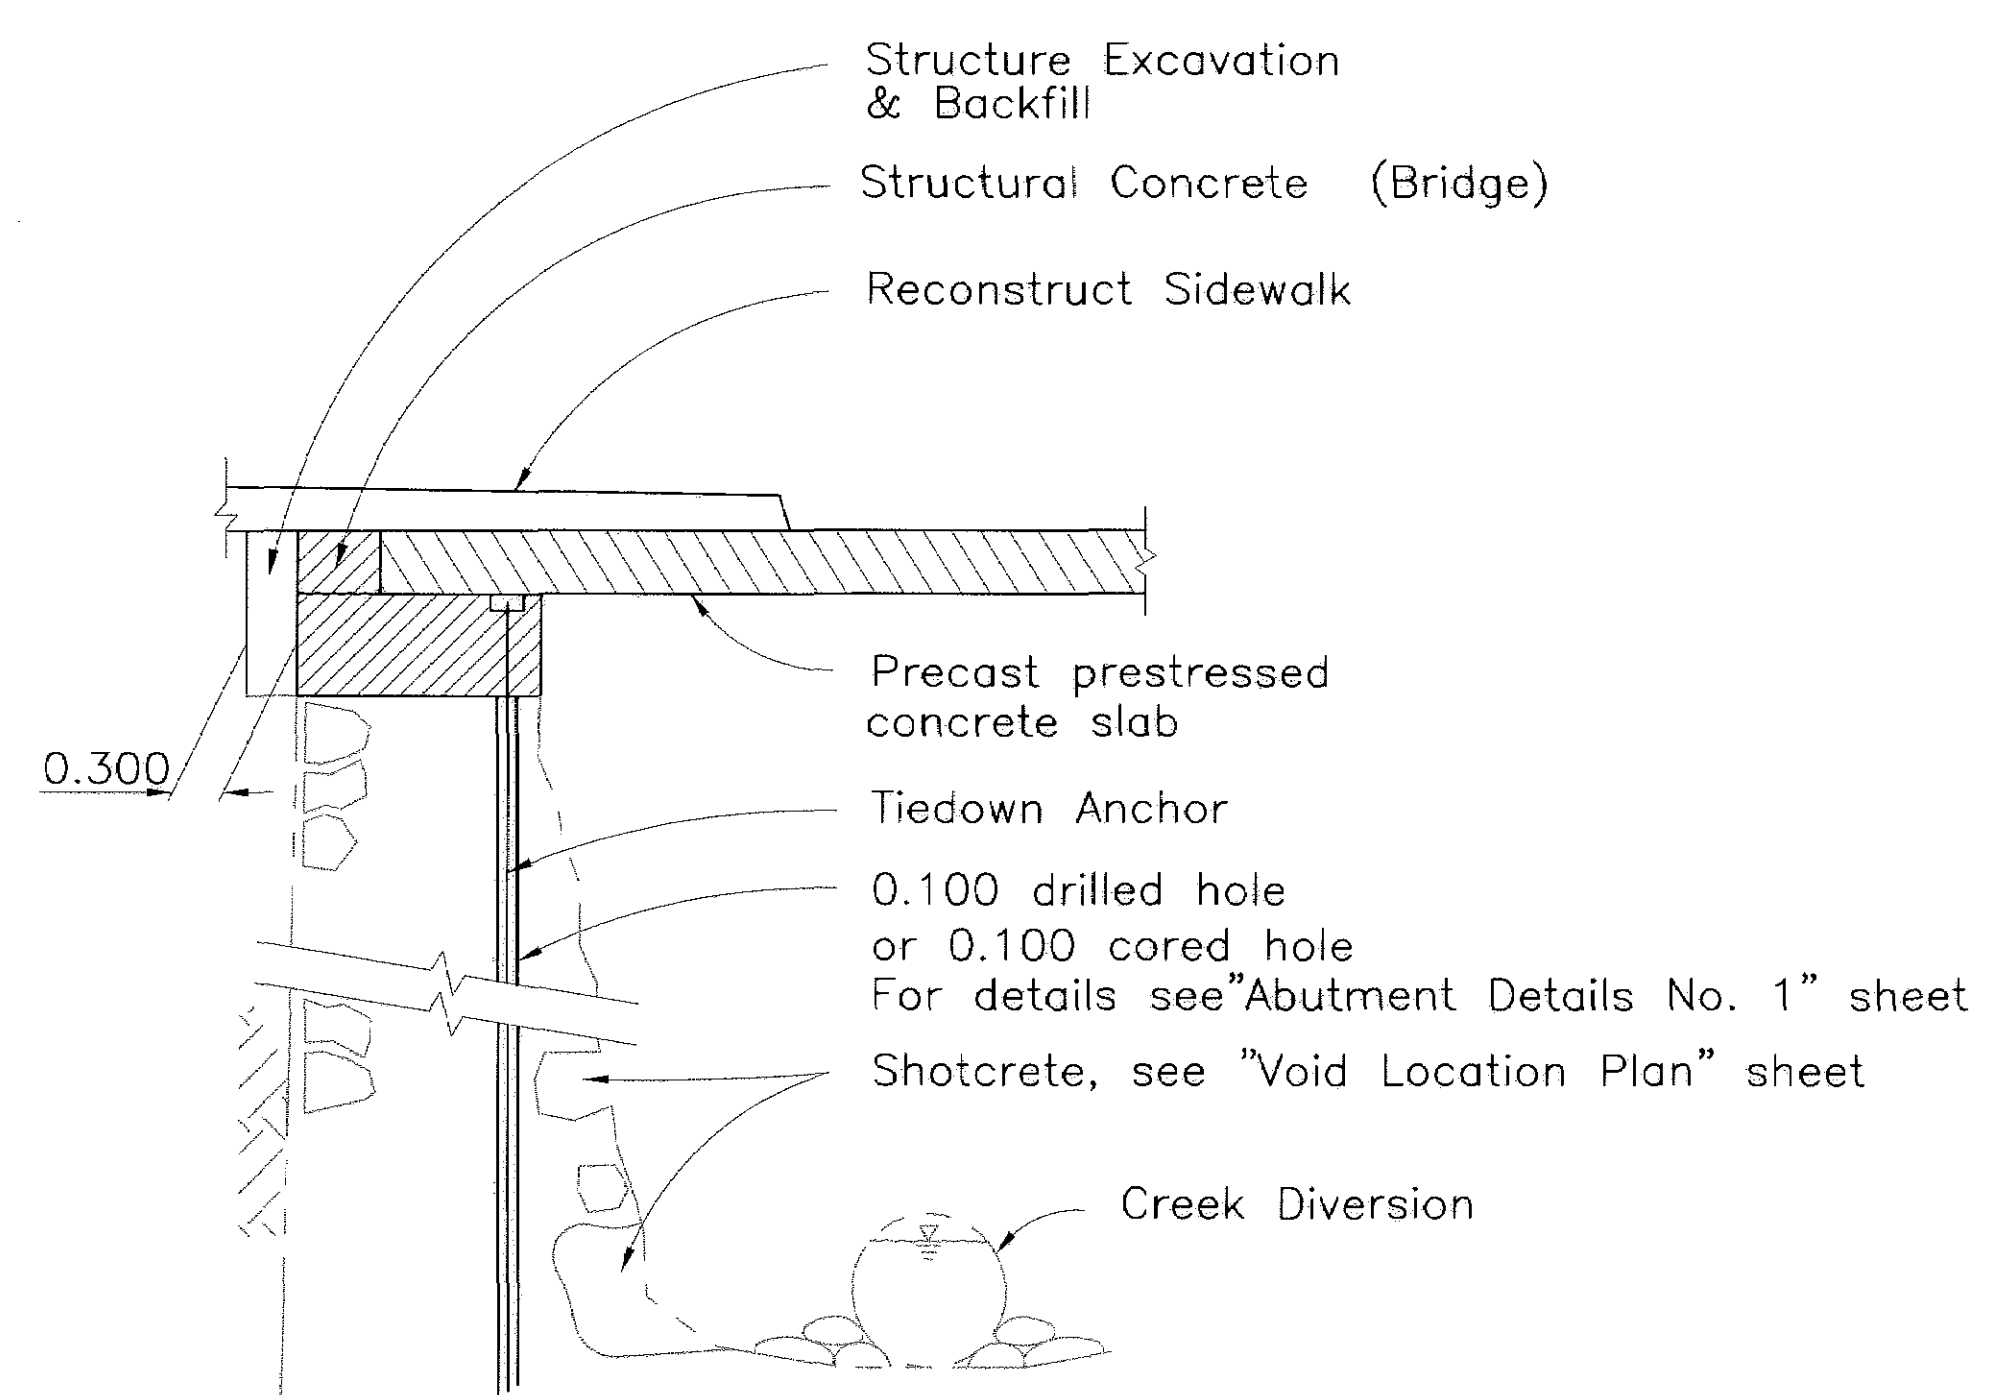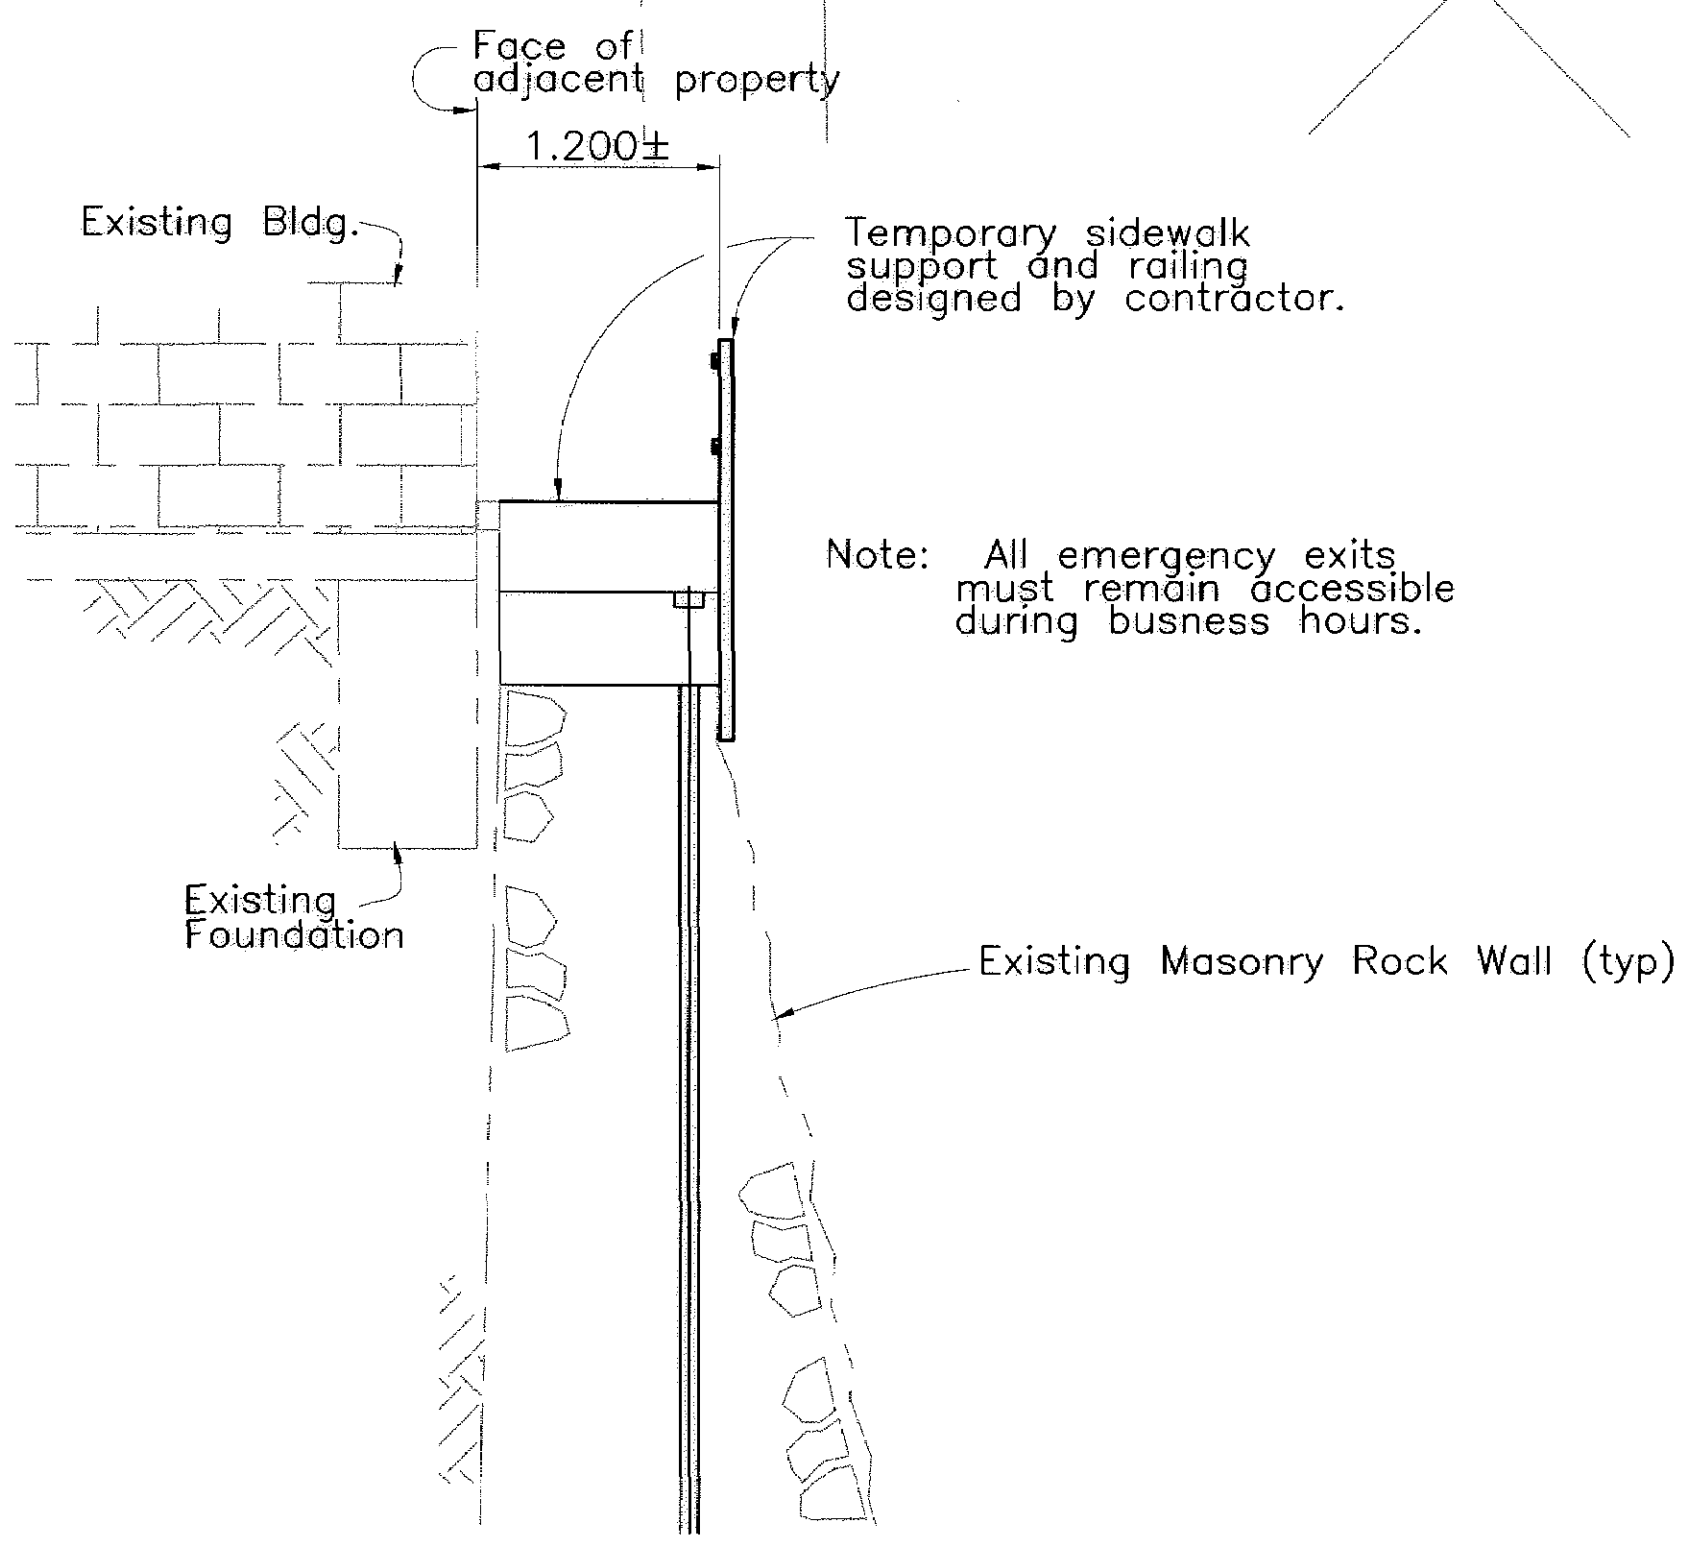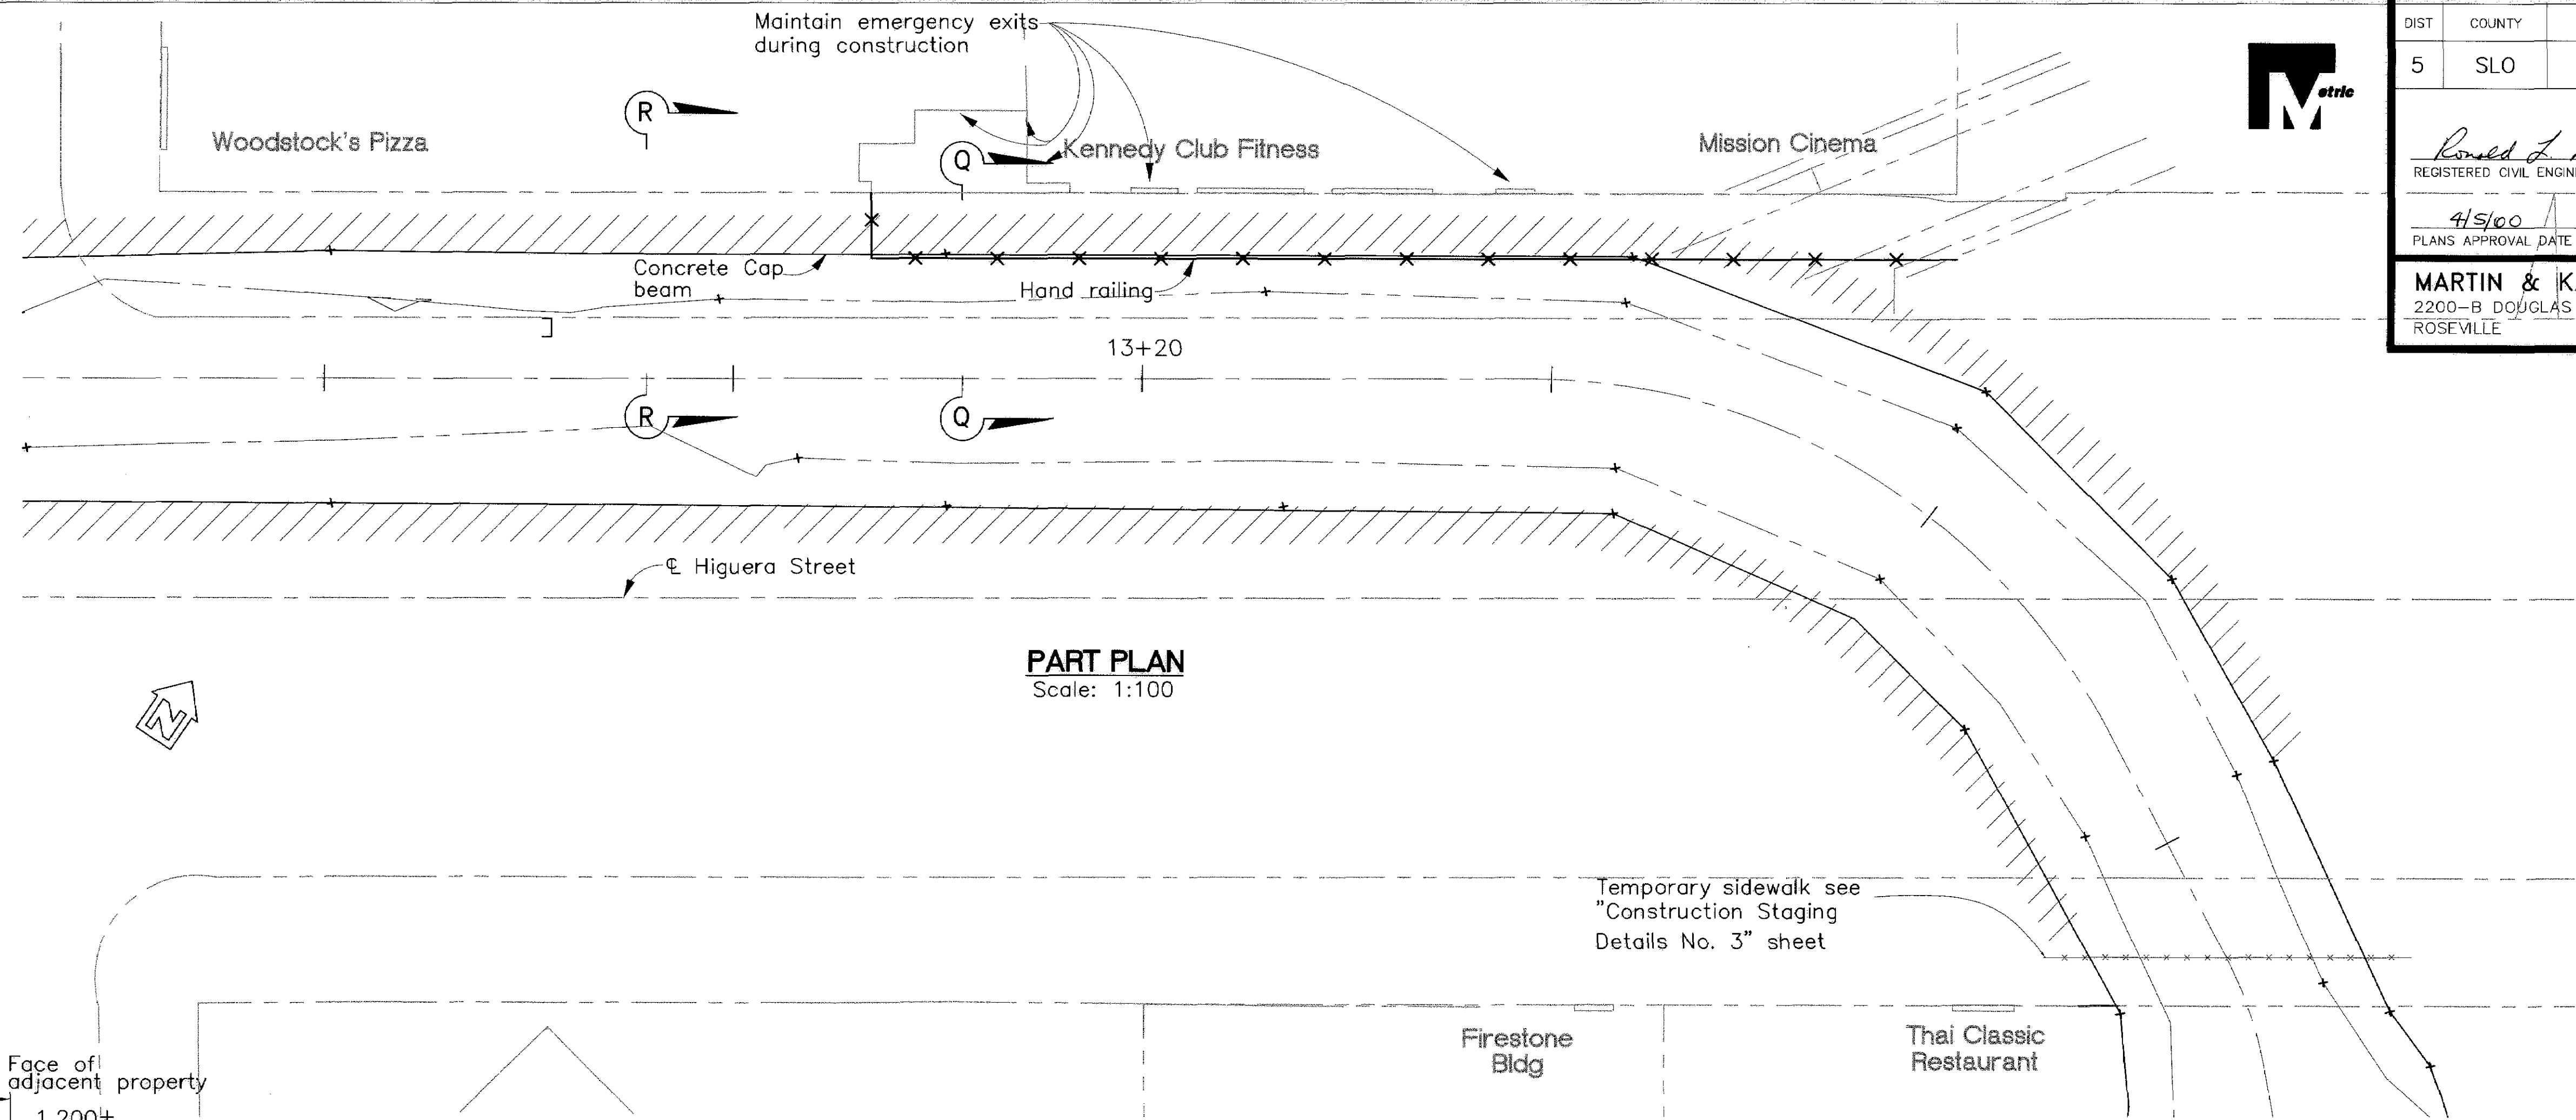

- LEGEND:
- Temporary sidewalk hand railing
 - Masonry rock wall

The contractor shall verify all controlling field dimensions before ordering or fabricating any materials.

All dimensions are in meters unless otherwise noted.

N:\MSR\01\WK PROJECTS\1997\97017.00 HIGUERA STREET BRIDGE REHAB\100& Submit\97017-MD.dwg 3-17-00

city of san luis obispo

HIGUERA STREET BRIDGE REPLACEMENT

FOR REDUCED PLANS
ORIGINAL SCALE IS IN MILLIMETERS

0 20 40 60 80 100

APPROVED BY

CITY ENGINEER

DATE 3/2000

SCALE As Noted

DESIGNED BY R.F.

DRAWN BY R.D., K.W.

CHECKED BY R.R.

APPROVED BY

UTILITIES DEPARTMENT

CONSTRUCTION DETAILS

SPECIFICATION NO. 9367

FILE NO./LOCATION 0066 B

SHEET 39 OF 41



DIST	COUNTY	ROUTE	POST MILES TOTAL PROJECT	SHEET NO.	TOTAL SHEETS
5	SL		-	40	41


REGISTERED CIVIL ENGINEER

PLANS APPROVAL DATE


MARTIN & KANE, INC.
2200-E DOUGLAS BLVD, #150
ROSEVILLE • CA 95661

REGISTERED PROFESSIONAL ENGINEER

Ronald L. Rivett
No. 31,268
EXP. 12/31/00
CIVIL
STATE OF CALIFORNIA

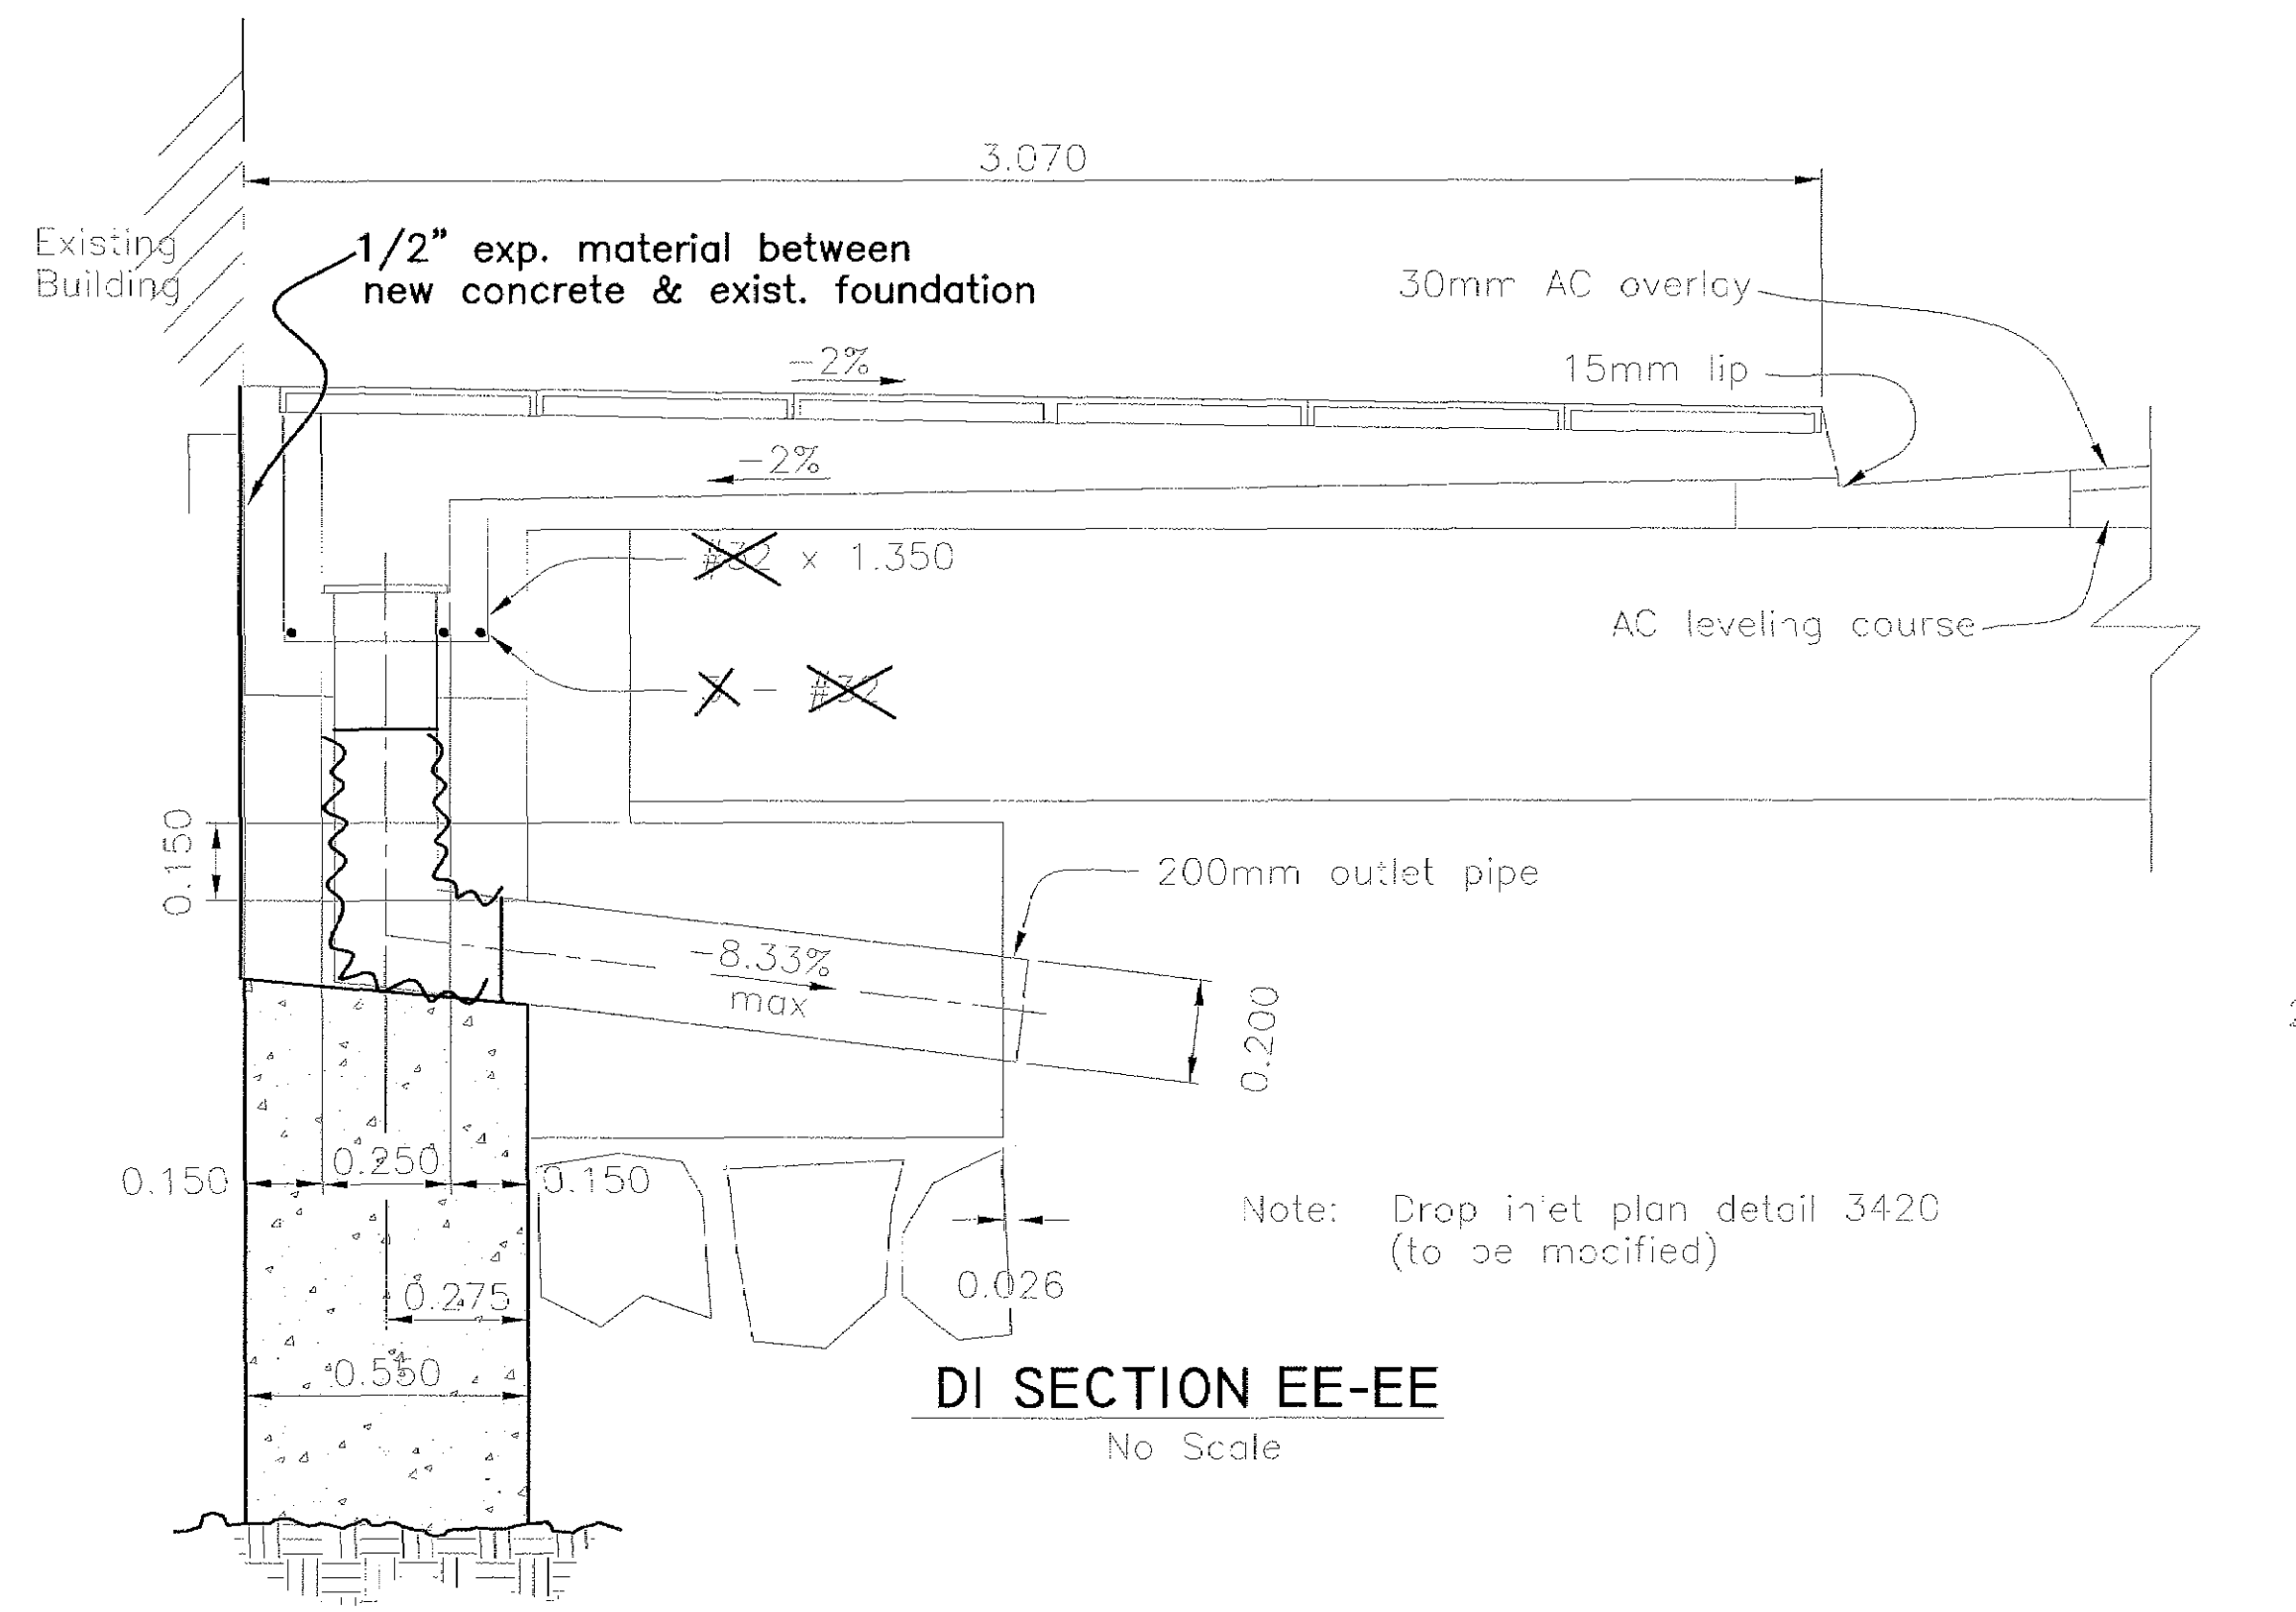


DI SECTION EE-EE
No Scale

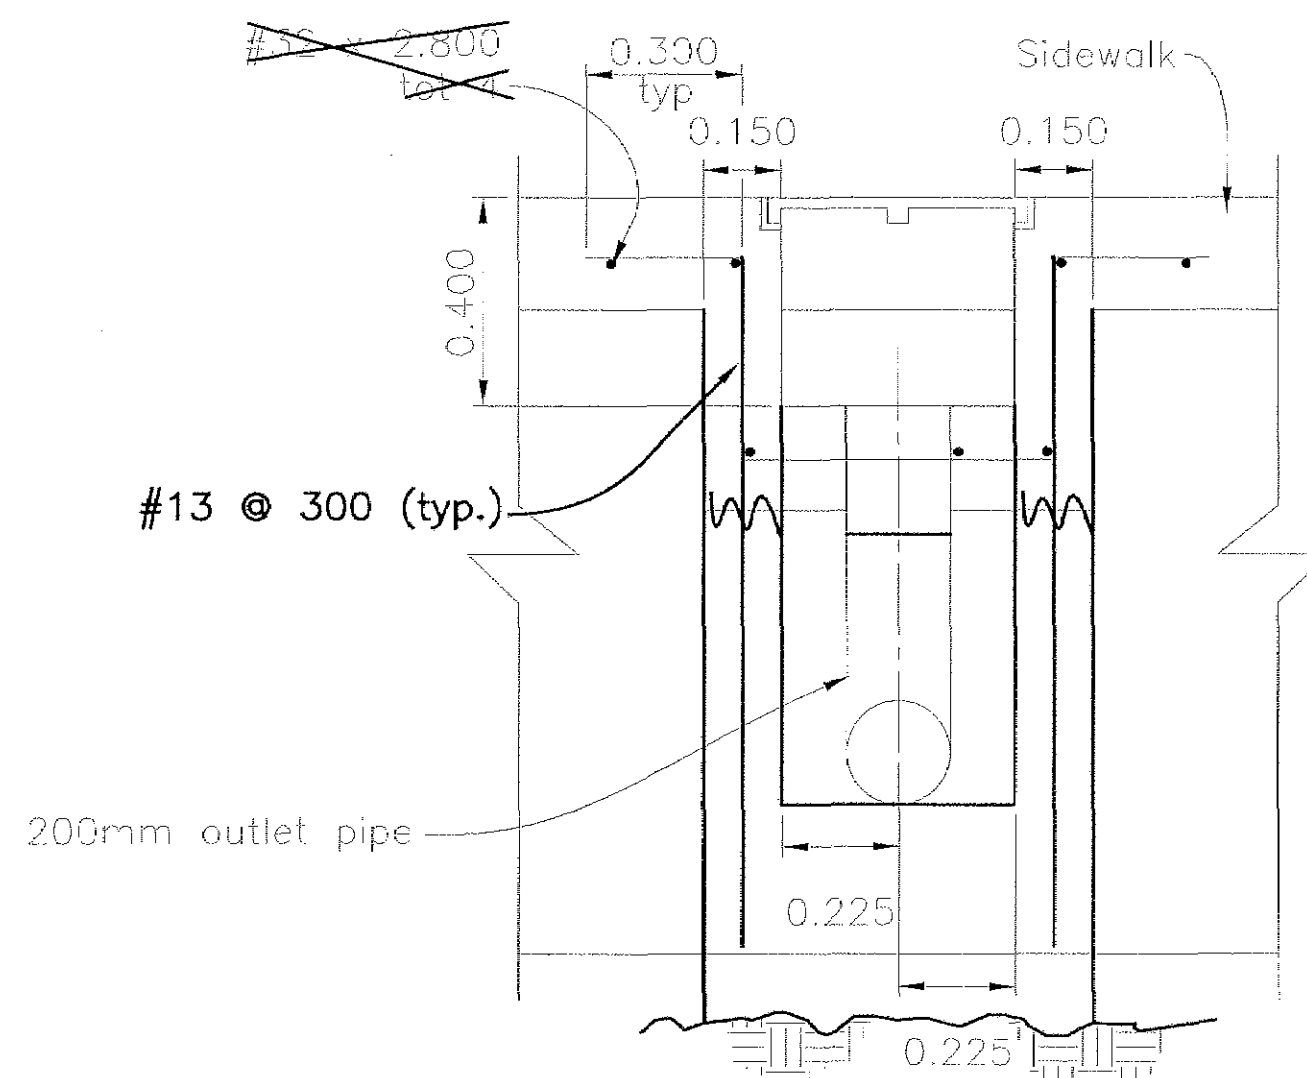


DI SECTION DD-DD
No Scale

Note: plan view and sections DD-DD, and EE-EE are for drop inlet (modified sidewalk underdrain) at Station 1+19±.

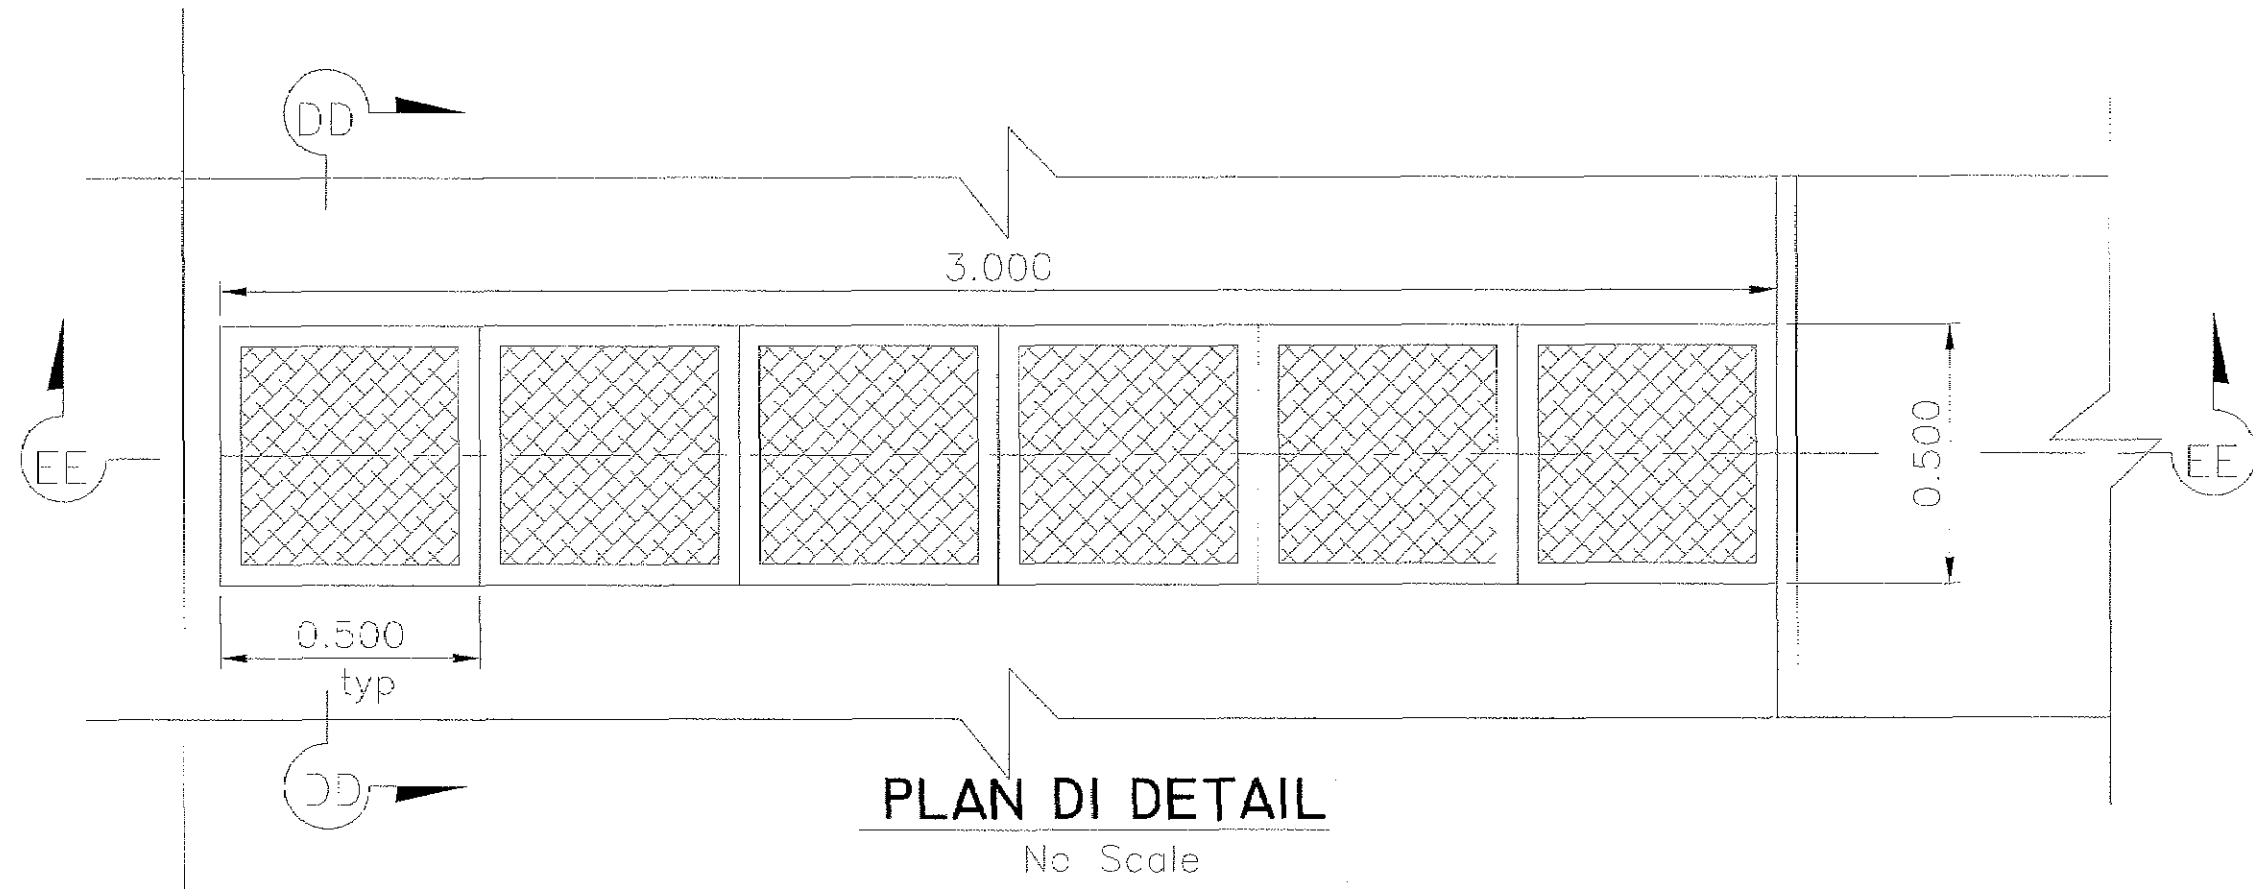

PLAN DI DETAIL
No Scale

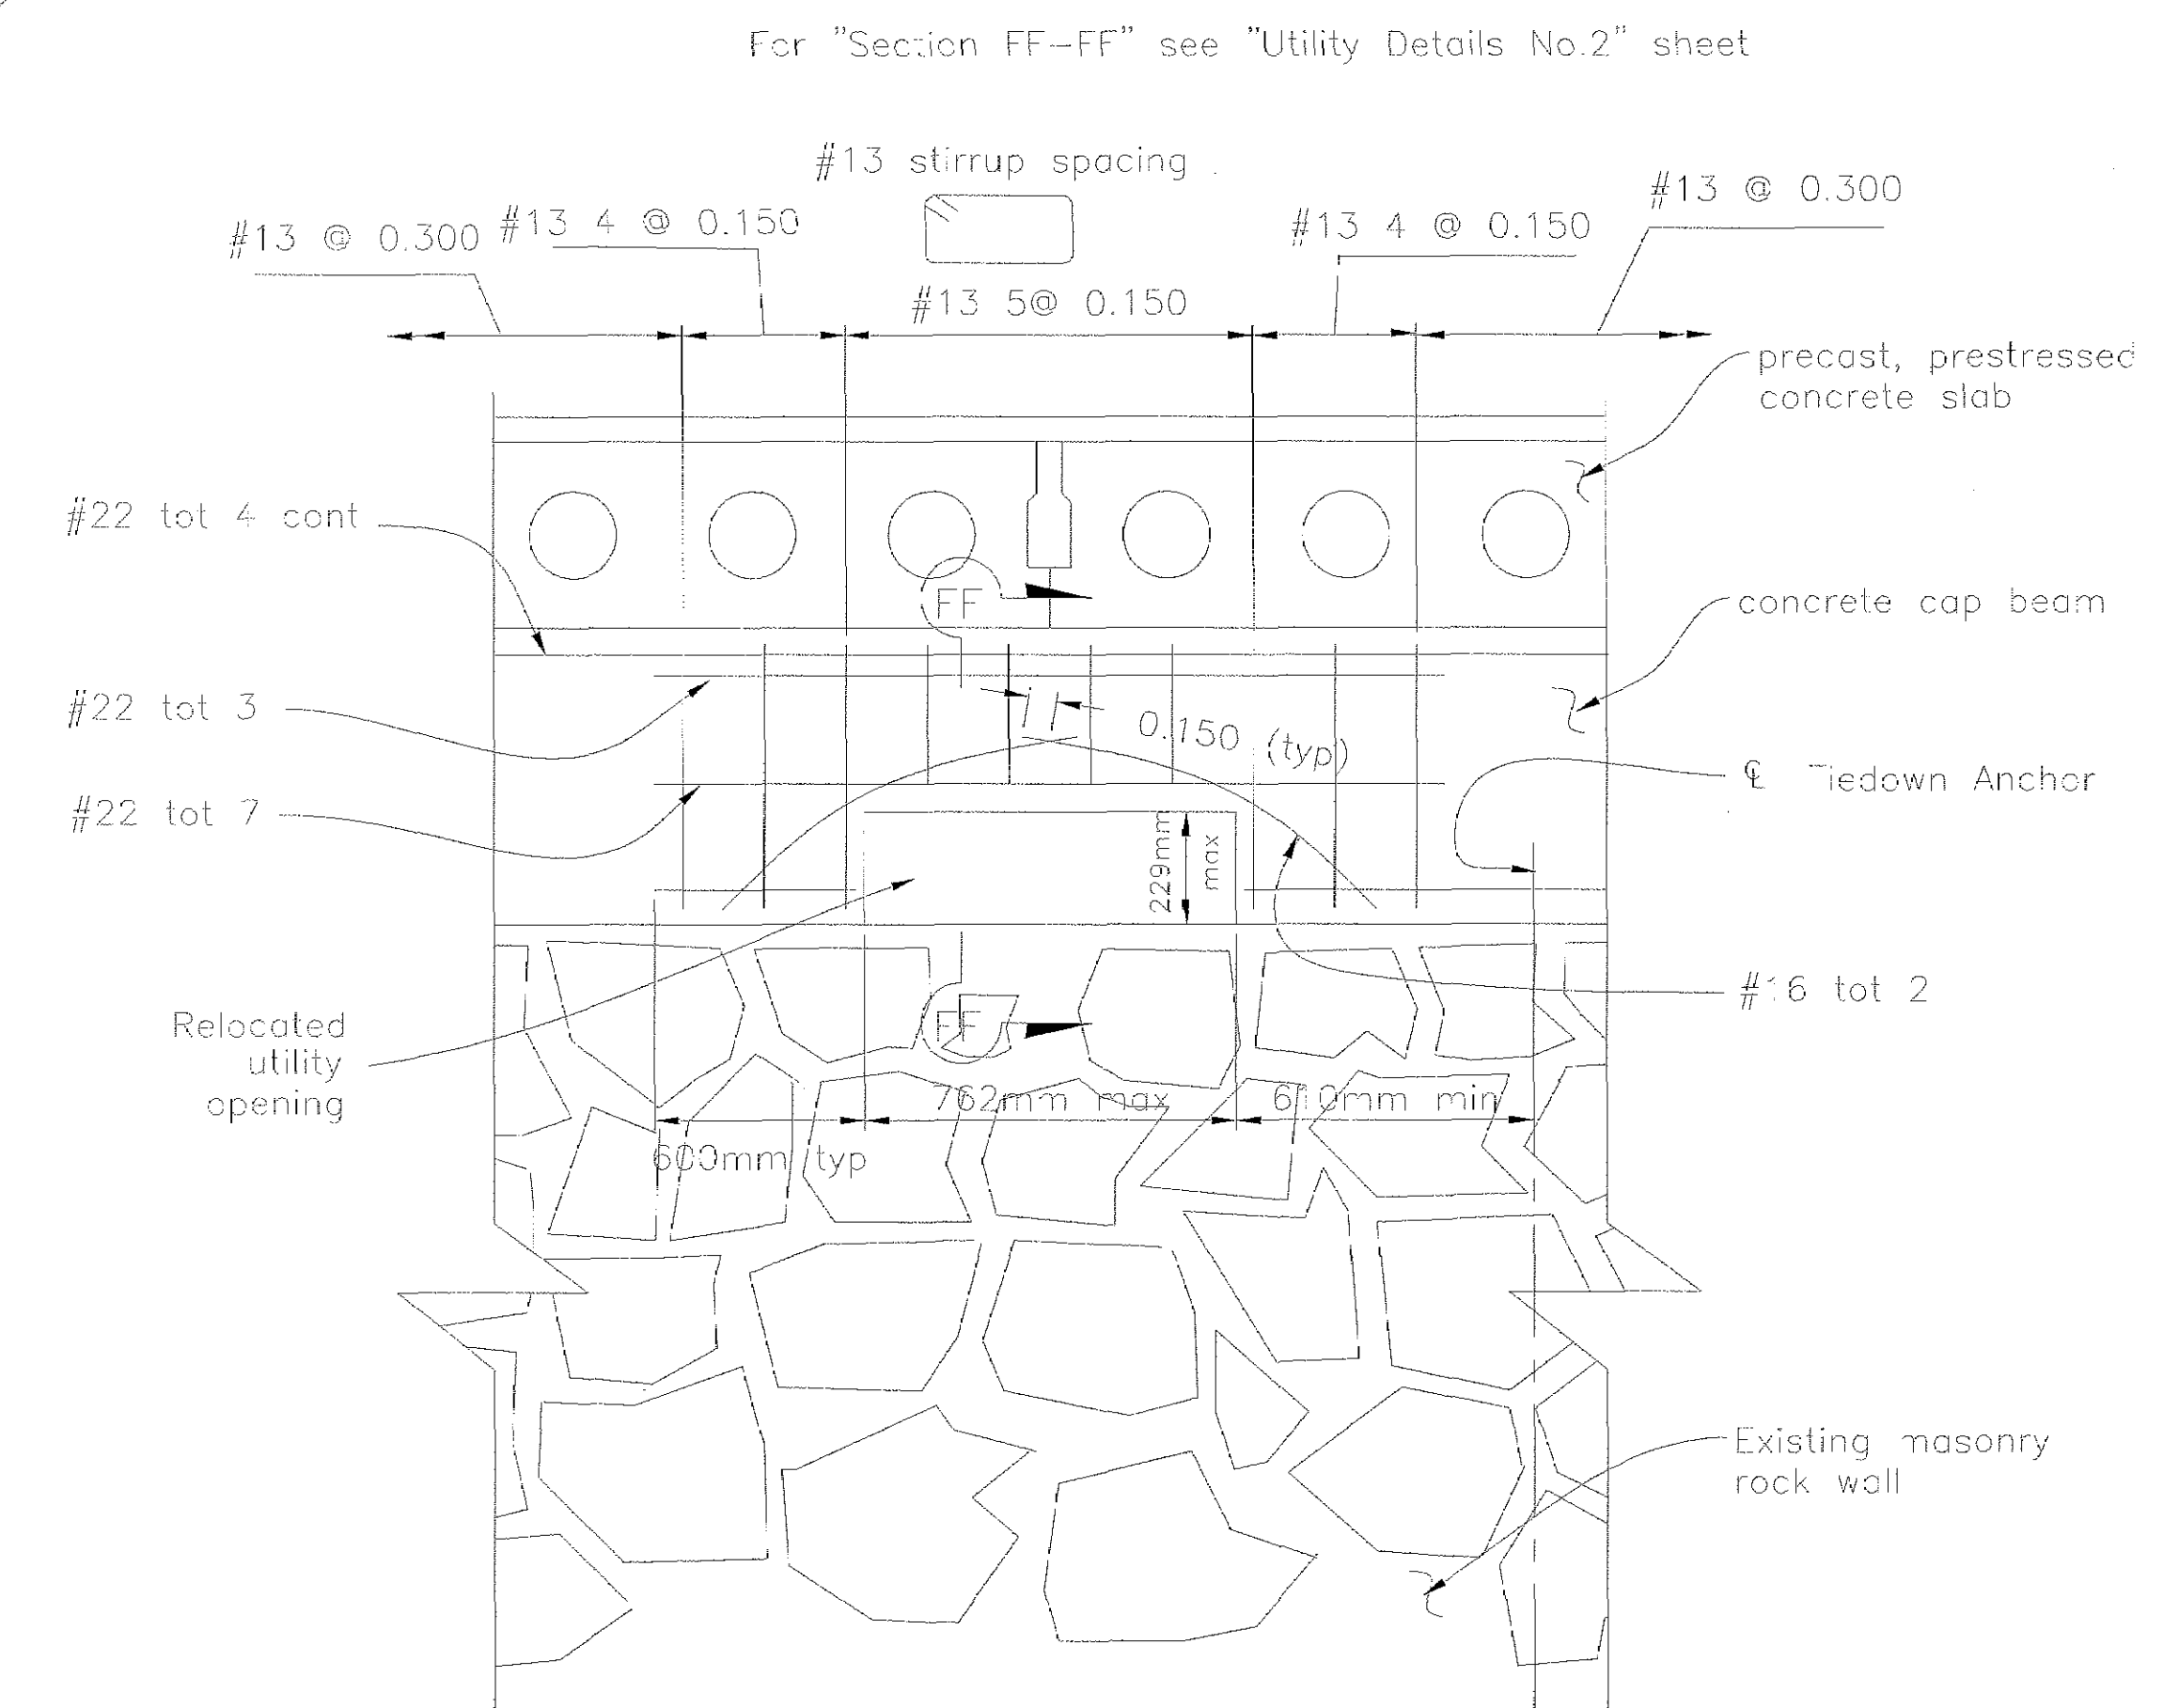


UTILITY RELOCATION ALTERNATIVE #1
No Scale


- Notes:
- For Utility Relocation Alternative #2 see "Utility Details No.2" sheet.
 - Either Alternative #1 or Alternative #2 to be used for utility relocation as needed.
 - Utilities cannot be relocated so that they penetrate the top of the concrete cap beam.

The contractor shall verify all controlling field dimensions before ordering or fabricating any materials.

All dimensions are in meters unless otherwise noted.

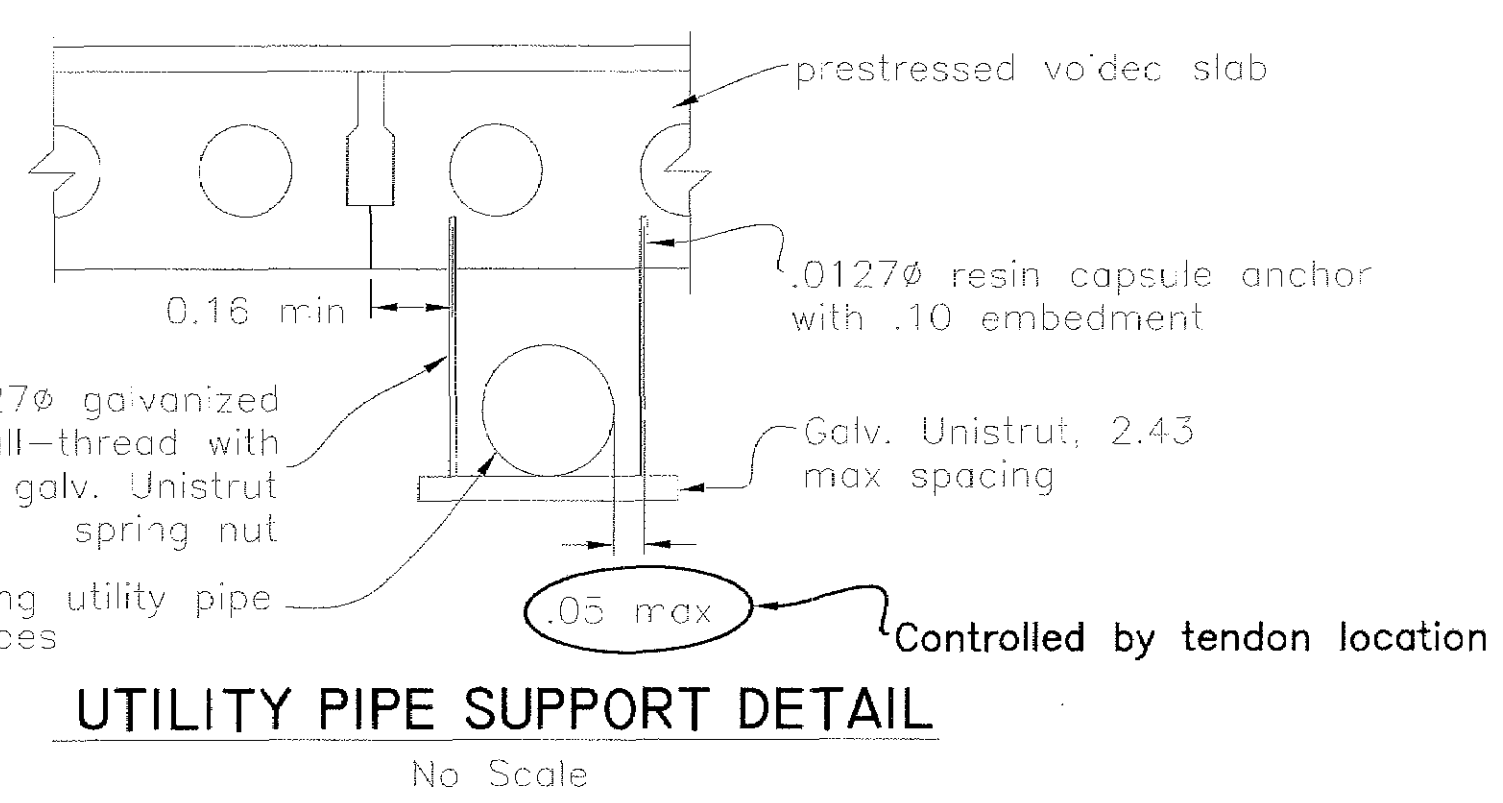

UTILITY PIPE SUPPORT DETAIL
No Scale

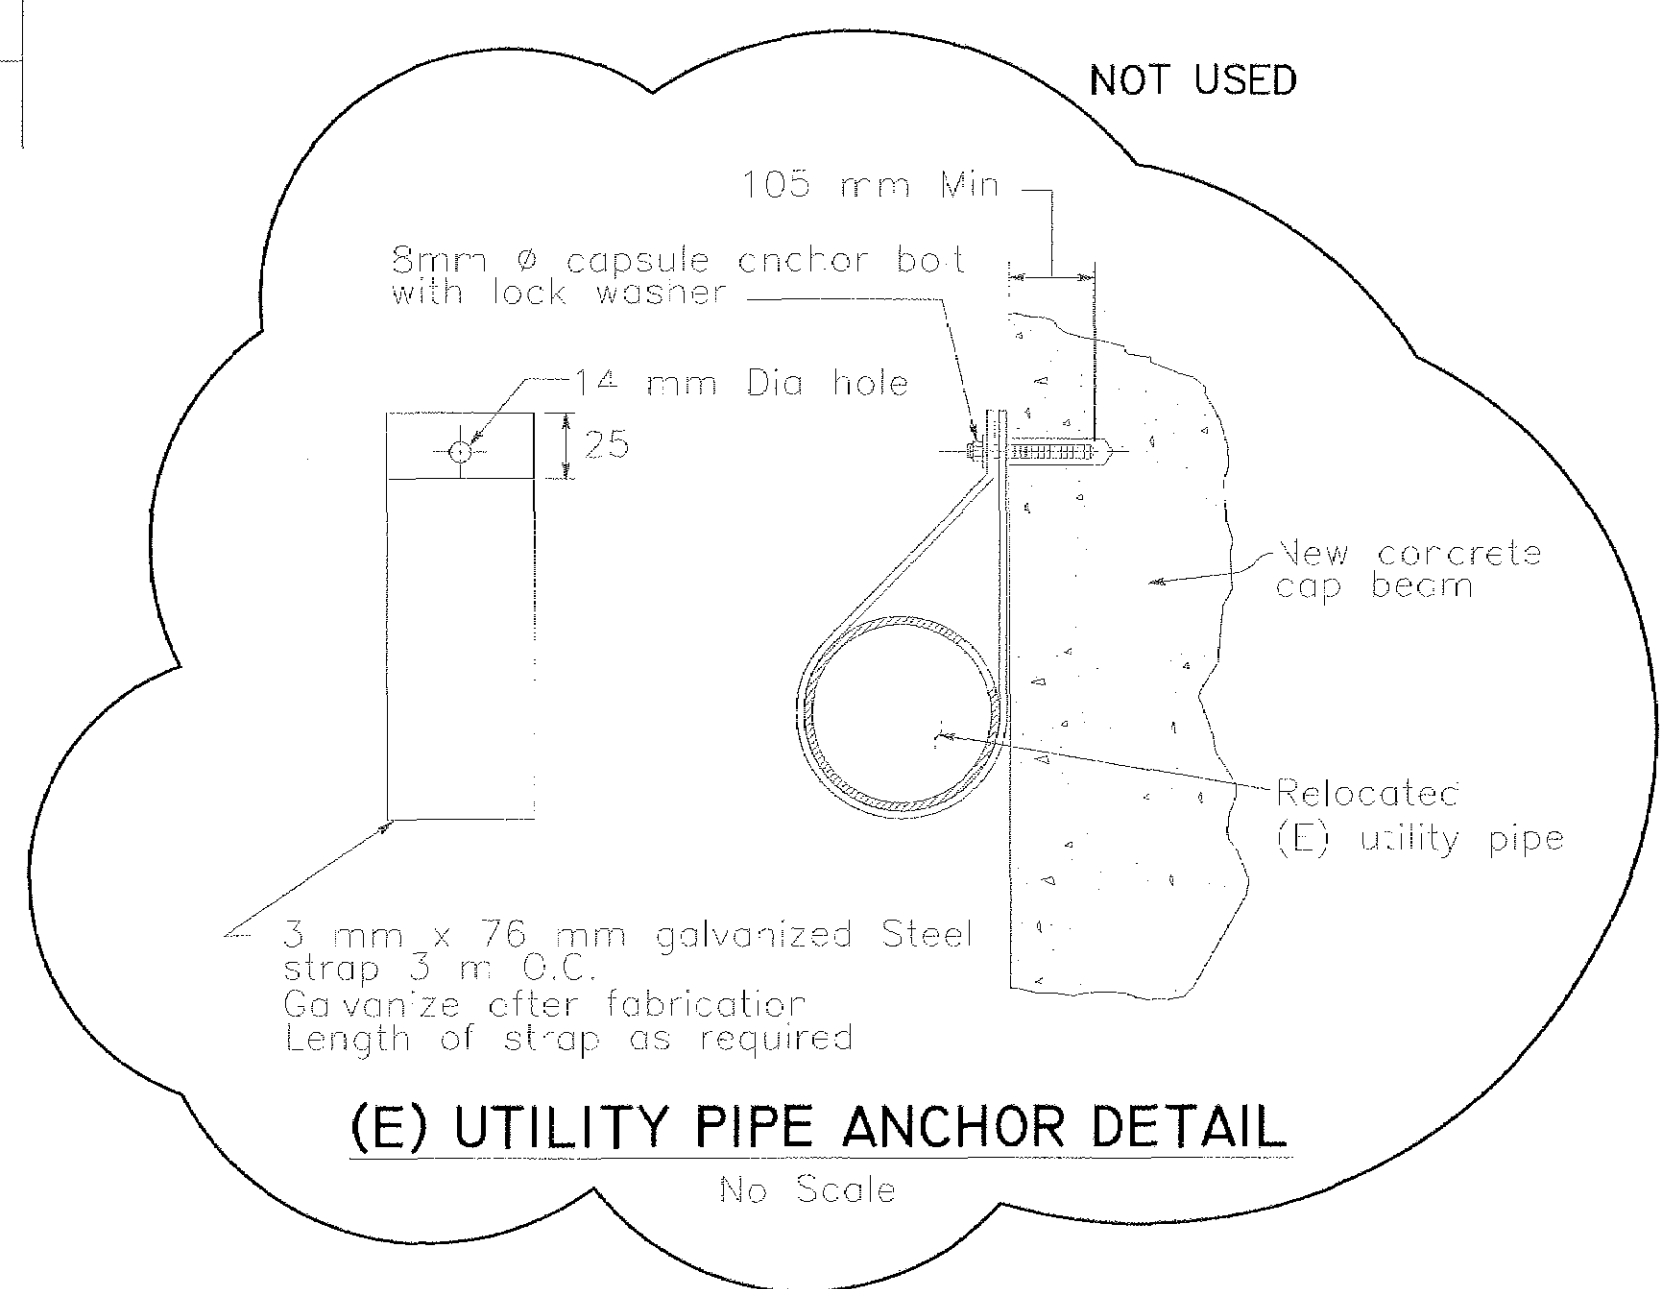

(E) UTILITY PIPE ANCHOR DETAIL
No Scale

RECORD DRAWING
DATE: 3/2/00 BY: [signature]



HIGUERA STREET BRIDGE REPLACEMENT

APPROVED BY
CITY ENGINEER

DATE: 3/2000
SCALE: As Noted
DESIGNED BY: R.F.
DRAWN BY: R.D., C.W.
CHECKED BY: R.R.
UTILITIES DEPARTMENT

UTILITY DETAILS NO. 1

SPECIFICATION NO. 9367
FILE NO./LOCATION 0060 B
SHEET 40 OF 41

$$\begin{array}{r}
 64.06 \\
 \underline{0.61} \\
 63.45 \text{ M} = 208.18' \\
 \text{BOTT. OF CAP BEAM}
 \end{array}$$



No. 5505
Engineer's Computation Pad

 

SEWER LINE NEAR MO'S

NORTH
CAP BEAM

SOUTH
CAP BEAM

$$\begin{array}{r}
 64.18 \text{ M} \text{ TOP OF PIPE} \\
 \underline{210.57'} \\
 16' \text{ BACK}
 \end{array}$$

42'

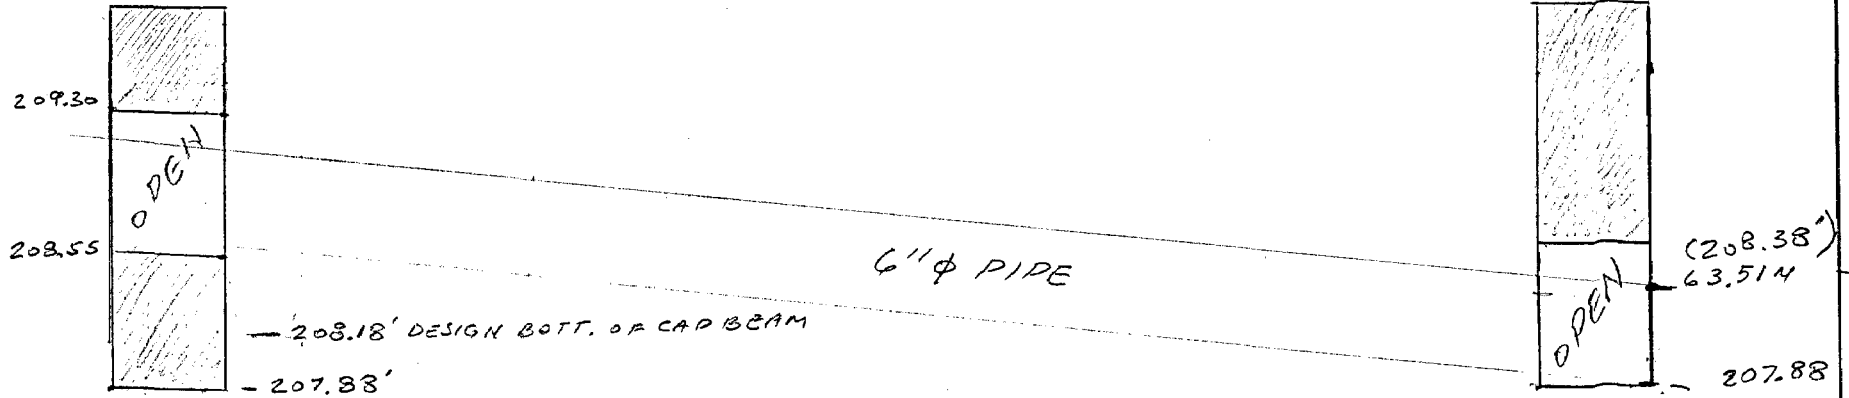

$$\begin{array}{r}
 208.55 \\
 \underline{207.88} \\
 0.67' = 8"
 \end{array}$$

$$\text{MAX. GRADE} = \frac{8"}{42'} = 0.19"/\text{FT} = 3/16"/\text{FT (MIN)}$$

SEWER LINE

(S)
@ RT. ABUT

11/11/11 63.51
4"φ

$\Delta = 0.37 \text{ m}$

(H)
LT. ABUT

11/11/11 64.18
4"φ

FROM BILL 8-30-00

DISTANCE BACK OF FTGS = 42'

10-13-00
FROM BILL
K

CURB P-Line @ Woodstock Pizza

AS BUILT
65.50 DESIGN

+5.33 220.23

214.90 TBM 0+92.8

1+08.07 -5.16 215.07 65.55 ^(65.53) @ C/F Prod.

1+10.46 -5.15 215.08 65.556 ^(65.53) @ Bid FACE

1+17.07 -4.88 215.35 65.64 (65.63)

1+24.69 -4.52 215.71 65.75 (65.74)

ELEV CHECK @ CF E-2118

10-6-00

Bill
Garey

AS BUILT

PLAN GRADE

E
Higuen +7.48 219.25 211.80 FROM C/P MOES

0+52 - 7.19 212.09 64.65 ✓ $64.21 + 0.39 = 64.60$ ∴ 2" HIGH

0+54.73 - 6.98 212.30 64.71 $64.27 + 0.39 = 64.66$ ∴ 2" HIGH

0+62.35 - 6.37 212.91 64.89 $64.45 + 0.39 = 64.84$ ∴ 2" HIGH

0+69.97 * - 5.90 213.38 65.04 = 65.01

0+77.59 - 5.35 213.93 65.21 $64.73 + 0.39 = 65.12$ ∴ 1½" HIGH

0+85.21 - 4.75 214.53 65.39 $64.97 + 0.39 = 65.36$ ∴ 1¼" HIGH

0+92.83 - 4.38 214.90 65.50 $65.11 + 0.39 = 65.50$ ✓

AT WOODSTOCKS

3.1 M SIDEWALK

$$3.1 \times 0.02 = (-) 0.062$$

$$\text{CURB} = (-) 0.100$$

$$(-) 0.162$$

$$\text{GUTTER RISE} = (+) 0.040$$

$$(-) 0.122$$

$$\text{FACE OF GUTTER} = (-) 0.150$$

$$(-) 0.272 \text{ M}$$

66.60

66.40

$$\text{ELAST. PAD} = 0.012 \text{ M}$$

$$\text{SI-48} = 0.380$$

$$0.392 \text{ M}$$

SIDE WALL
OF MOVIE

PARKING LOT

TIE-IN GRADE AT SIDEWALK

TOP OF DECK PANEL

TOP OF CAP BEAM

SW INSIDE
CORNER OF
SIDEWALK
OSOS & HIGUERA

TIE-IN GRADE
AT SIDEWALK

CORNER OF
WOODSTOCKS
OSOS & HIGUERA

$$\text{ELAST. PAD} = 0.012 \text{ M}$$

$$\text{SI-48} = 0.380$$

$$0.392 \text{ M}$$

#13(N)

TOP OF
DECK PANEL

65.25

65.14
LEVEL

TOP OF
CAP BEAM

65.60

65.40

1+10 1+20 1+30 1+40 1+50 1+60 1+80

#150

#149

65.14
34
13

AT PARKING LOT

4.9 M SIDEWALK

$$4.90 \times 0.02 = (-) 0.098 \text{ M}$$

$$\text{CURB } (+) 0.100$$

$$(-) 0.198$$

$$\text{GUTTER RISE } + 0.040$$

$$\text{FACE OF GUTTER } (-) 0.158$$

$$(-) 0.150$$

$$\text{TOTAL DROP } (-) 0.308 = 1'-0\frac{1}{8}"$$

FROM TIE-IN
TO TOP OF SLAB

SW INSIDE
CORNER OF
SIDEWALK
OSOS & HIGUERA

TIE-IN GRADE
AT SIDEWALK

$$SII - 48 = 0.380 \text{ M}$$

$$SII - 48 = 0.460 \text{ M}$$

$$SID - 48 = 0.530 \text{ M}$$

$$\text{ELAST. PAD} = 0.012 \text{ M}$$

$$SII - 48 = 0.380$$

$$0.392 \text{ M}$$

TOP OF
DECK PANEL

65.25

65.14
LEVEL

TOP OF
CAP BEAM

OSOS ST

HIGUERA
ST.

0+20

0+30

0+40

0+50

0+60

0+70

0+80

0+90

1+00

#151
BET. LOUISIANA'S
& CHANDLER
SHOP

#152

#153
MO. CORNER

#154

#155

#156

#157

#158

#159

#160
CORNER NW
OSOS & HIGUERA

64.20

64.27

64.10

65.01

#170(H)

0.308

0.392

